


AS-BUILT
25 SEPT 1984

ROOF PLAN NOTES

1. ALL VENTS NOT OTHERWISE NOTED ARE 3" PLUMBING VENTS.
2. ALL WORK SHOWN ON THIS SHEET IS BY MECHANICAL TRADES.
3. PROVIDE DECK CLAMPS FOR ALL ROOF DRAINS INSTALLED IN CONCRETE DECK.
4. NO ROOF DRAIN SHALL BE SET WITHOUT PRIOR CONSULTATION WITH THE ARCHITECT'S FIELD REPRESENTATIVE. IN GENERAL, THE ROOF DRAIN SHALL BE SET ON THE STRUCTURAL DECK, AND NOT ON THE ROOF INSULATION.
5. THE MECHANICAL OVERFLOW DRAIN SHALL BE SET OUT THE SMALL ROOF METAL DECK OR SIMILAR ROOF CONSTRUCTION.
6. PROVIDE PIPE PORTAL FOR REPRESENTATION PIPING PASSING THROUGH ROOF.
7. PROVIDE AIR CURB FOR ALL ROOF AIR CURBS.
8. PROVIDE AIR CURB FOR ALL ROOF AIR CURBS.
9. PROVIDE AIR CURB FOR ALL ROOF AIR CURBS.
10. PROVIDE AIR CURB FOR ALL ROOF AIR CURBS.

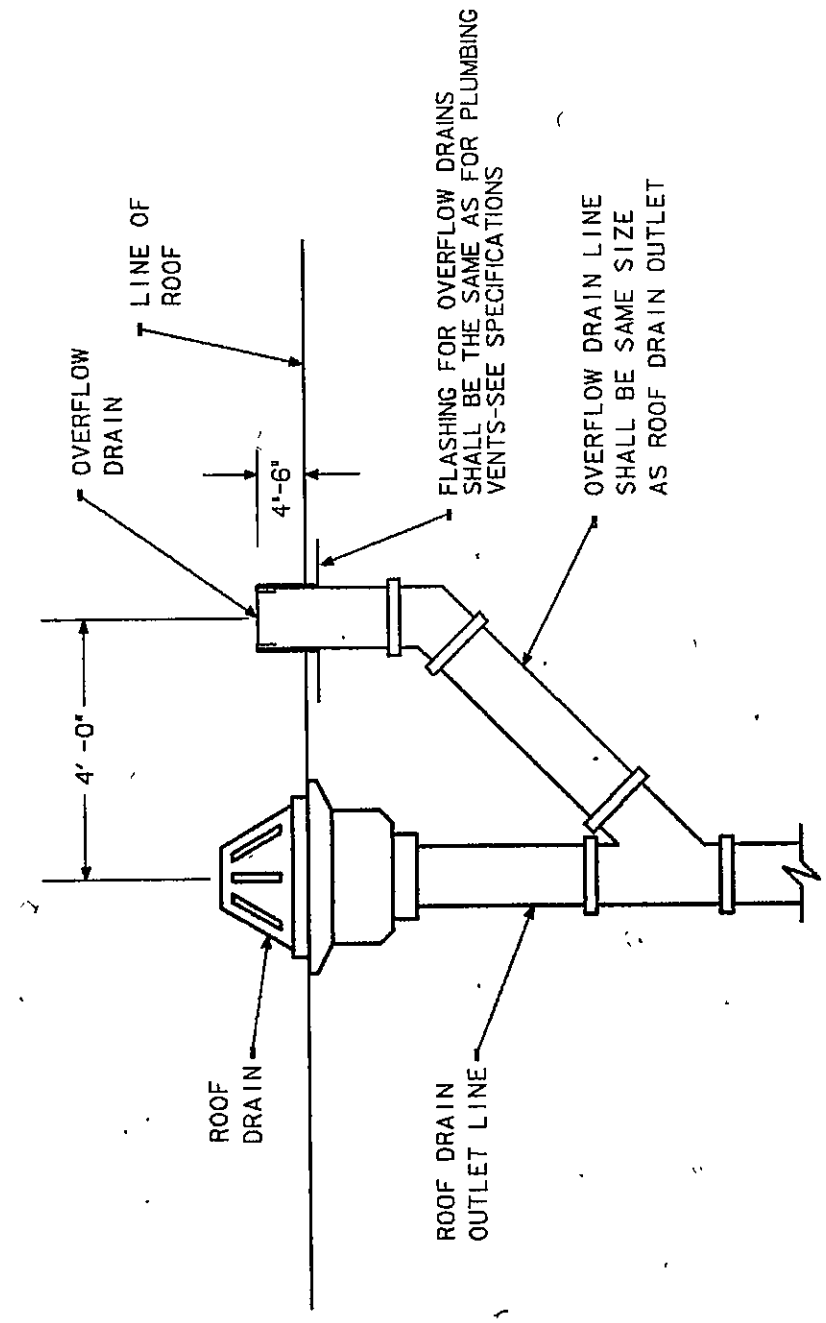

ROOF OVERFLOW DRAIN DETAIL
NO SCALE

NOTES:

1. OVERFLOW REQUIRED FOR ROOF DRAINS A-7 & A-8 ONLY.



ROOF DRAIN SCHEDULE				
ROOF DRAIN NUMBER	SIZE	J. R. SMITH	JOSAM	WADE
A-1 THRU A-8 AND B-1 THRU B-6	4"	1010	21500	3500

ROOF EXHAUST FAN SCHEDULE									
NO.	AREA EXHAUSTED	JUNCTION NUMBER	BACK DAMPER	C.F.M.	R.P.M.	V.P.	V.P.	V.P.	V.P.
JA-1	A-127 HOOD	70GR	8" X 8"	225	1/4	1550	1/25	115	1
JA-2	A-105 HOOD	70GR	8" X 8"	225	1/4	1550	1/25	115	1
JB-1	B-133	71GR	8" X 8"	145	1/4	1600	1/25	115	1


NOTES:

1. CONTROL DES (CONTROLS) (M) FAN TO BE CONTROLLED BY MANUAL SWITCH PROVIDED BY ELECTRICAL CONTRACTOR.
2. INSTALL FAN ON CURB PROVIDED BY THE GENERAL CONTRACTOR.

A-H.U. - A-4 REFRIGERATION PIPING DETAIL
NO SCALE

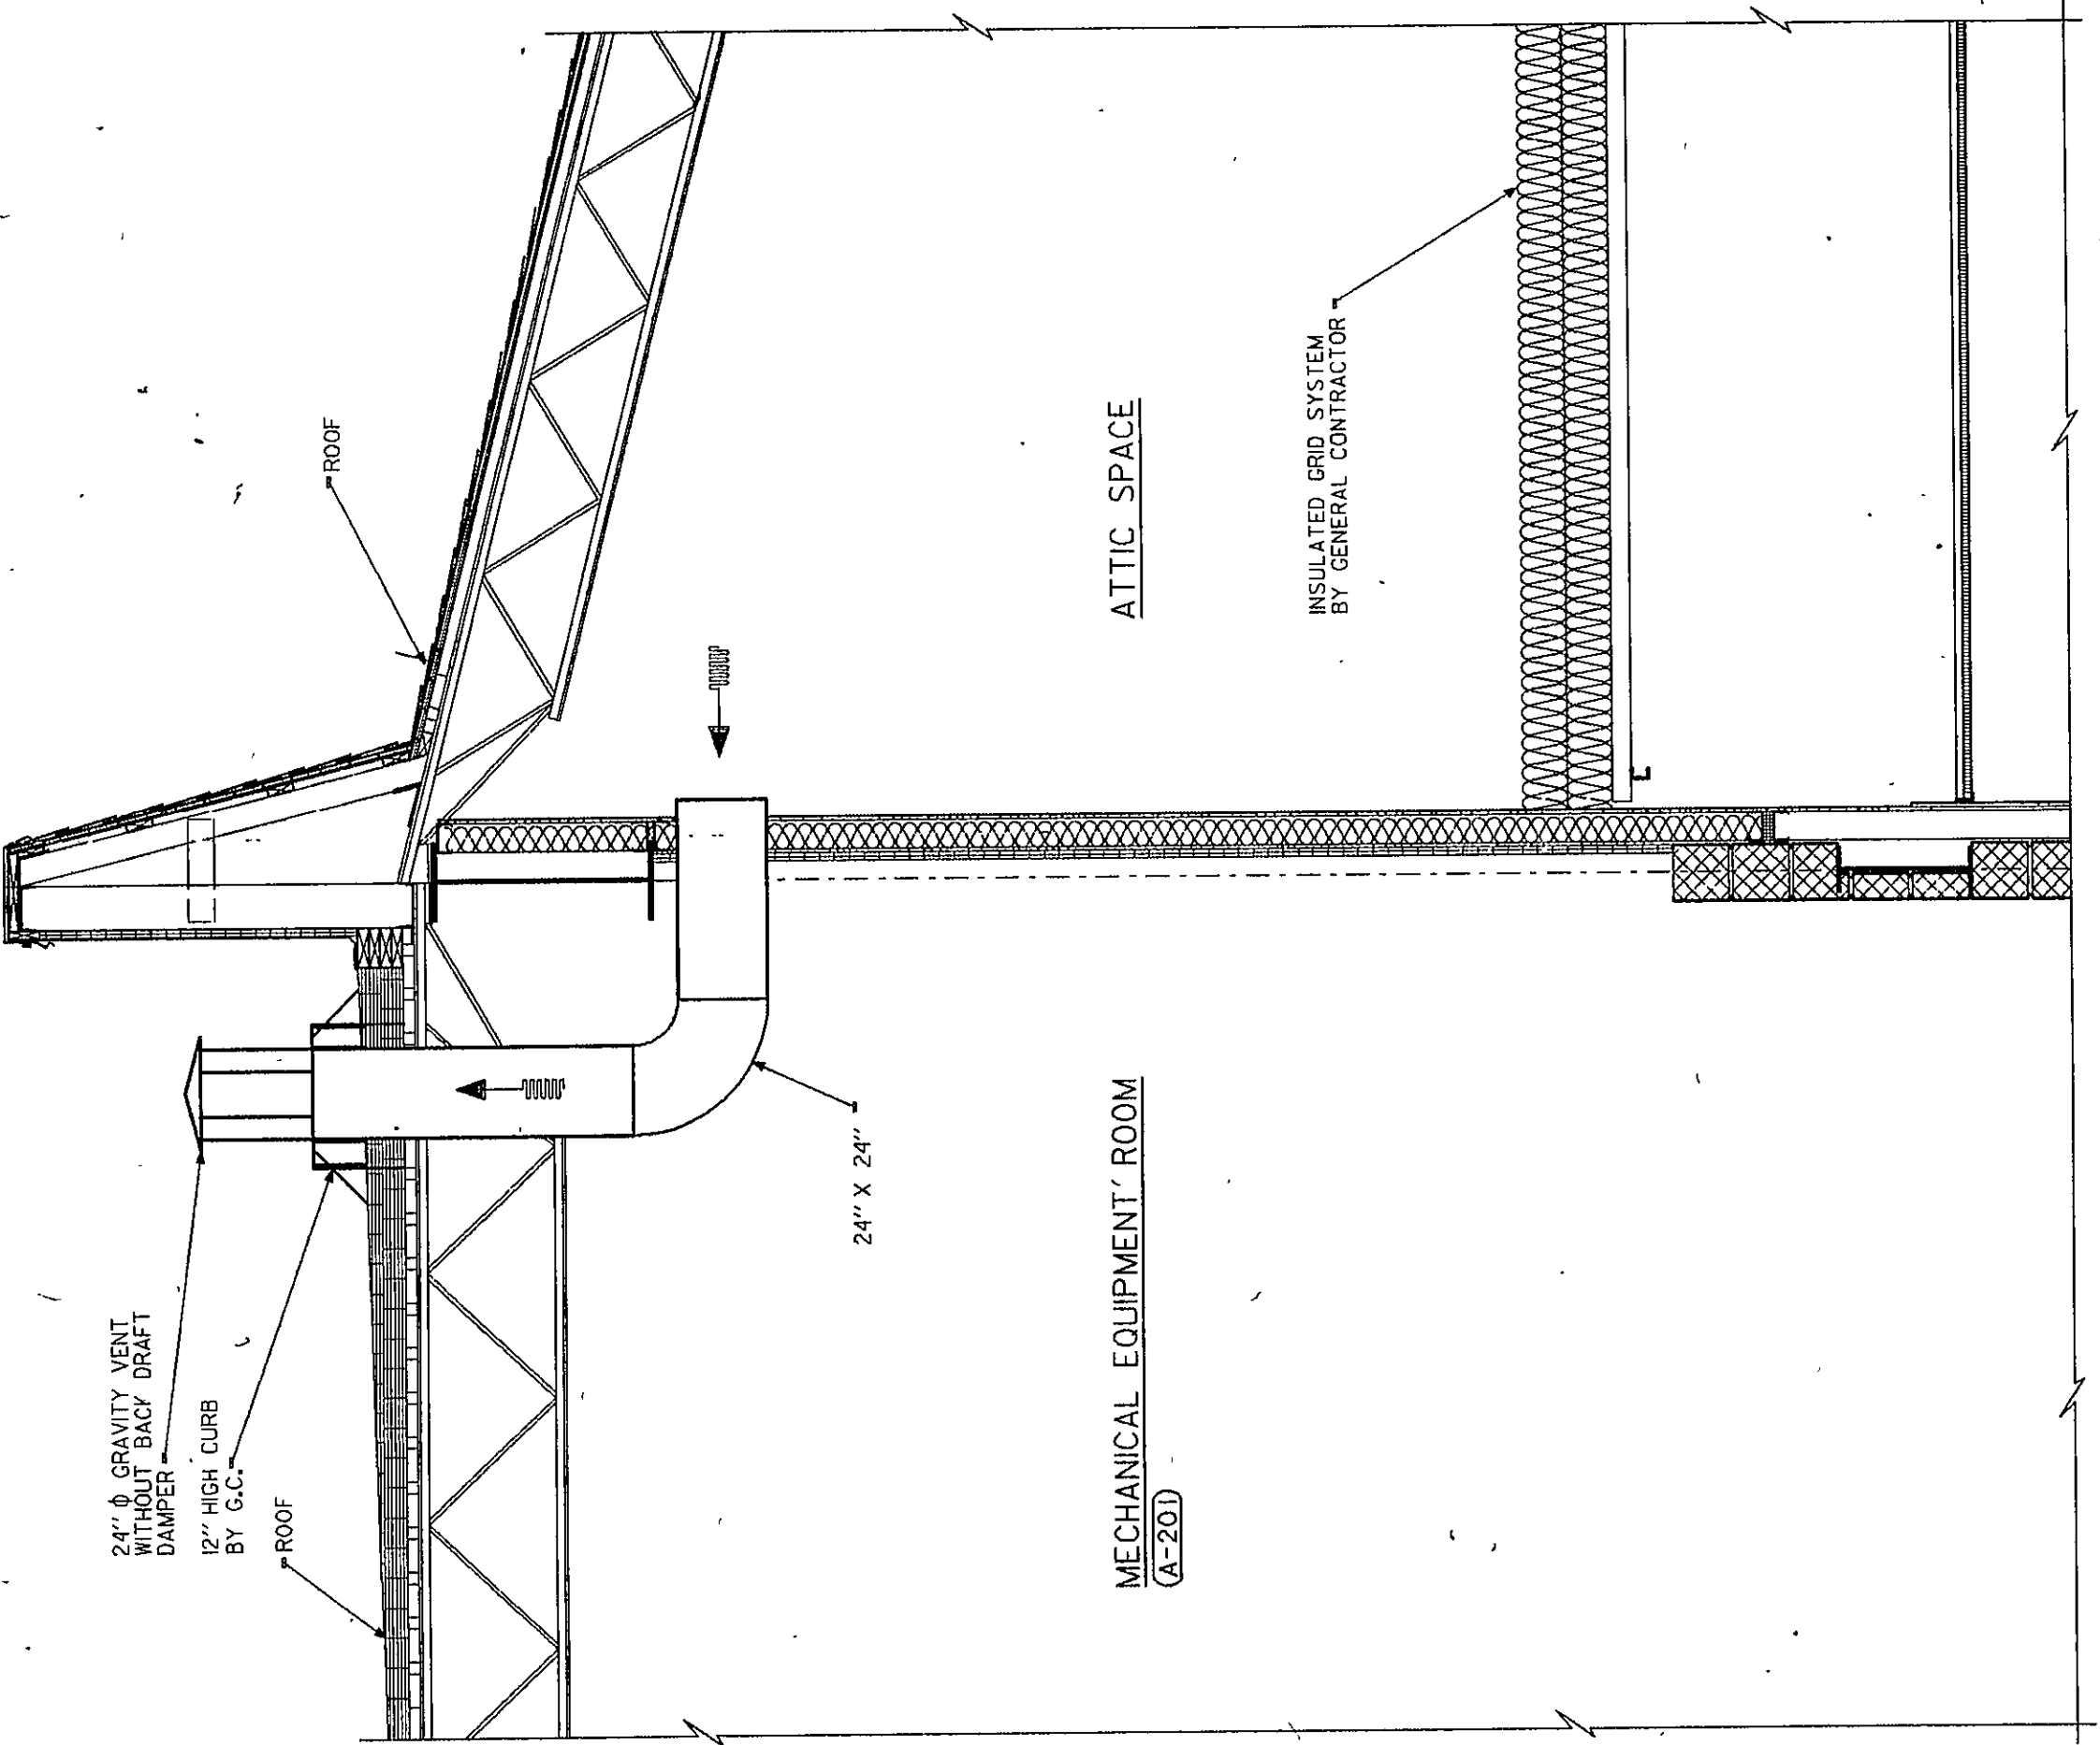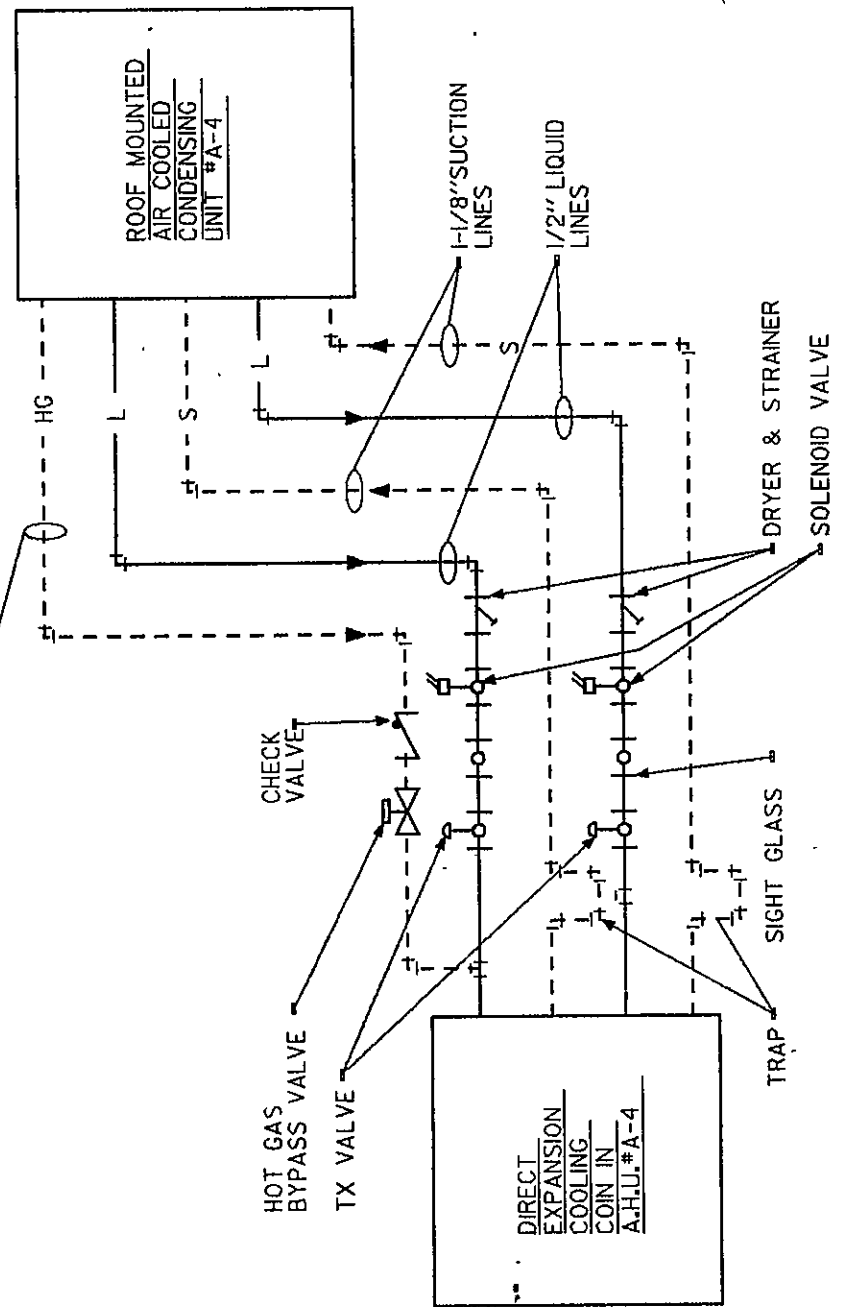

GRAVITY VENT DETAIL
NO SCALE

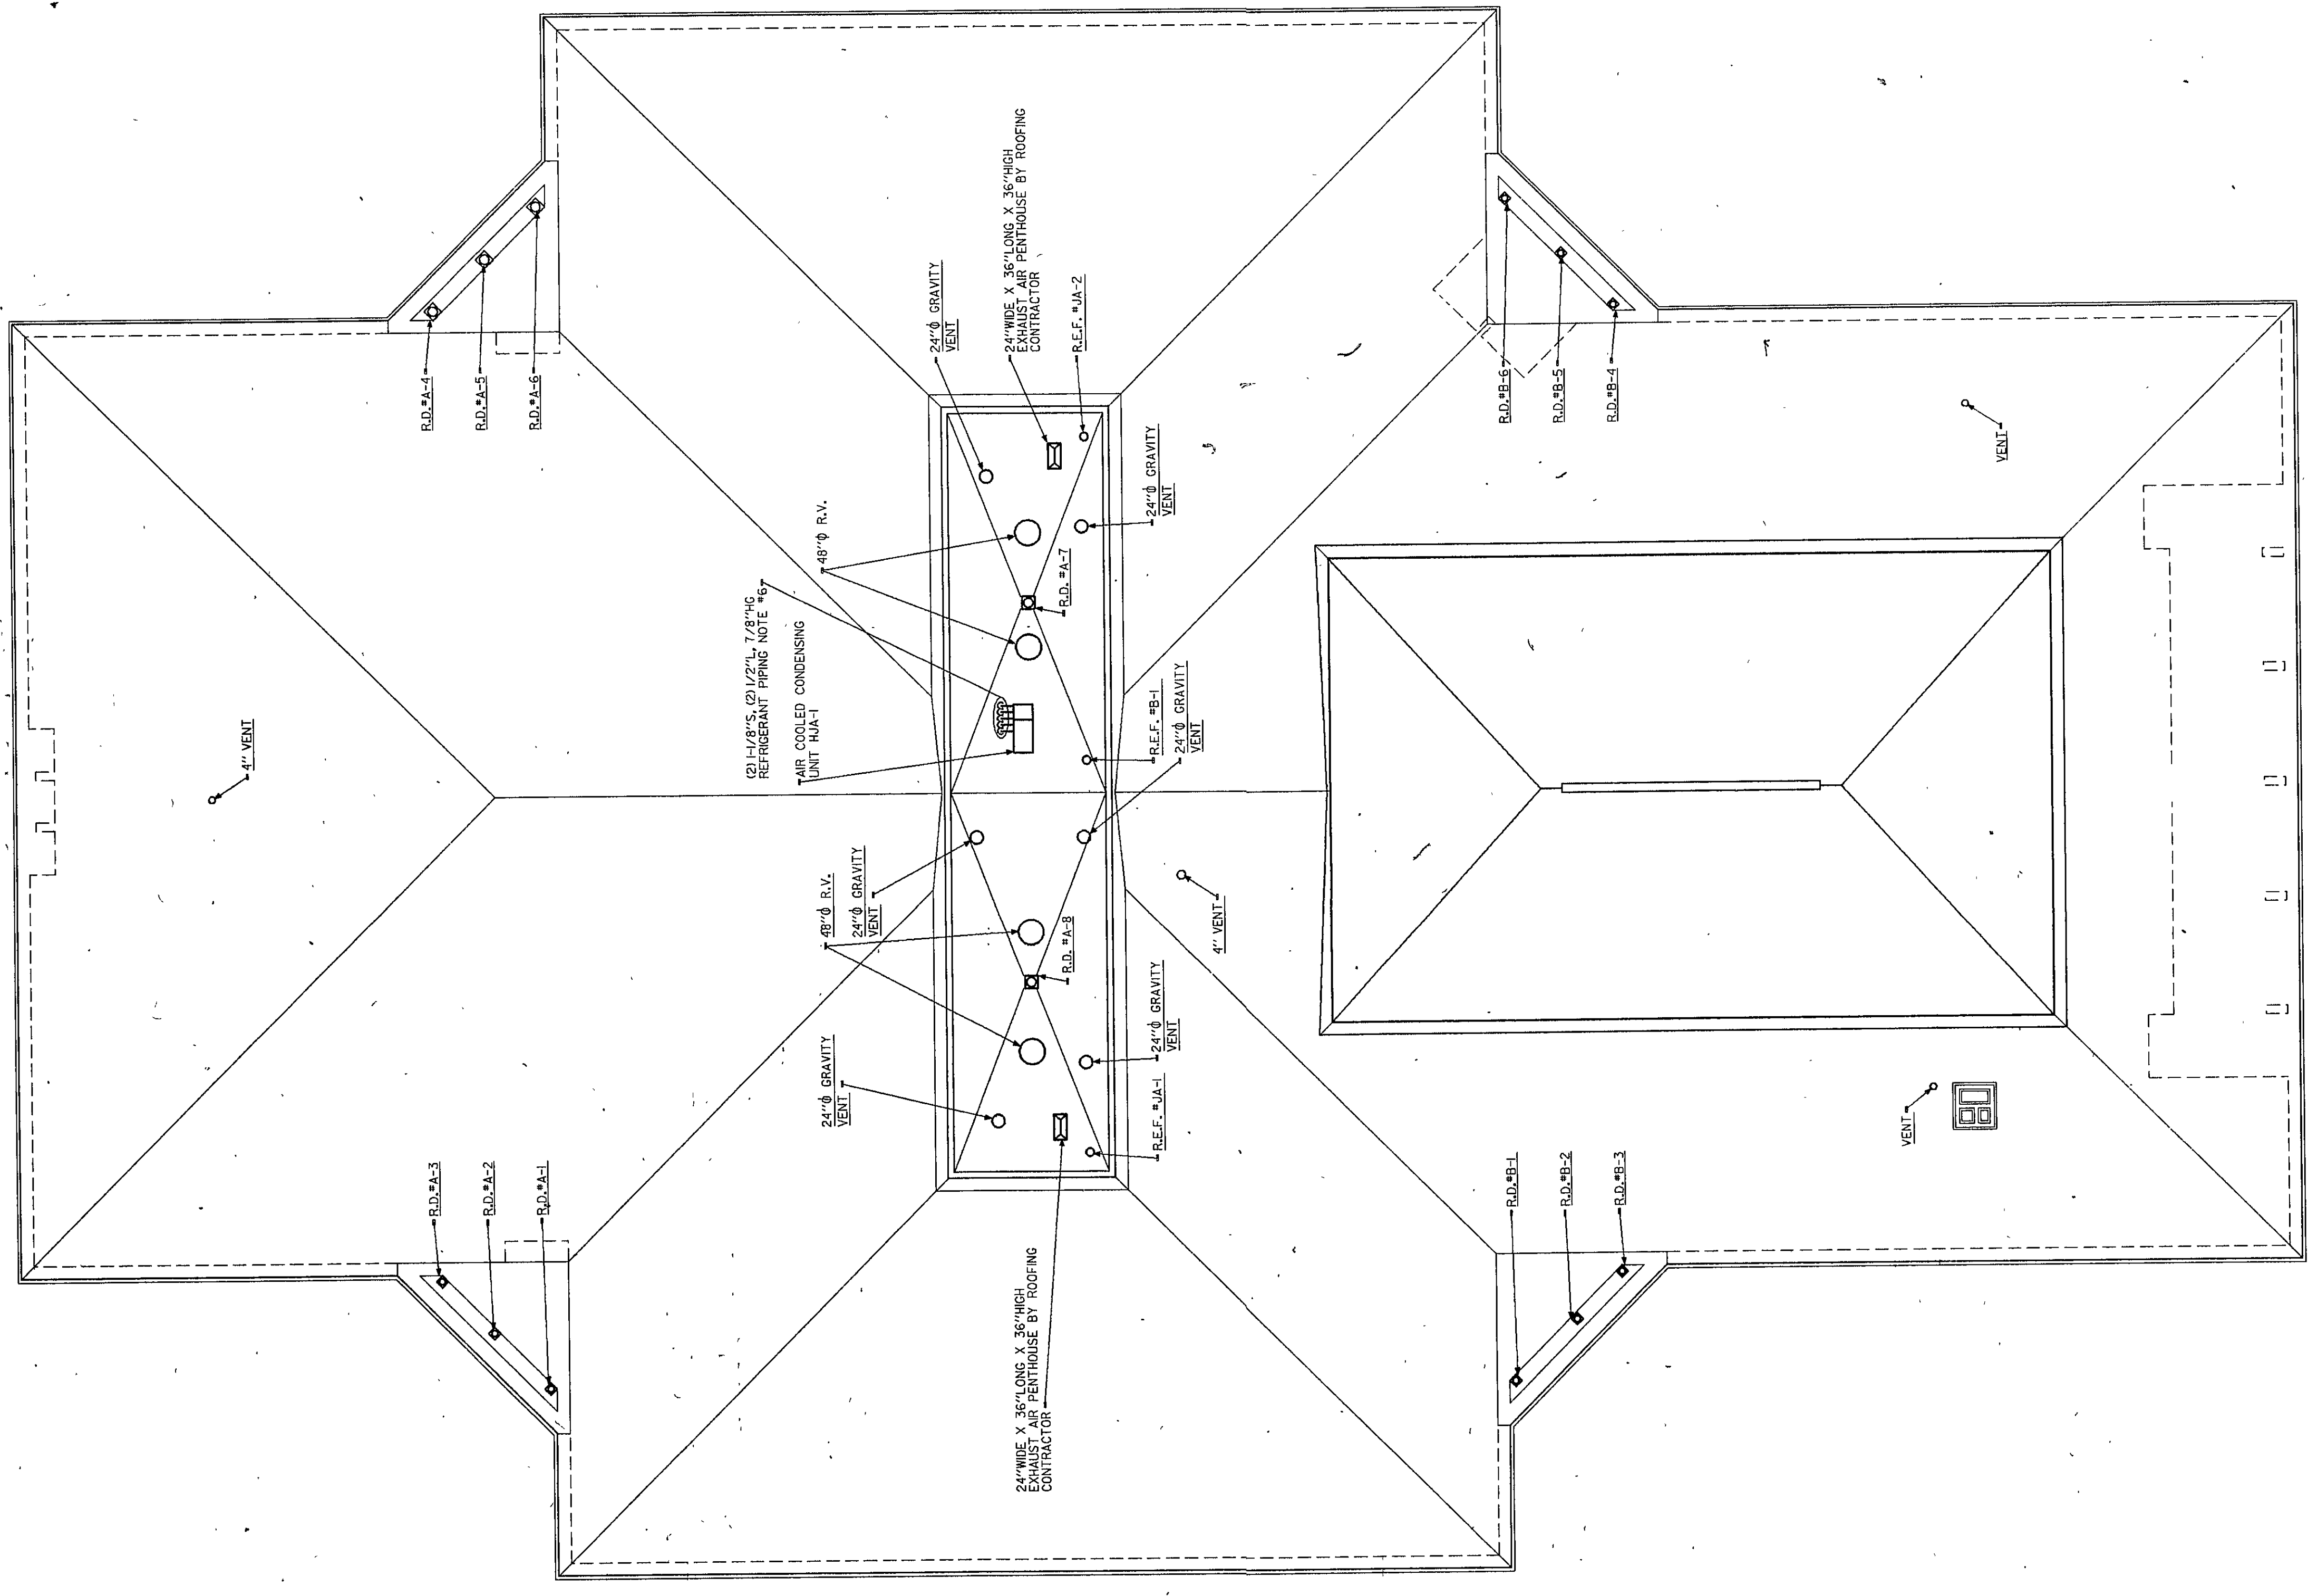

MECHANICAL ROOF PLAN
SCALE: 1/8" = 1'-0"

