


HANGER RETAIL - A
 $\frac{9}{16}'' = 1 - 0''$
 - FOR ROOMS C103, C104 & C105.

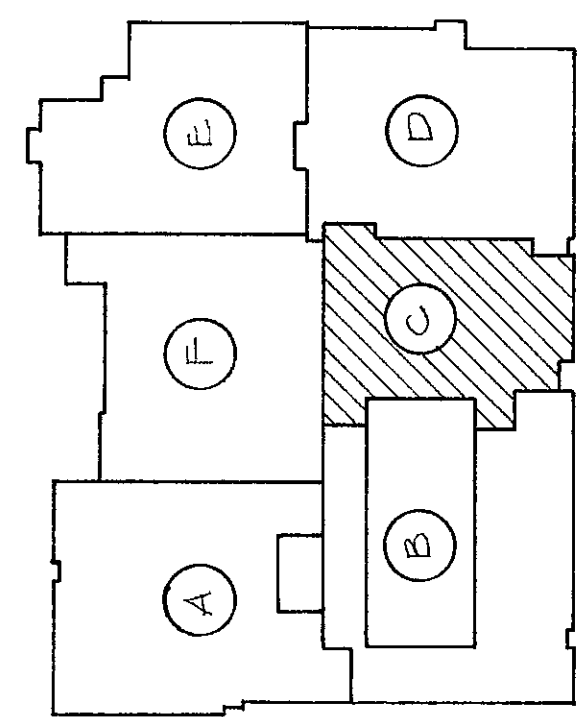

KEY PLAN
NO SCALE

RM.	ROOM NAME	CEILING HEIGHT
C101	Classroom	9'0"
C102	Classroom	Varies
C103	Classroom	Varies
C104	Classroom	Varies
C105	Classroom	Varies
C106	Classroom	Varies
C107	Classroom	Varies
C108	Classroom	Varies
C109	Classroom	Varies
C110	Classroom	Varies
C111	Classroom	Varies
C112	Classroom	Varies
C113	Classroom	Varies
C114	Classroom	Varies
C115	Classroom	Varies
C116	Classroom	Varies
C117	Classroom	Varies
C118	Classroom	Varies
C119	Classroom	Varies
C120	Classroom	Varies
C121	Classroom	Varies
C122	Classroom	Varies
C123	Classroom	Varies
C124	Classroom	Varies
C125	Classroom	Varies
C126	Classroom	Varies

[illegible]

2		
1		
ITEM	REVISION	


LIBERTY MIDDLE
R.R. # 1, BOX 356
CHICESTON, INDI

SHAMBAUGH & SON, INC.
Five Deane Street, Boston

Fire Protection Division

FORT WAYNE, INDIANA 9011 FRONT STREET, 46818
INDIANAPOLIS, INDIANA 1010 EAST SUMNER AVE., 46227
EVANSVILLE, INDIANA 2131 COMMERCIAL COURT, 47712

DEGREE OF SPRINKLER	165	165			
TYPE OF SPRINKLER	C-P	B-U			
TOTAL SPRINKLERS	173	2			
TOTAL THIS SHEET	121	TOTAL THIS JOB	986		
APPROVAL AGENCY	STATE FIRE MARSHAL 150.				
DRAWN BY	DATE	SCALE	CS NO	DWG NO	
TSP		1/8" = 1'-0"	4005 B.	4 OF 7	

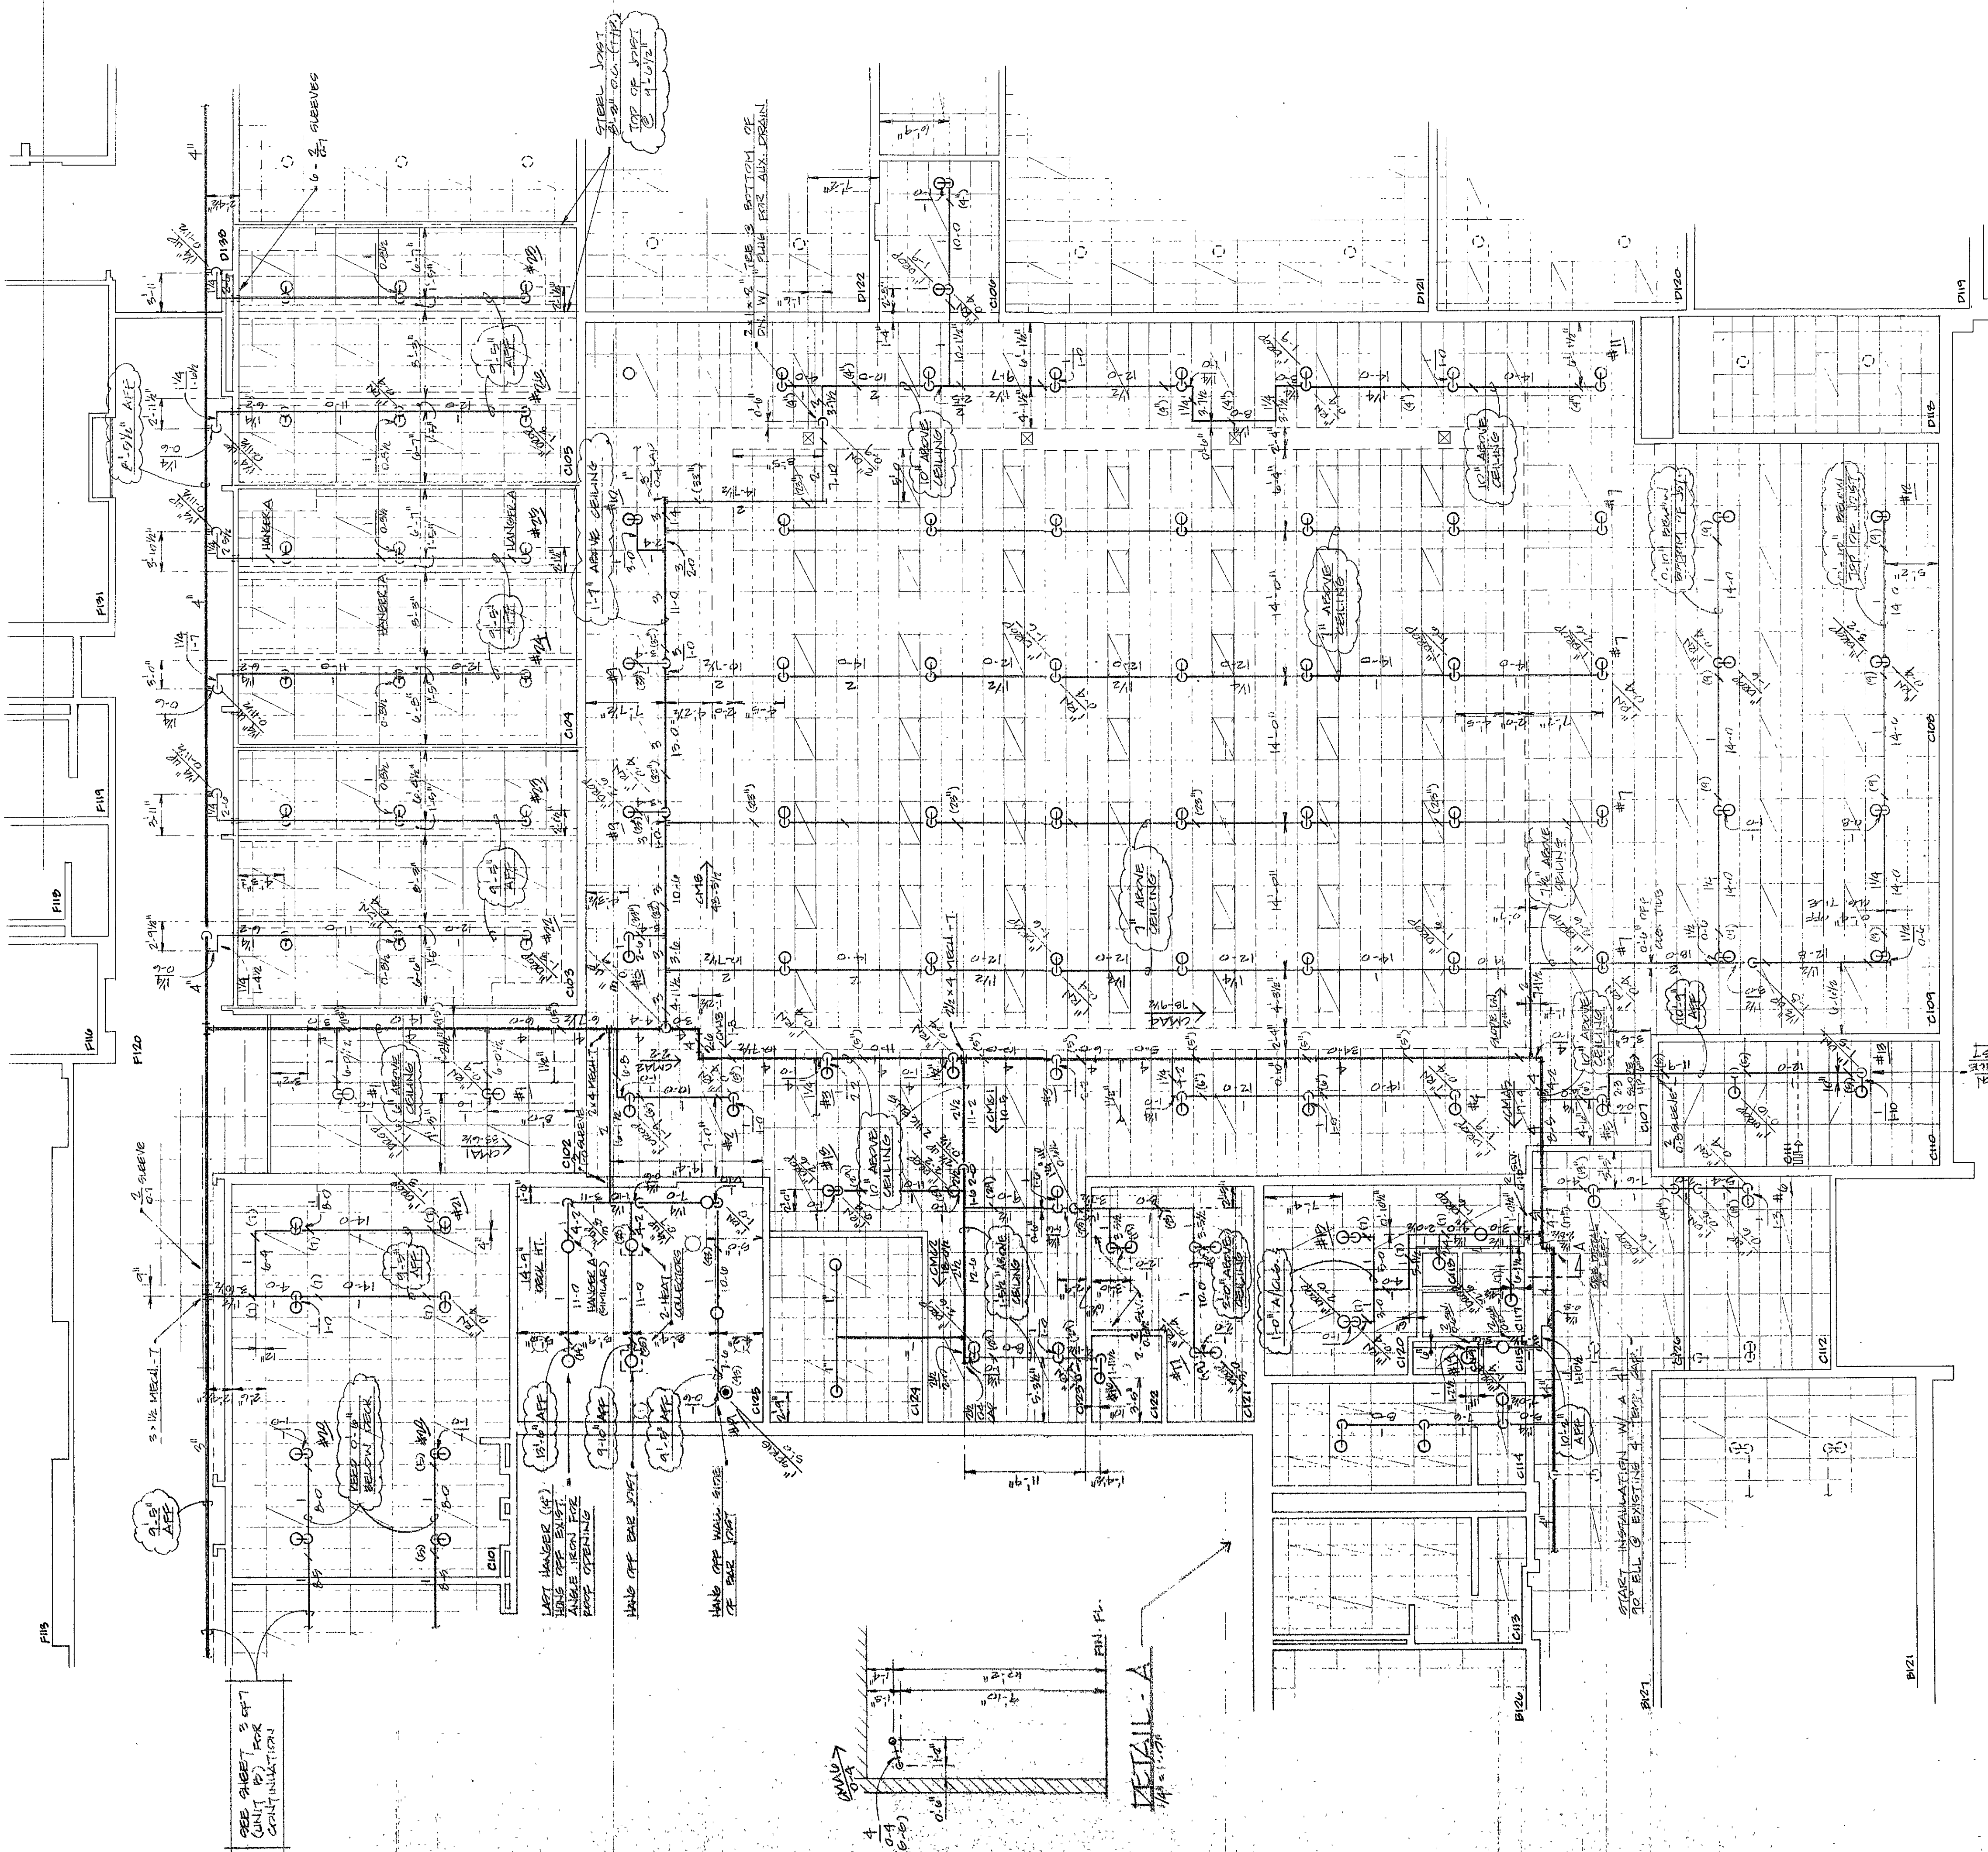

UNIT "C" - FLOOR PLAN