


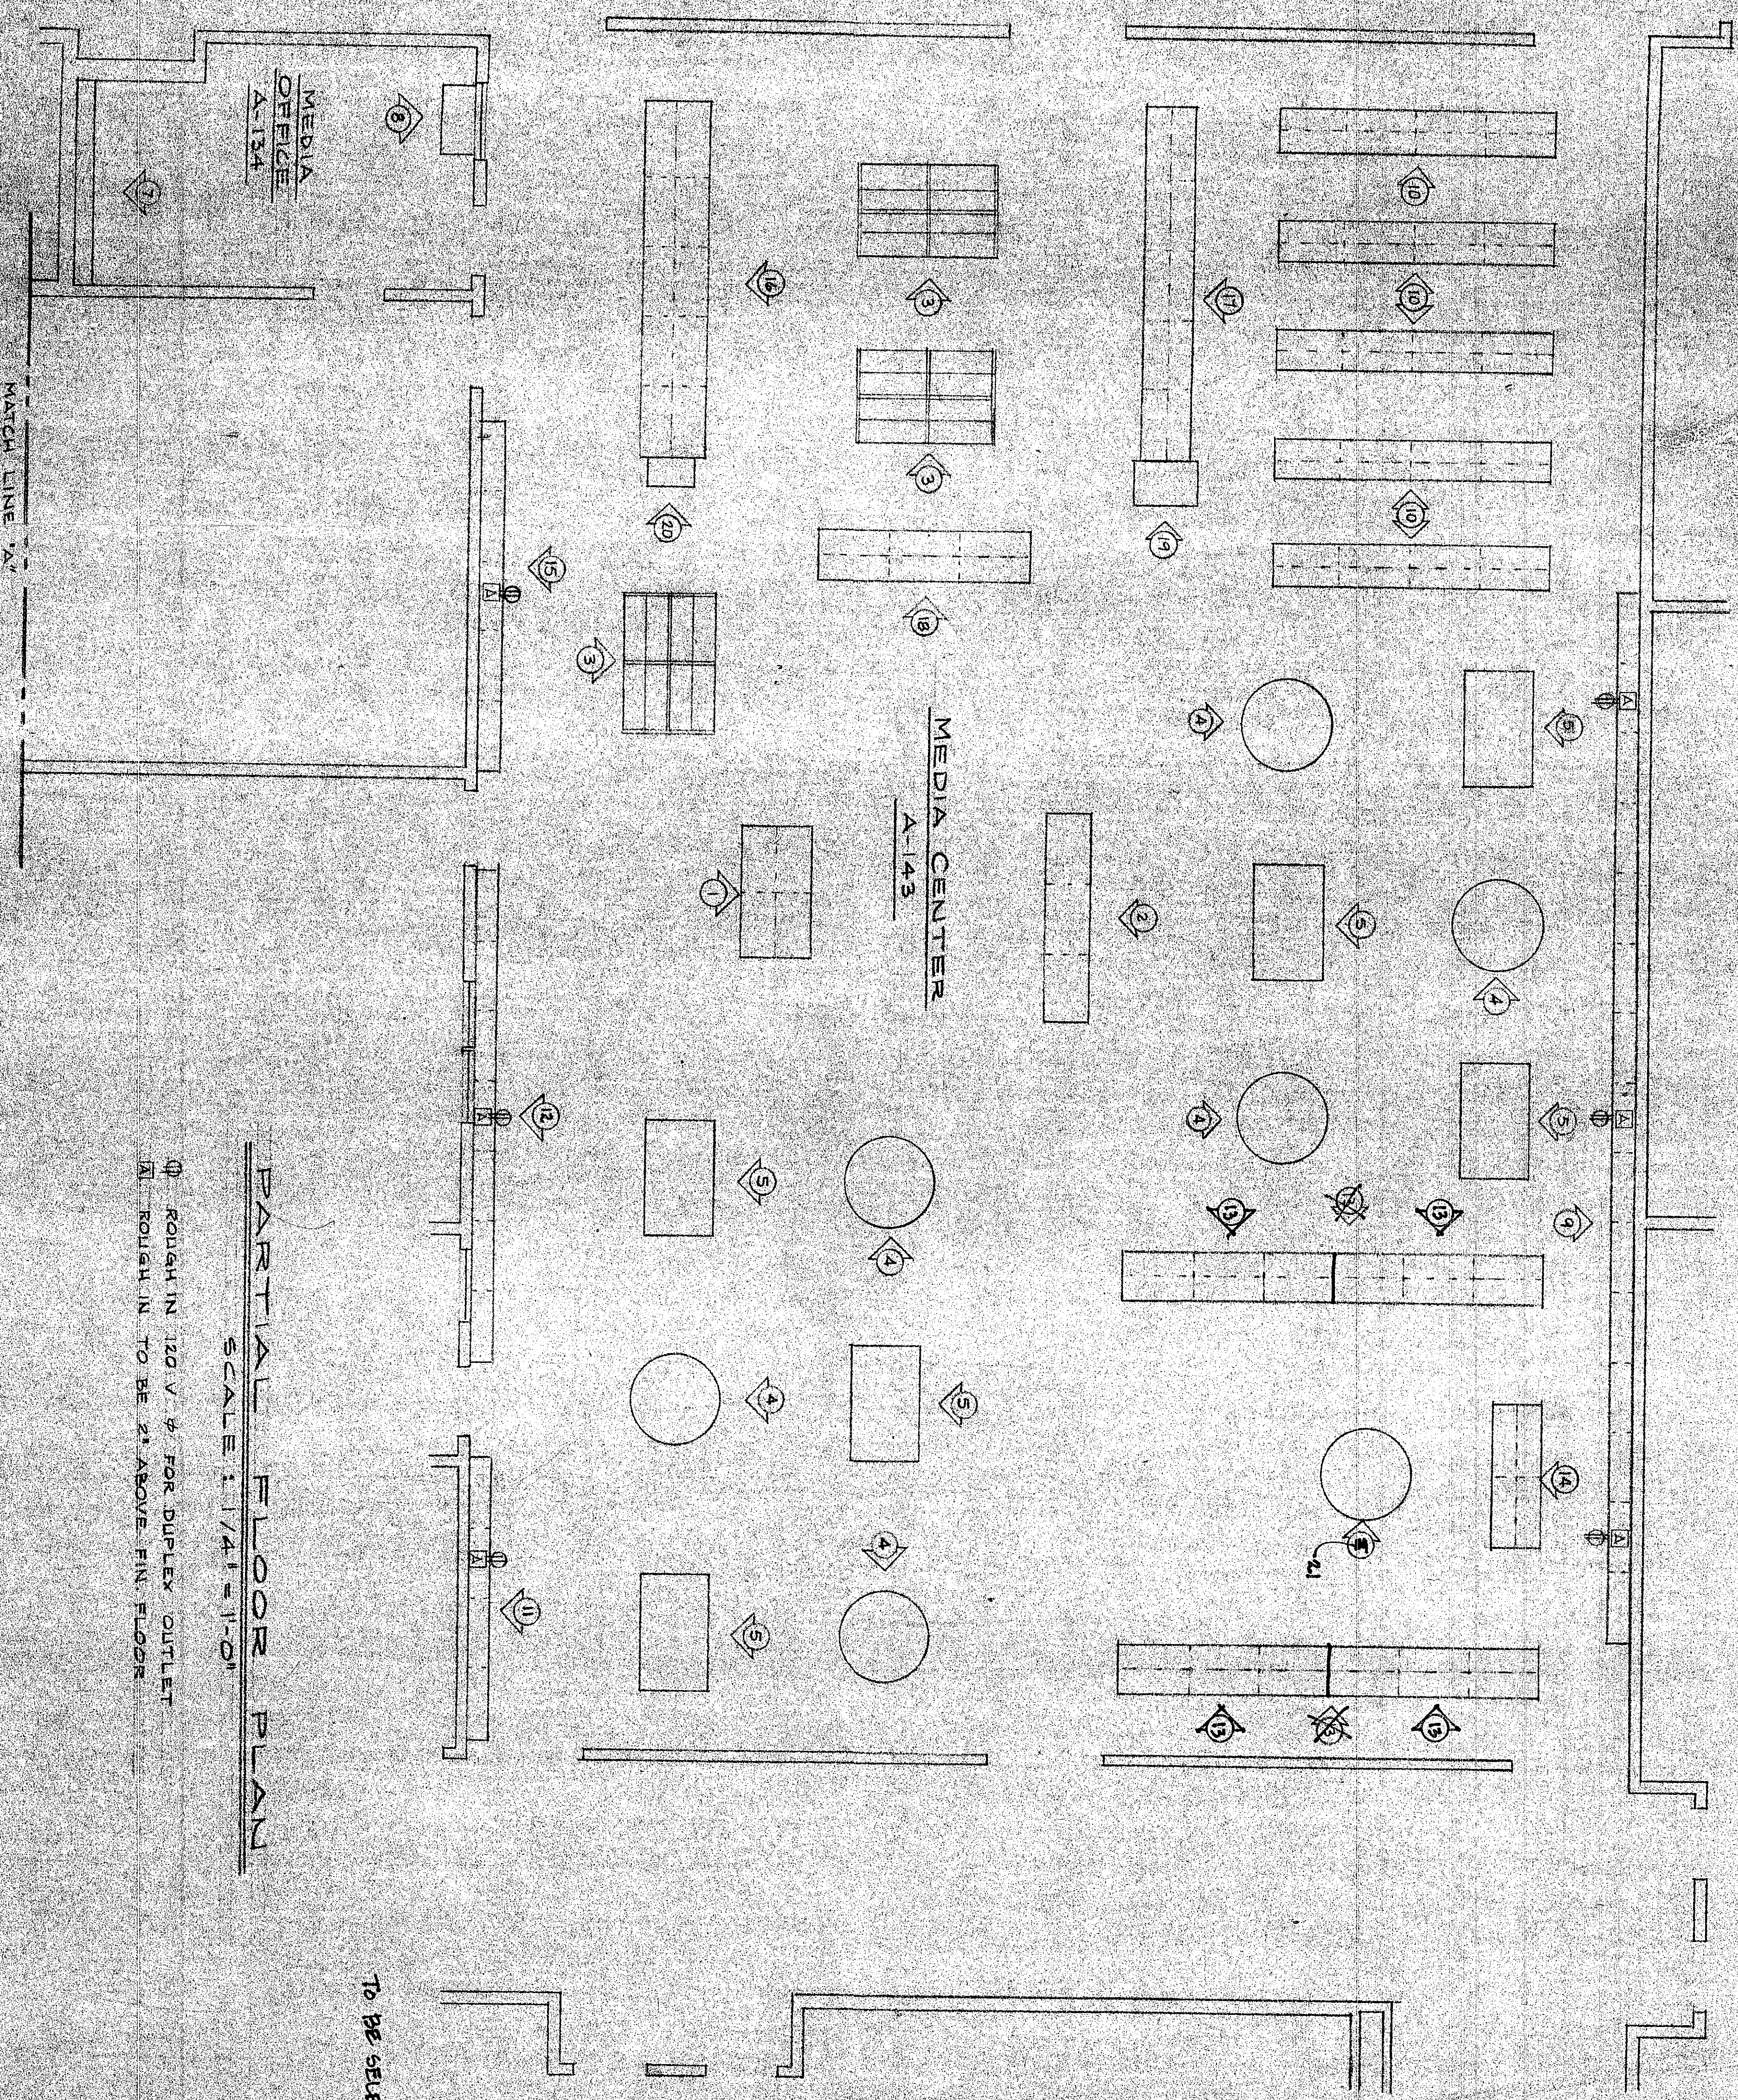

PARTIAL FLOOR PLAN

SCALE: 1/4" = 1'-0"

- 1. ROUGH IN 120 V. 3. FOR DUPLEX OUTLET
- 2. ROUGH IN TO BE 2" ABOVE FIN. FLOOR

GENERAL NOTES

CONSTRUCTION	STEVENS STANDARD	REFERENCE
COLOR SELECTION		COLOR SELECTOR
EXTERIOR		
* INTERIOR		
FRONTS		
TOPS		
TRIM		
GROUP I	CHECK	
GROUP II	ONE	
GROUP III		
GROUP IV		

TO BE SELECTED

BASE MOLDING
BY OTHERS
PASS: SEYMOUR C100
GRAY RECEPTACLE
SERIAL 5-BN COVER PLATE
2 X 5 SWITCH BOX

* STARTER AND ADJUSTING (S) SPRING WILL
BE SELECTED FOR EXTERIOR. ALL EXTERIOR
SELECTOR FOR EXTERIOR. ALL EXTERIOR
SELECTOR FOR EXTERIOR.

APPROVED FOR

Approved As Noted
Beverly L. Brown Co.

Date: March 20, 1983
By: Jack Kreyer

NOTE TO GENERAL ELECTRICAL AND MECHANICAL CONTRACTORS:
1. ALL DIMENSIONS ARE TO FINISHED SURFACES.
2. SEE ARCHITECT'S MECHANICAL AND ELECTRICAL LAYOUTS
FOR ADDITIONAL INFORMATION.
NOTE TO: Jackson Elementary School
1. IT IS THE CONTRACTOR'S RESPONSIBILITY TO VERIFY
ALL ROUGH IN LOCATIONS BEFORE SLAB IS POURED.

STEVENS

LEE COMPANY, INC.
TERRE HAUTE, INDIANA

JACKSON ELEMENTARY SCHOOL
VALPARAISO, INDIANA

82335
OF 3

1/4" = 1'-0"
MECHANICAL

APPROVED
FIELD CHECK
DATE

ACCEPTED BY