


STANDARD DRAWING 101.04

DATEPRINT CORP. 700 SO. CLAREMONT ST. SAN MATEO, CA. 94402

BASEMENT TUNNEL LEVEL FLOOR PLAN - HVAC

SCALE: 1/8"=1'-0"

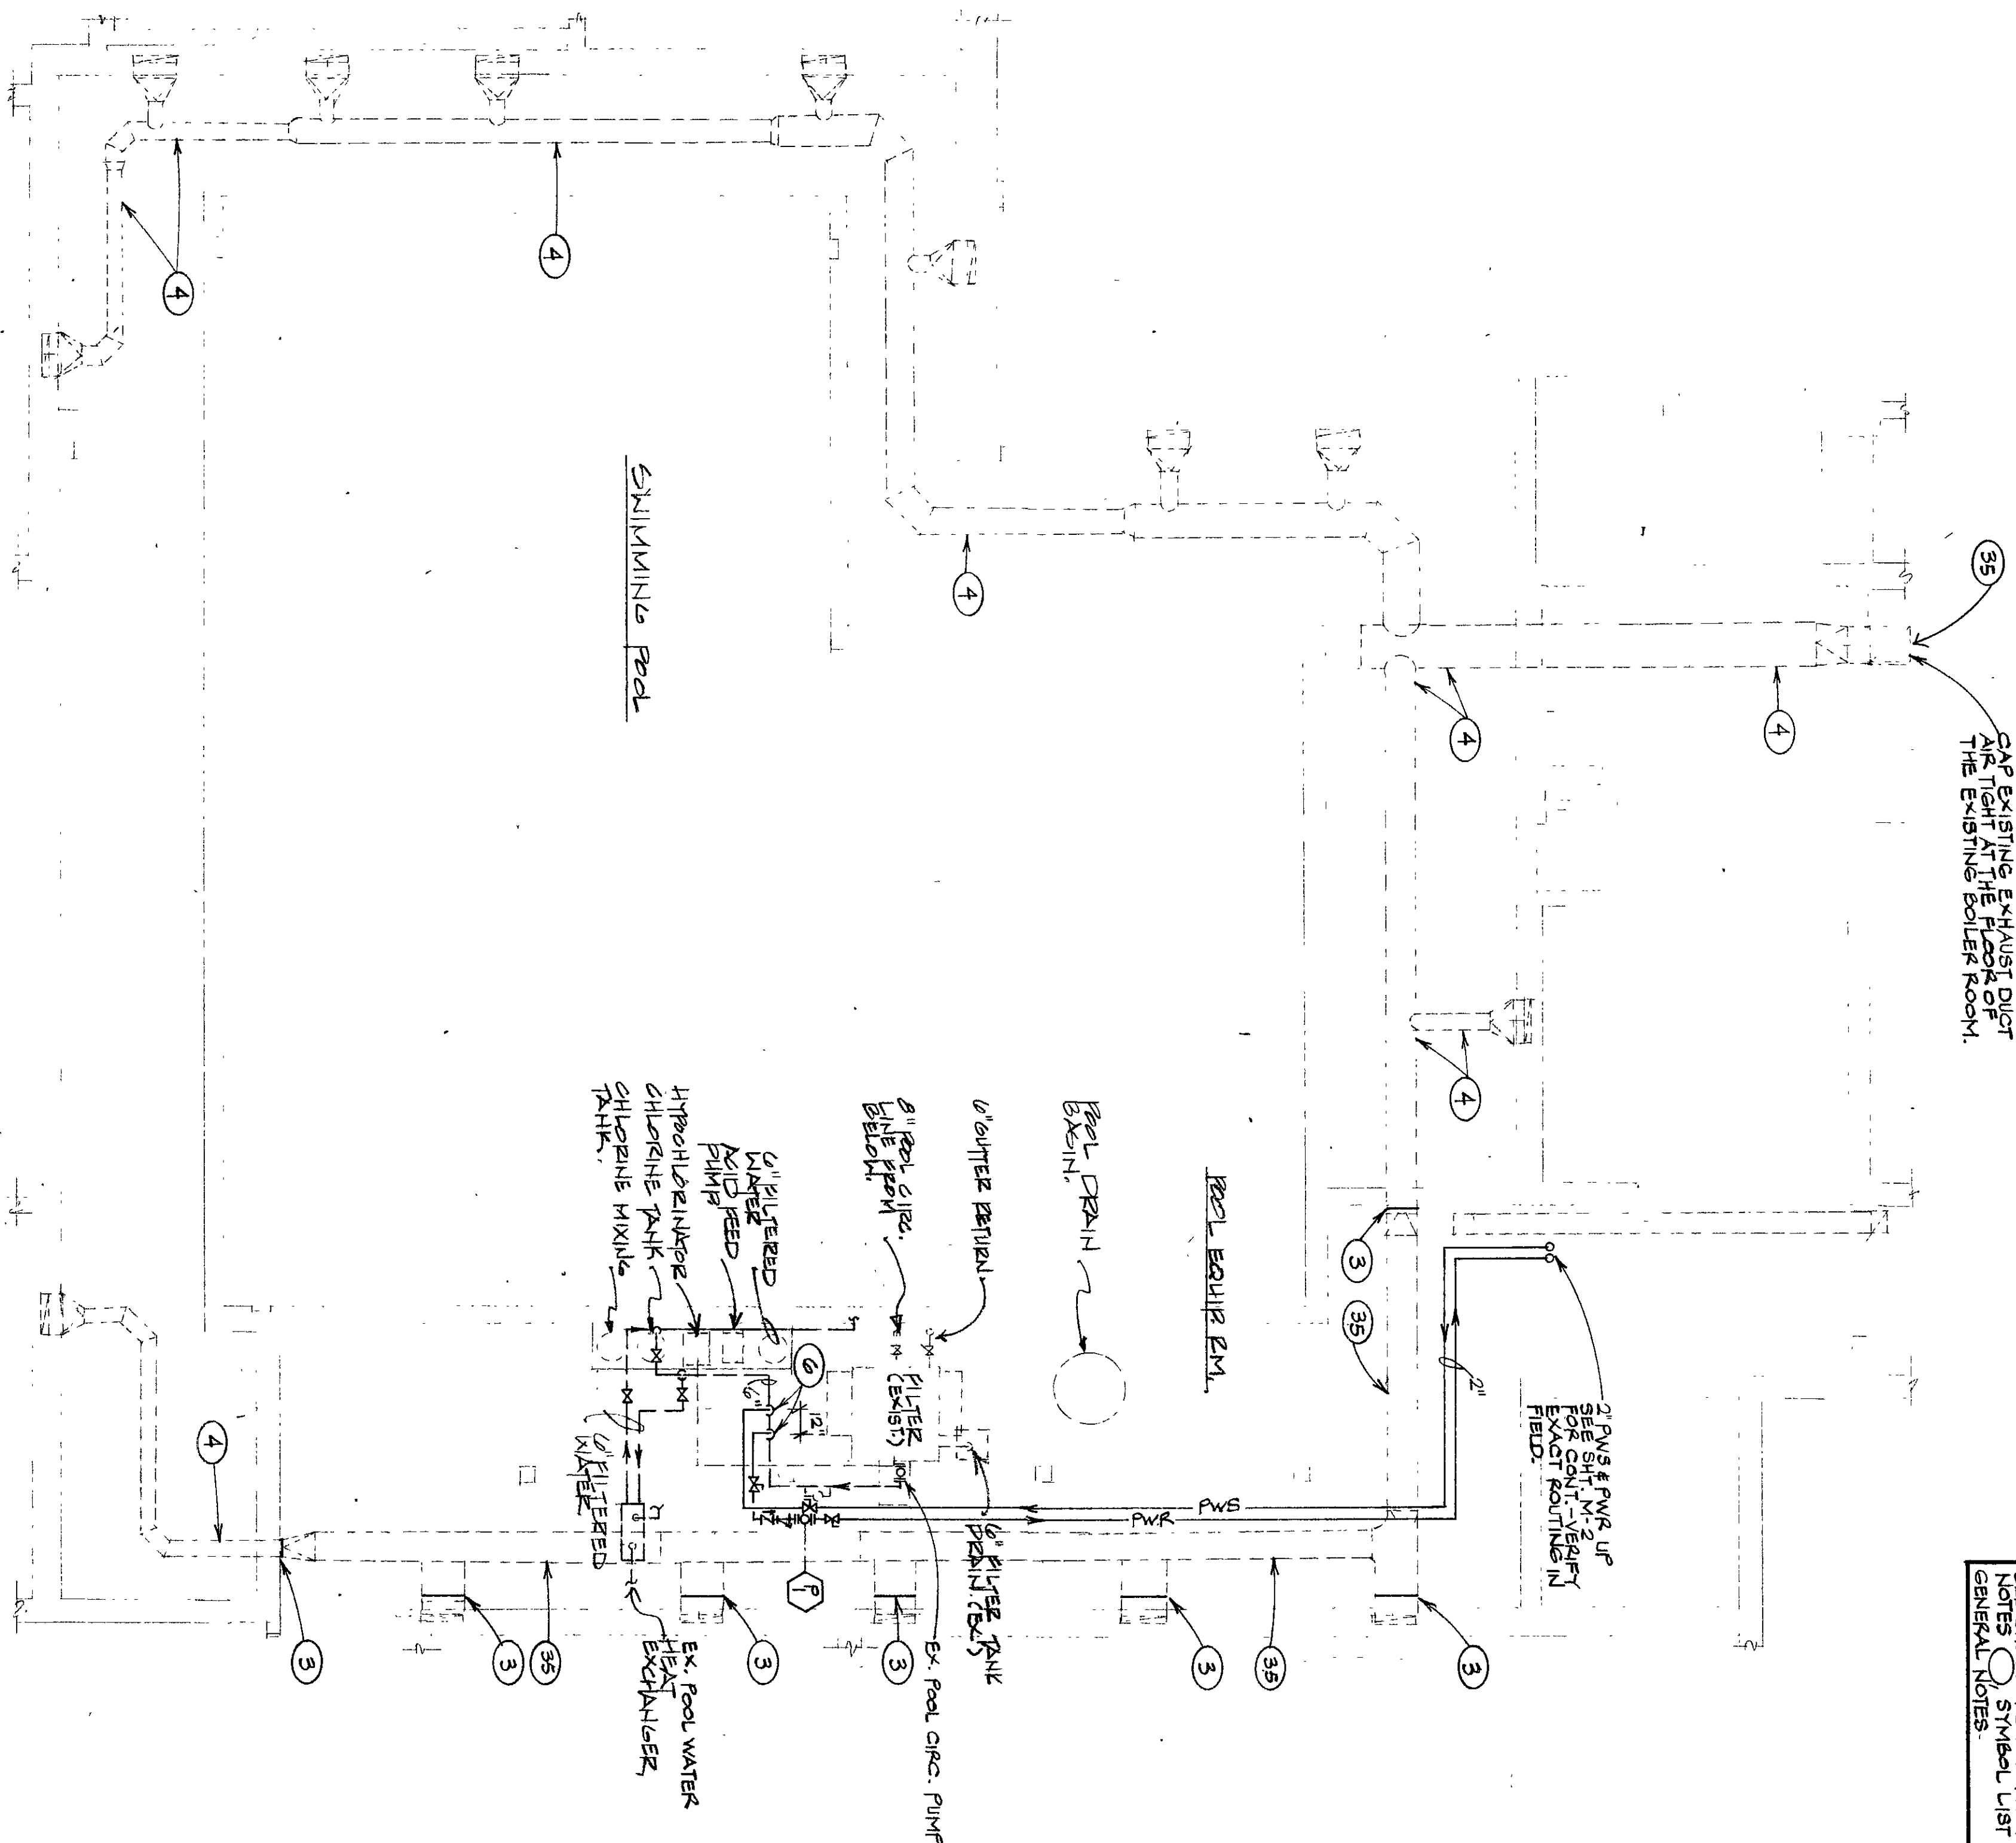

SEE SHEET M-3 FOR MECHANICAL NOTES SYMBOL LIST & GENERAL NOTES

SEE ENLARGED MECHANICAL ROOM PLAN SHT. M-2 FOR CONTINUATION OF DUCT WORK & NEW SYSTEM LAYOUT.

DRILL THROUGHOUT & HIDE/DRIFT WIDE OPEN IN ALL DOORS

NOTE: ARCHITECTURAL DRAWING A-2 FOR EXACT LOCATION OF ALL DUCTWORK PENETRATIONS THRU NORTH WALL OF MECHANICAL ROOM

20/20 UP TO EX. EXH. FAN #C-12. REBALANCE FOR 3400 CFM CHANGE DRIVE & MOTOR AS REQ'D.

SET DIFFUSERS @ 45° DEFLECTION (TYPICAL)

DIFFUSERS TO LINE UP WITH ROSE ACCESS POOL. VERIFY EXACT LOCATION W/ARCH. IN FIELD.

UPPER LEVEL FLOOR PLAN - HVAC

SCALE: 1/8"=1'-0"

