


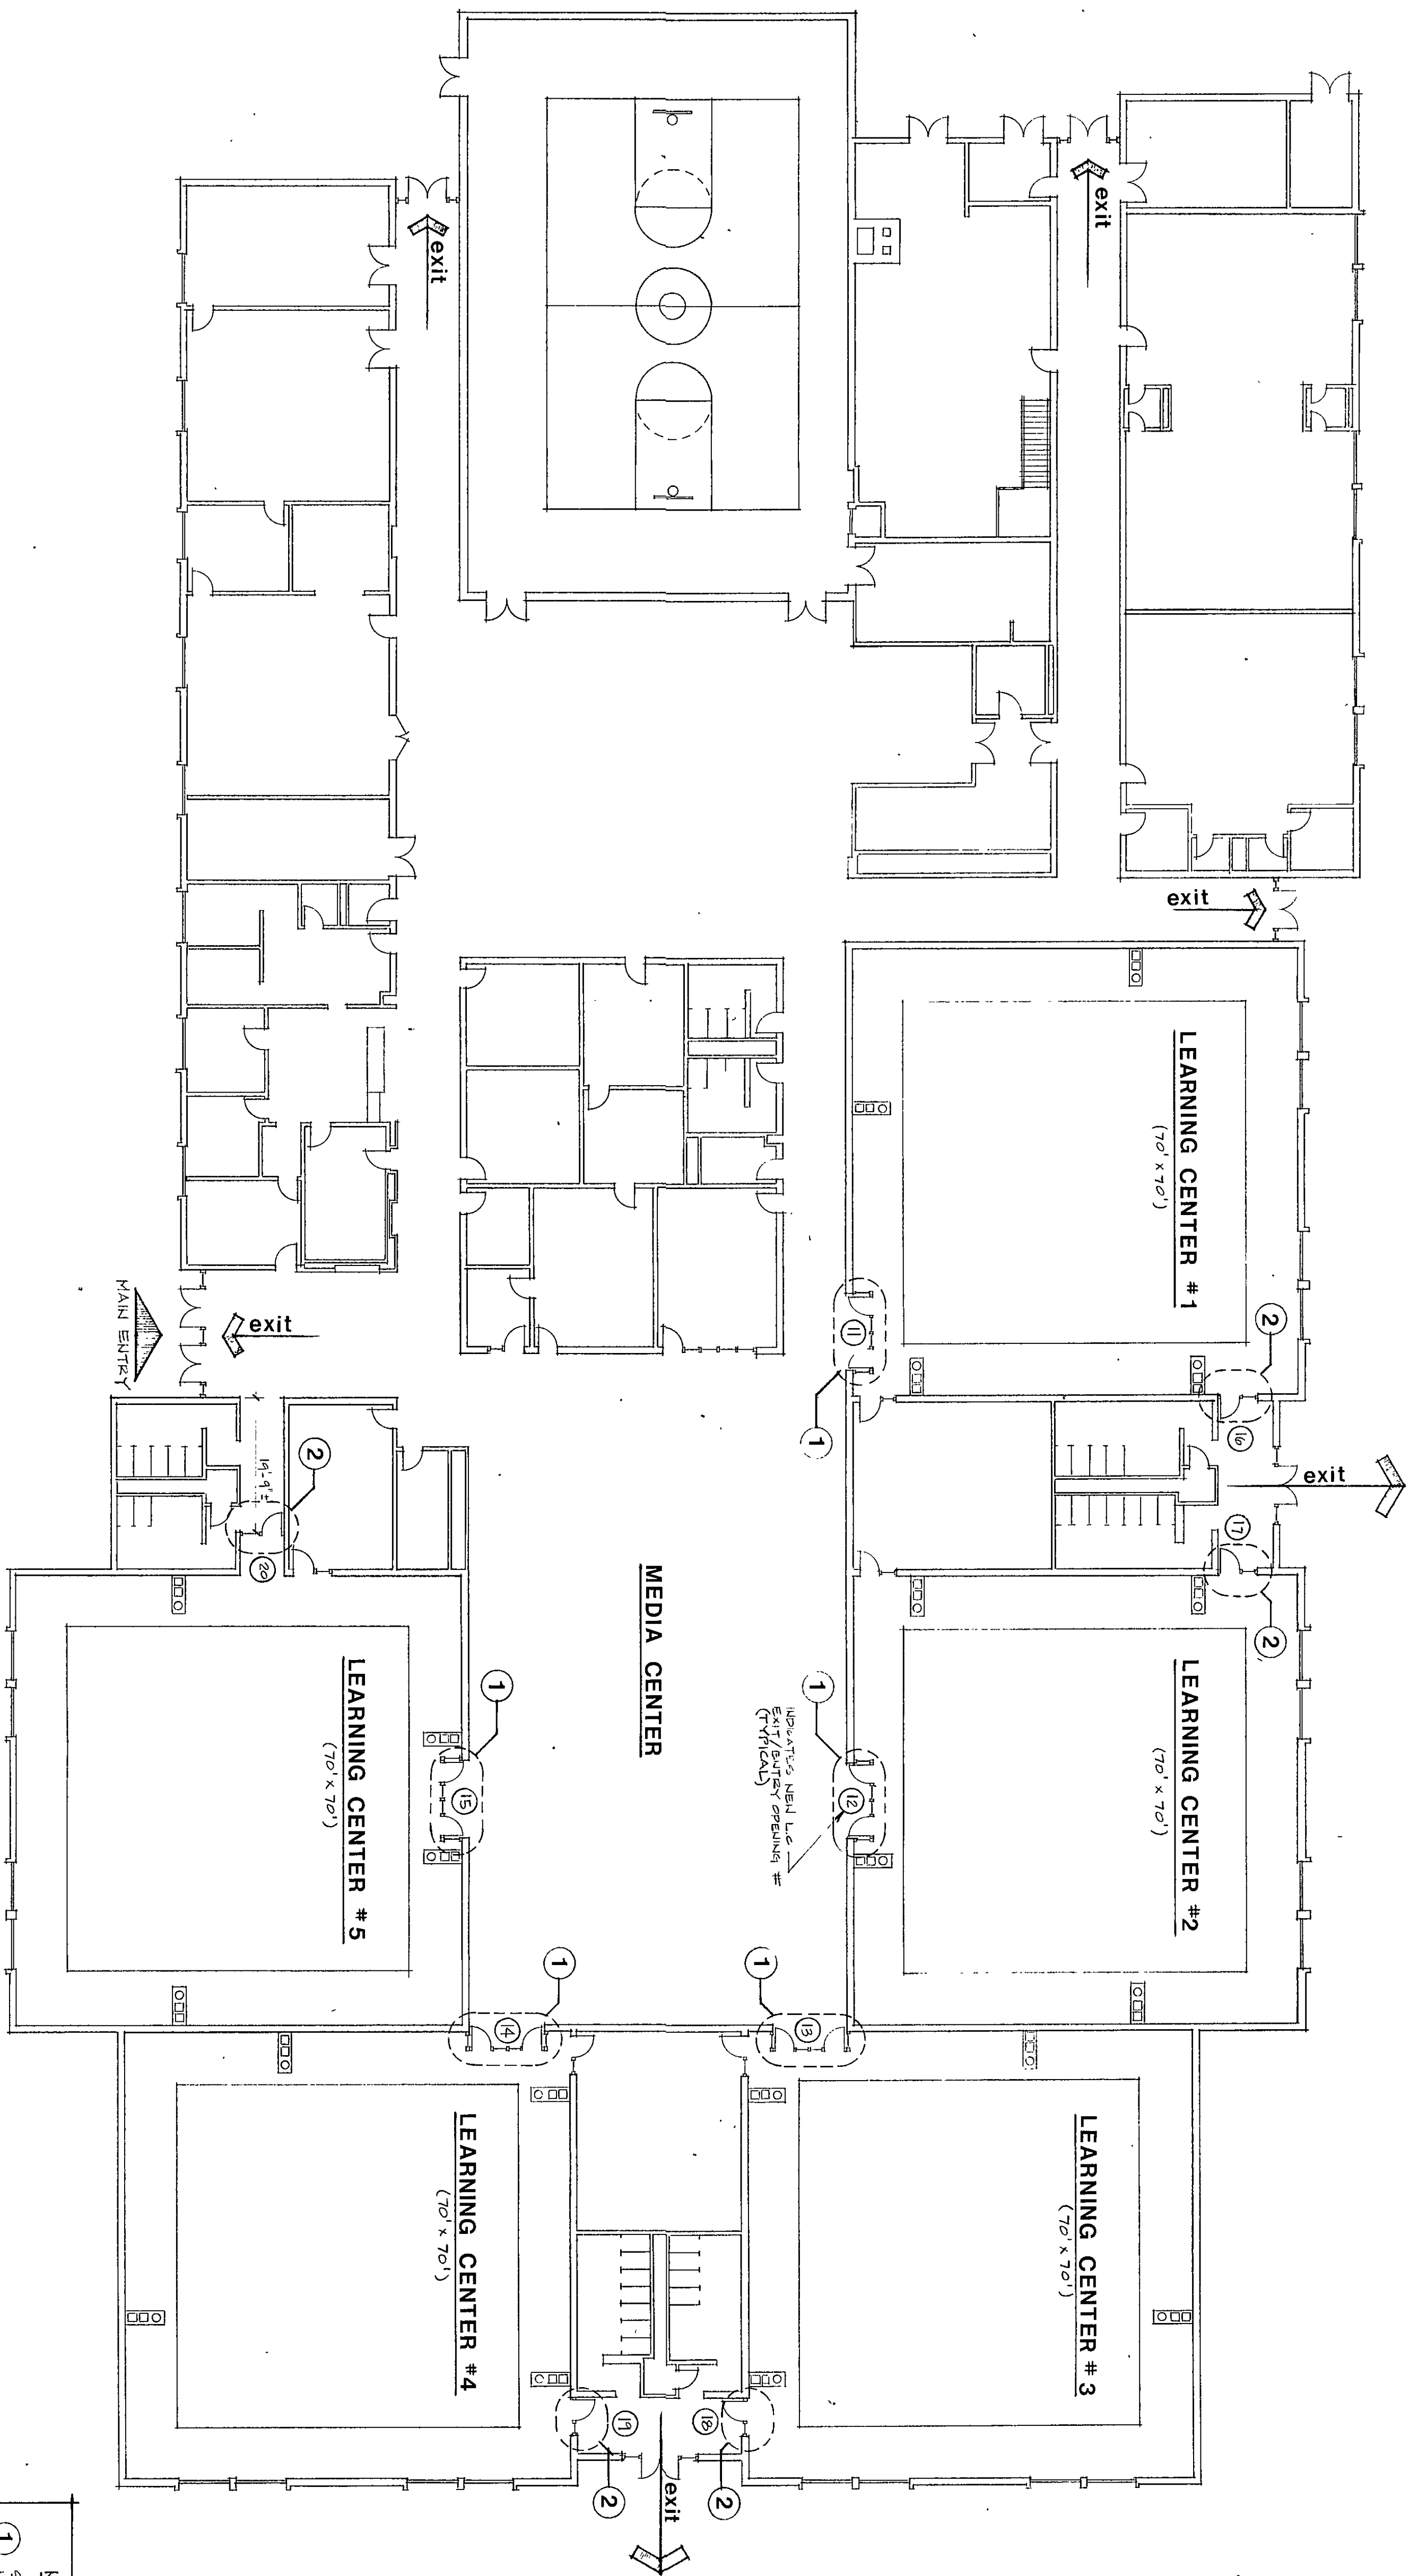

LIBERTY ELEMENTARY

1/16" = 1'-0"

NORTH

PLAN REVIEW NOTE:

1. LIBERTY ELEMENTARY SCHOOL WAS BUILT/OCCUPIED IN 1971
2. EXISTING BUILDING CONSTRUCTION IS TYPICAL
3. BUILDING IS SINGLE-STORY SLAB ON GRADE, APPROXIMATELY 69,600 S.F.
4. BUILDING WAS CONSIDERED AS AN "EXISTING CONCEPT" FOR EDUCATIONAL FACILITY
5. BUILDING IS NOT FIRE SPANNED, BUT DOES CONTAIN A SIPSPECIFIED FULL STATION FIRE ALARM SYSTEM.

NOTES:



1. SEE DRAWING SHEET A-3 FOR NEW LEARNING CENTER ENTRY DOORS, PLAN AND ELEVATION
2. SEE DRAWING SHEET A-3 FOR NEW LEARNING CENTER EXIT DOORS, PLAN & ELEVATION

LIBERTY ELEMENTARY FLOOR PLAN

L. CENTER CLASSROOM ENTRYS & PARTITIONS PROJECT
DUNELAND SCHOOL CORPORATION
CHESTERTON, INDIANA

gerometta & kinel architects, inc.

chesterton, indiana

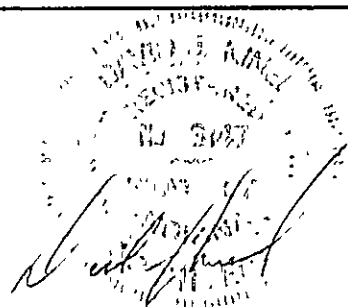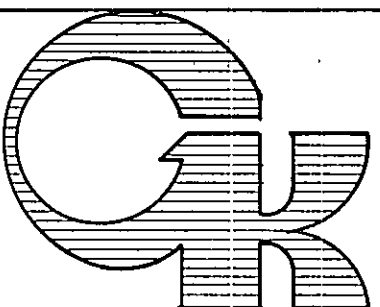

REVISIONS BY

DATE 4/22/91
SCALE As NOTED
DRAWN R.B.
JOB 9120
SHEET
A-2
OF 7 SHEETS