

SUMMER 1991 RENOVATION PROJECTS

DUNELAND SCHOOL CORPORATION

CHESTERTON, INDIANA

DUNELAND SCHOOL BOARD

JOHN W. KROFT	president	ROBERT G. MATTHYS	member
RAYMOND VAGELSKI JR.	vice pres.	MICHAEL J. TROUT	member
MICHAEL J. GRIFFIN	secretary		

DR. KENNETH L. PAYNE, SUPERINTENDENT

MICHAEL C. HARRIS, BOARD ATTORNEY

gerometta & kinel architects, inc.

chesteron, indiana

INDEX OF DRAWINGS

PROJECT TITLE SHEET

R-1 WMS REROOFING PLAN & NOTES

R-2 WMS REROOFING DETAILS

R-3 CHS REROOFING PLAN & NOTES

AE-1 CHS/YES ALUM. ENTRY REPLACEMENT PLANS & ELEVATIONS.

RI-1 RESTROOM IMPROVEMENT PLANS

(CHS, BABS, BRES, LES, LMS & YES)

PM-1 CHS PAINTING/MALICOVERING PLANS

PM-2 CHS PAINTING/MALICOVERING PLANS

PM-3 BABS PAINTING/MALICOVERING PLANS

PM-4 LES PAINTING/MALICOVERING PLANS

PC-1 FLOOR COVERING REPLACEMENT PLANS

(CHS, BRES, LES & YES)

CL-1 CHS/YES CEILING & LIGHTING PLANS

CL-2 SSC SITE LIGHTING; WMS CEILING & LIGHTING; ELECTRIC WATER COOLERS

SI-1 BABS/WMS SIDEWALK RENOVATION PLAN

SI-2 JES/YES SIDEWALK RENOVATION PLANS; CHS TENNIS COURT RESURFACING PLAN

SUMMER 1991 RENOVATION PROJECTS

DUNELAND SCHOOL CORPORATION

CHESTERTON, INDIANA

CONTRACT #1 REROOFING CONTRACT

CHS & WMS

CONTRACT #2 ALUM. ENTRY REPLACEMENT

CHS & YES

CONTRACT #3 RESTROOM & PLUMBING IMPROVEMENTS

CHS, BABS, BRES, LES, LMS & YES

CONTRACT #4 FLOOR COVERING REPLACEMENT

CHS, BRES, LES & YES

CONTRACT #5 PAINTING/MALICOVERING CONTRACT

CHS, BABS & LES

CONTRACT #6 CEILING, LIGHTING & ELECTRIC

CHS, WMS, YES & SSC

CONTRACT #7 DIGITAL SYSTEM CONTROL IMPROVEMENTS

JES

CONTRACT #8 SIDEWALK RENOVATIONS

BABS, JES, WMS & YES

CONTRACT #9 TENNIS COURT RESURFACING

CHS

CONTRACT #10 SIDEWALK RENOVATIONS

JES, WMS & YES

CONTRACT #11 SIDEWALK RENOVATIONS

JES, WMS & YES

CONTRACT #12 SIDEWALK RENOVATIONS

JES, WMS & YES

CONTRACT #13 SIDEWALK RENOVATIONS

JES, WMS & YES

CONTRACT #14 SIDEWALK RENOVATIONS

JES, WMS & YES

CONTRACT #15 SIDEWALK RENOVATIONS

JES, WMS & YES

CONTRACT #16 SIDEWALK RENOVATIONS

JES, WMS & YES

CONTRACT #17 SIDEWALK RENOVATIONS

JES, WMS & YES

SCHOOL ADDRESSES

BRUNNIT ELEMENTARY SCHOOL

2500 Indian Boundary Rd., Chesteron

CHESTERTON HIGH SCHOOL

651 W. Morgan Ave., Chesteron

YOST ELEMENTARY SCHOOL

100 W. Bean St., Porter

BAILY ELEMENTARY SCHOOL

800 S. Fifth St., Chesteron

WESTCHESTER MIDDLE SCHOOL

1050 S. Fifth St., Chesteron

LIBERTY MIDDLE SCHOOL

50 W. Co. Rd. 900 N., Chesteron

LIBERTY ELEMENTARY SCHOOL


50 W. Co. Rd. 900 N., Chesteron

SPECIAL SERVICE CENTER

1012 N. Old Re. 49, Chesteron

JACKSON ELEMENTARY SCHOOL

811 N. Co. Rd. 400 E., Valparaiso

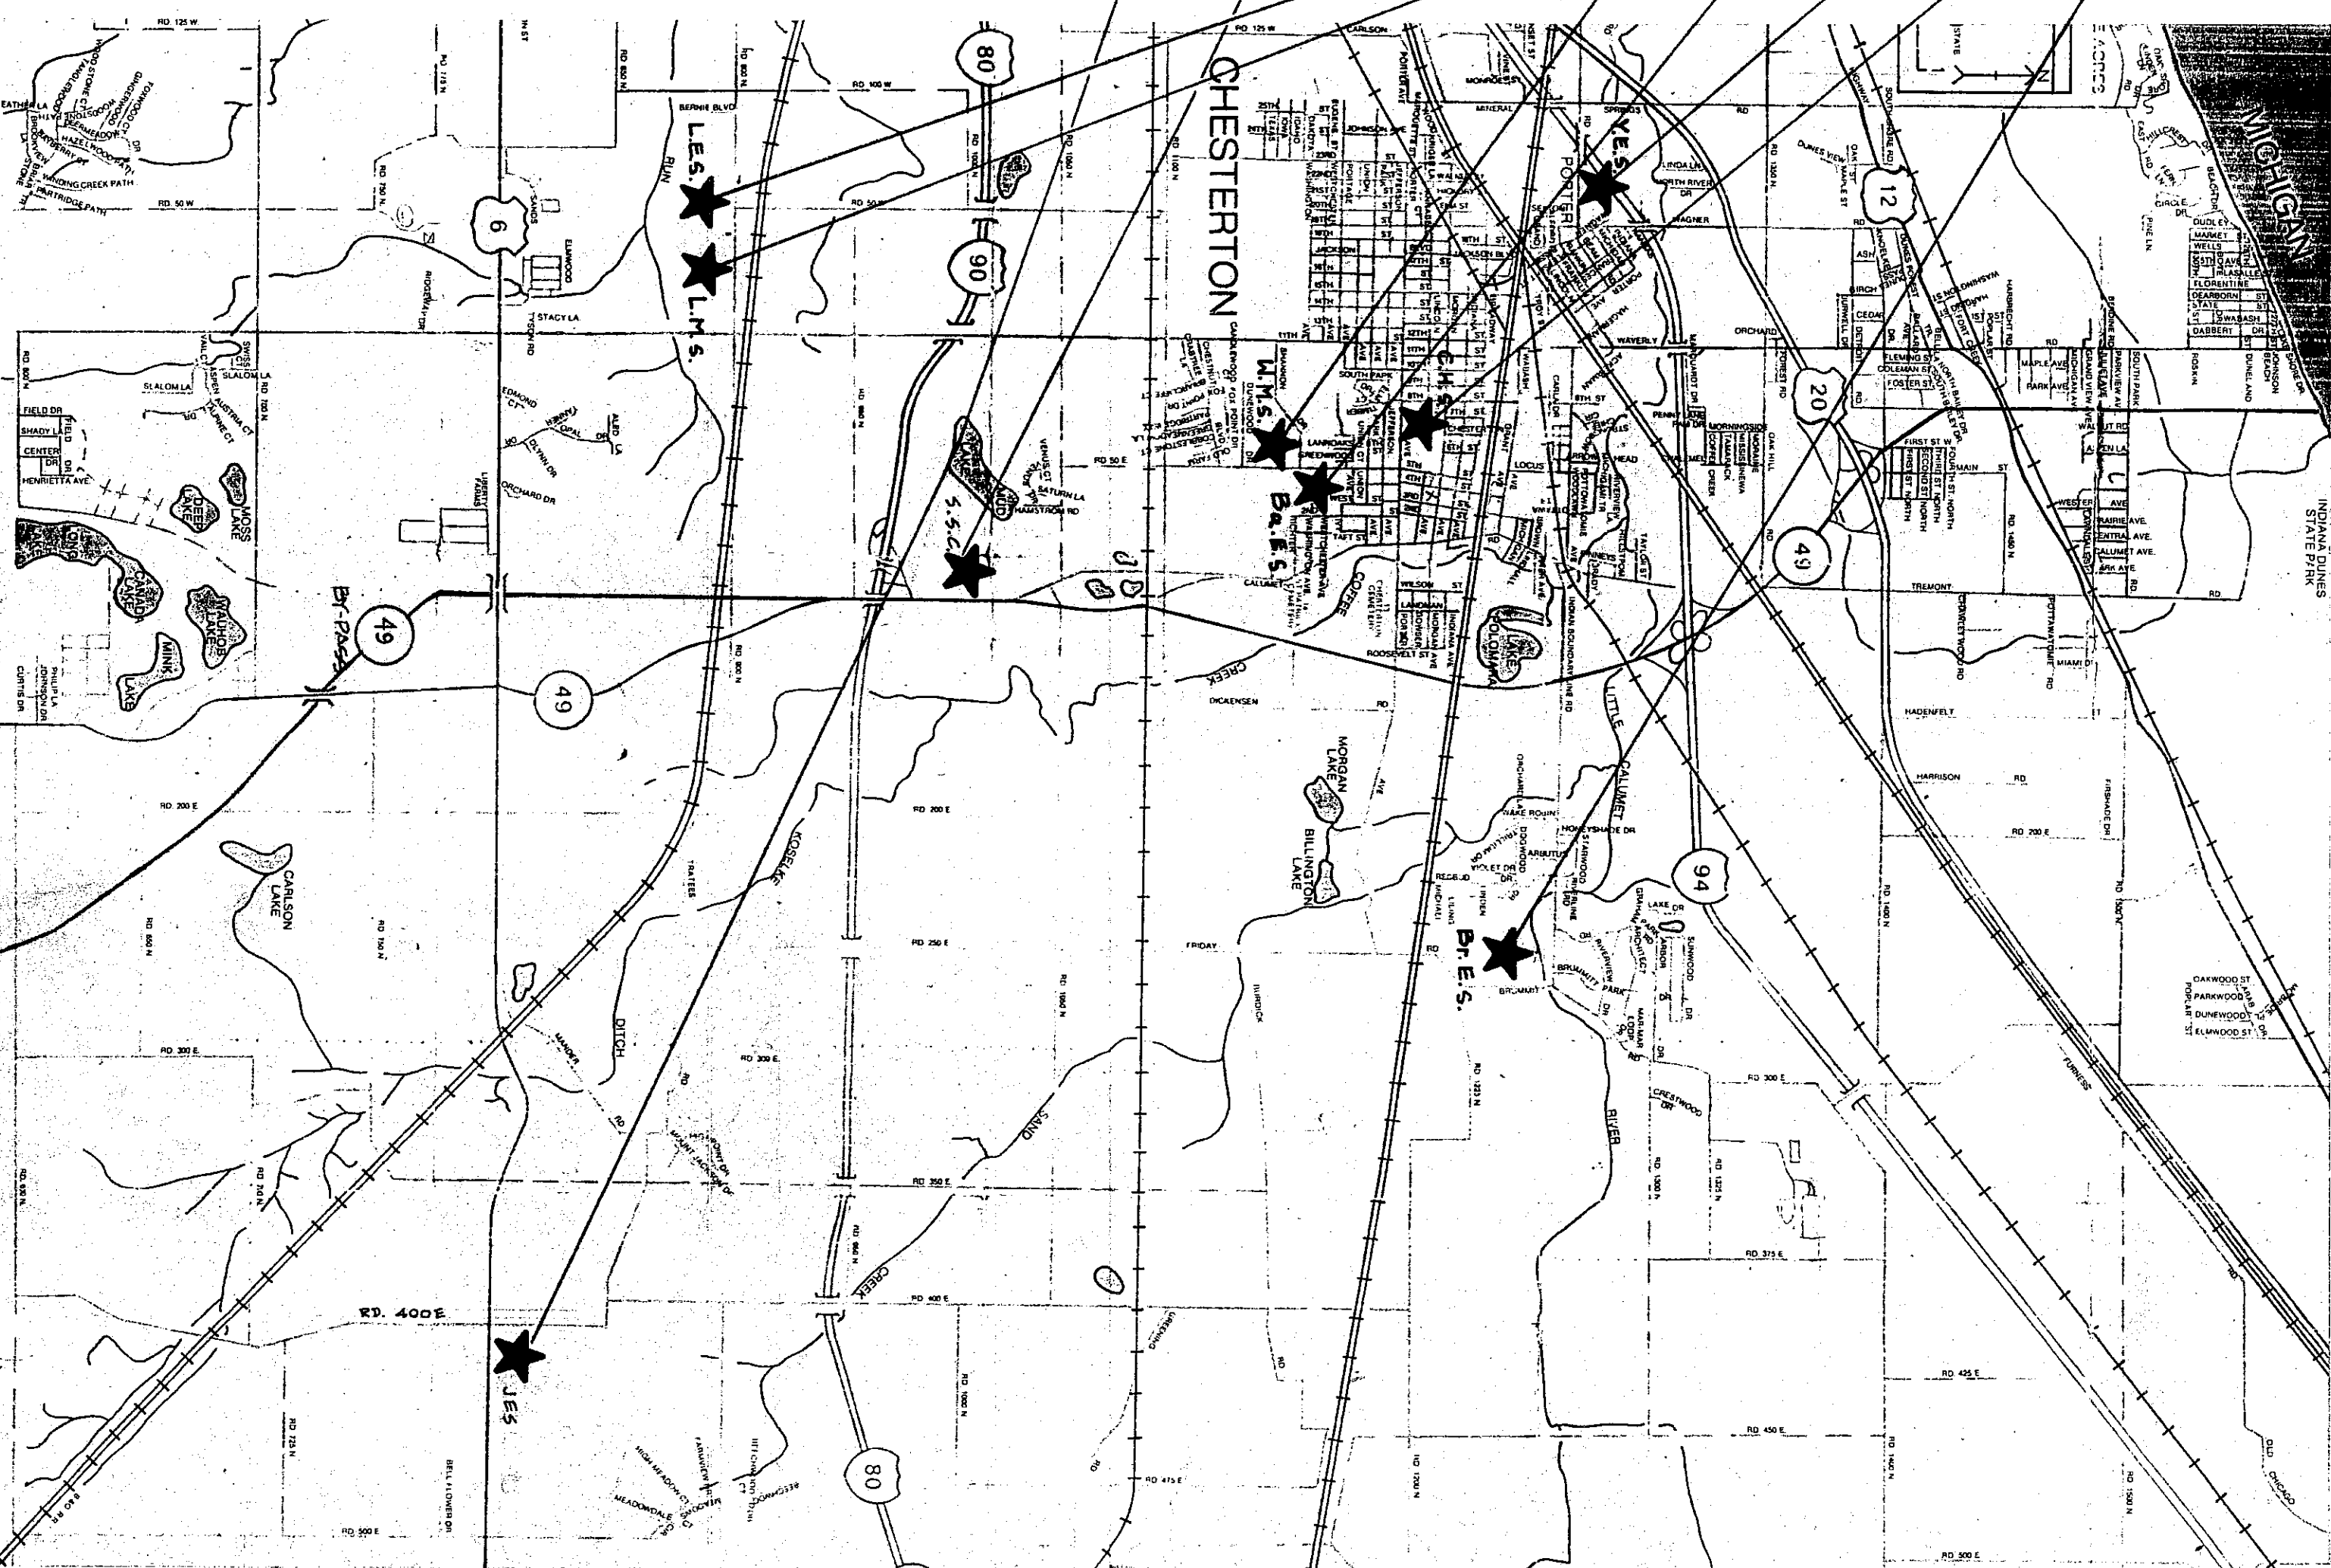

LOCATION MAP

NO SCALE

CHS: CHESTERON HIGH SCHOOL
WMS: WESTCHESTER MIDDLE SCHOOL
LES: LIBERTY ELEMENTARY SCHOOL
BABS: BAILY ELEMENTARY SCHOOL
JES: JACKSON ELEMENTARY SCHOOL
SSC: SPECIAL SERVICE CENTER


SET #8

TITLE SHEET

SUMMER 1991 DUNELAND RENOVATION PROJECTS

DUNELAND SCHOOL CORPORATION

gerometta & kinel architects, inc.

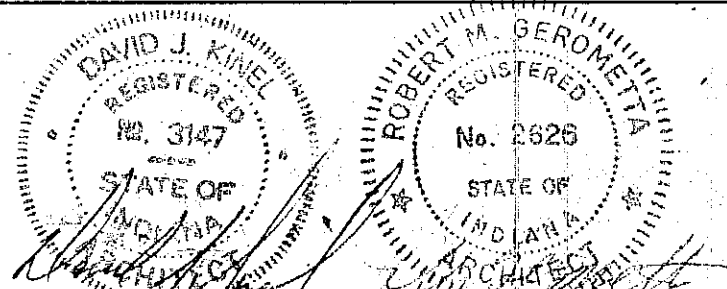

REVISIONS	BY

DATE 2/5/91

SCALE AS NOTED

DRAWN TLA:EB

CHECKED 9/107

SHEET 1

TITLE

OF 15 SHEETS