



REVISIONS	BY

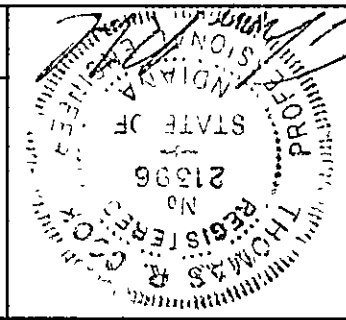

Handwritten signature

LIBERTY MIDDLE SCHOOL - F.A. DEMOLITION PLAN
FALL 1994
DUNELAND SCHOOL CORPORATION
chesteron, Indiana
gerometta & kinel architects, inc.


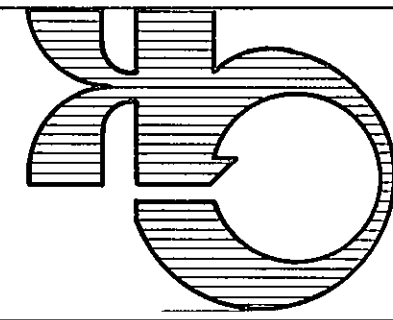


Date	11-1-94
Scale	AS SHOWN
Drawn	KSK
Job	9420
Sheet	FA-2
Of	7 Sheets


M/E DESIGN SERVICES
MECHANICAL ENGINEERING
113 1/2 Liberty Ave.
Chesterton, Indiana 46304
(219) 226-1111

94-FA-02


KEY PLAN
NO SCALE

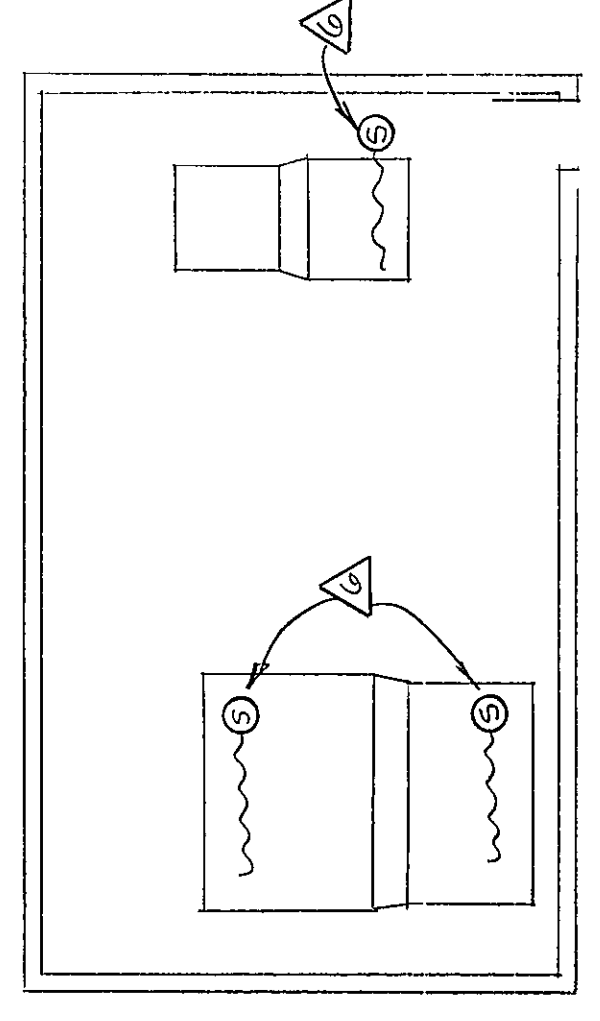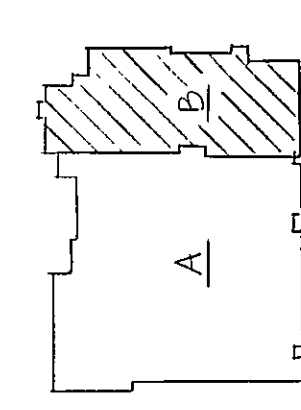


FAN RM. D-201 DEMOLITION PLAN
1/8"=1'-0"

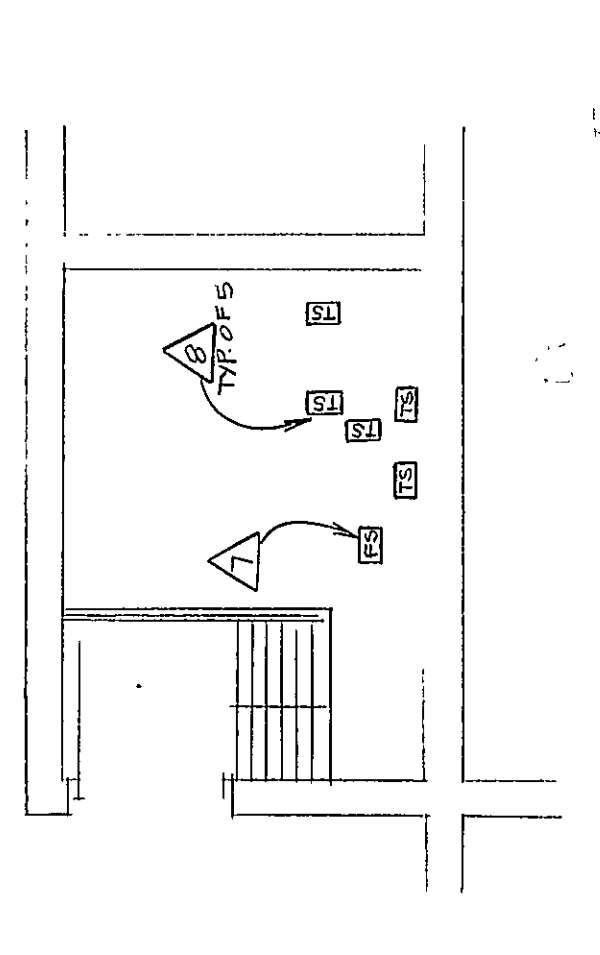


ENLARGED PUMP RM. E-III
DEMOLITION PLAN
1/8"=1'-0"

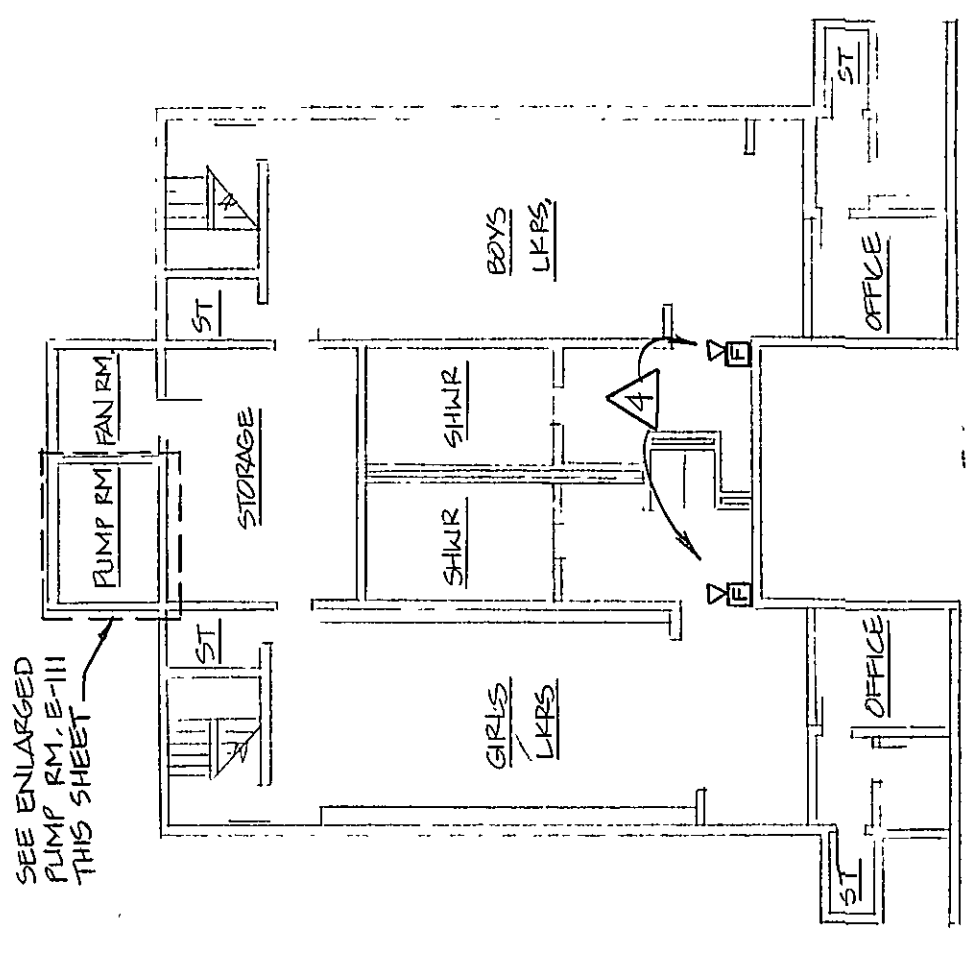

BASEMENT DEMOLITION PLAN
1/16"=1'-0"

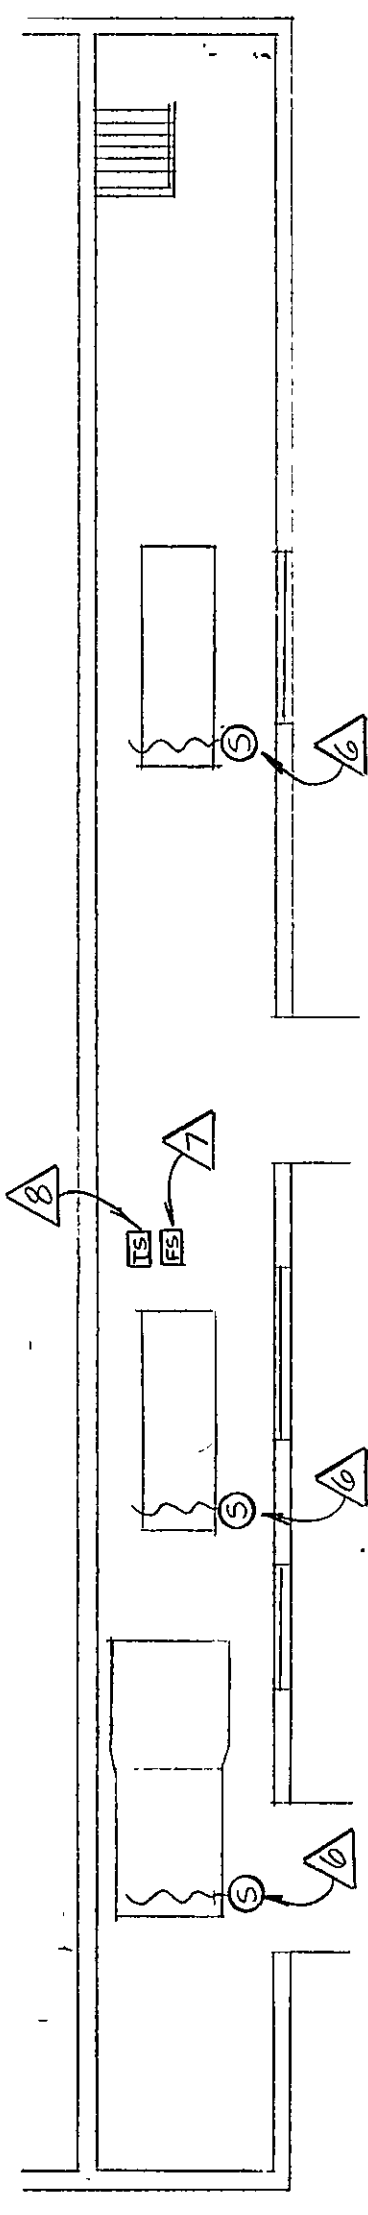

MECHANICAL RM. E-201 DEMOLITION PLAN
1/8"=1'-0"

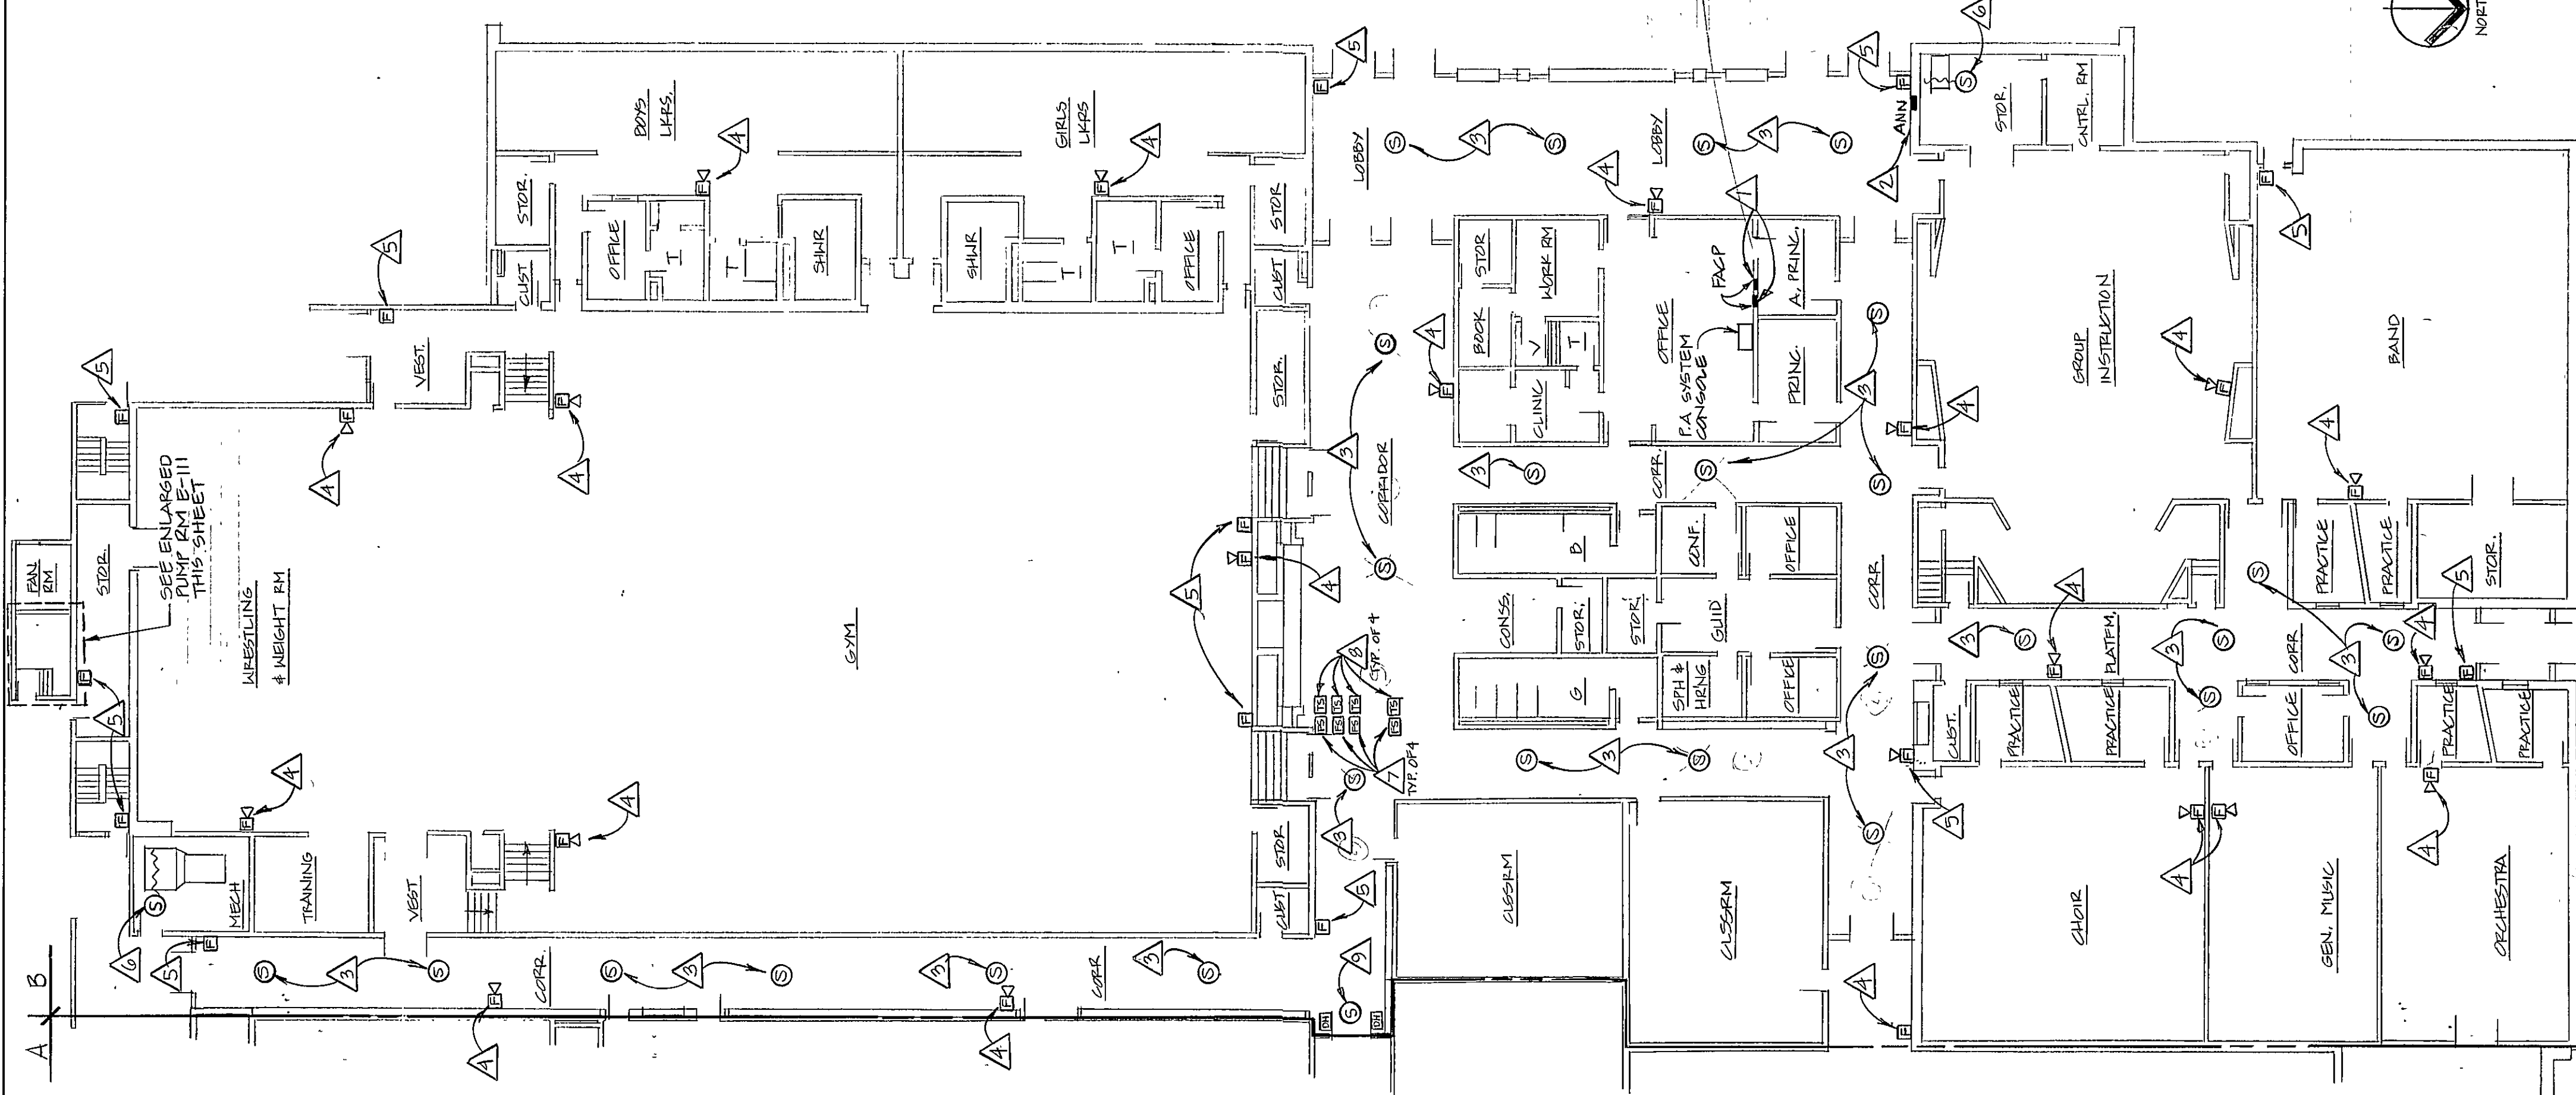

FIRE ALARM SYSTEM DEMOLITION
PLAN - LIBERTY MIDDLE SCHOOL
1/16"=1'-0" (SECTION-B)

