


LIGHTING SCHEDULE					
SYMBOL	LAMPS		DESCRIPTION	MOUNTING	MANUFACTURE
	NO.	TYPE			
	2	F40 CW	1'x4' SPECIFICATION GRADE TROFFER, STEEL HOUSING, GASKETED ALUMINUM DOOR, 1/25 ACRYLIC PRISMATIC LENS	LAY-IN CEILING	LITHONIA #SP6240 FW A12.125 120 ES ABC OR EQUAL
	2	F40 CW	1'x4' "WRAPAROUND" TYPE FIXTURE, STEEL HOUSING, ACRYLIC LENS	SURFACE MOUNTED	LITHONIA #SB240 A 120 ES OR EQUAL
	2	F20 CW	2'x2' WALL MOUNTED MIRROR LIGHT, STEEL HOUSING, END PLATES, ACRYLIC LENS	WALL MOUNTED	LITHONIA #W220 120 ES OR EQUAL
	1	70W HPS	EXTERIOR WALL PACK, PRISMATIC LENS, MEDIUM BRONZE FINISH	WALL MOUNTED	LITHONIA #TWP70S120RHPDMB OR EQUAL
	2	BY MFR.	2 HEAD EMERGENCY LIGHT, WHITE THERMOPLASTIC HOUSING, MAINT. FREE LEAD CALCIUM BATTERY + = WIREGUARD	WALL MOUNTED	LITHONIA #ELM120-120 OR EQUAL
	-	LED BY MFR.	EXIT LIGHT WITH GREEN LETTERS ON BRUSHED ALUMINUM HOUSING, ACRYLIC LENS, # OF FACES & ARROWS AS INDICATED ON DRAWINGS	WALL MOUNTED	LITHONIA #W220 120 ES OR EQUAL

ELECTRICAL LEGEND

C	CONDUIT		NO FUSE DISCONNECT SWITCH. NUMBER INDICATES SIZE.
C.B.	CIRCUIT BREAKER		CONTROL FURNISHED BY OTHERS.
COMB.	COMBINATION		JUNCTION BOX
DISC.	DISCONNECT		PANELBOARD
E.C.	ELECTRICAL CONTRACTOR/TRADE		SPEAKER - CLG. MOUNTED RECESSED
L.T.G.	LIGHTING		"A", "B", "C" = LIGHT FIXTURE TYPE FROM SCHEDULE B1 = PANEL AND CIRCUIT NUMBER e = SWITCH CONTROL
M.F.C.R.	MANUFACTURER		WIRE AND CONDUIT SIZE OTHER THAN MINIMUM SPECIFIED. CONDUIT SIZE
M.C.	MECHANICAL CONTRACTOR/TRADE		WIRE SIZE
R.C.P.T.	RECEPTACLE		NUMBER OF WIRES
SW.	SWITCH		CONDUIT AND WIRE CONCEALED IN CEILING OR WALL
W.P.	WEATHERPROOF		HOME RUN TO PANELBOARD: A1.3 = PANELBOARD A, CIRCUITS 1 AND 3, THREE CROSS LINES = 3 WIRES. UNLESS OTHERWISE NOTED, THE CONDUIT AND WIRE SIZES ARE THE MINIMUM AS REQUIRED BY THE SPECIFICATIONS. LONG CROSS LINE = NEUTRAL.
S	SINGLE POLE SWITCH		
S ³	THREE-WAY SWITCH		
	DUPLEX RECEPTACLE		
	"WP" AT ANY RECEPTACLE SYMBOL INDICATES IT IS A WEATHERPROOF DEVICE.		
	RECEPTACLE MOUNTING HEIGHT = 1'-0" UNLESS NOTED. "2" AT ANY RECEPTACLE SYMBOL = 44" MOUNTING HEIGHT.		
	RECEPTACLE WITH INTEGRAL GROUND FAULT INTERRUPTER		
	FIRE ALARM AUDIO/VISUAL ALARM UNIT		
	FIRE ALARM PULL STATION(MANUAL)		
	SMOKE/HEAT DETECTOR		
	DUCT SMOKE DETECTOR		
	TELEPHONE OUTLET		
	MOTOR LOCATION.		

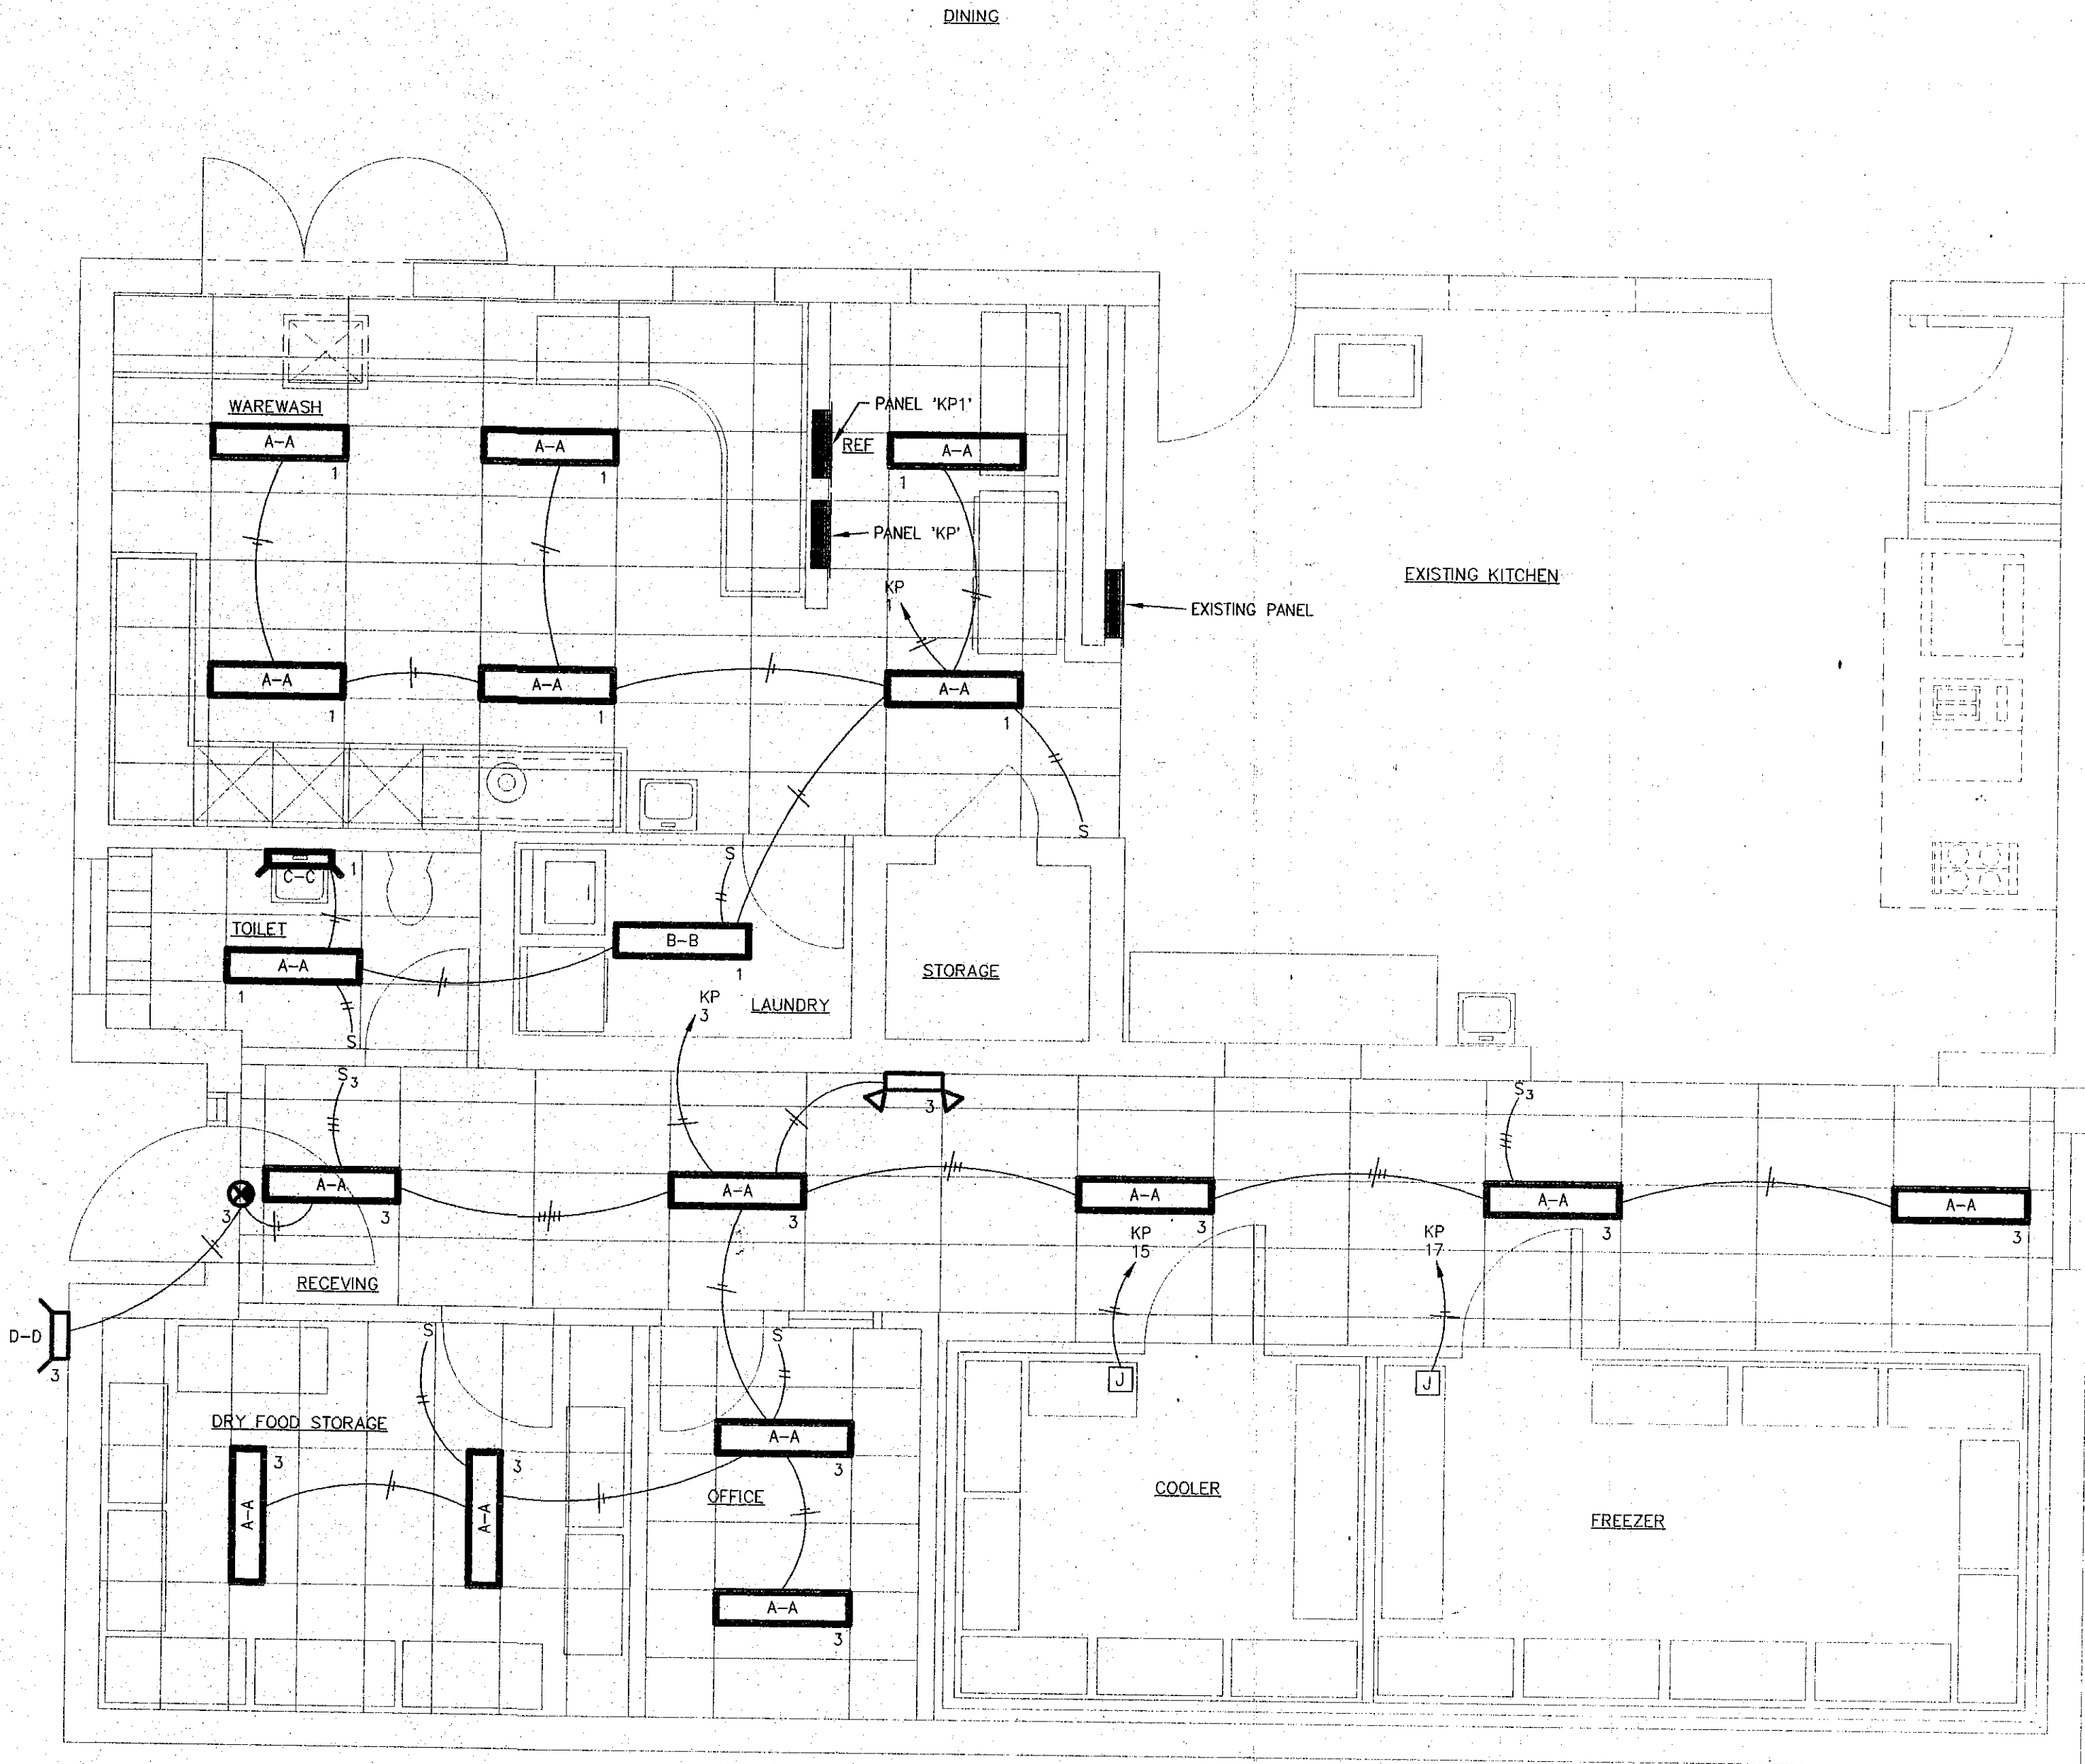


KITCHEN LIGHTING PLAN

SCALE: 1/4" = 1'-0"



REVISIONS	BY

LIGHTING PLAN
YOST ELEM. SCHOOL KITCHEN ADDITION
DUNELAND SCHOOL CORP.
gerometta & kinel architects, inc.
chesterton, indiana

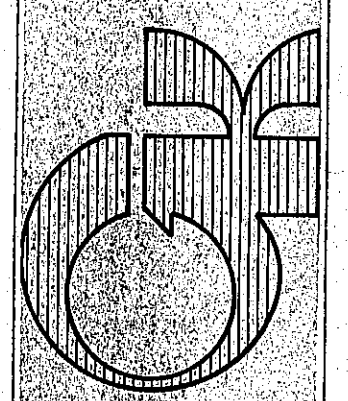

Date	6-14-95
Scale	AS SHOWN
Drawn	JUB
Job	9519
Sheet	E-11
Of	9
Sheets	

M/E DESIGN SERVICES
MECHANICAL/ELECTRICAL CONSULTING ENGINEERS
112 1/2 Lincolnway East
Mishawaka, Indiana 46544
(219) 256-1914