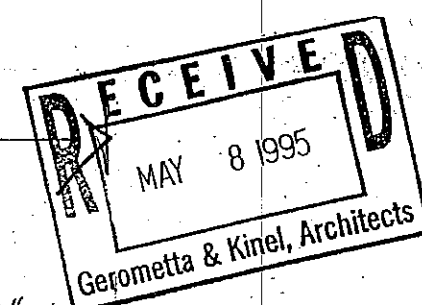


POWER PLAN
YOST ELEM. SCHOOL
DUNELAND SCHOOL CORP.
gerometta & kinel architects, inc.

10


[illegible]

☒ NO EXCEPTIONS TAKEN
☐ MAKE CORRECTIONS NOTED
(NO RESUBMISSION REQ'D)
☐ AMEND AND RESUBMIT
☐ REJECTED - RESUBMIT
☒ OTHER

SUBJECT TO ALL REQUIREMENTS
OF PLANS, SPECIFICATIONS AND
CONTRACT. CONTRACTOR SHALL VERIFY
ALL DIMENSIONS, QUANTITIES AND
FIELD CONDITIONS AS REQUIRED FOR
THE PROPER AND COMPLETE INSTALLATION
OF THIS WORK.

BY YMB
5/12 1995

JUL 19 1995

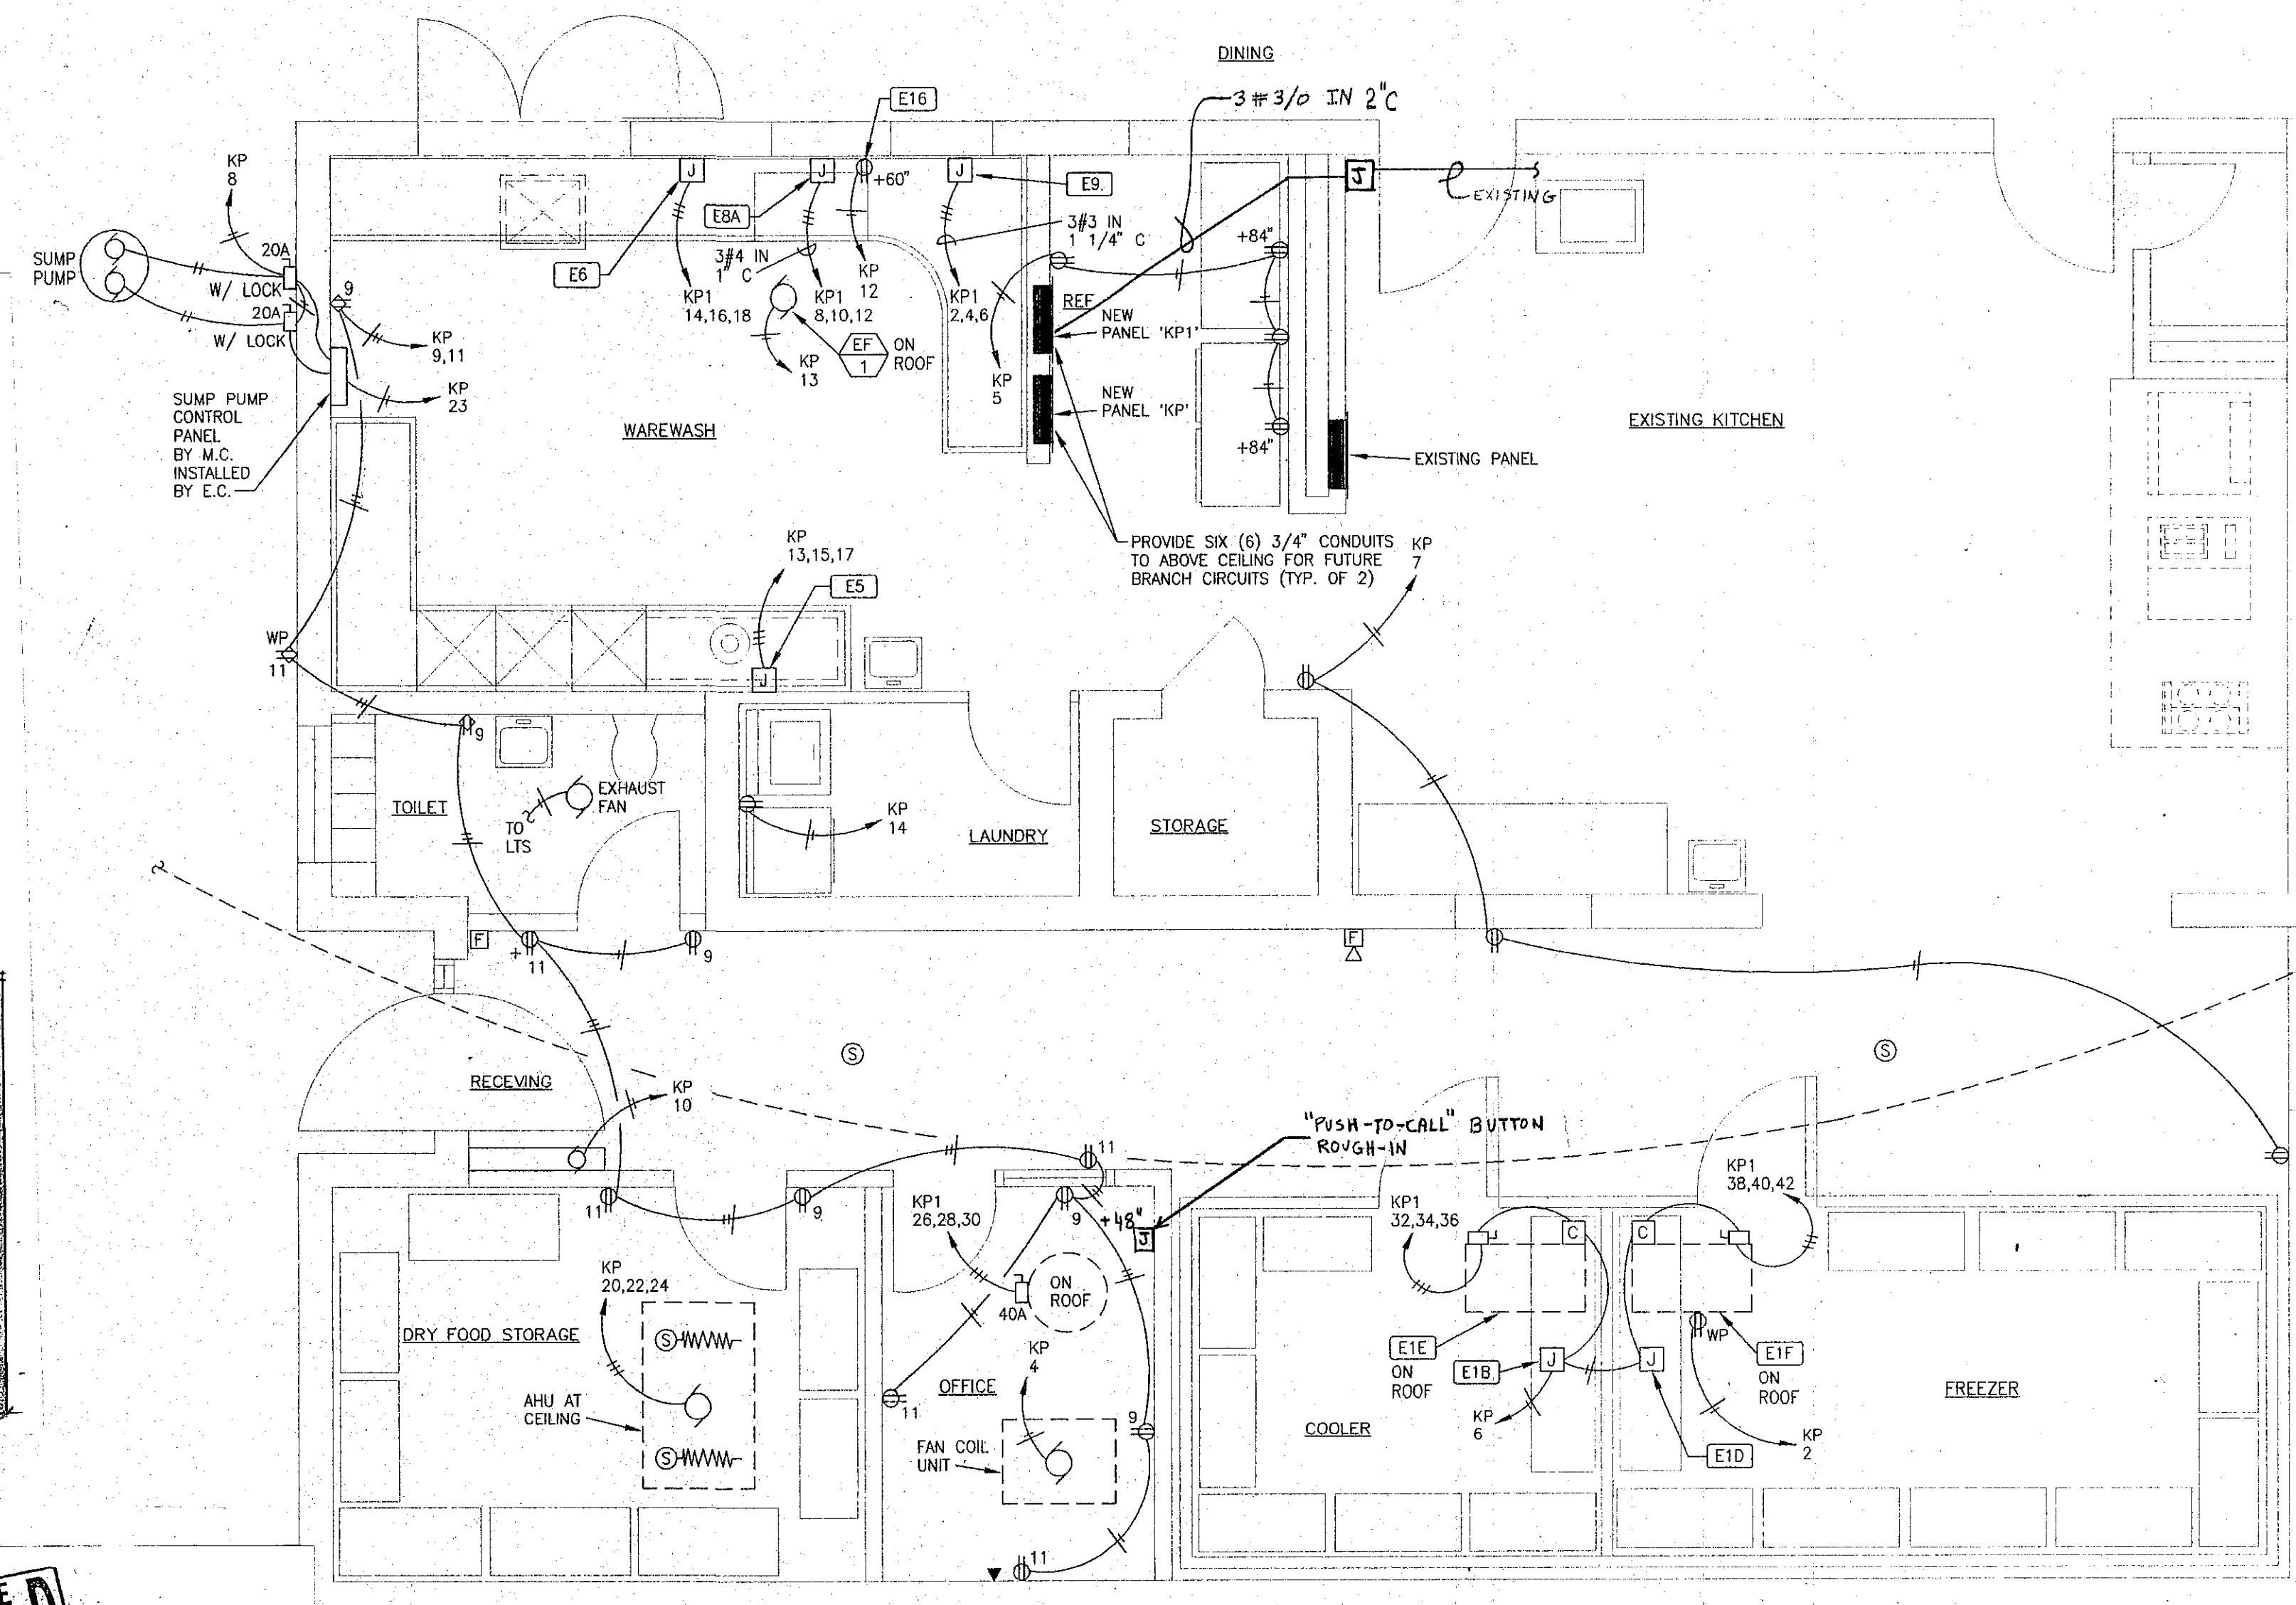

NOTES:

1. E.C. TO PROVIDE SLEEVES THROUGH FOUNDATION WALL AS REQUIRED FOR EXISTING ELECTRICAL FEED. (TYPICAL OF 4) SLEEVES TO BE SIZED AS REQUIRED.
2. E.C. TO ENCASE EXISTING ELECTRICAL FEED IN 12" x 12" CONCRETE. BELOW NEW SLAB.

KITCHEN POWER PLAN

SCALE: 1/4" = 1'-0"

- KITCHEN EQUIP DRAWINGS
IN SPEC SECTION 11400



M/E DESIGN SERVICES
MECHANICAL/ELECTRICAL CONSULTING ENGINEERS
112 1/2 Lincolnway East
Mishawaka, Indiana 46544
(219) 256-1914