


Chesterton High School

Section A8

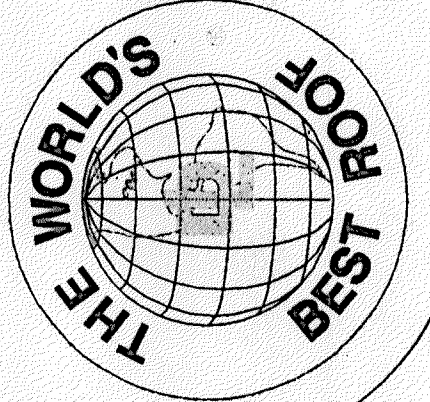

DURO-LAST, INC.
525 MORLEY DRIVE
SAGINAW, MICHIGAN 48601


CHESTERTON HIGH SCHOOL
SECTION A8
WR KELSO

DWG NAME: CHESTERTON
DRAWN BY: KNOX
REV. BY:



SCALE: not to scale
DATE: 9/23/97
REV.:

LEGEND
FACTORY WELD
FIELD WELD

97-2-4

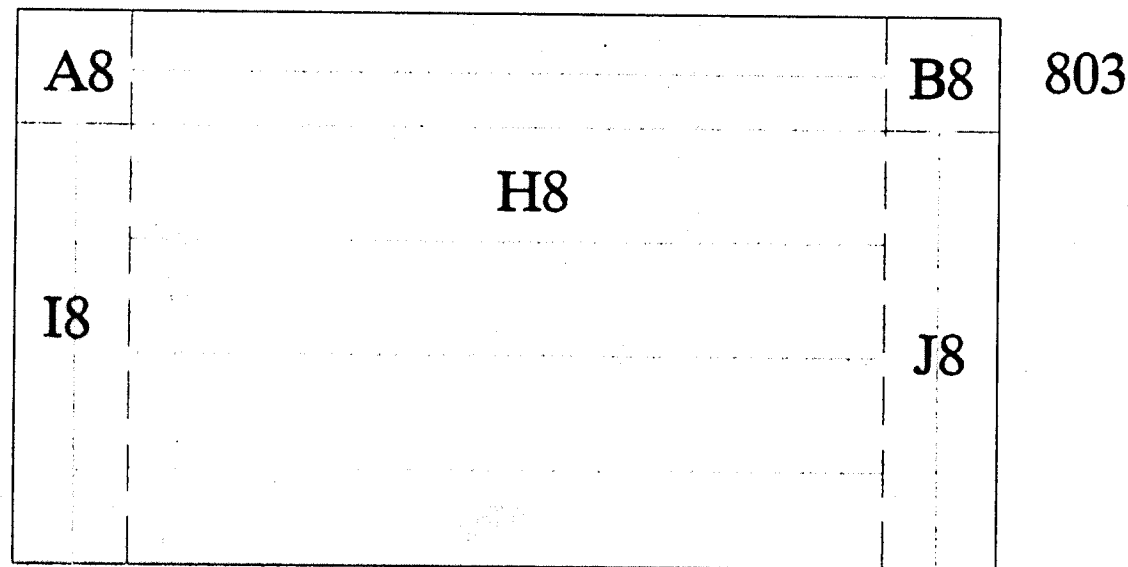

804

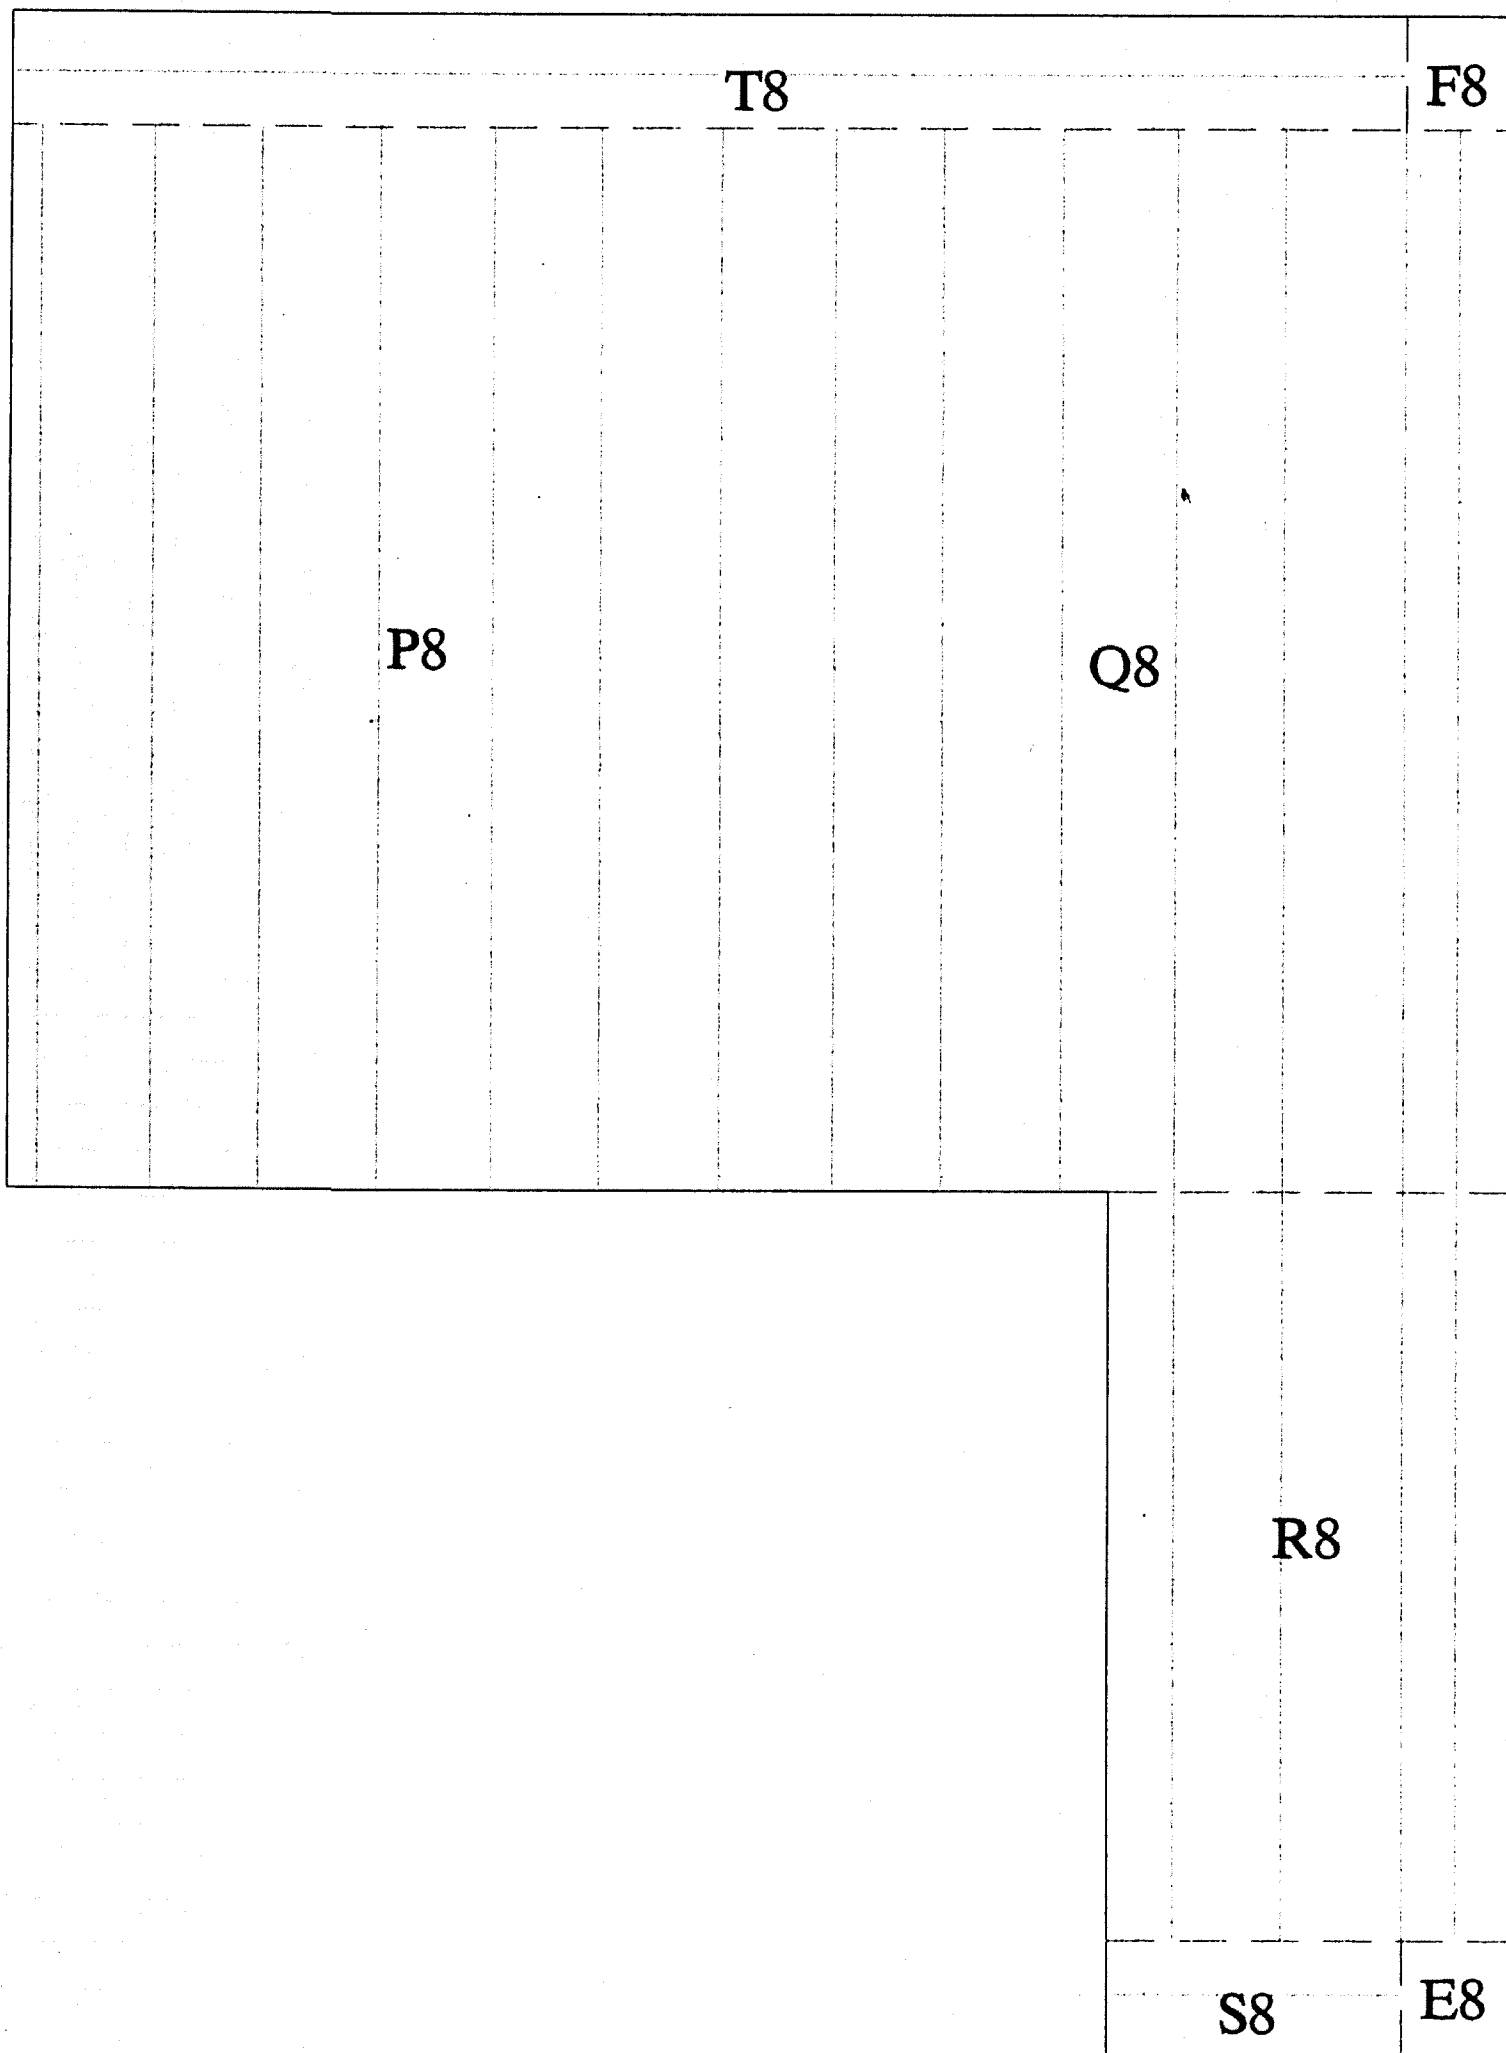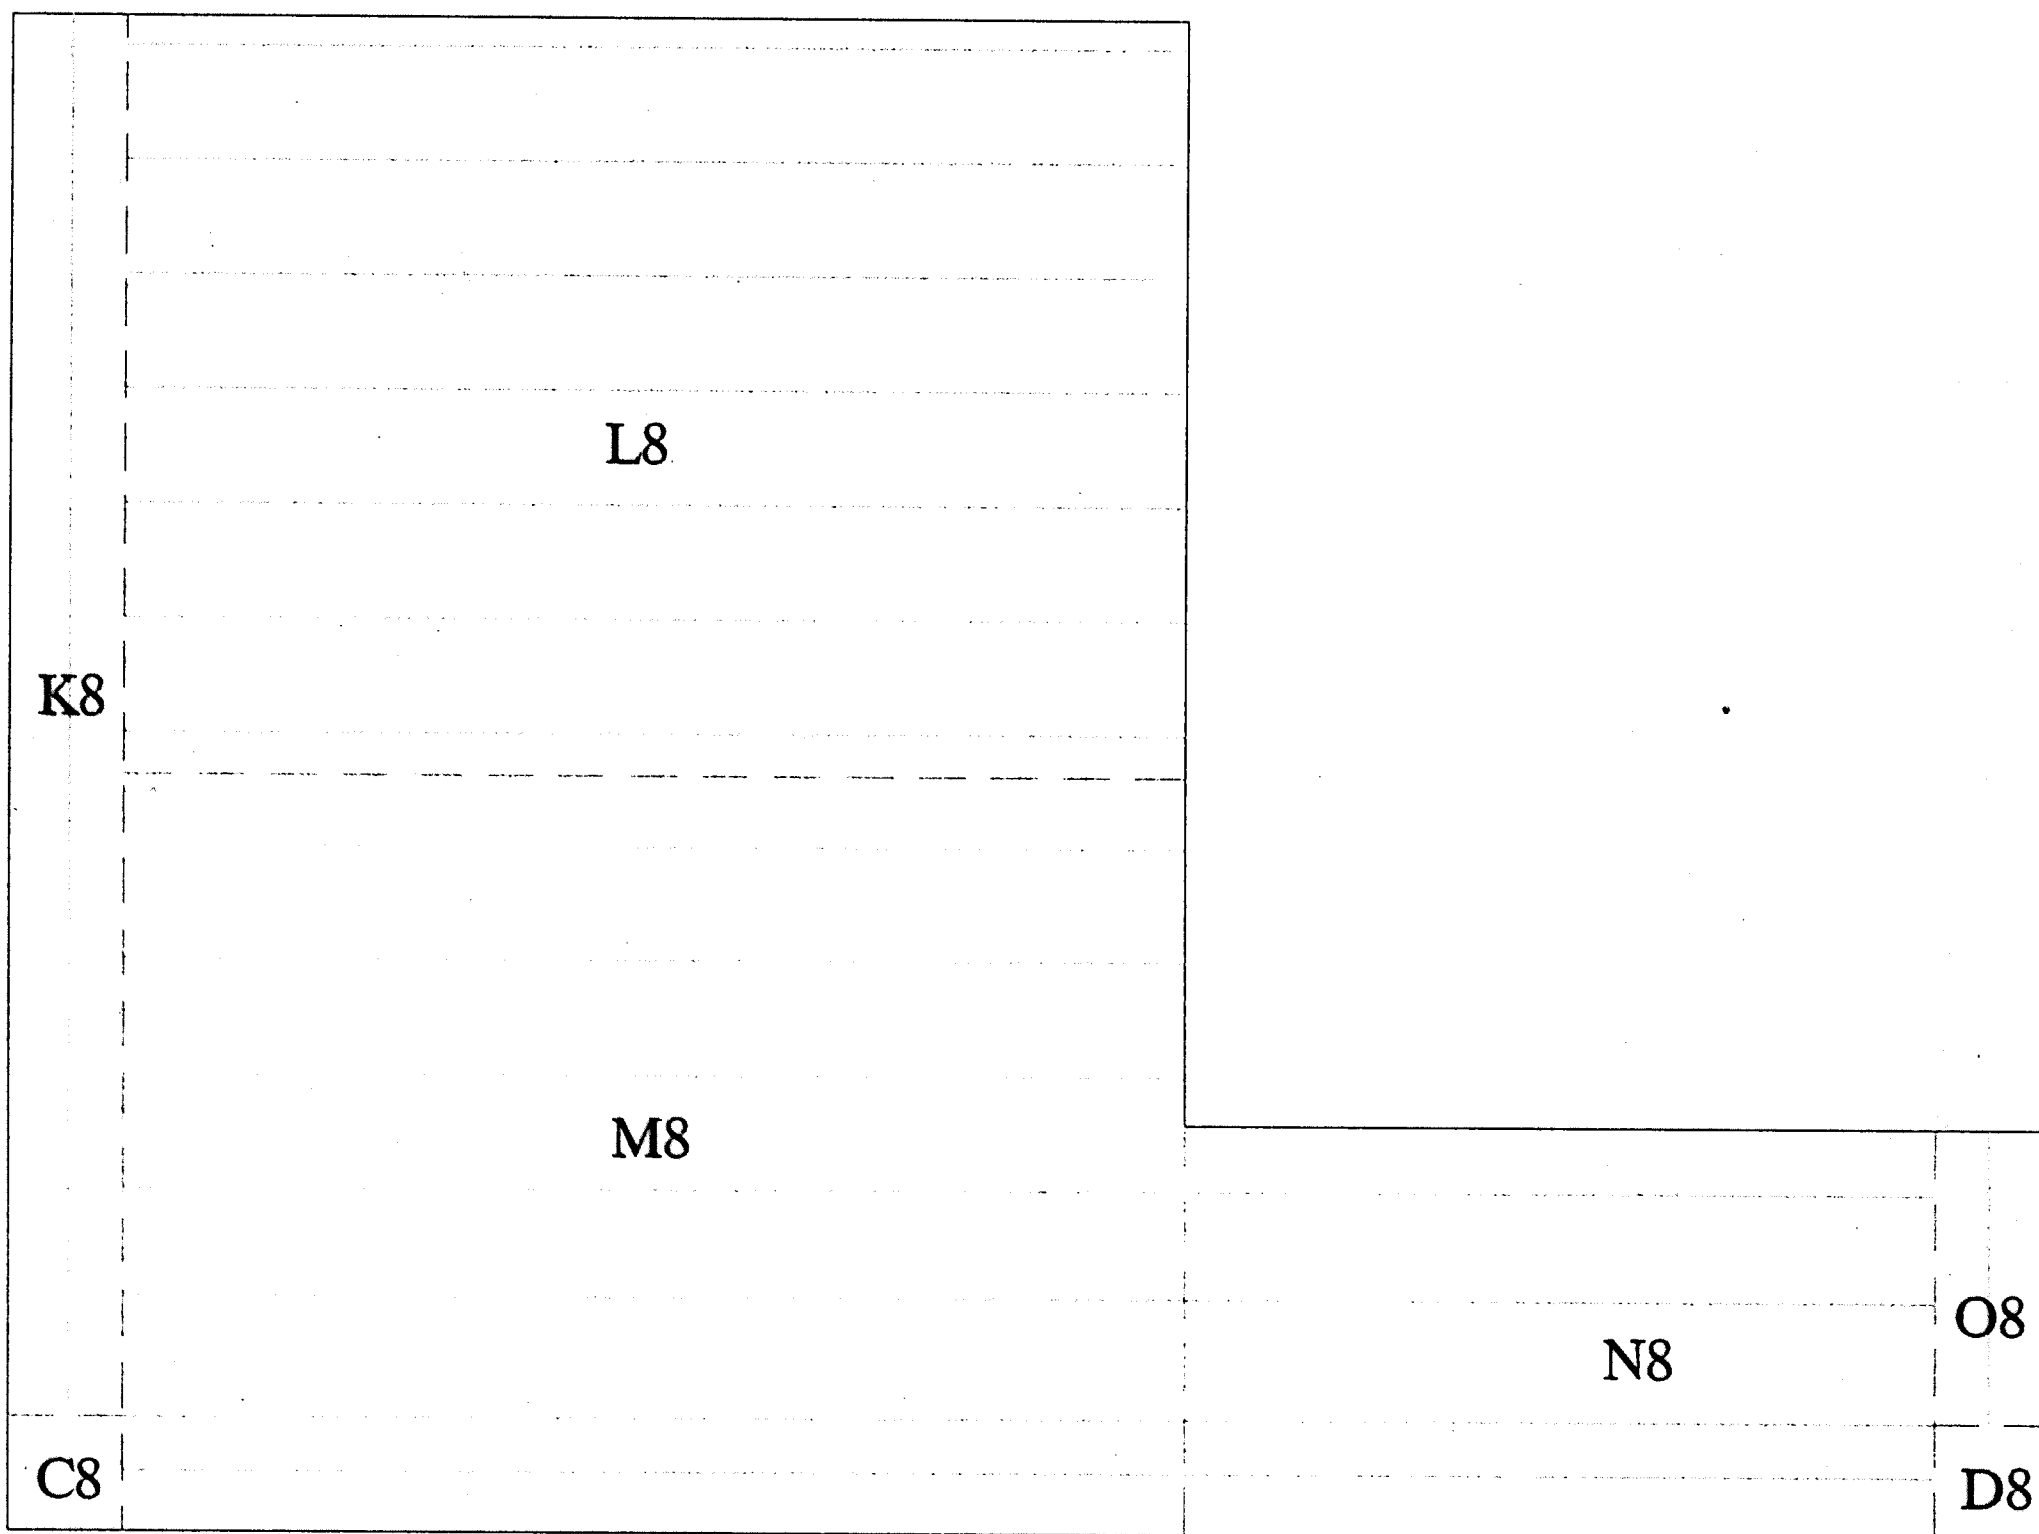


ROOF DECK PANEL SCHEDULE


PC	STD/ ROLLS	27" TAB SHTS	WIDTH (FEET)	LGTH (FEET)	TAB	NOTES
A8	-	X	4.5	4.5	4.5	24"REV/21" TABS
B8	-	X	4.5	4.5	4.5	24"REV/21" TABS
C8	-	X	4.5	4.5	4.5	24"REV/21" TABS
D8	-	X	4.5	4.5	4.5	24"REV/21" TABS
E8	-	X	4.5	4.5	4.5	24"REV/21" TABS
F8	-	X	4.5	4.5	4.5	24"REV/21" TABS
G8	-	-	13	50	50	30"REV
H8	-	-	24	33	33	30.57"REV FB
I8	-	X	4.5	19	19	30"REV
J8	-	X	4.5	19	19	30"REV
K8	-	X	4.5	59	59	30"REV
L8	-	-	31	45	45	30"REV
M8	-	-	31.5	45	45	30.57"REV FB
N8	-	-	17	32	32	30.57"REV FB
O8	-	X	4.5	13	13	30"REV
P8	-	-	31	45	45	30"REV
Q8	-	-	31.5	45	45	30.57"REV FB
R8	-	-	17	32	32	30.57"REV FB
S8	-	X	4.5	13	13	30"REV
T8	-	-	1	125	NO	ROLLED GOODS

SHOP DRAWING/SUBMITTAL REVIEW STATUS		✓	CHECKED AND FORWARDED TO A/E
ARCHITECT'S DETERMINATION	RESPONSE REQUIRED		REVISE AND RESUBMIT
No Exceptions Taken ☒ Rejected ☐	Confirm ☐		INSUFFICIENT INFORMATION
Note Markings ☒ Comments Attached ☒	Resubmit ☐		
Architect's review is only for checking conformance with the information given, and with the design and construction details shown in the Contract Documents. Contractor is responsible for dimensions to be confirmed on the job site for fabrication and erection. The Contractor shall not release the Contractor from compliance with the Contract Documents for any discrepancies. The Contractor remains responsible for details and accuracy of quantities and dimensions, and dimensions, for selecting fabrication processes or methods of assembly, for performing his work in a safe manner, and for coordinating his work with other trades.			
ARCHITECT/ENGINEER		DATE	12/2/97
By: JEC		CC: CONSTRUCTION CONTROL	
FORT WAYNE, INDIANA			

802

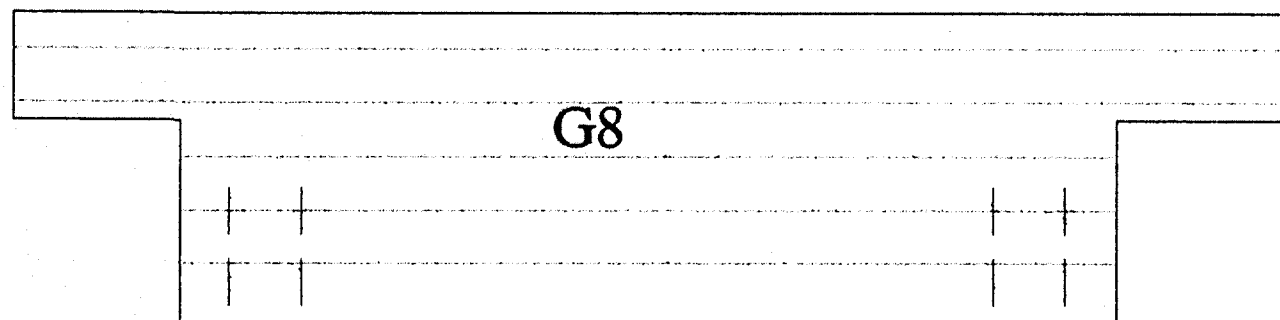

801

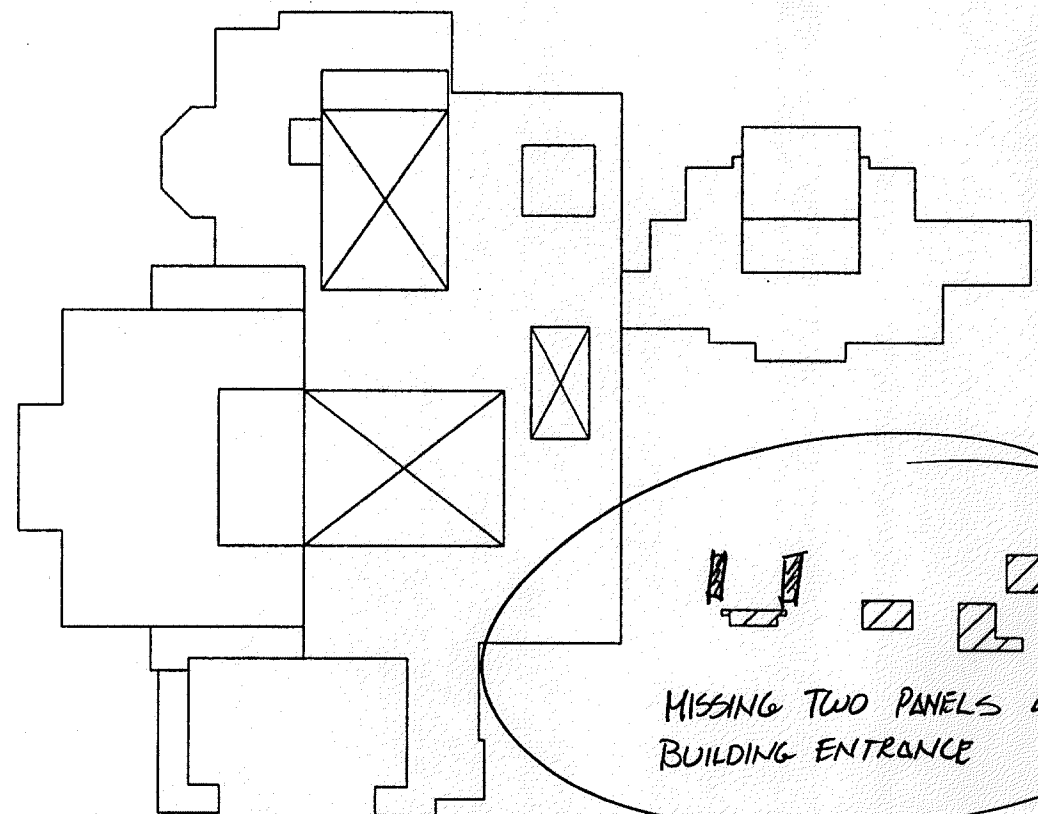

MISSING TWO PANELS AT BUILDING ENTRANCE