


Chesterton High School

Section A7

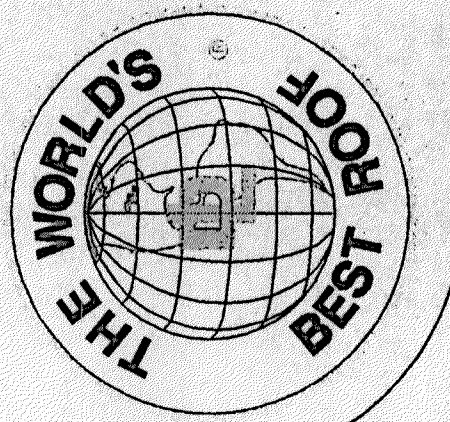

DURO-LAST, INC.
525 MORLEY DRIVE
SAGINAW, MICHIGAN 48601


CHESTERTON HIGH SCHOOL
SECTION A7
W.R. KELSO

DWG NAME: chesterton
DRAWN BY: KNOX
REV. BY:

SCALE: 1/8" = 1'-0"
DATE: 9/19/97
REV.:

LEGEND
FACTORY WELD
FIELD WELD

97-8-03

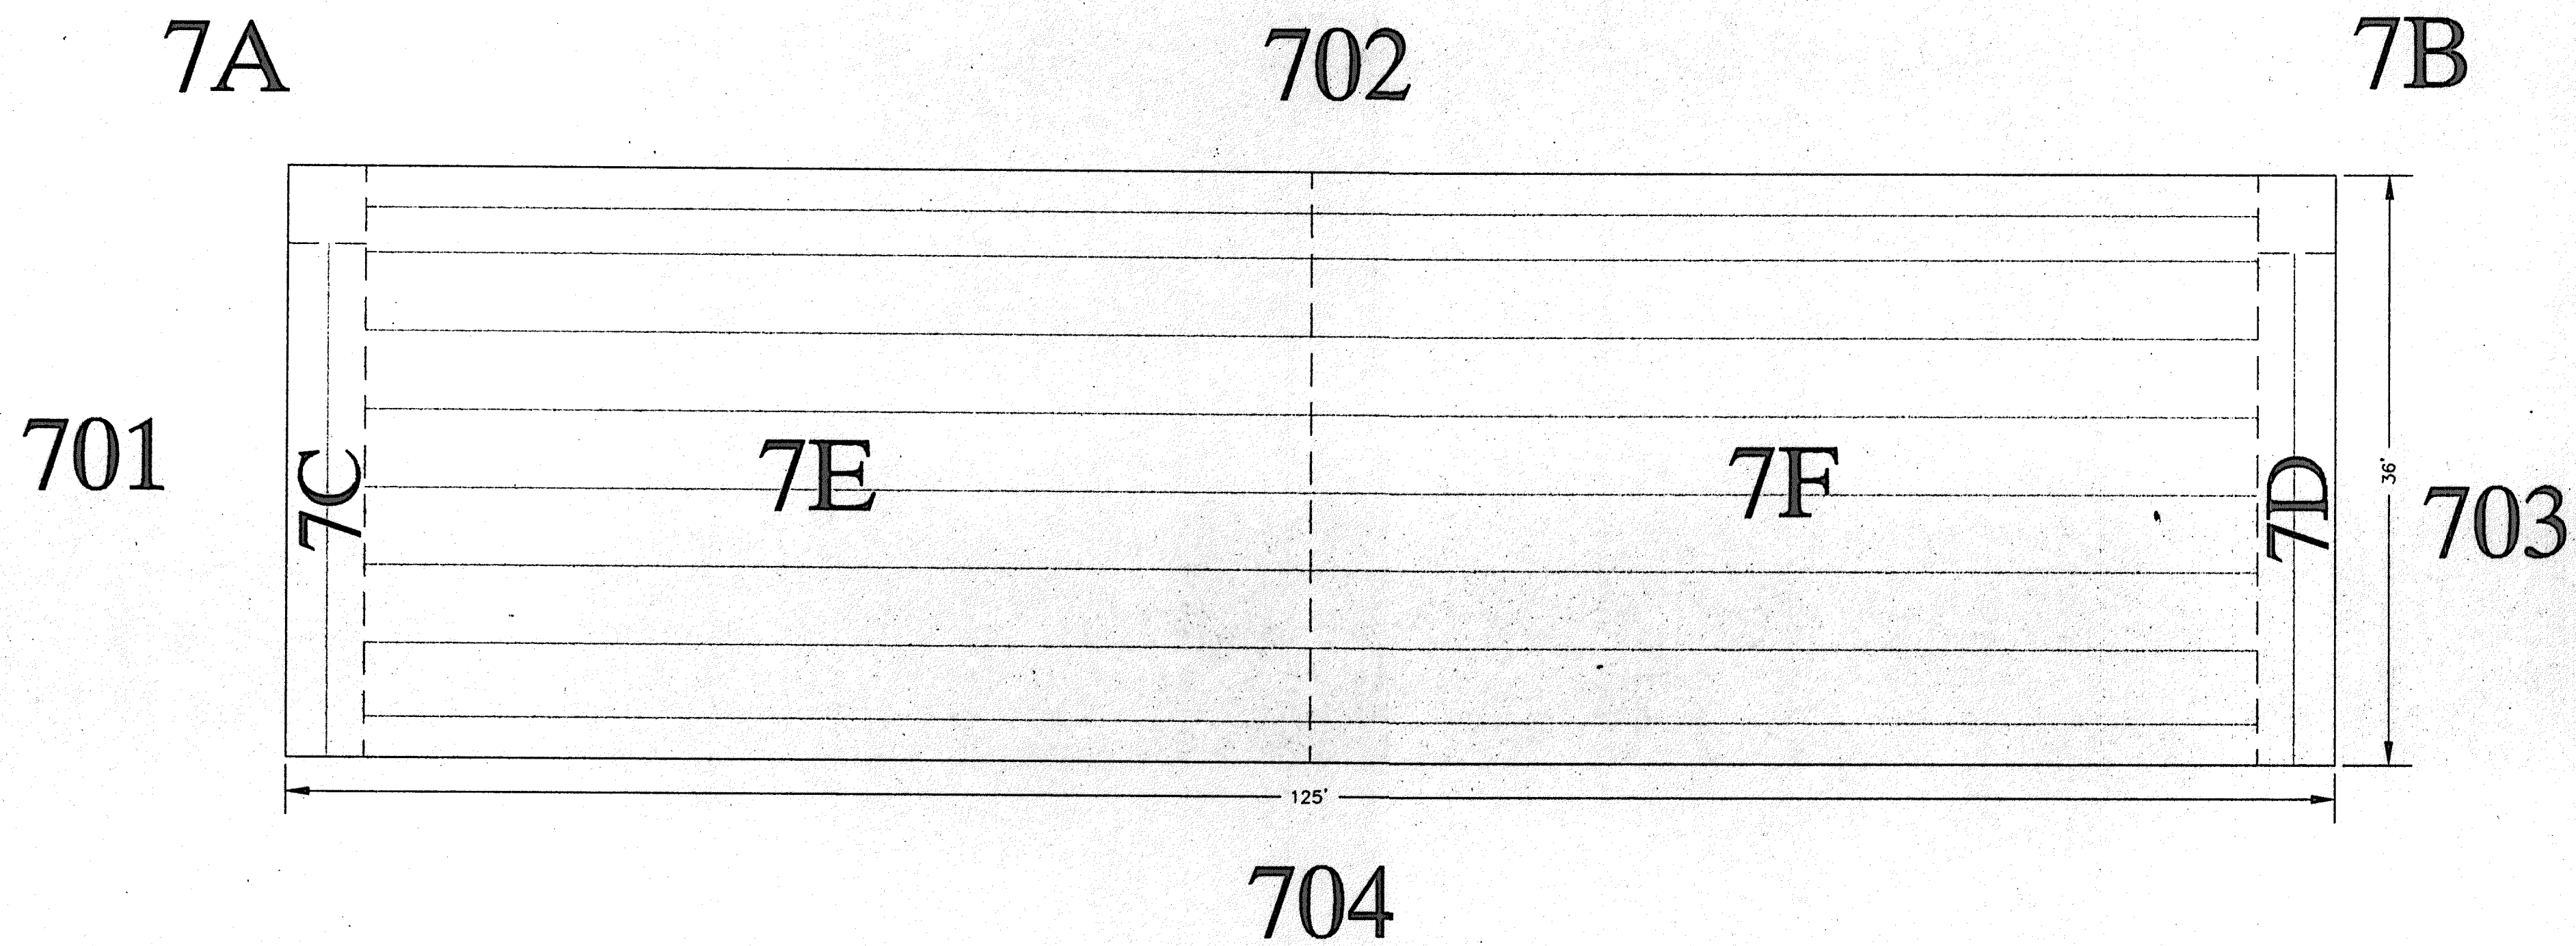

ROOF DECK PANEL SCHEDULE

PC	STD/ ROLLS	27"TAB SHTS	WIDTH (FEET)	LGTH (FEET)	TAB	NOTES
A7	-		4.5	4.5	4.5	24"REV21"TEBS
B7	-		4.5	4.5	4.5	24"REV21"TEBS
C7	-		4.5	32	32	30"REV
D7	-		4.5	32	32	30"REV
E7	X		35.5	56.5	56.5	30,57"REV
F7	X		35.5	56.5	56.5	30,57"REV

☒ CHECKED AND FORWARDED TO A/E
☐ REVIEW AND RESUBMIT
☐ INSUFFICIENT INFORMATION
Checking is only for performance and compliance with the
information given in the Contract Documents. Contractor is
responsible for dimensions in his drawings. It is not to be
used as a basis for information. It is not to be used as a
basis for construction. It is not to be used as a basis for
construction. It is not to be used as a basis for construction.
D: VRA
C: CONTROL
WEST WAYNE, INDIANA

