


Chesterton High School

Section A5

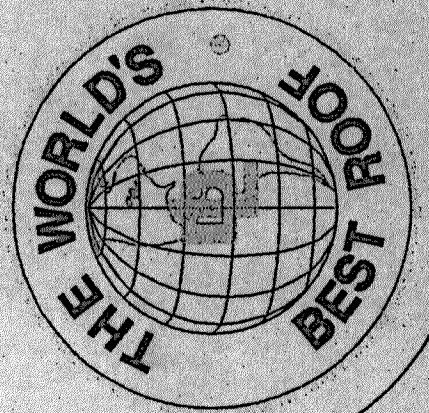

DUROLAST, INC.
525 MORLEY DRIVE
SAGINAW, MICHIGAN 48601


CHESTERTON HIGH SCHOOL
SECTION A5
W.R. KELSO

DWG NAME: CHESTERTON
DRAWN BY: KNOX
REV. BY:

SCALE: 1/16"=1'-0"
DATE: 9/19/97
REV.:

LEGEND
FACTORY WELD
FIELD WELD

97-R-05

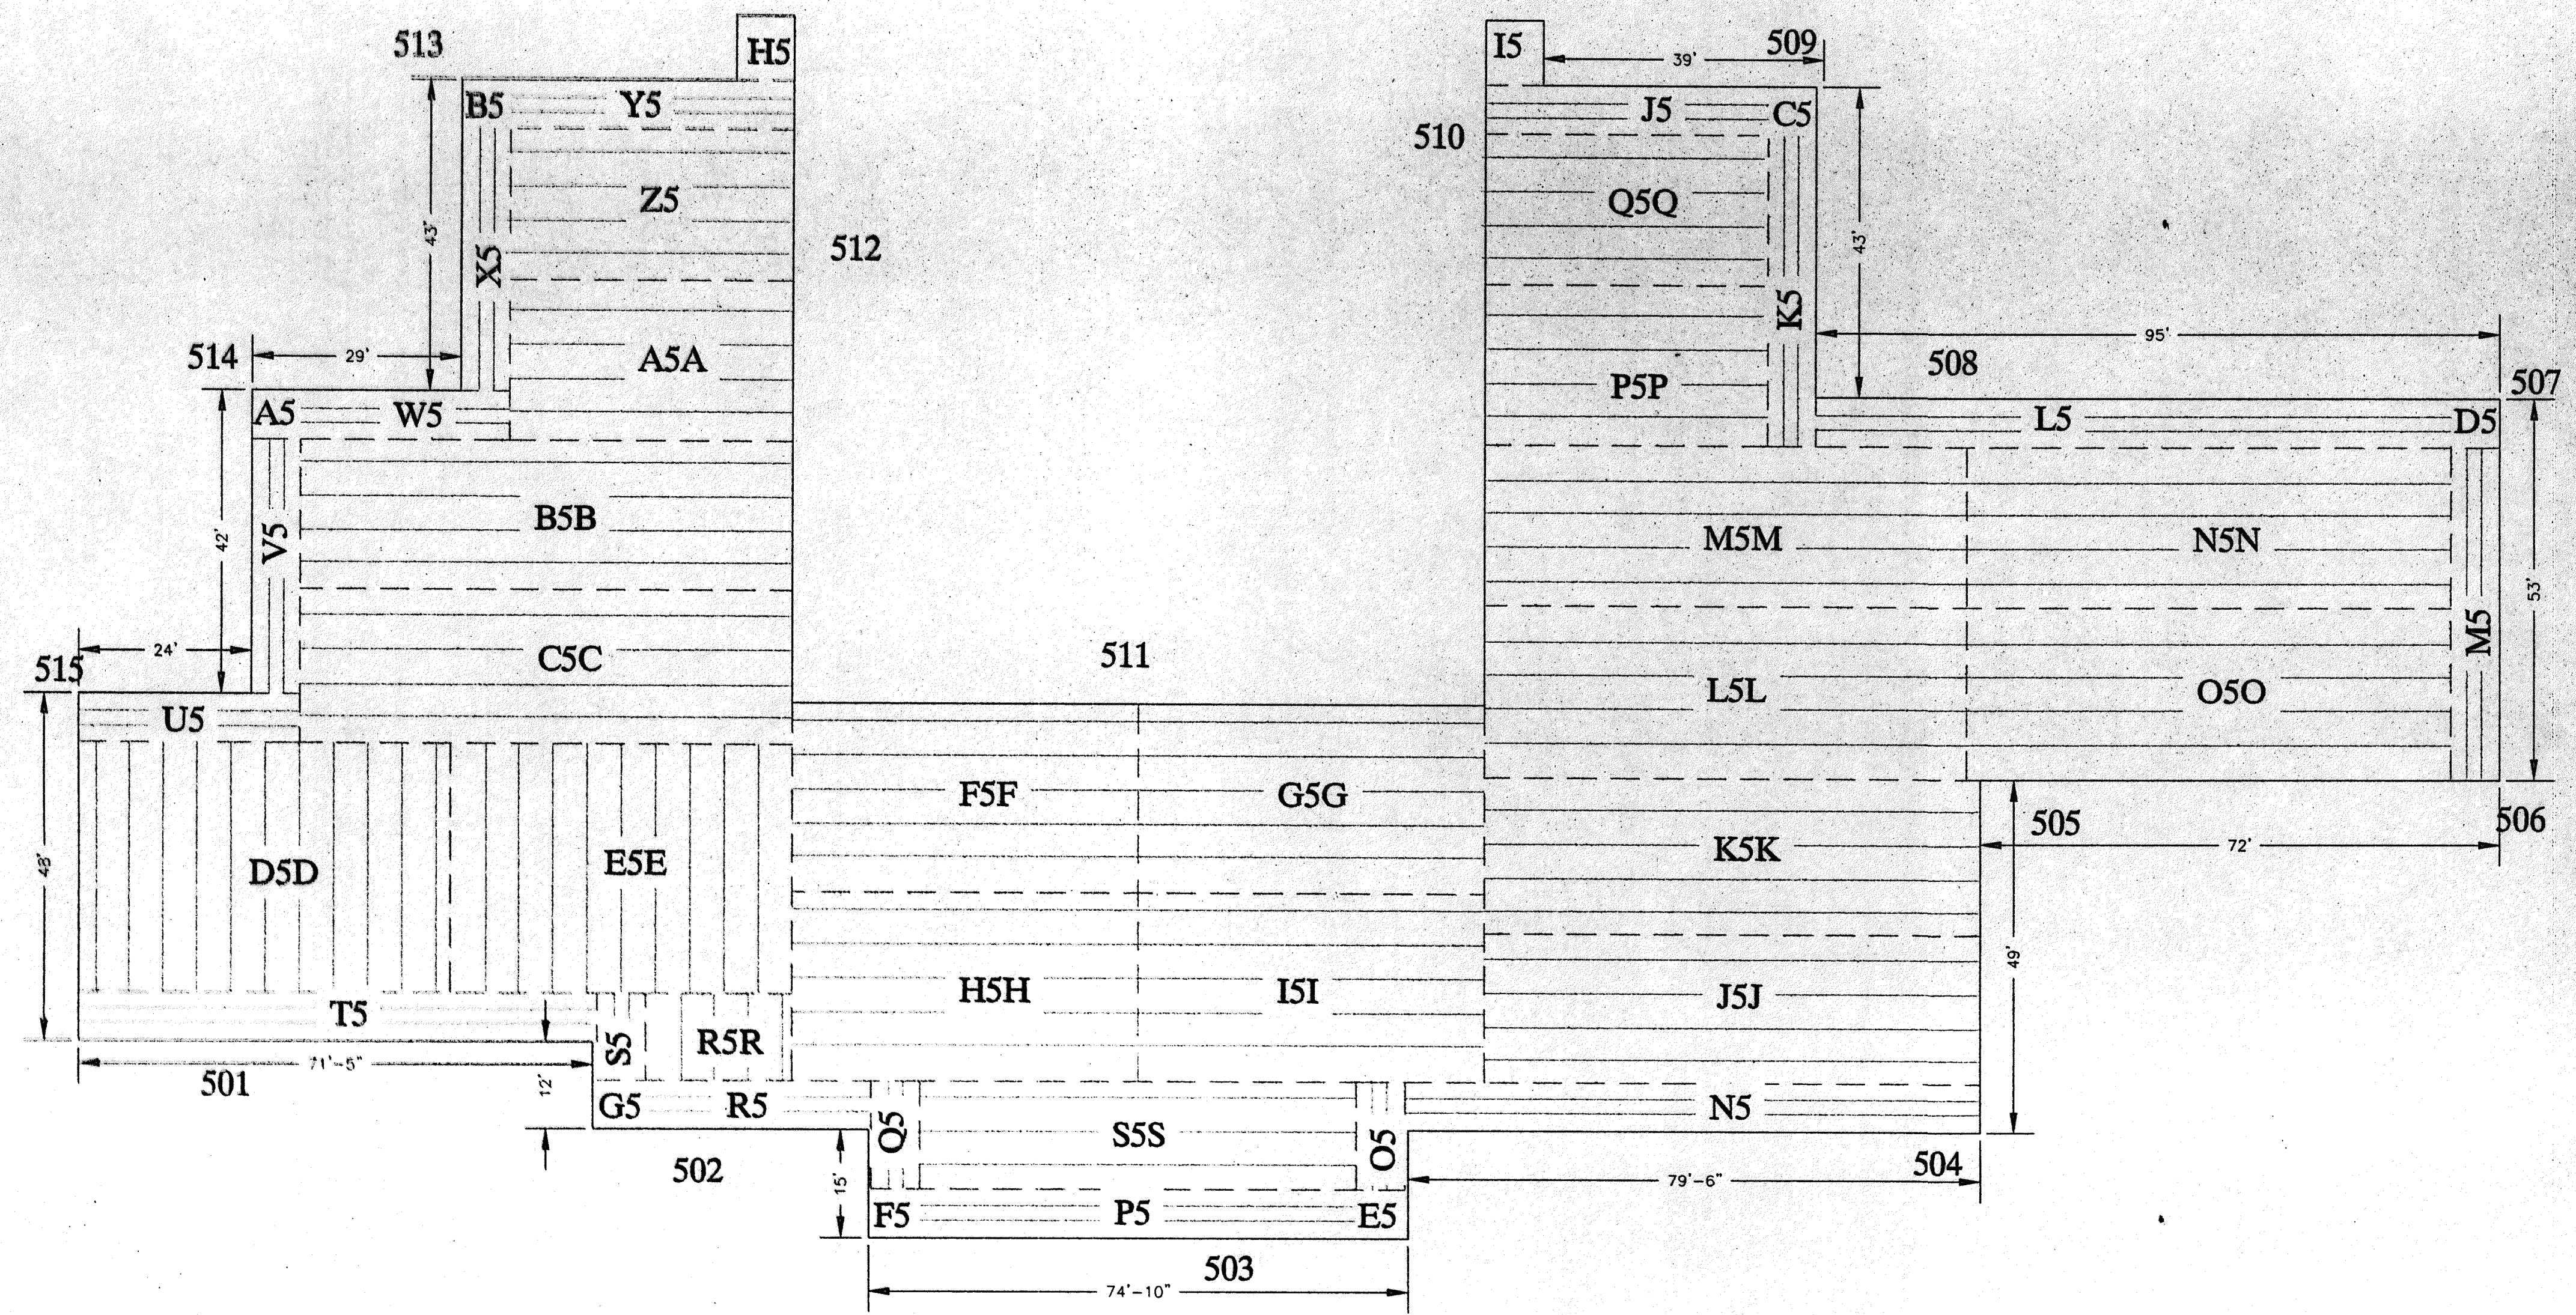

ROOF DECK PANEL SCHEDULE

PC	STD/ROLLS	27" TAB SHTS	WIDTH (FEET)	LGTH (FEET)	TAB	NOTES
A5	-	X	6.5	6.5	6.5	24"REV 21" TABS
B5	-	X	6.5	6.5	6.5	24"REV 21" TABS
C5	-	X	6.5	6.5	6.5	24"REV 21" TABS
D5	-	X	6.5	6.5	6.5	24"REV 21" TABS
E5	-	X	6.5	6.5	6.5	24"REV 21" TABS
F5	-	X	6.5	6.5	6.5	24"REV 21" TABS
G5	-	X	6.5	6.5	6.5	24"REV 21" TABS
H5	-	X	9.5	8	8	24"REV 21" TABS
I5	-	X	9.5	8	8	24"REV 21" TABS
J5	-	X	6.5	42	42	30"REV
K5	-	-	6.5	43.5	43.5	30"REV
L5	-	-	6.5	89.5	89.5	30"REV
M5	-	-	6.5	47	47	30"REV
N5	-	-	6.5	80.5	80.5	30"REV
O5	-	-	6.5	15.5	15.5	30"REV
P5	-	-	6.5	62	62	30"REV
Q5	-	-	6.5	15.5	15.5	30"REV
R5	-	-	6.5	32.5	32.5	30"REV
S5	-	-	6.5	12.5	12.5	30"REV
T5	-	-	6.5	73	73	30"REV
U5	-	-	6.5	30.5	30.5	30"REV
V5	-	-	6.5	36.5	36.5	30"REV
W5	-	-	6.5	22	22	30"REV
X5	-	-	6.5	37.5	37.5	30"REV
Y5	-	X	6.5	42	42	30"REV
Z5	X	-	23.5	40	40	30"REV
A5A	X	-	21.5	40	40	FULL REV
B5B	X	-	21.5	65	65	FULL REV
C5C	X	-	21.5	65	65	FULL REV
D5D	-	-	49.5	36	36	FULL REV
E5E	-	-	50	36	36	FULL REV
F5F	X	-	28.5	49	49	FULL REV
G5G	X	-	28.5	49	49	FULL REV
H5H	X	-	24	49	49	FULL REV
I5I	X	-	24	49	49	FULL REV
J5J	-	-	20.5	64.5	64.5	30"REV
K5K	X	-	23.5	64.5	64.5	30"REV
L5L	X	-	24	71	71	FULL REV
M5M	X	-	23.5	71	71	30"REV
N5N	X	-	23.5	71	71	30"REV
O5O	X	-	24	71	71	FULL REV
P5P	X	-	21.5	40	40	FULL REV
Q5Q	X	-	23.5	40	40	30"REV
R5R	-	-	21	12.5	12.5	FULL REV
S5S	X	-	16.5	62	62	FULL REV

☒ CHECKED AND FORWARDED TO A/E
☐ REVISE AND RESUBMIT
☐ INSUFFICIENT INFORMATION
Checked for accuracy and compliance with the
Contract Documents. Contractor is responsible for
the accuracy of the information and correlated
data. The information herein pertains solely to the
fabrication and erection of the roof deck panels and
for coordination of the work of all trades.
BY MPA
DATE 12/2/97
CONSTRUCTION CONTROL
FORT WAYNE, INDIANA

