



# Chersterton High School

## Section A4

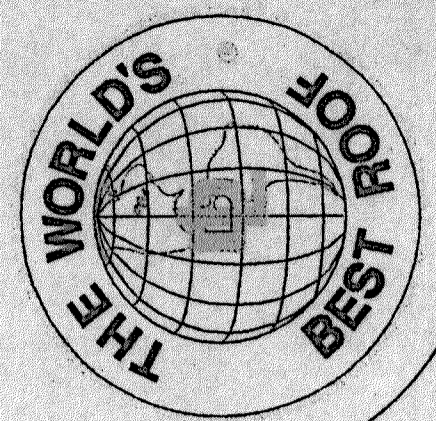


DURO-LAST, INC.  
525 MORLEY DRIVE  
SAGINAW, MICHIGAN 48601

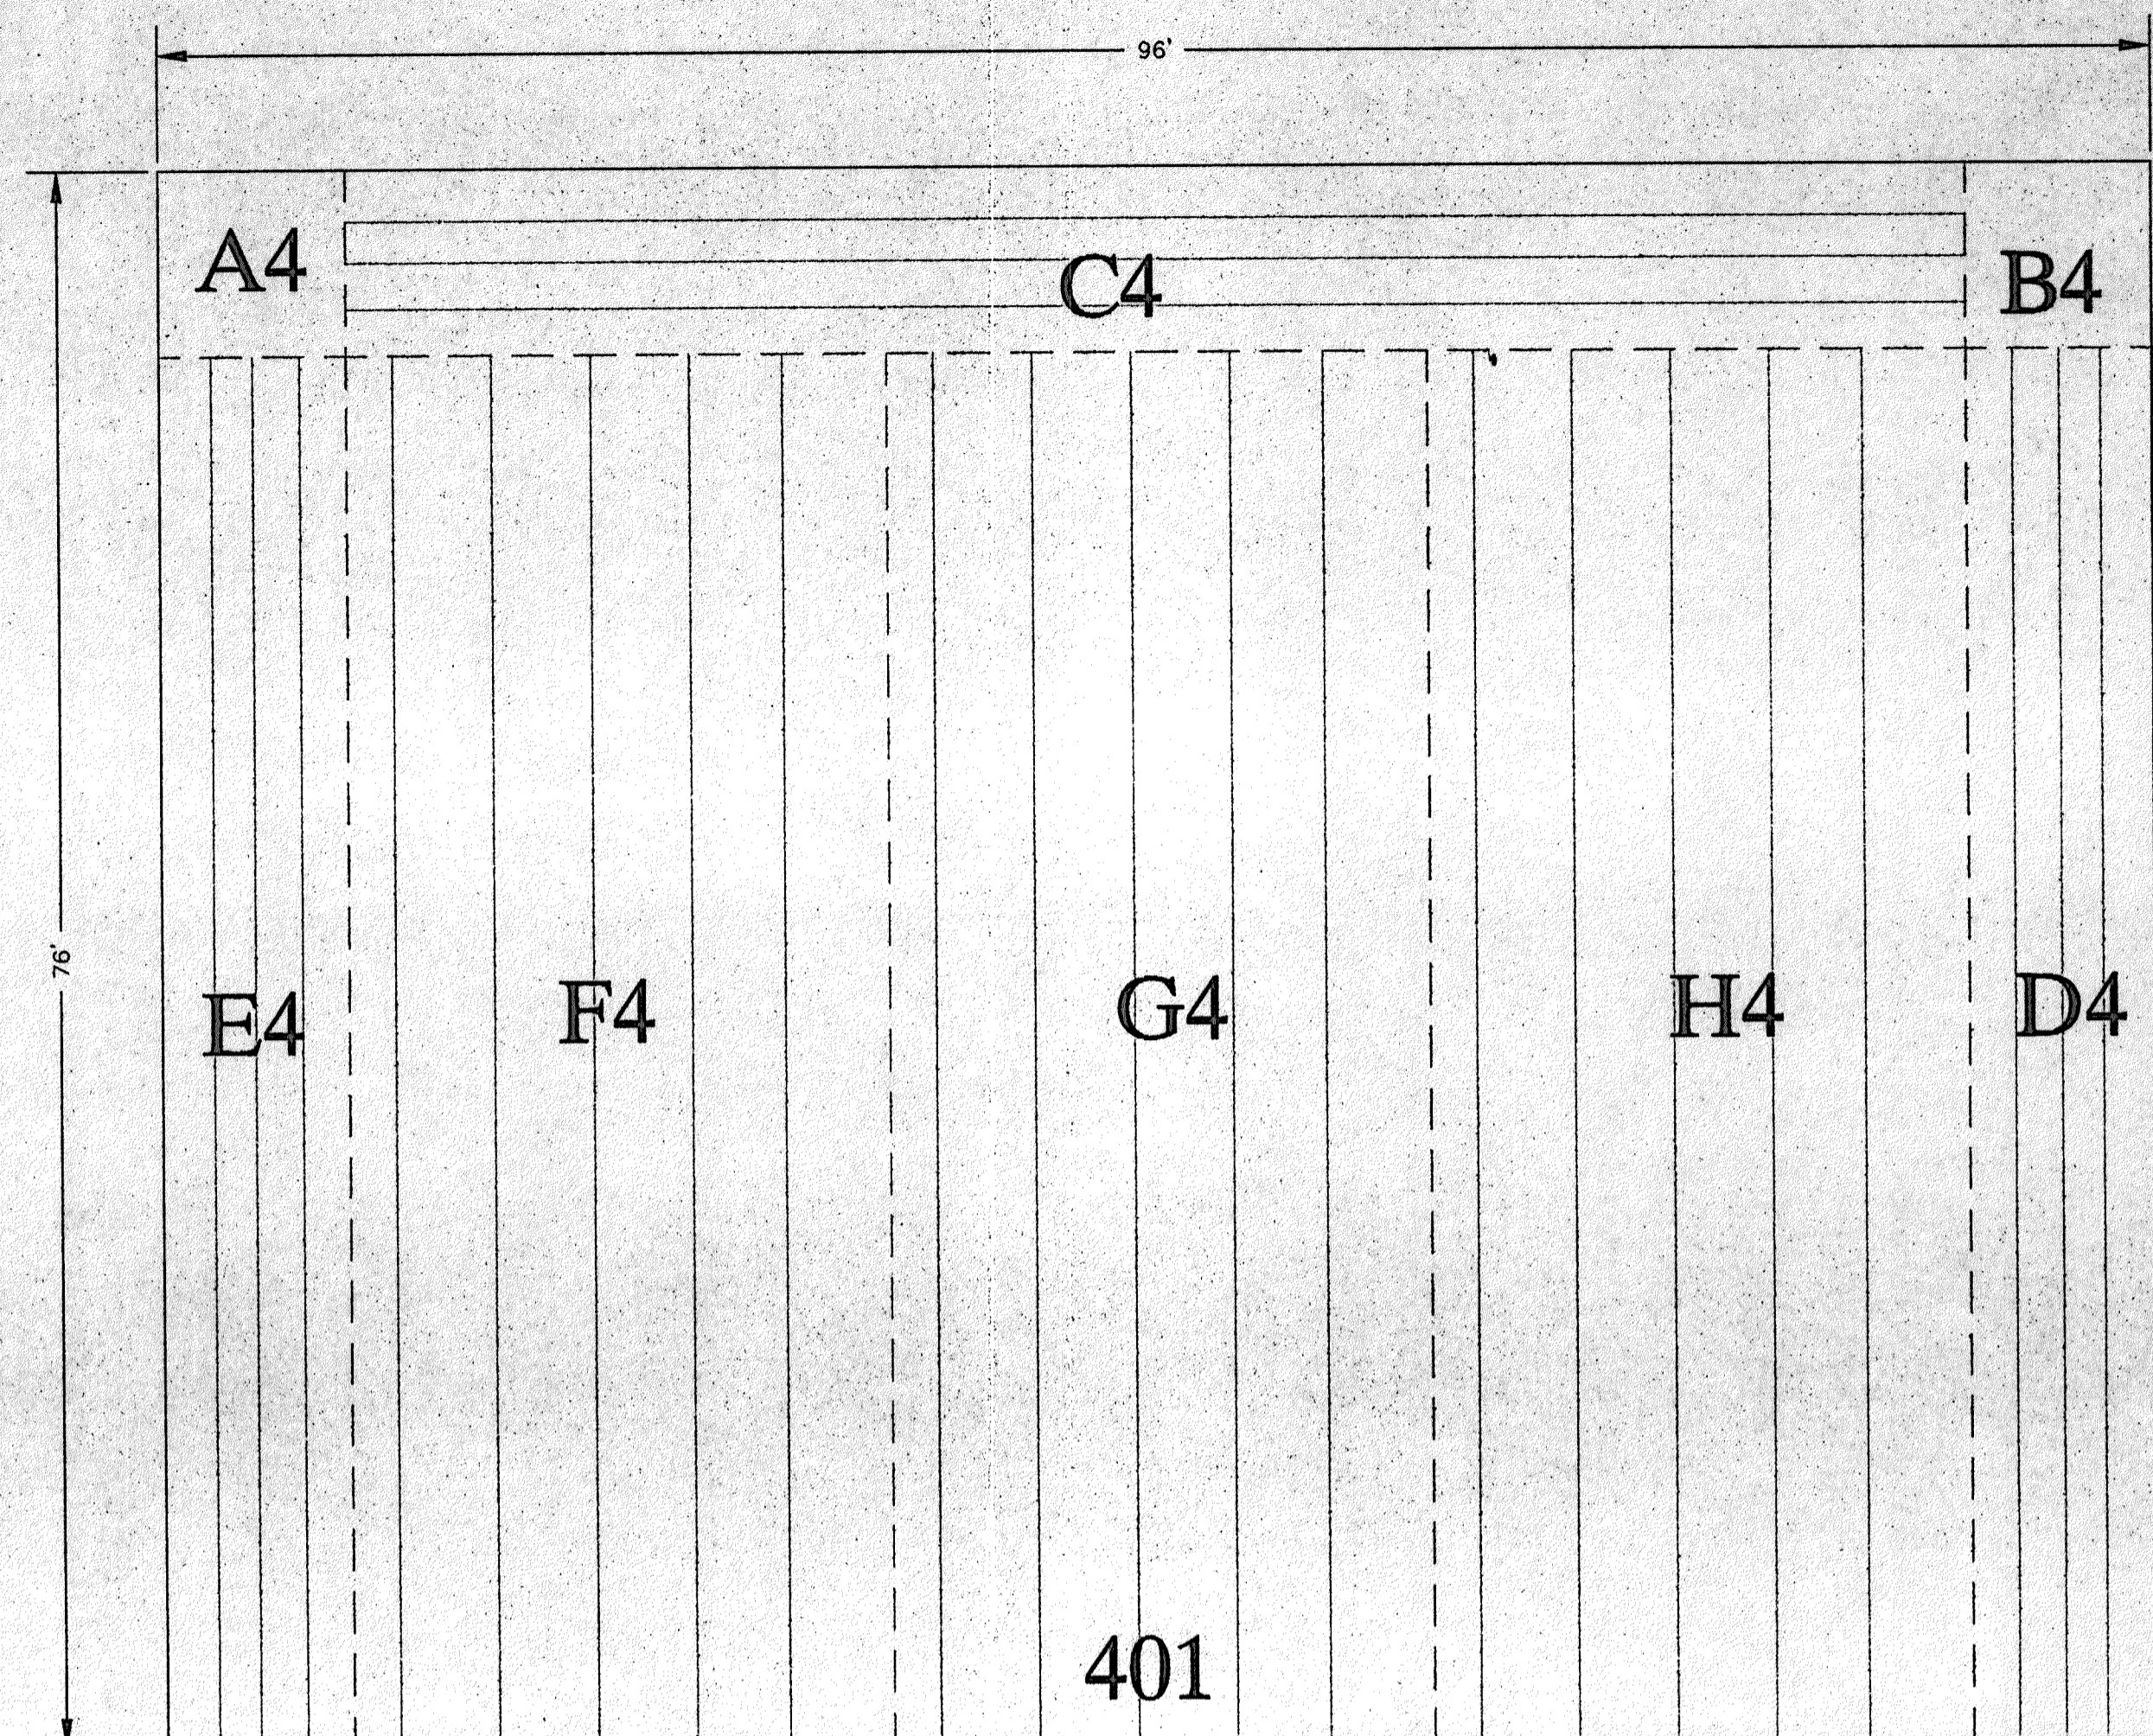


ROOF DECK PANEL SCHEDULE

PC	STD/ ROLLS	27"TAB SHTS	WIDTH (FEET)	LGTH (FEET)	TAB	NOTES
A4	-	X	9	9	9	24"REV21" TABS
B4	-	X	9	9	9	24"REV21" TABS
C4	-	X	9	80	80	30"REV
D4	-	X	9	68	68	30"REV
E4	-	X	9	68	68	30"REV
F4	X		26	68	68	30"REV
G4	X		26	68	68	30"REV
H4	X		28.5	68	68	30"REV
I4	-	X	4.5	4.5	4.5	24"REV21" TABS
J4	-	X	4.5	4.5	4.5	24"REV21" TABS
K4	-	X	4.5	4.5	4.5	24"REV21" TABS
L4	-	X	4.5	4.5	4.5	24"REV21" TABS
M4	-	X	4.5	89	89	30"REV
N4	-	X	4.5	37	37	30"REV
O4	-	X	4.5	89	89	30"REV
P4	-	X	4.5	37	37	30"REV
Q4	-		44.5	37	37	FULL REV
R4	-		45	37	37	FULL REV

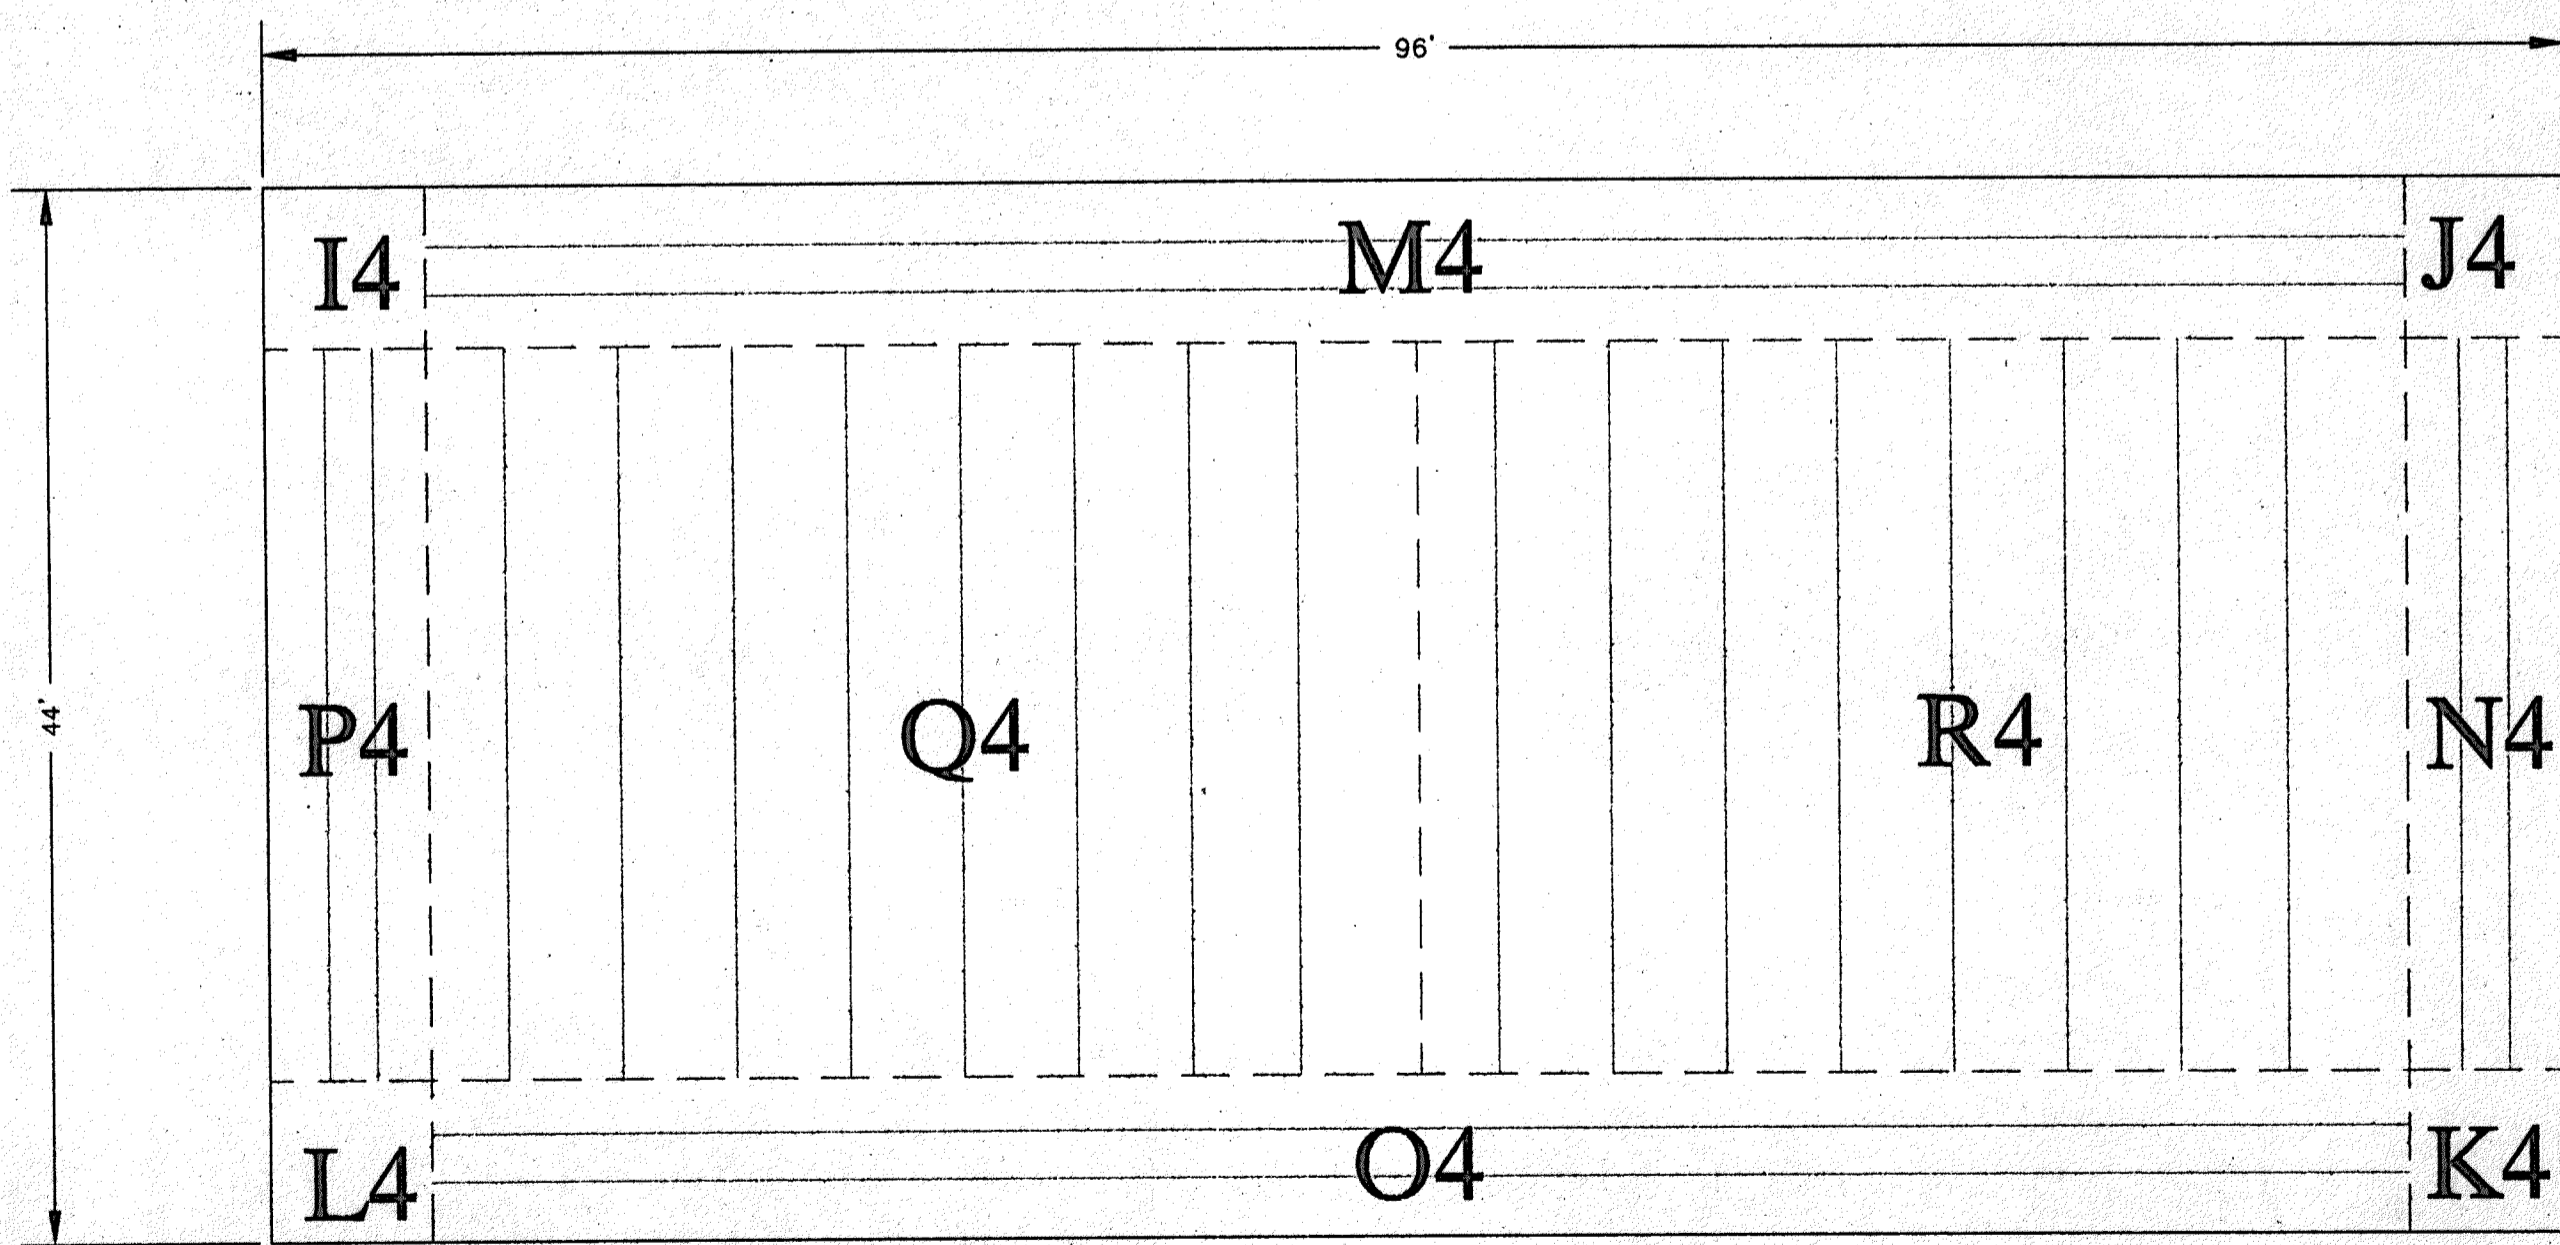

☒ CHECKED AND FORWARDED TO A/E  
☐ REVISE AND RESUBMIT  
☐ INSUFFICIENT INFORMATION  
Contractor is responsible for performance and compliance with the  
plans and specifications. Contractor is responsible for the  
accuracy of the information furnished and correlated  
with the plans and specifications. The contractor's liability to the  
owner is limited to the work of construction and  
for completion of the work of all trades.  
BY MPA  
DATE 12/2/97  
CONSTRUCTION CONTROL  
FORT WAYNE, INDIANA

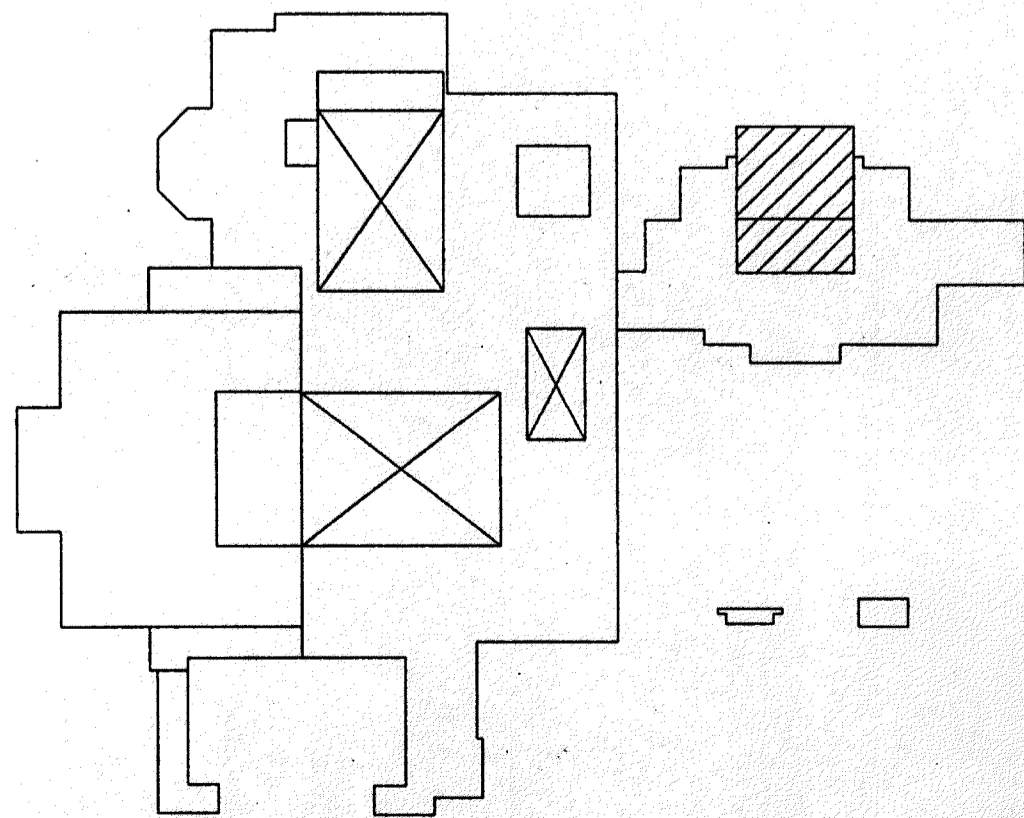

CHESTERTON HIGH SCHOOL  
SECTION A4  
W.R. KELSO

DWG NAME: CHESTERTON  
DRAWN BY: KNOX  
REV. BY:

SCALE: 1/8" = 1' - 0"  
DATE: 9/19/97  
REV.:

LEGEND  
FACTORY WELD  
FIELD WELD