


Chesterton High School

Section 3A

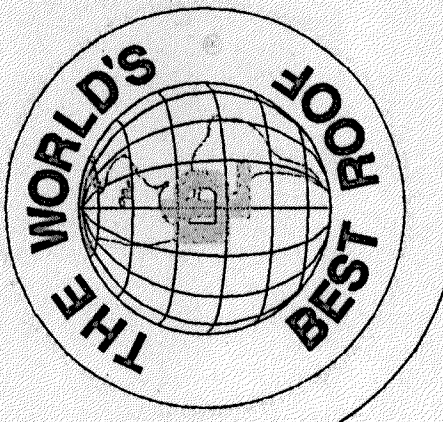

DURO-LAST, INC.
525 MORLEY DRIVE
SAGINAW, MICHIGAN 48601




CHESTERTON HIGH SCHOOL
SECTION A3
W.R. KELSO

DWG NAME: CHESTERTON
DRAWN BY: KNOX
REV. BY:

SCALE: 1/8"=1'-0"
DATE: 9/19/97
REV.:

LEGEND
FACTORY WELD
FIELD WELD

97-07

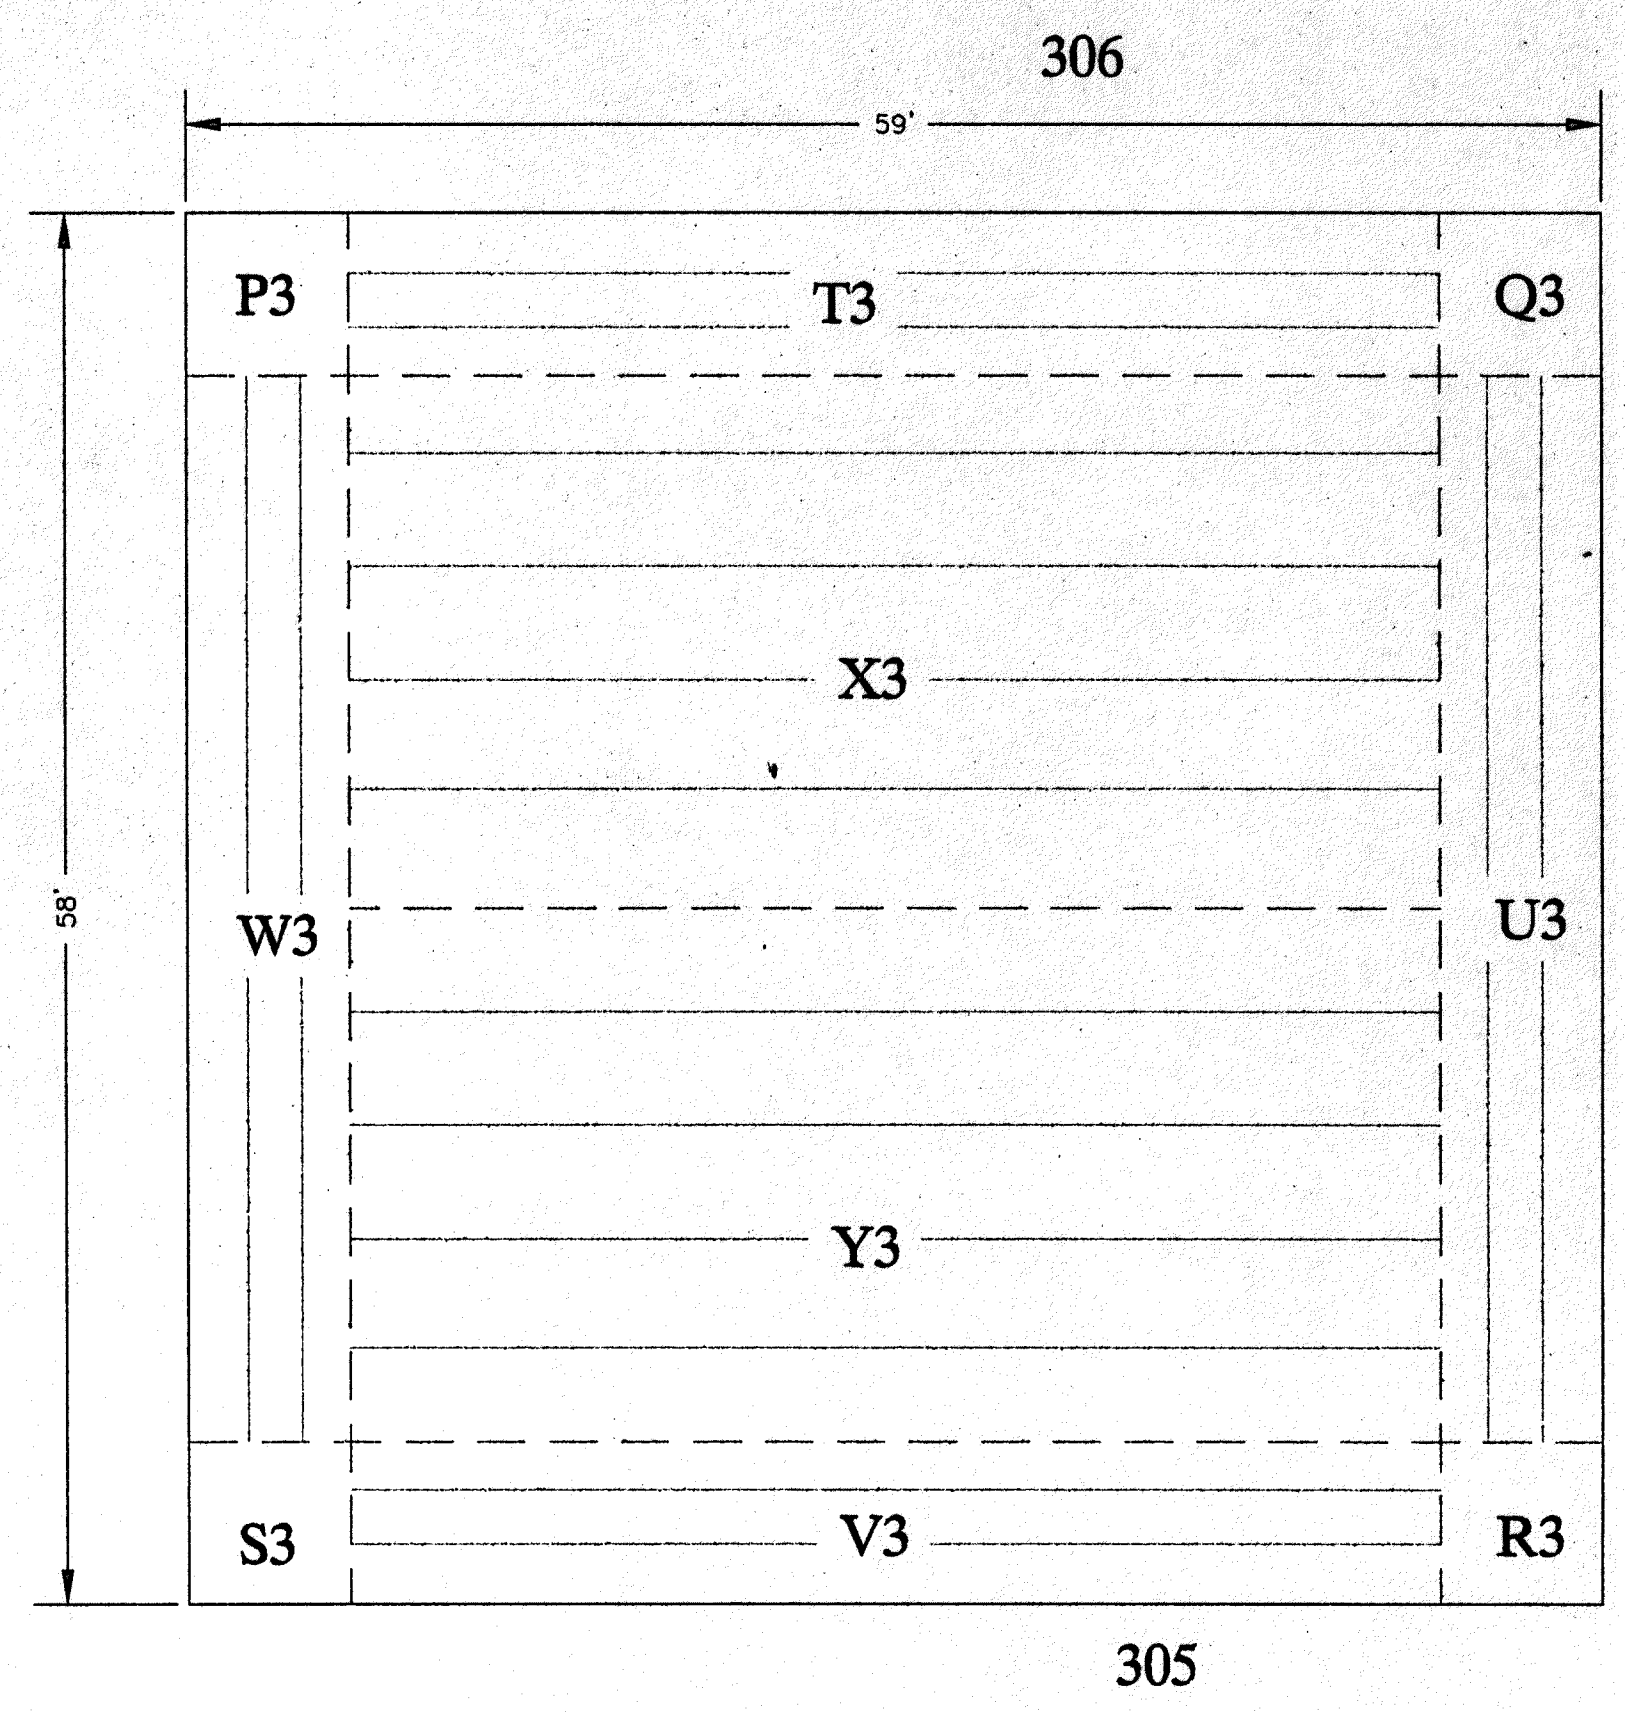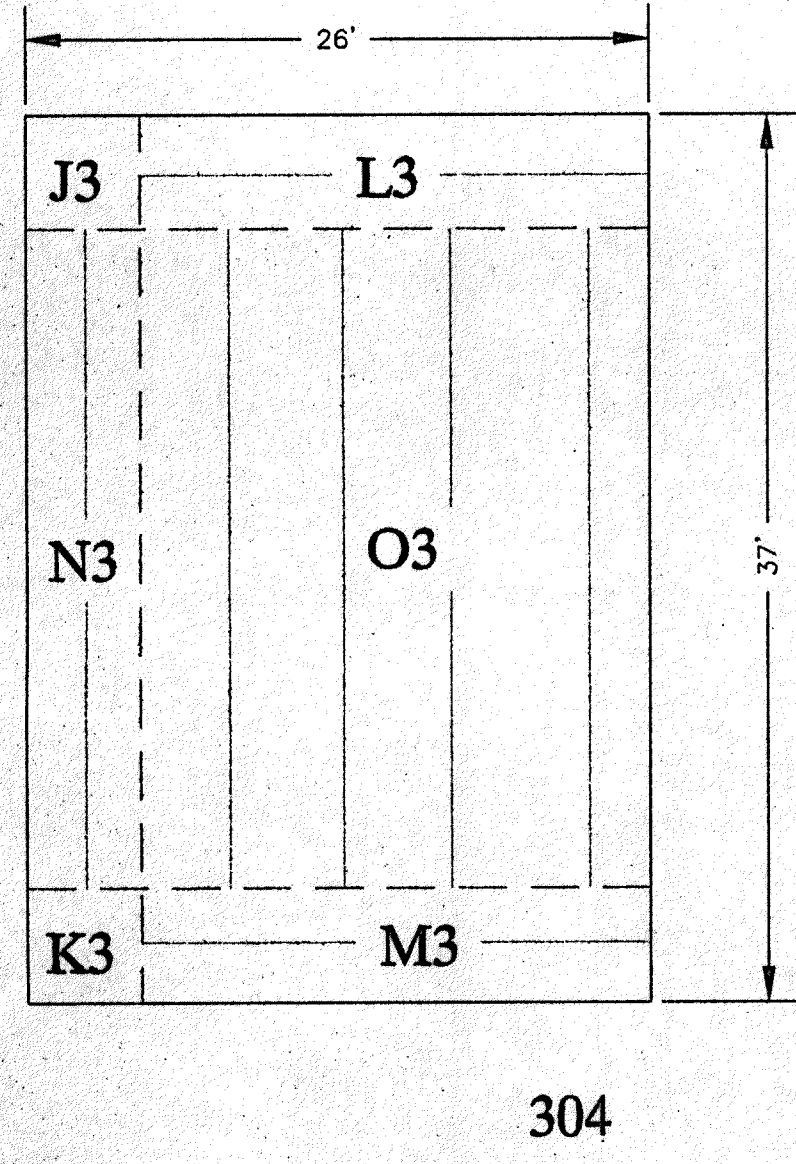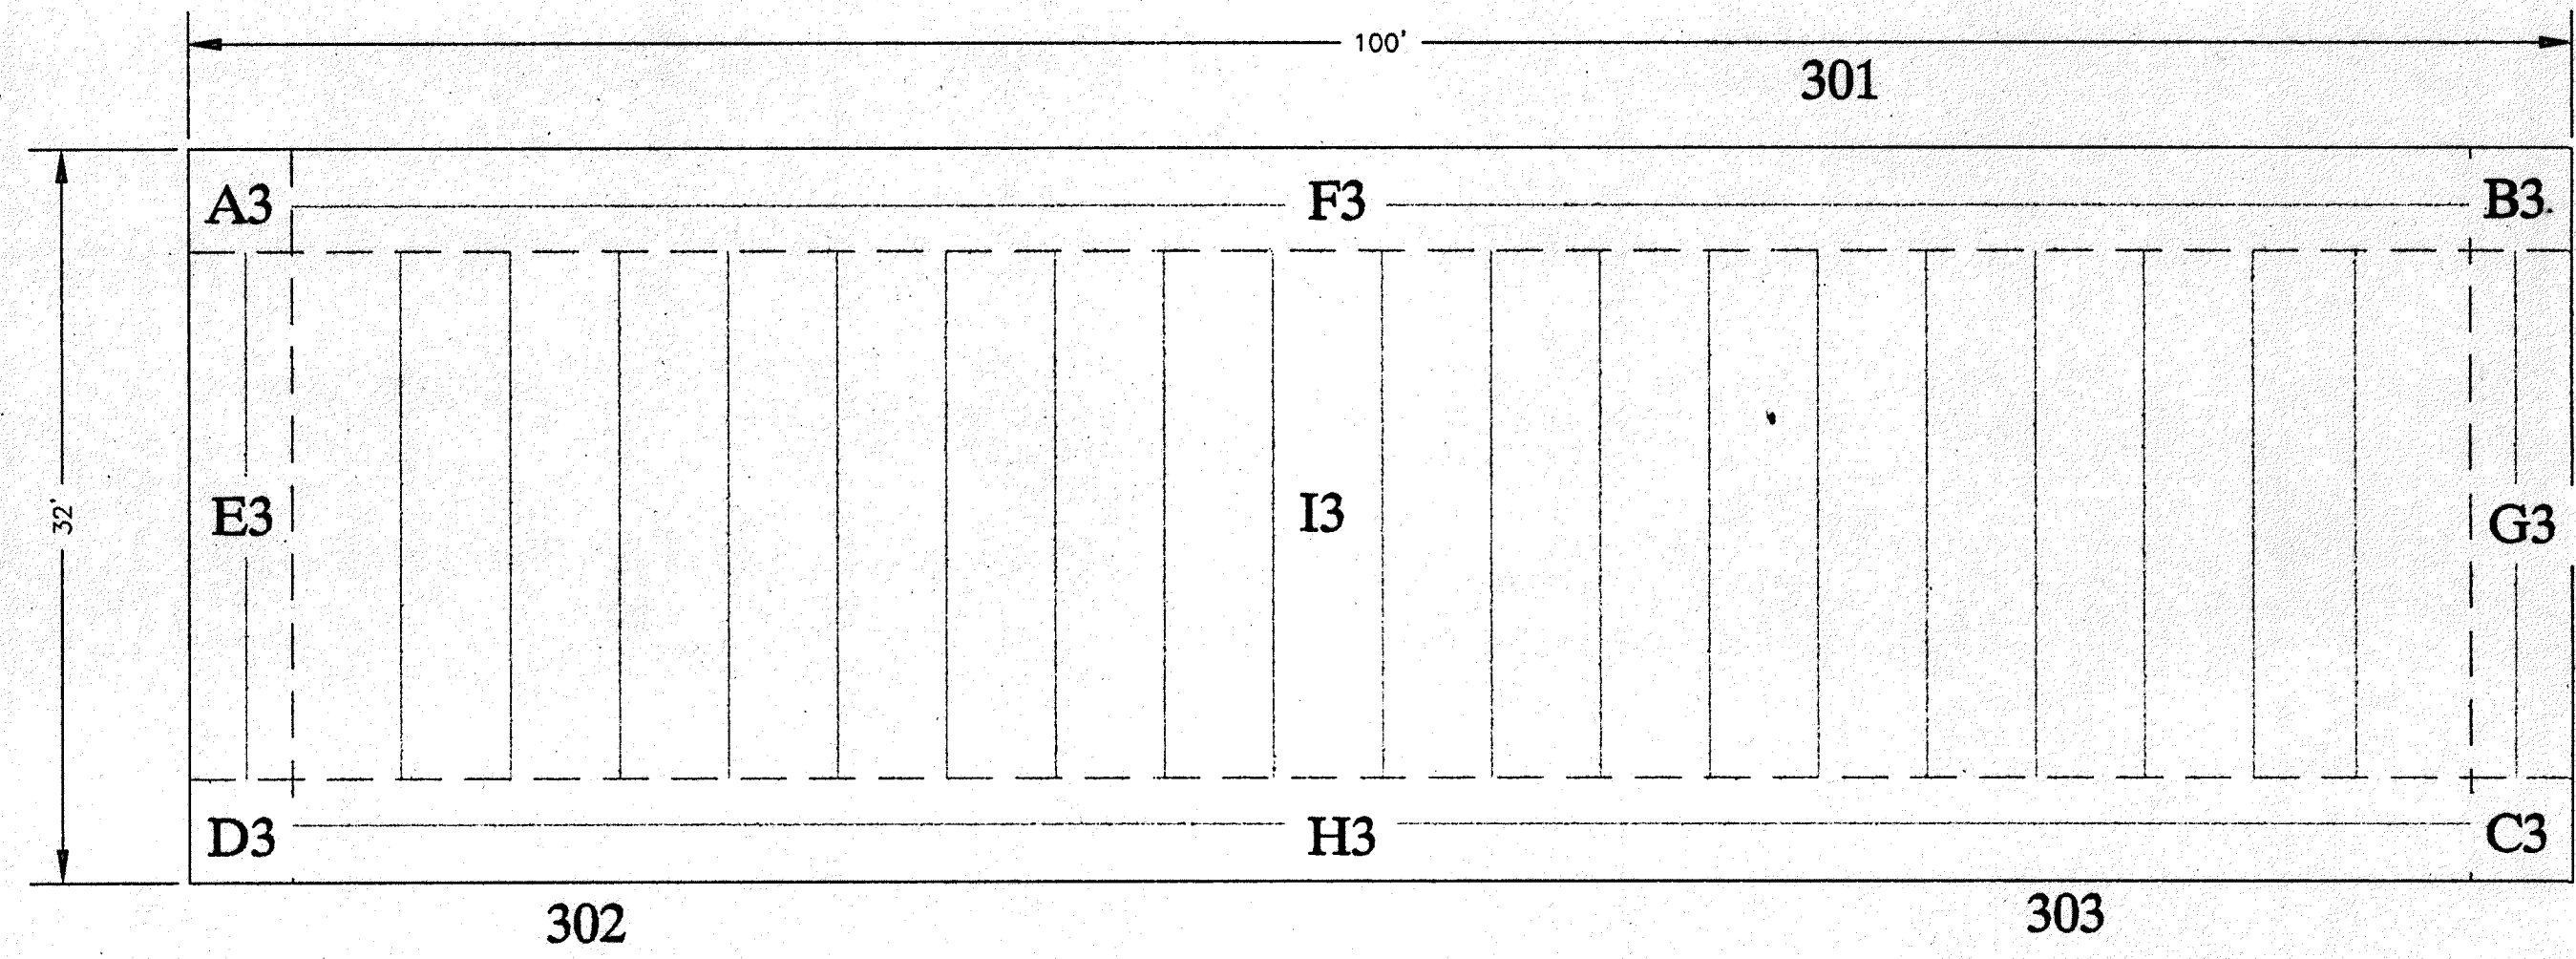

ROOF DECK PANEL SCHEDULE

PC	STD/ ROLLS	27'TAB SHTS	WIDTH (FEET)	LGTH (FEET)	TAB	NOTES
A3	-	X	4.5	4.5	4.5	24'REV/21'TABS
B3	-	X	4.5	4.5	4.5	24'REV/21'TABS
C3	-	X	4.5	4.5	4.5	24'REV/21'TABS
D3	-	X	4.5	4.5	4.5	24'REV/21'TABS
E3	-	X	4.5	24	24	30'REV
F3	-	X	4.5	92	92	30'REV
G3	-	X	4.5	24	24	30'REV
H3	-	X	4.5	92	92	30'REV
I3	-	-	92	24	24	FULL REV
J3	-	X	4.5	4.5	4.5	24'REV/21'TABS
K3	-	X	4.5	4.5	4.5	24'REV/21'TABS
L3	-	X	4.5	22.5	22.5	30'REV
M3	-	X	4.5	22.5	22.5	30'REV
N3	-	X	4.5	30	30	30'REV
O3	-	-	22.5	30	30	FULL REV
P3	-	X	6.5	6.5	6.5	24'REV/21'TABS
Q3	-	X	6.5	6.5	6.5	24'REV/21'TABS
R3	-	X	6.5	6.5	6.5	24'REV/21'TABS
S3	-	X	6.5	6.5	6.5	24'REV/21'TABS
T3	-	X	6.5	48	48	30'REV
U3	-	X	6.5	46	46	30'REV
V3	-	X	6.5	48	48	30'REV
W3	-	X	6.5	46	46	30'REV
X3	X	-	23.5	48	48	30'REV
Y3	X	-	23.5	48	48	30'REV

☒ CHECKED AND FORWARDED TO A/E
☐ REVISE AND RESUBMIT
☐ INSUFFICIENT INFORMATION
Checked for performance and compliance with the
requirements of the contract documents. Contractor is
responsible for the accuracy of the information and
the design of the work. The contractor's responsibility
for coordination of the work of all trades.
BY: MZA
DATE: 12/3/97
CONSTRUCTION CONTROL
FORT WAYNE, INDIANA

