



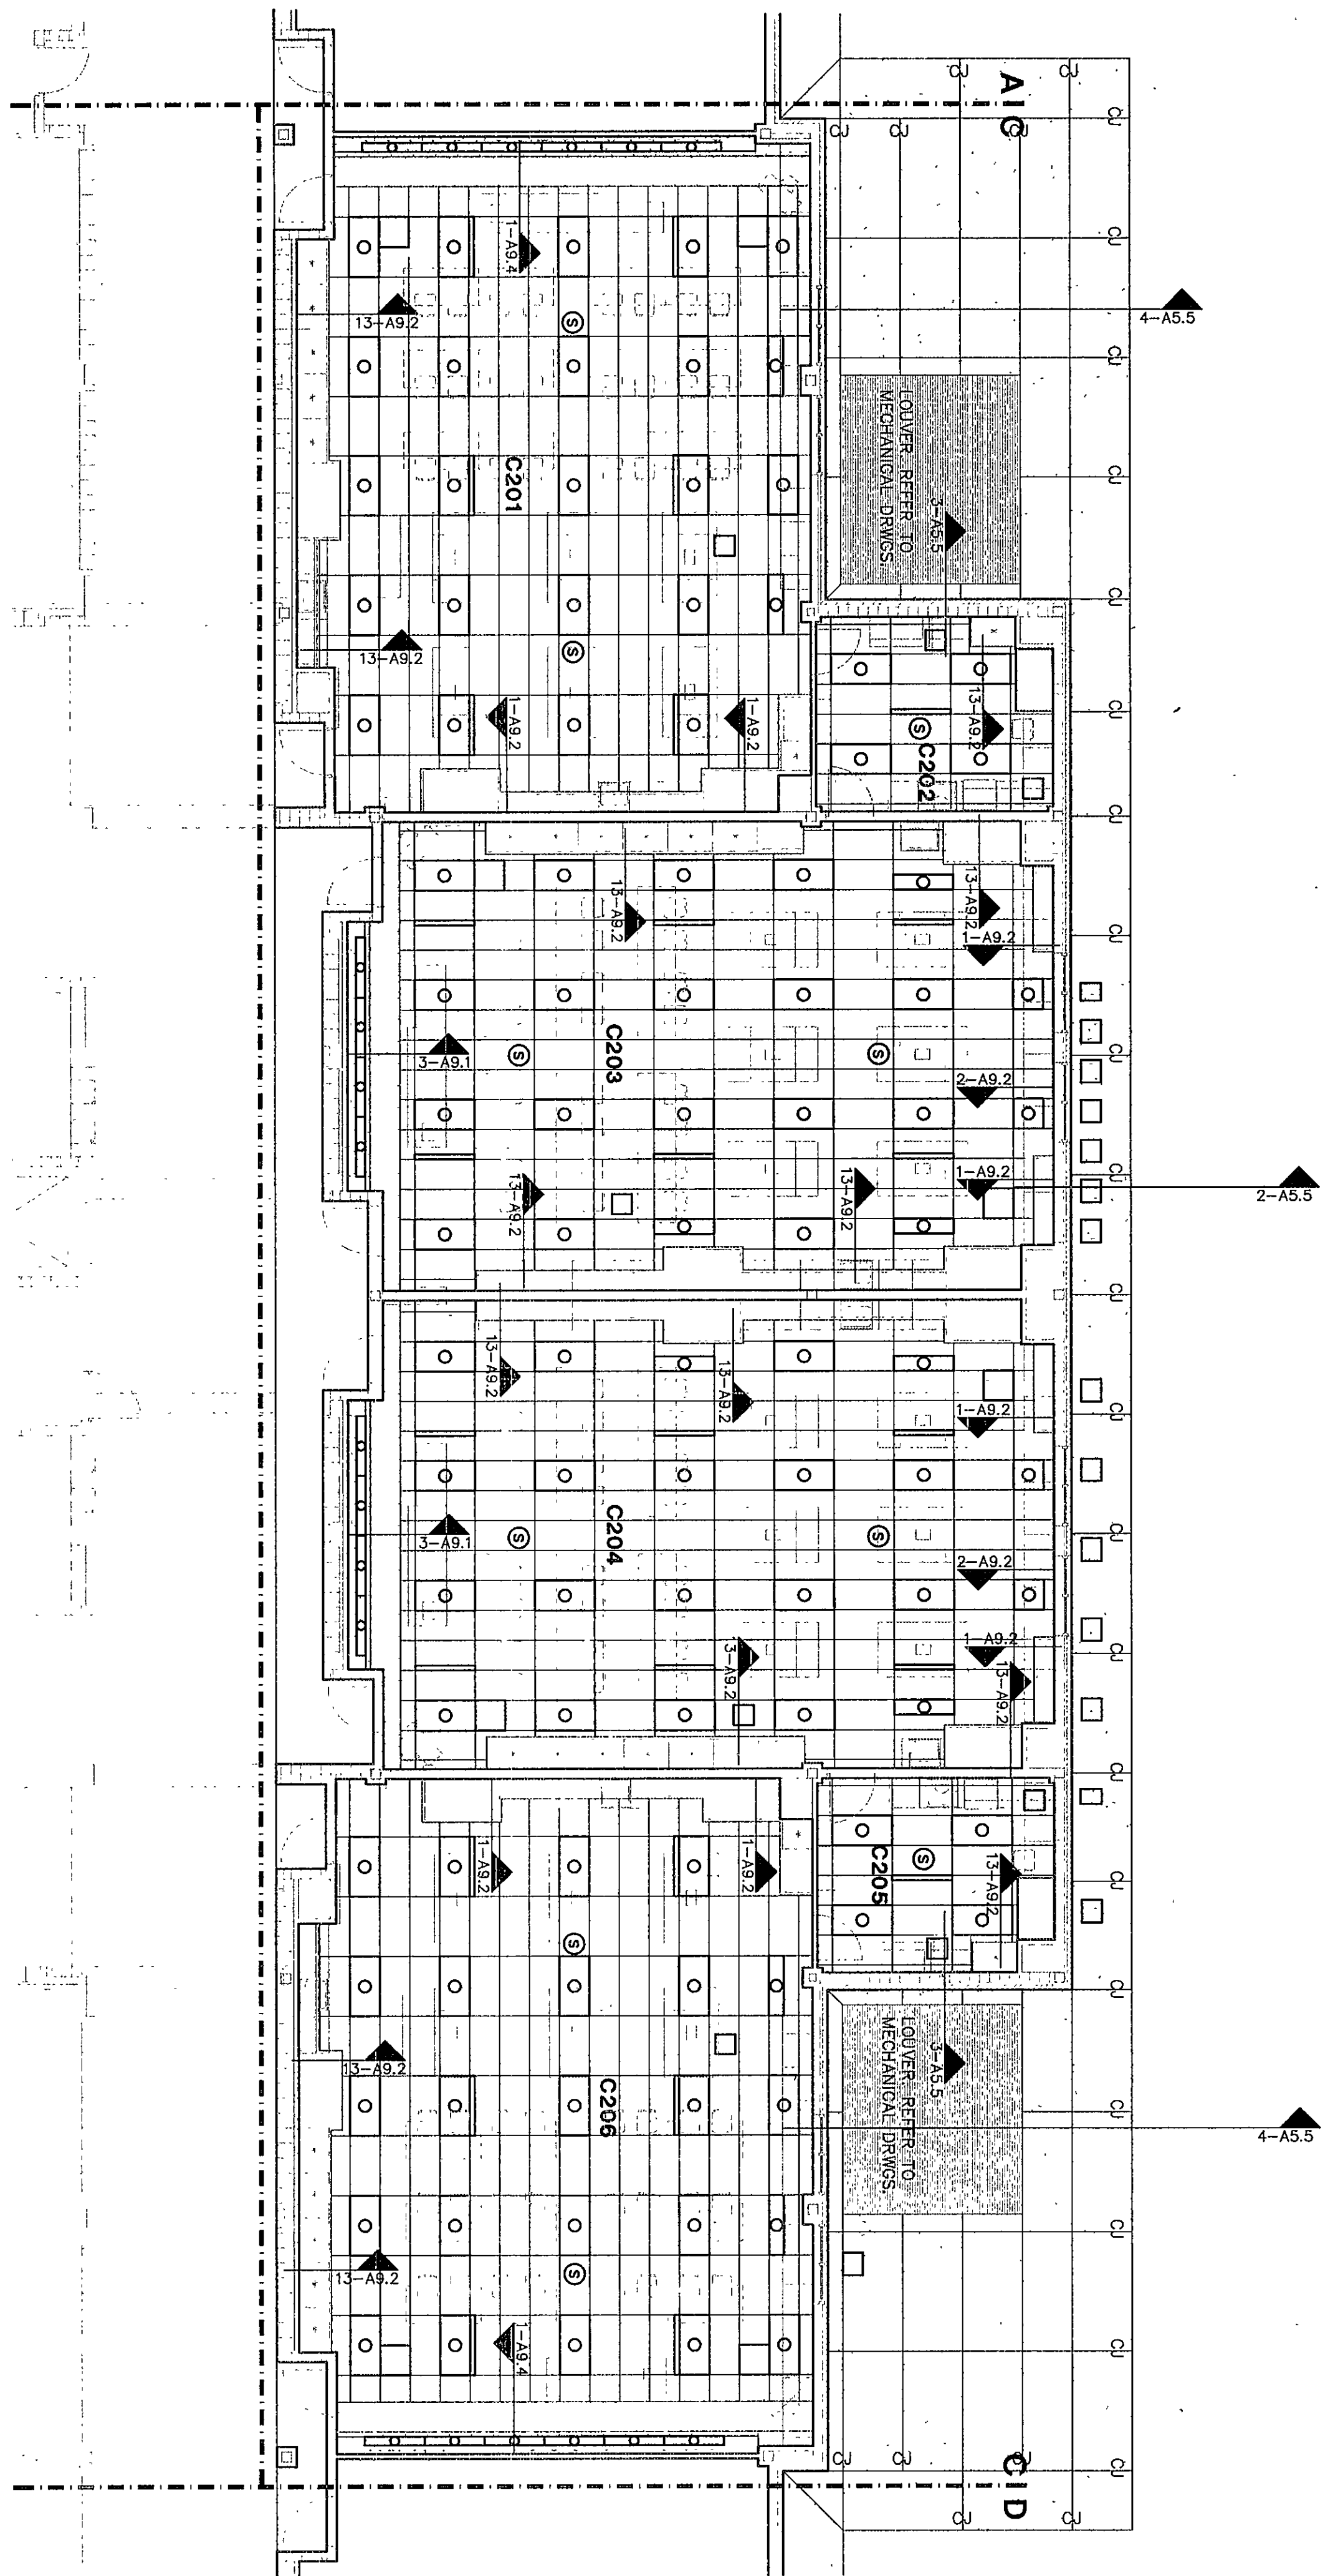

CEILING PLAN UNIT C2

1/8" = 1'-0"

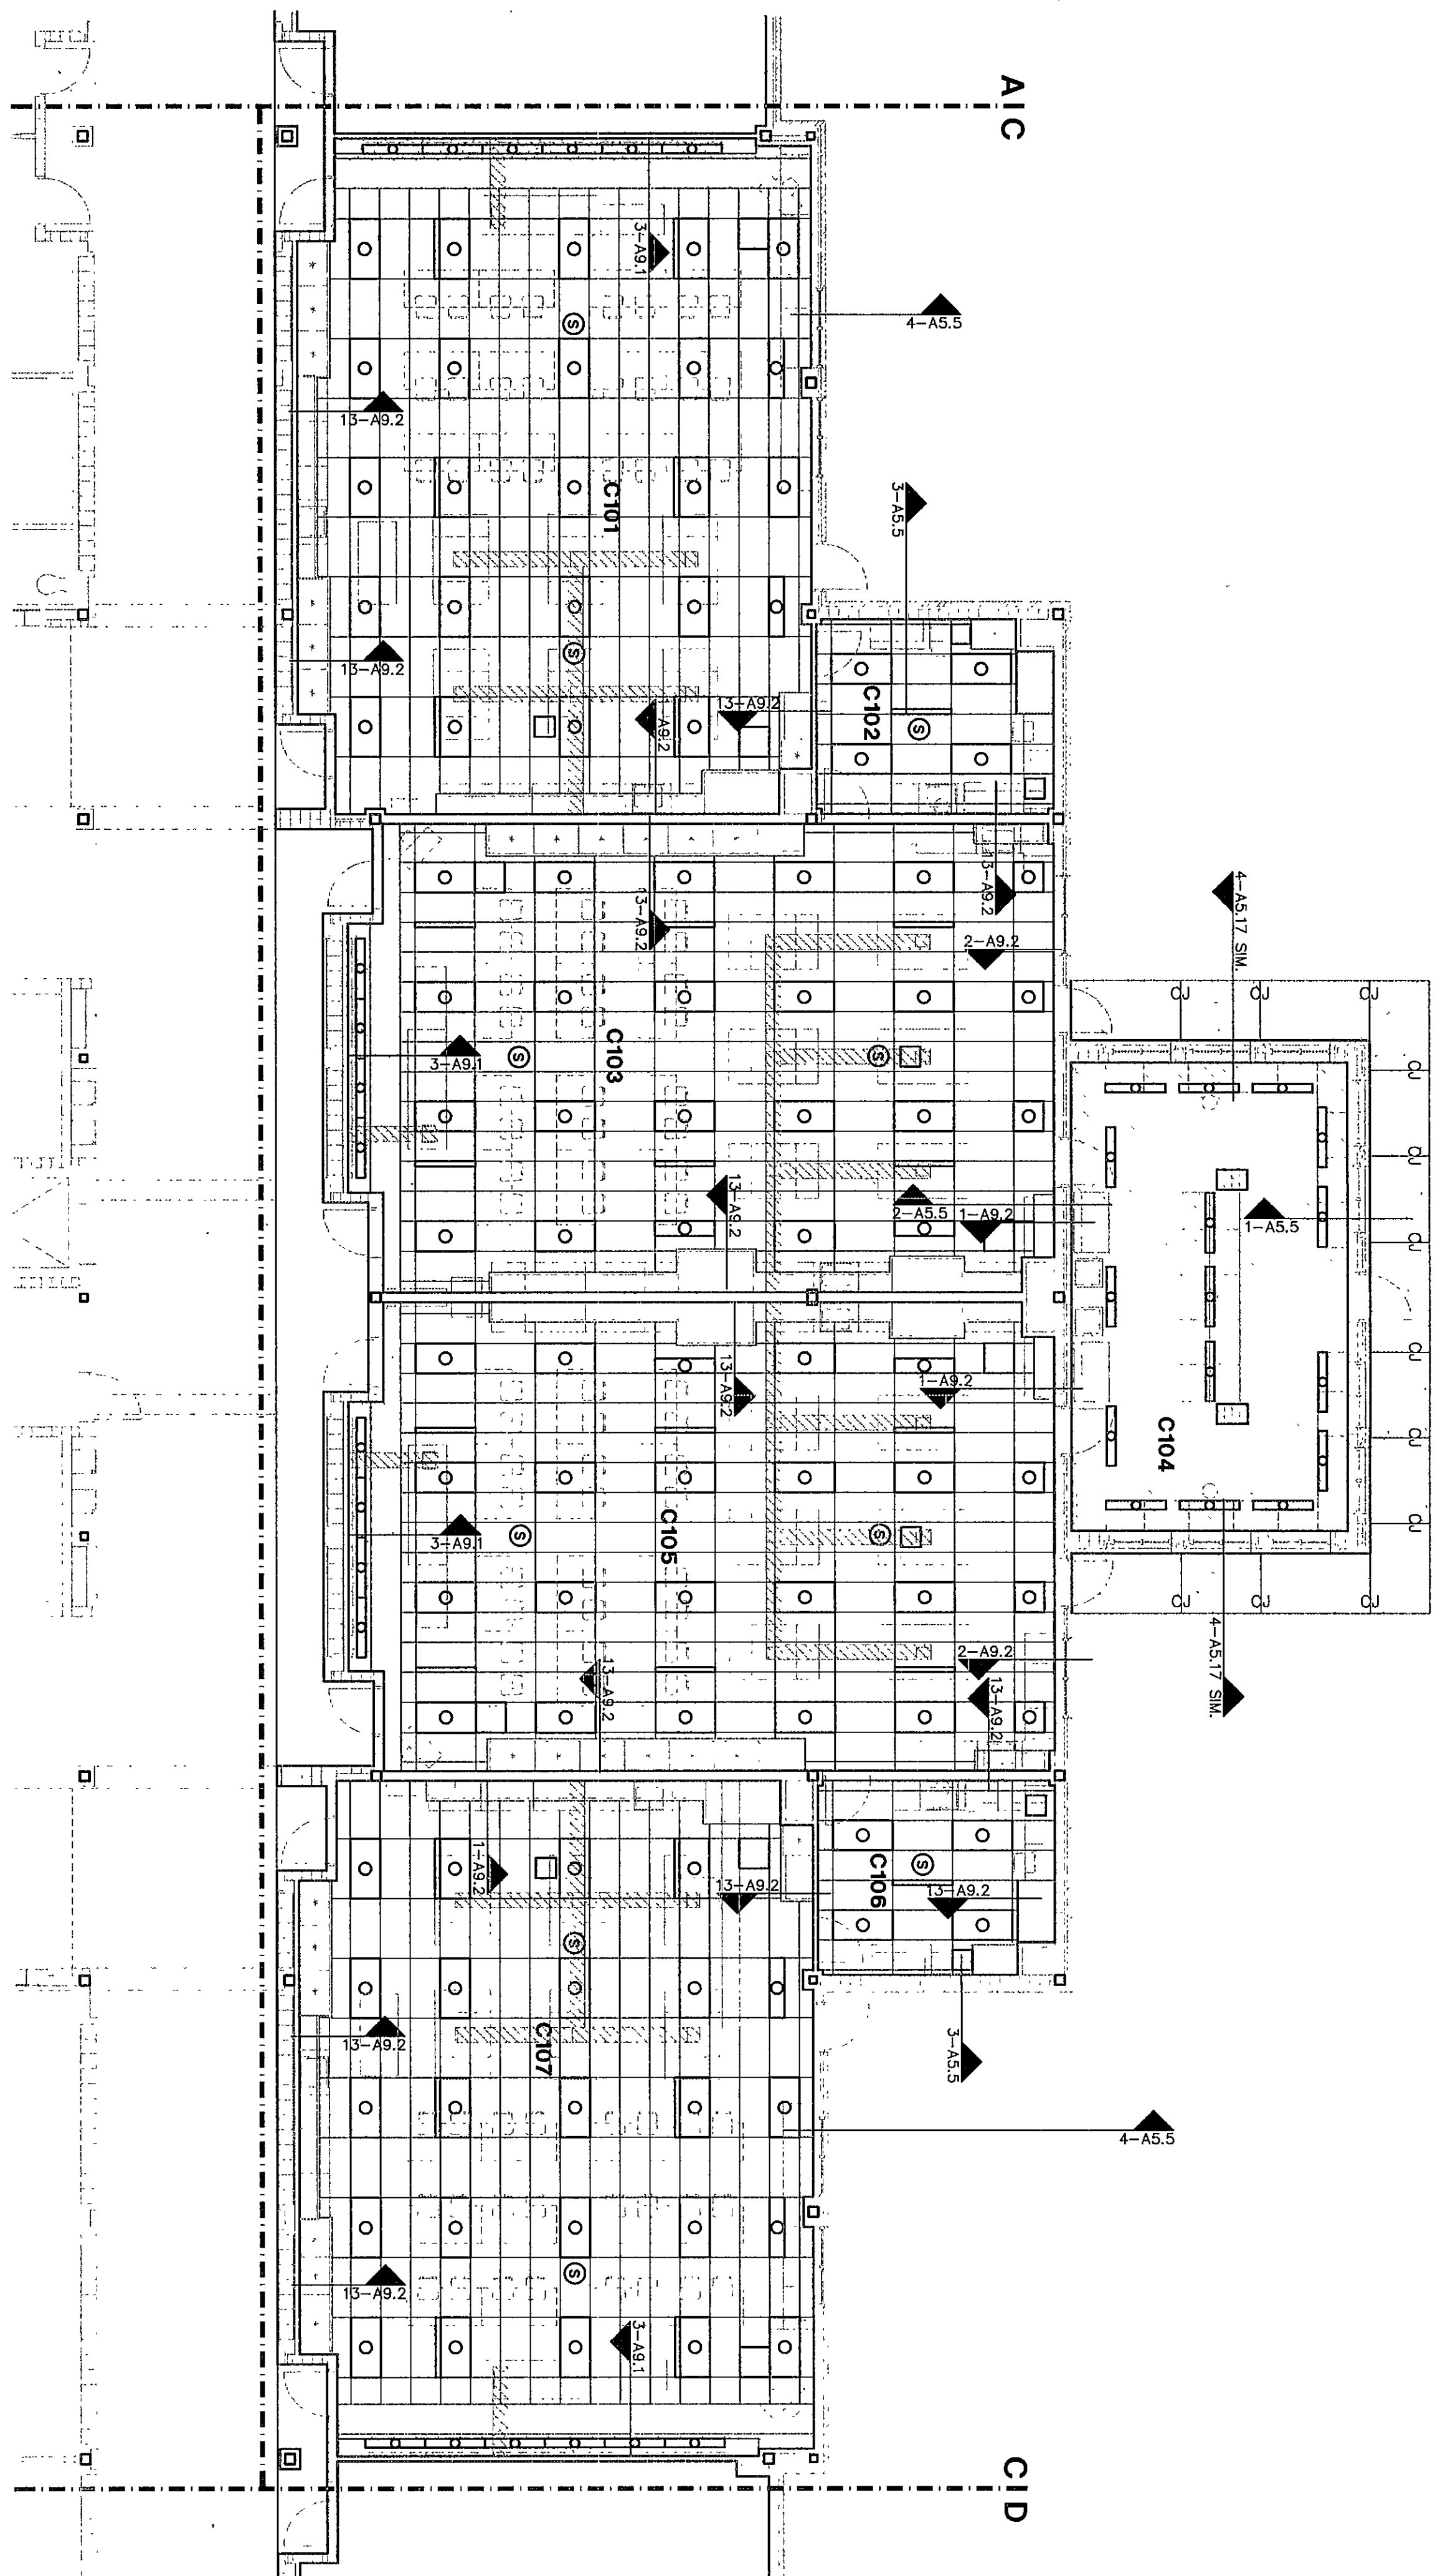

CEILING PLAN UNIT C1

1/8" = 1'-0"

ROOM LEGEND "C2"

ROOM NO.	ROOM NAME	AREA S.F.	CEILING HEIGHT
C201	SCIENCE LAB	2005	9' VARIES
C202	SCIENCE LAB	2005	9' VARIES
C203	SCIENCE LAB	1436	9' VARIES
C204	SCIENCE LAB	1436	9' VARIES
C205	SCIENCE LAB	1436	9' VARIES
C206	SCIENCE LAB	1505	9' VARIES

GENERAL CEILING NOTES



1. ALTERNATE - SCHED CEILING PROTECTION SURFACES AND LIGHTING SIMILAR TO DETAIL 3-A9.1 ARE TO BE PROVIDED UNDER AN ALTERNATIVE BID. REFER TO ALTERNATIVES SPECIFICATION SECTION 01300.
2. UNDER THE BASE AND PROVIDE 1/2" CEILING GAGES AT 9'-0" A.F.F. AT CLASSROOM LOCATIONS UNLESS NOTED OTHERWISE. REFER TO ALTERNATIVES SPECIFICATION SECTION 01300. ALSO REFER TO ALTERNATIVES SPECIFICATION SECTION 01300. REFER TO ELECTRICAL DRAWINGS FOR LIGHTING REQUIREMENTS.
3. PROVIDE A REVEAL DRYWALL JUMP AT ALL LOCATIONS WHERE GYPSUM BOARD IS REVEALED. REFER TO DETAIL 4-A9.1. REFER TO SPEC SECTION 09250. OTHERWISE, REFER TO DETAIL 4-A9.1. REFER TO SPEC SECTION 09250.
4. PROVIDE A SHADOW MOLDING AT THE FULL PERIMETER OF ALL ACOUSTICAL CEILING TILE (ACT) CEILING. TYPICAL UNLESS NOTED OTHERWISE. REFER TO DETAIL 9-A9.1. REFER TO SPECIFICATION SECTION 09310.

REFLECTED CEILING PLAN LEGEND

- LIGHT FIXTURE - REFER TO ELECTRICAL
- SPEAKER - REFER TO ELECTRICAL
- LOUVER/GRILLE - REFER TO MECHANICAL
- SLOT DIFFUSER - REFER TO MECHANICAL
- ACOUSTICAL CEILING TILE (ACT) - REFER TO ROOM FINISH SCHEDULE FOR TYPES
- GYPSUM WALLBOARD (GWB)
- EXTERIOR INSULATION FINISH SYSTEM (EIFS)
- CEMENT PLASTER (PLAS)
- SPRAY-ON ACOUSTICAL INSULATION (SAI)
- OVER GLASS FIBER REINFORCED GYPSUM UNITS
- PAINTED EXPOSED STRUCTURE (PES)
- CONTROL JOINT REFER TO DETAIL 12-A9.2

ROOM LEGEND "C1"

ROOM NO.	ROOM NAME	AREA S.F.	CEILING HEIGHT
C101	SCIENCE LAB	1509	9' VARIES
C102	SCIENCE LAB	1441	9' VARIES
C103	SCIENCE LAB	1441	9' VARIES
C104	SCIENCE LAB	1441	9' VARIES
C105	SCIENCE LAB	1441	9' VARIES
C106	SCIENCE LAB	1441	9' VARIES
C107	SCIENCE LAB	1508	9' VARIES

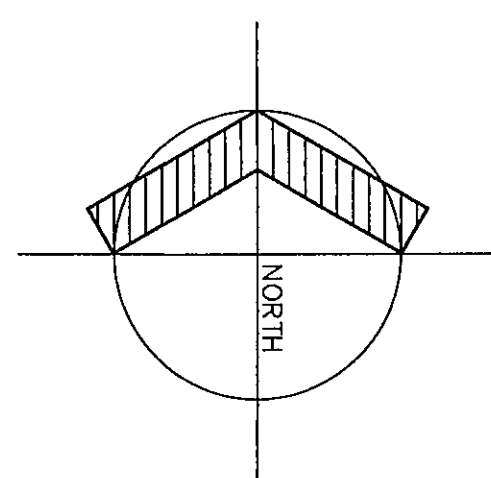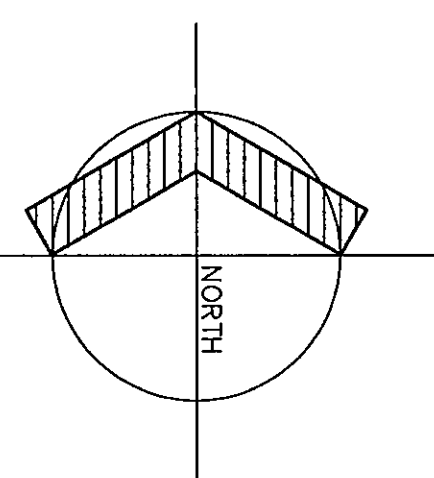

01-A-151


CEILING PLAN UNIT C1 & C2

DRAWN BY: GJE COMM. NO.: 95067.00
 CHECKED BY: JHJ DATE: APRIL 21, 1997

A9.5

REVISIONS NO. DATE

Fanning/Howey Associates, Inc.
 Architects Engineers Consultants

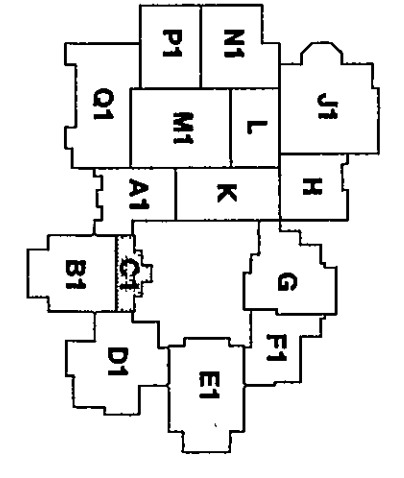

THE NEW
CHESTERTON HIGH SCHOOL
 FOR THE
 DUNELAND SCHOOL CORPORATION
 CHESTERTON, INDIANA

COPYRIGHT 1997 BY FANNING/HOWEY ASSOCIATES, INC.