
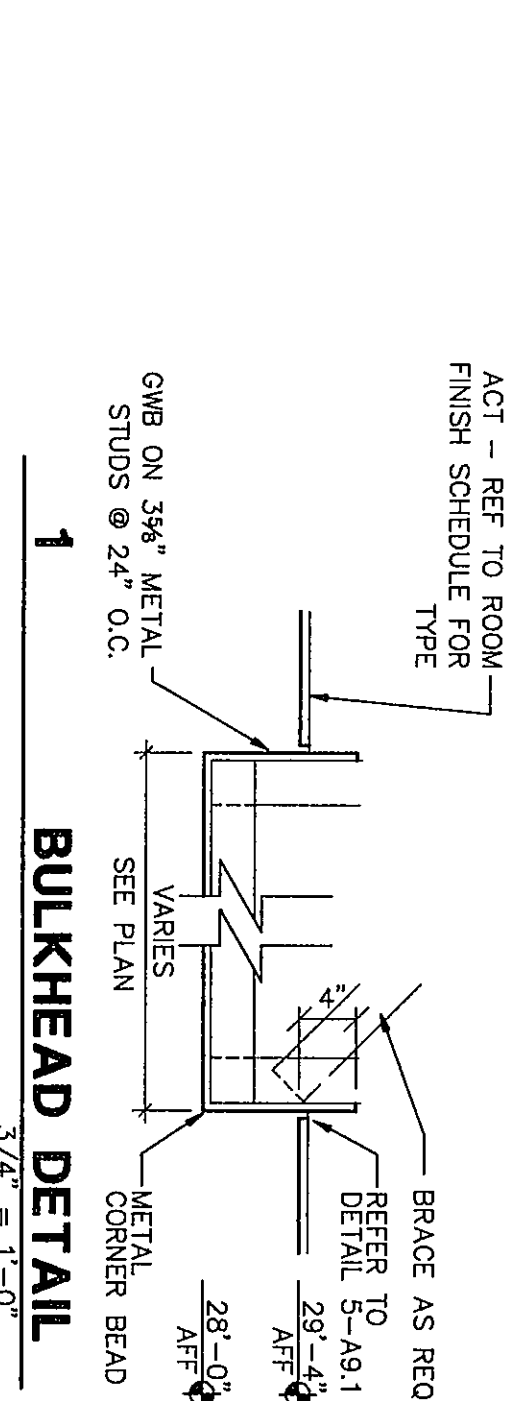
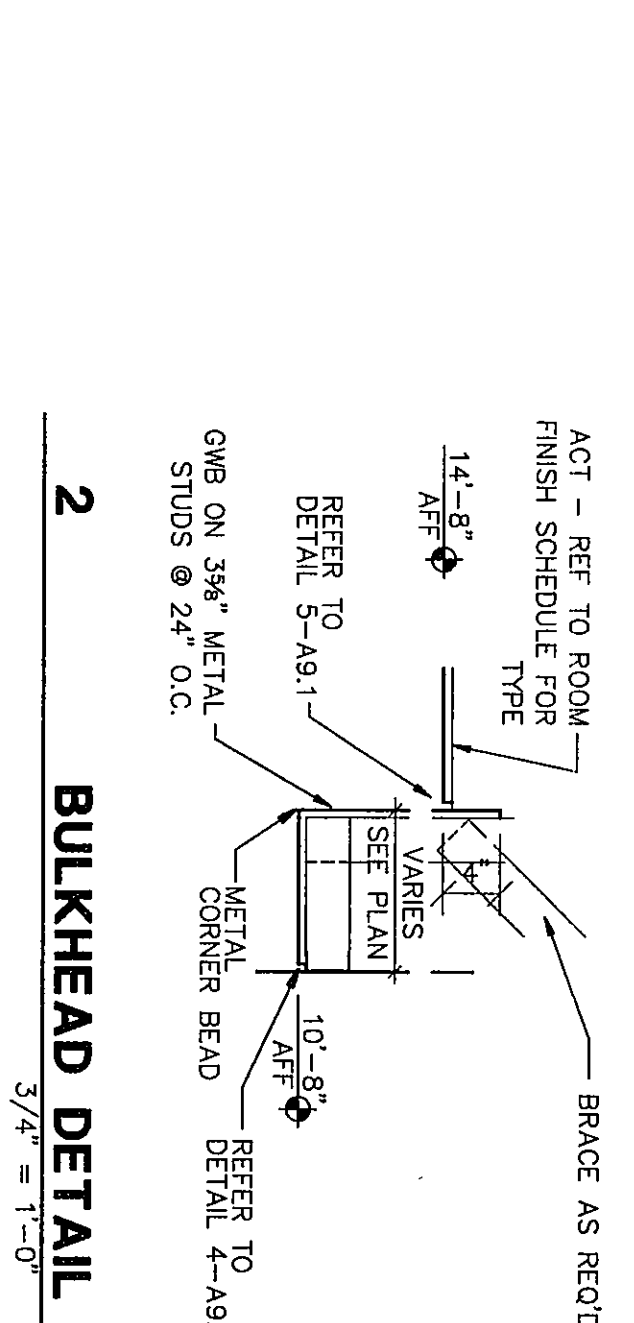


ROOM NO.	ROOM NAME	AREA S.F.	CEILING HEIGHT
J201	MECHANICAL MEZZANINE	808	9'-4"
J202	LIGHT SPOT ROOM	234	9'-4"
J203	BALCONY	112	VARIES
J204	STORAGE ROOM	112	VARIES
J205	BALCONY	112	VARIES
J206	LIGHT SPOT ROOM	234	9'-4"
J207	ELECTRICAL ROOM	225	---


REFLECTED CEILING PLAN LEGEND

- LIGHT FIXTURE - REFER TO ELECTRICAL
- SPEAKER - REFER TO ELECTRICAL
- LOUVER/GRILLE - REFER TO MECHANICAL
- SLOT DIFFUSER - REFER TO MECHANICAL
- ACOUSTICAL CEILING TILE (ACT) - REFER TO ROOM FINISH SCHEDULE FOR TYPES
- GYPSUM WALLBOARD (GWB)
- EXTERIOR INSULATION FINISH SYSTEM (EIFS)
- CEMENT PLASTER (PLAS)
- SPRAY-ON ACOUSTICAL INSULATION (SAI)
- OVER GLASS FIBER REINFORCED GYPSUM UNITS
- PAINTED EXPOSED STRUCTURE (PES)
- CONTROL JOINT REFER TO DETAIL 12-A9.2

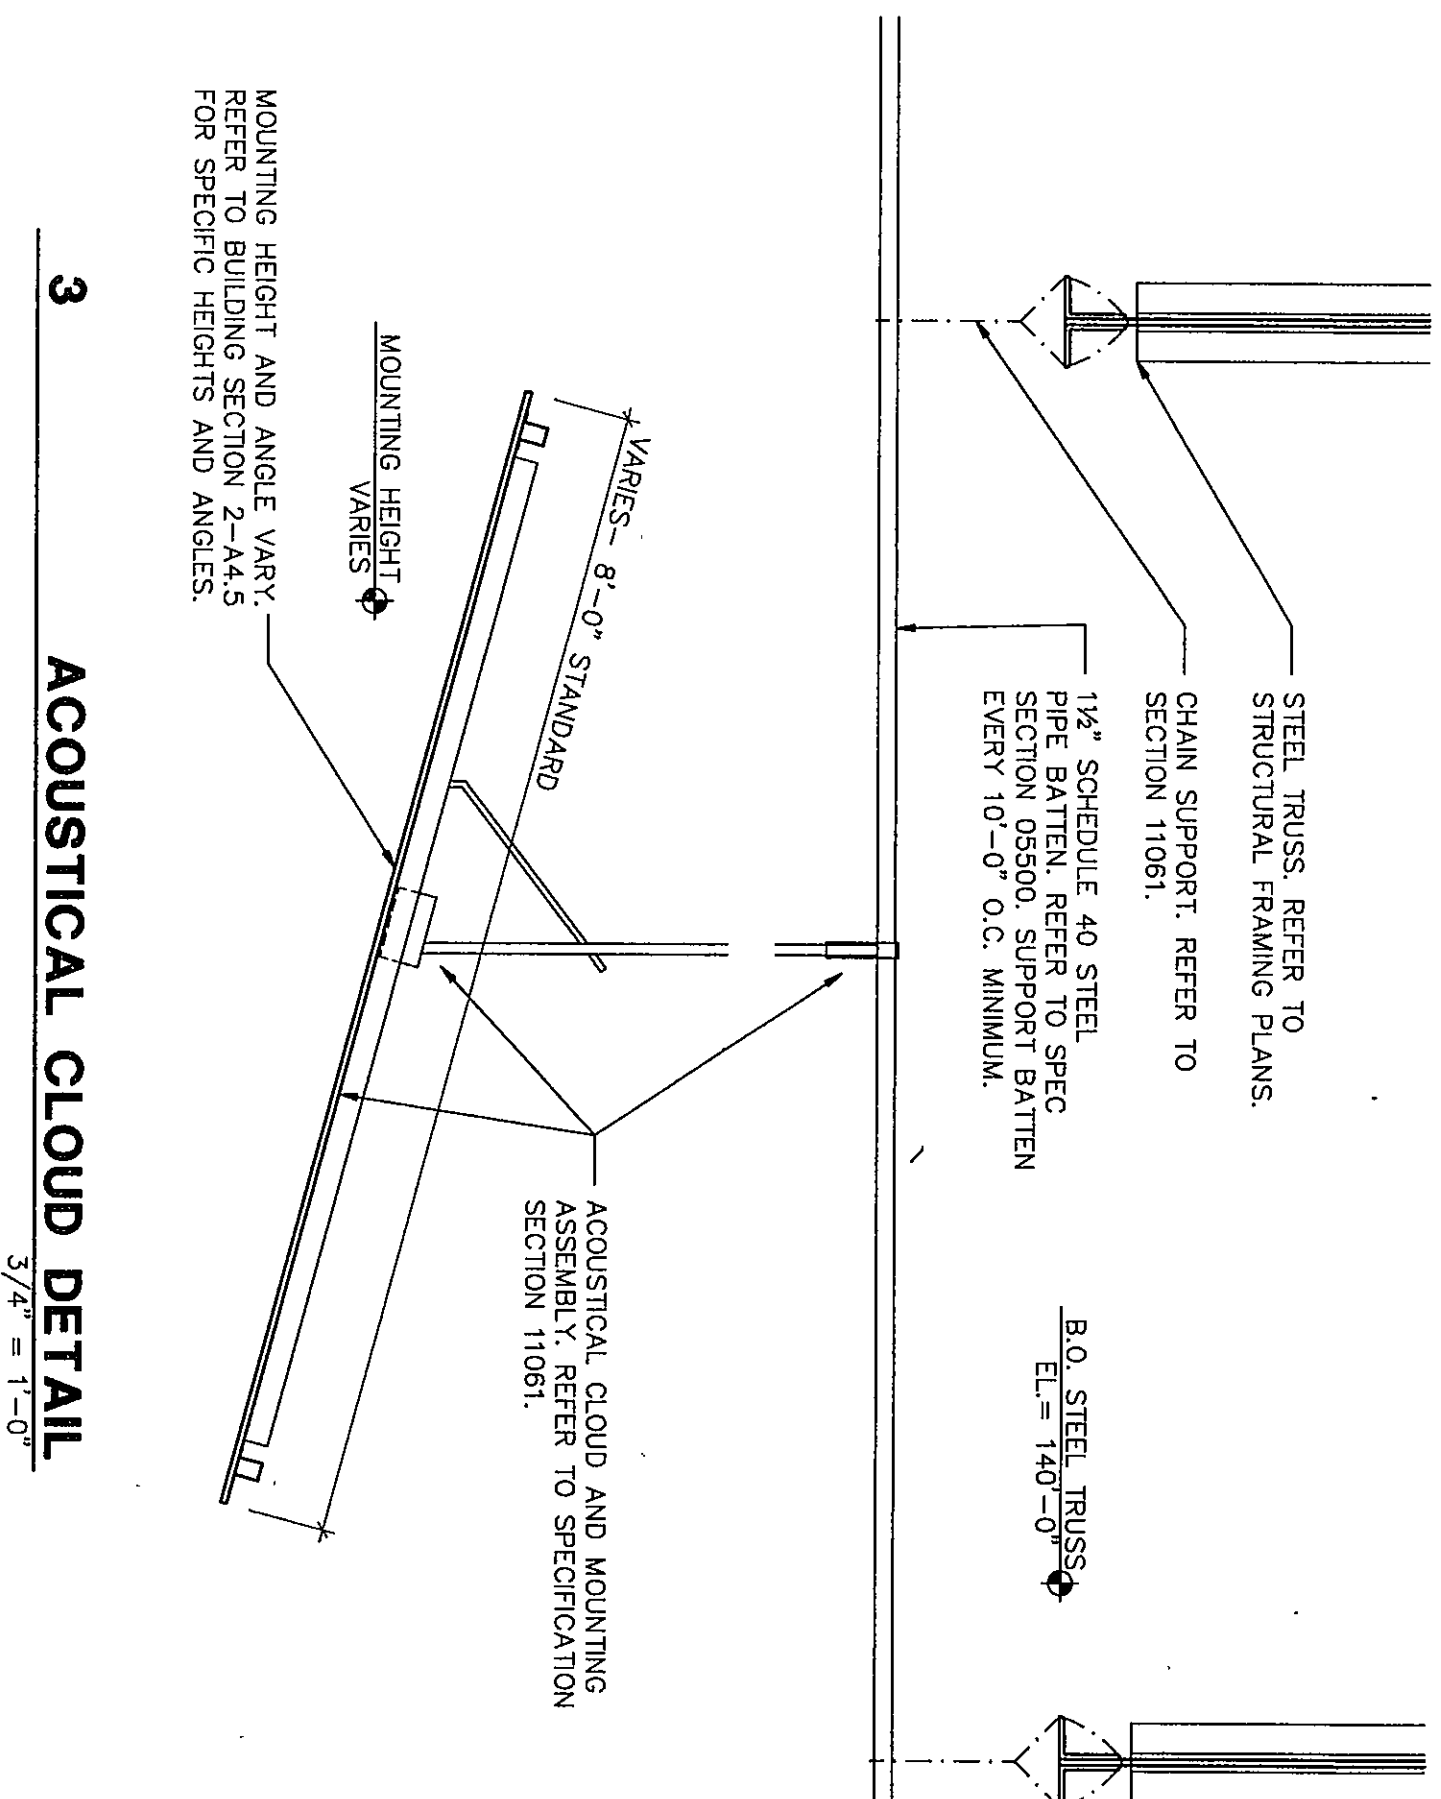


GENERAL CEILING NOTES

1. ALTERNATE --- SLOPED CEILINGS, PROJECTION SURFACES, AND LIGHTING SIMILAR TO DETAIL 5-A9.1 ARE TO BE PROVIDED UNDER AN ALTERNATIVE BID. TYPICAL AT CLASSROOM LOCATIONS UNLESS NOTED OTHERWISE. REFER TO ALTERNATIVES SPECIFICATION SECTION 01030.
2. UNDER THE BASE BID, PRONGE LEVEL CEILING GRIDS AT 9'-4" A.F.F. WITHOUT SLOPED PROJECTION SURFACES IN CLASSROOMS. TYPICAL AT CLASSROOM LOCATIONS UNLESS NOTED OTHERWISE. REFER TO ELECTRICAL DRAWINGS FOR LIGHTING REQUIREMENTS.
3. PROVIDE A RIGID DRYWALL TRIM AT ALL LOCATIONS WHERE GYPSUM WALLBOARD (GWB) ABUTS A DISSIMILAR MATERIAL. TYPICAL UNLESS NOTED OTHERWISE. REFER TO DETAIL 4-A9.1. REFER TO SPEC SECTION 09250.
4. PROVIDE A SHADOW MOLDING AT THE FULL PERIMETER OF ALL ACOUSTICAL CEILING TILE (ACT) CEILINGS. TYPICAL UNLESS NOTED OTHERWISE. REFER TO DETAIL 5-A9.1. REFER TO SPECIFICATION SECTION 09510.

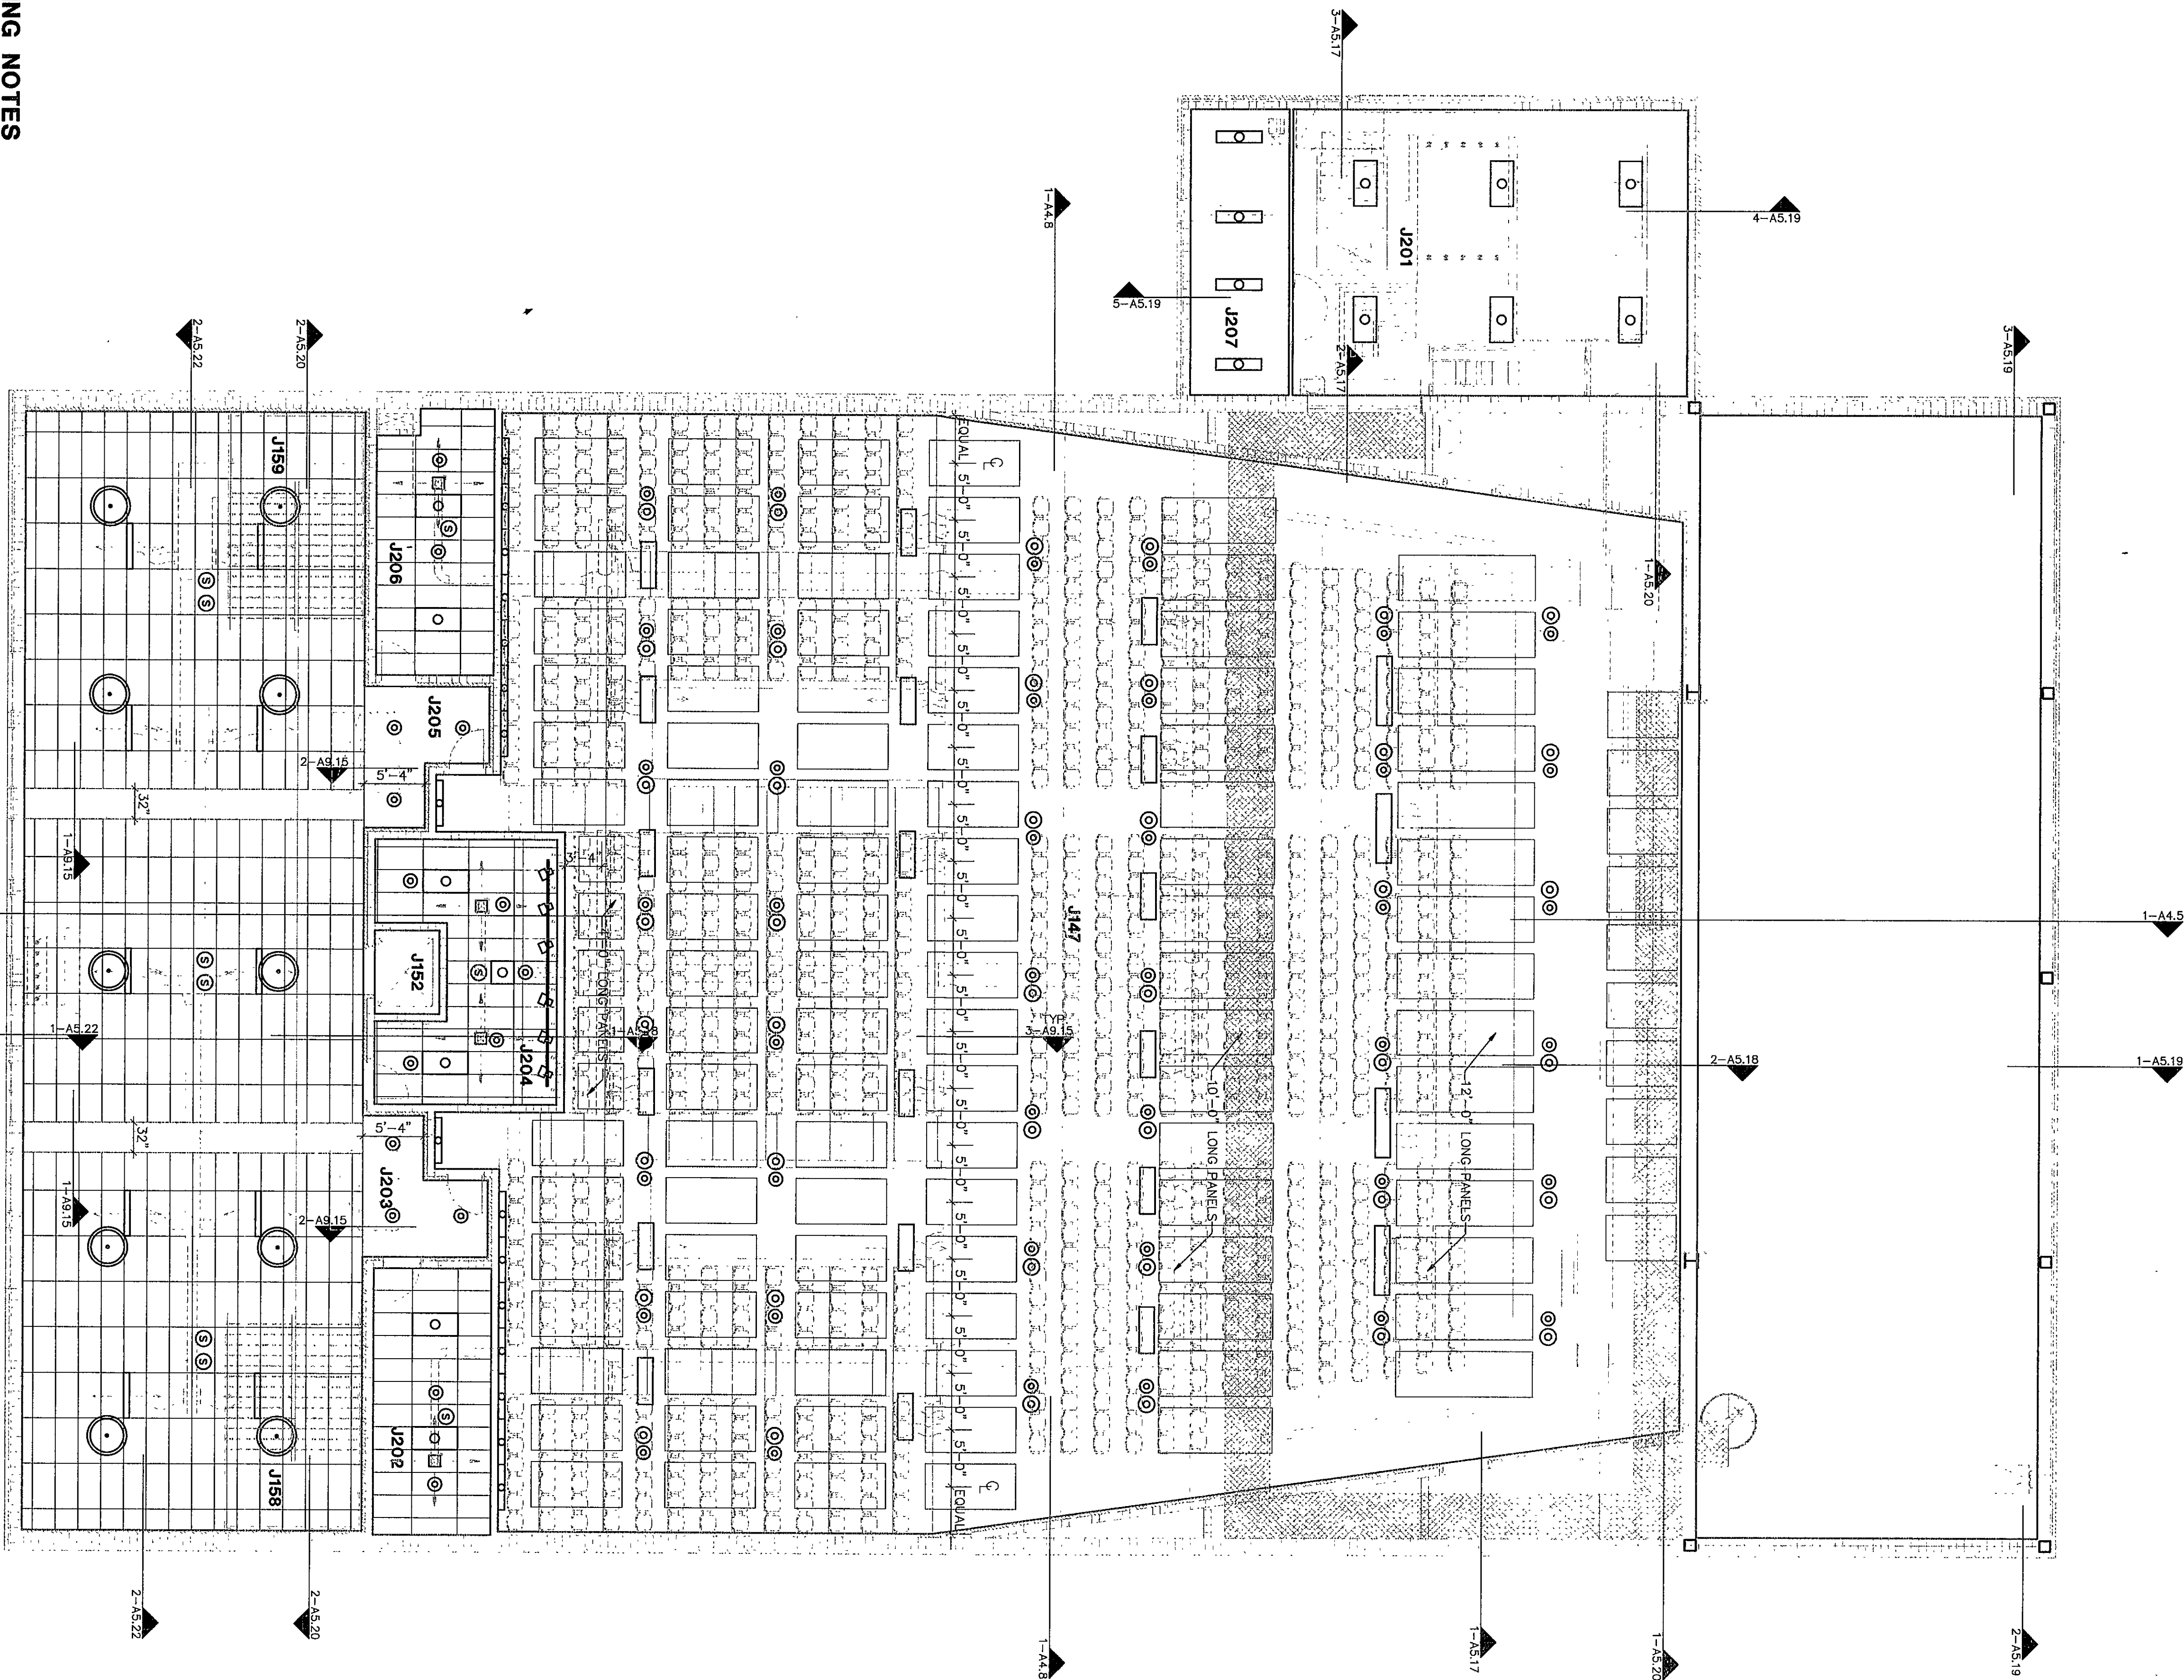

CEILING PLAN UNIT J2

1/4" = 1'-0"

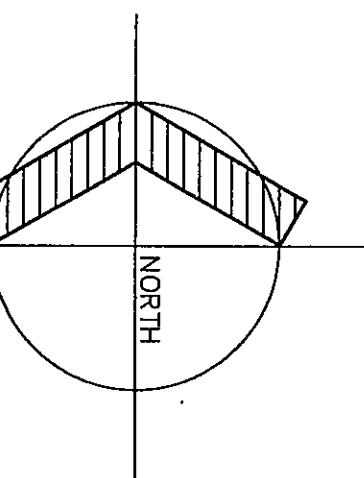

CEILING PLAN UNIT J2

DRAWN BY: CJE

CHECKED BY: JHJ

COMM. NO.: 95067.00

DATE: APRIL 21, 1997

A9.15

REVISIONS NO. DATE

Fanning/Howey

Associates, Inc.

Architects

Engineers

Consultants

THE NEW

CHESTERTON HIGH SCHOOL

FOR THE

DUNELAND SCHOOL CORPORATION

CHESTERTON, INDIANA

COPYRIGHT 1997 BY FANNING/HOWEY ASSOCIATES, INC.

ARCHITECT

1997

ENGINEER

1997