


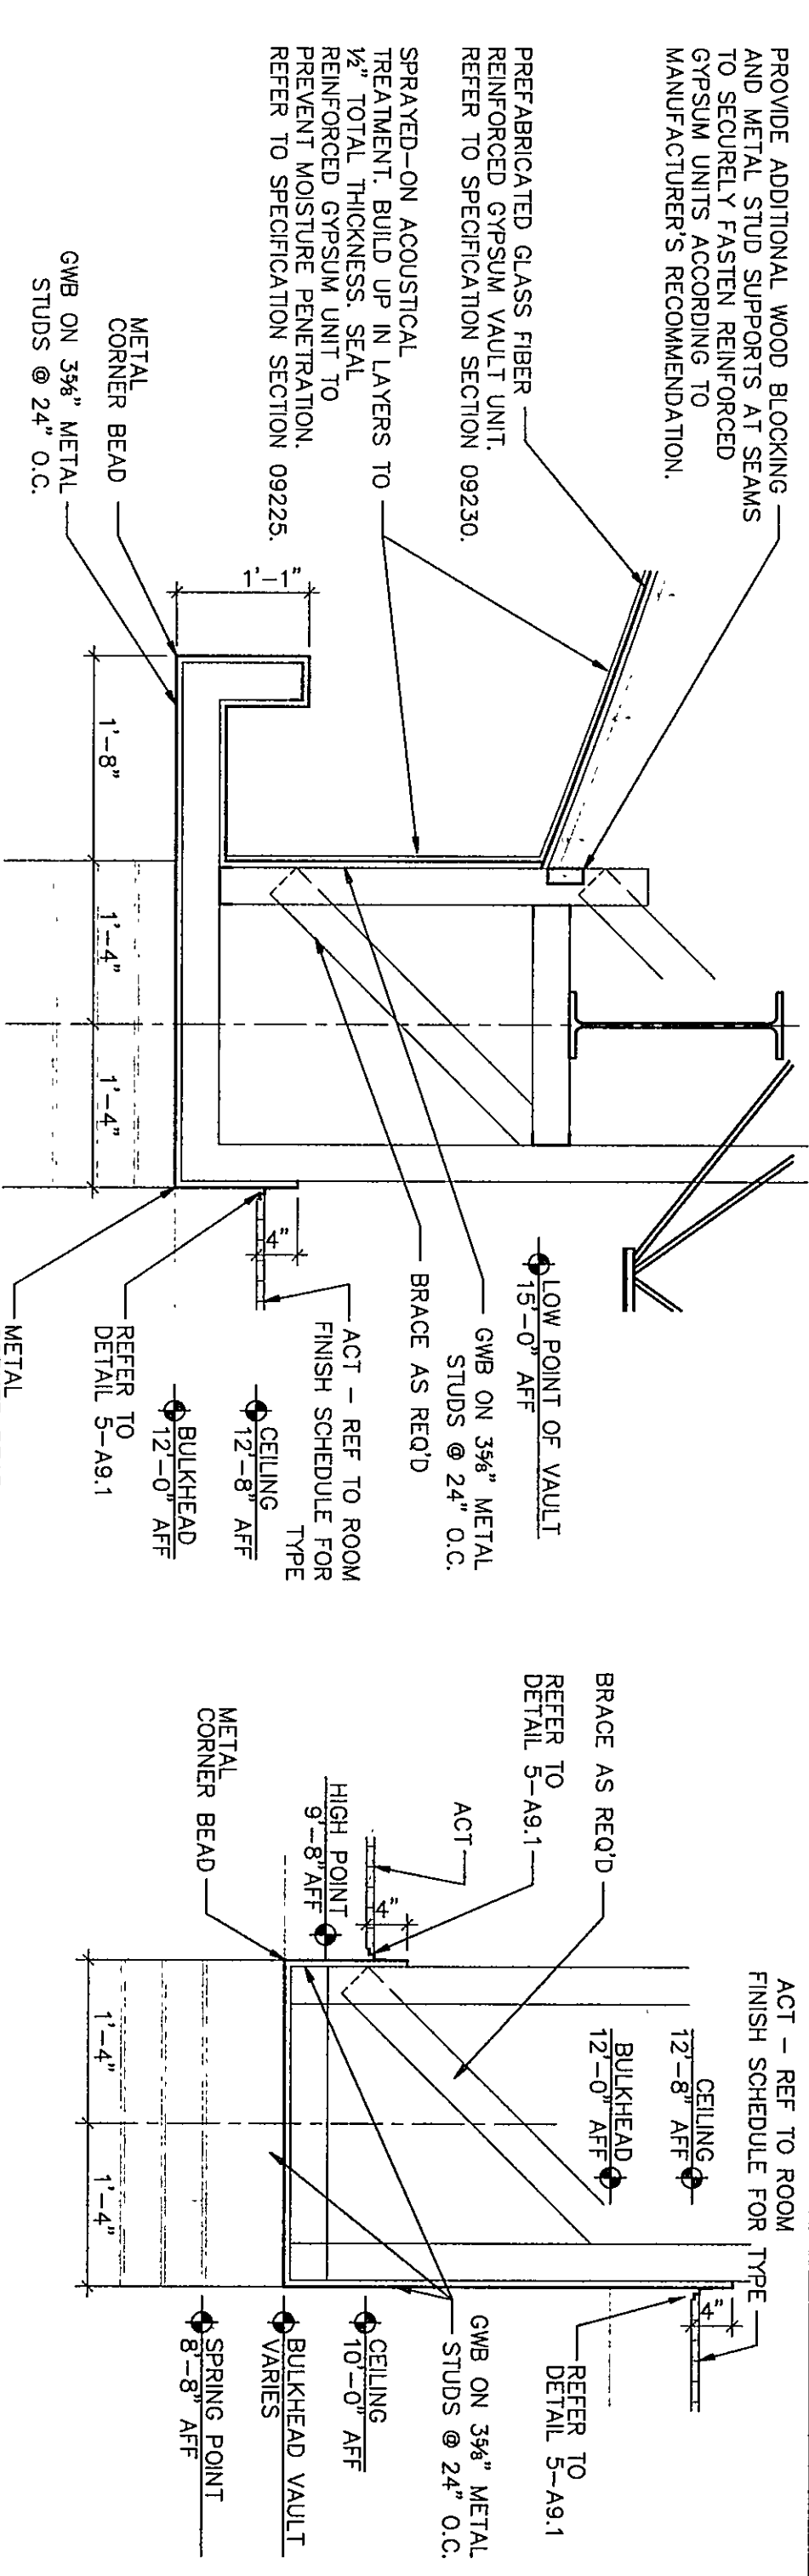


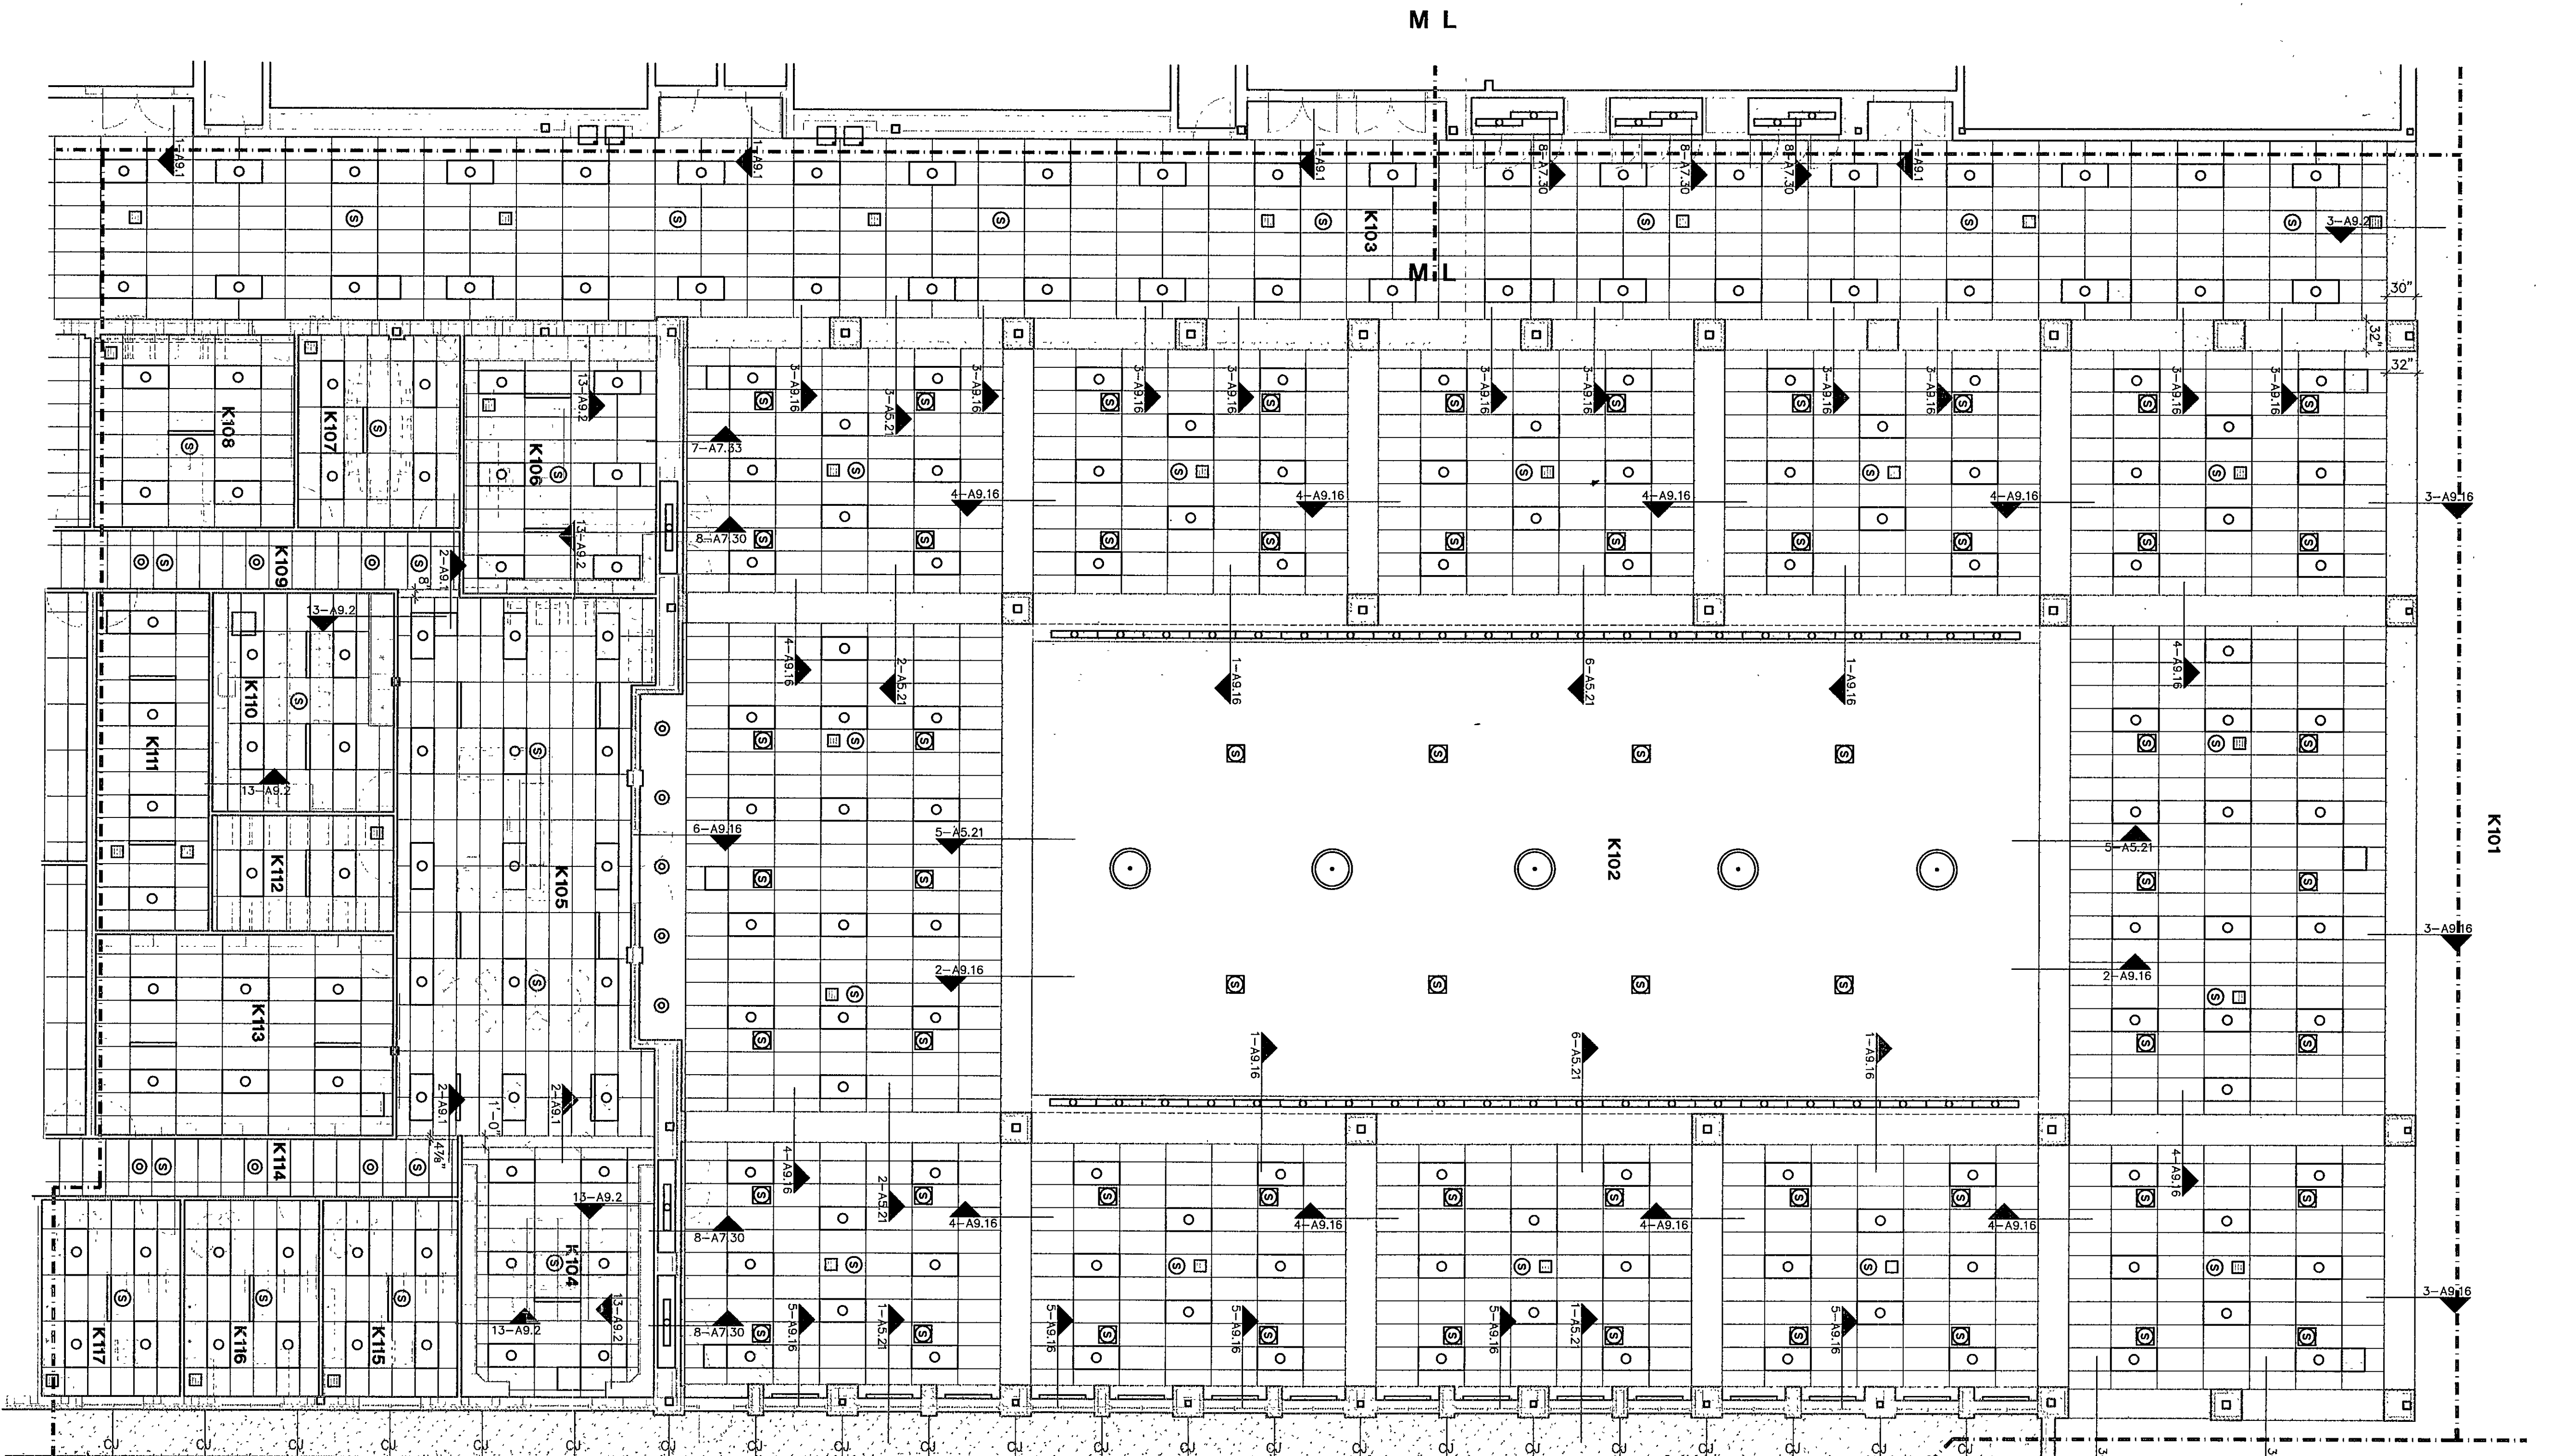


1
BULKHEAD DETAIL
3/4" = 1'-0"

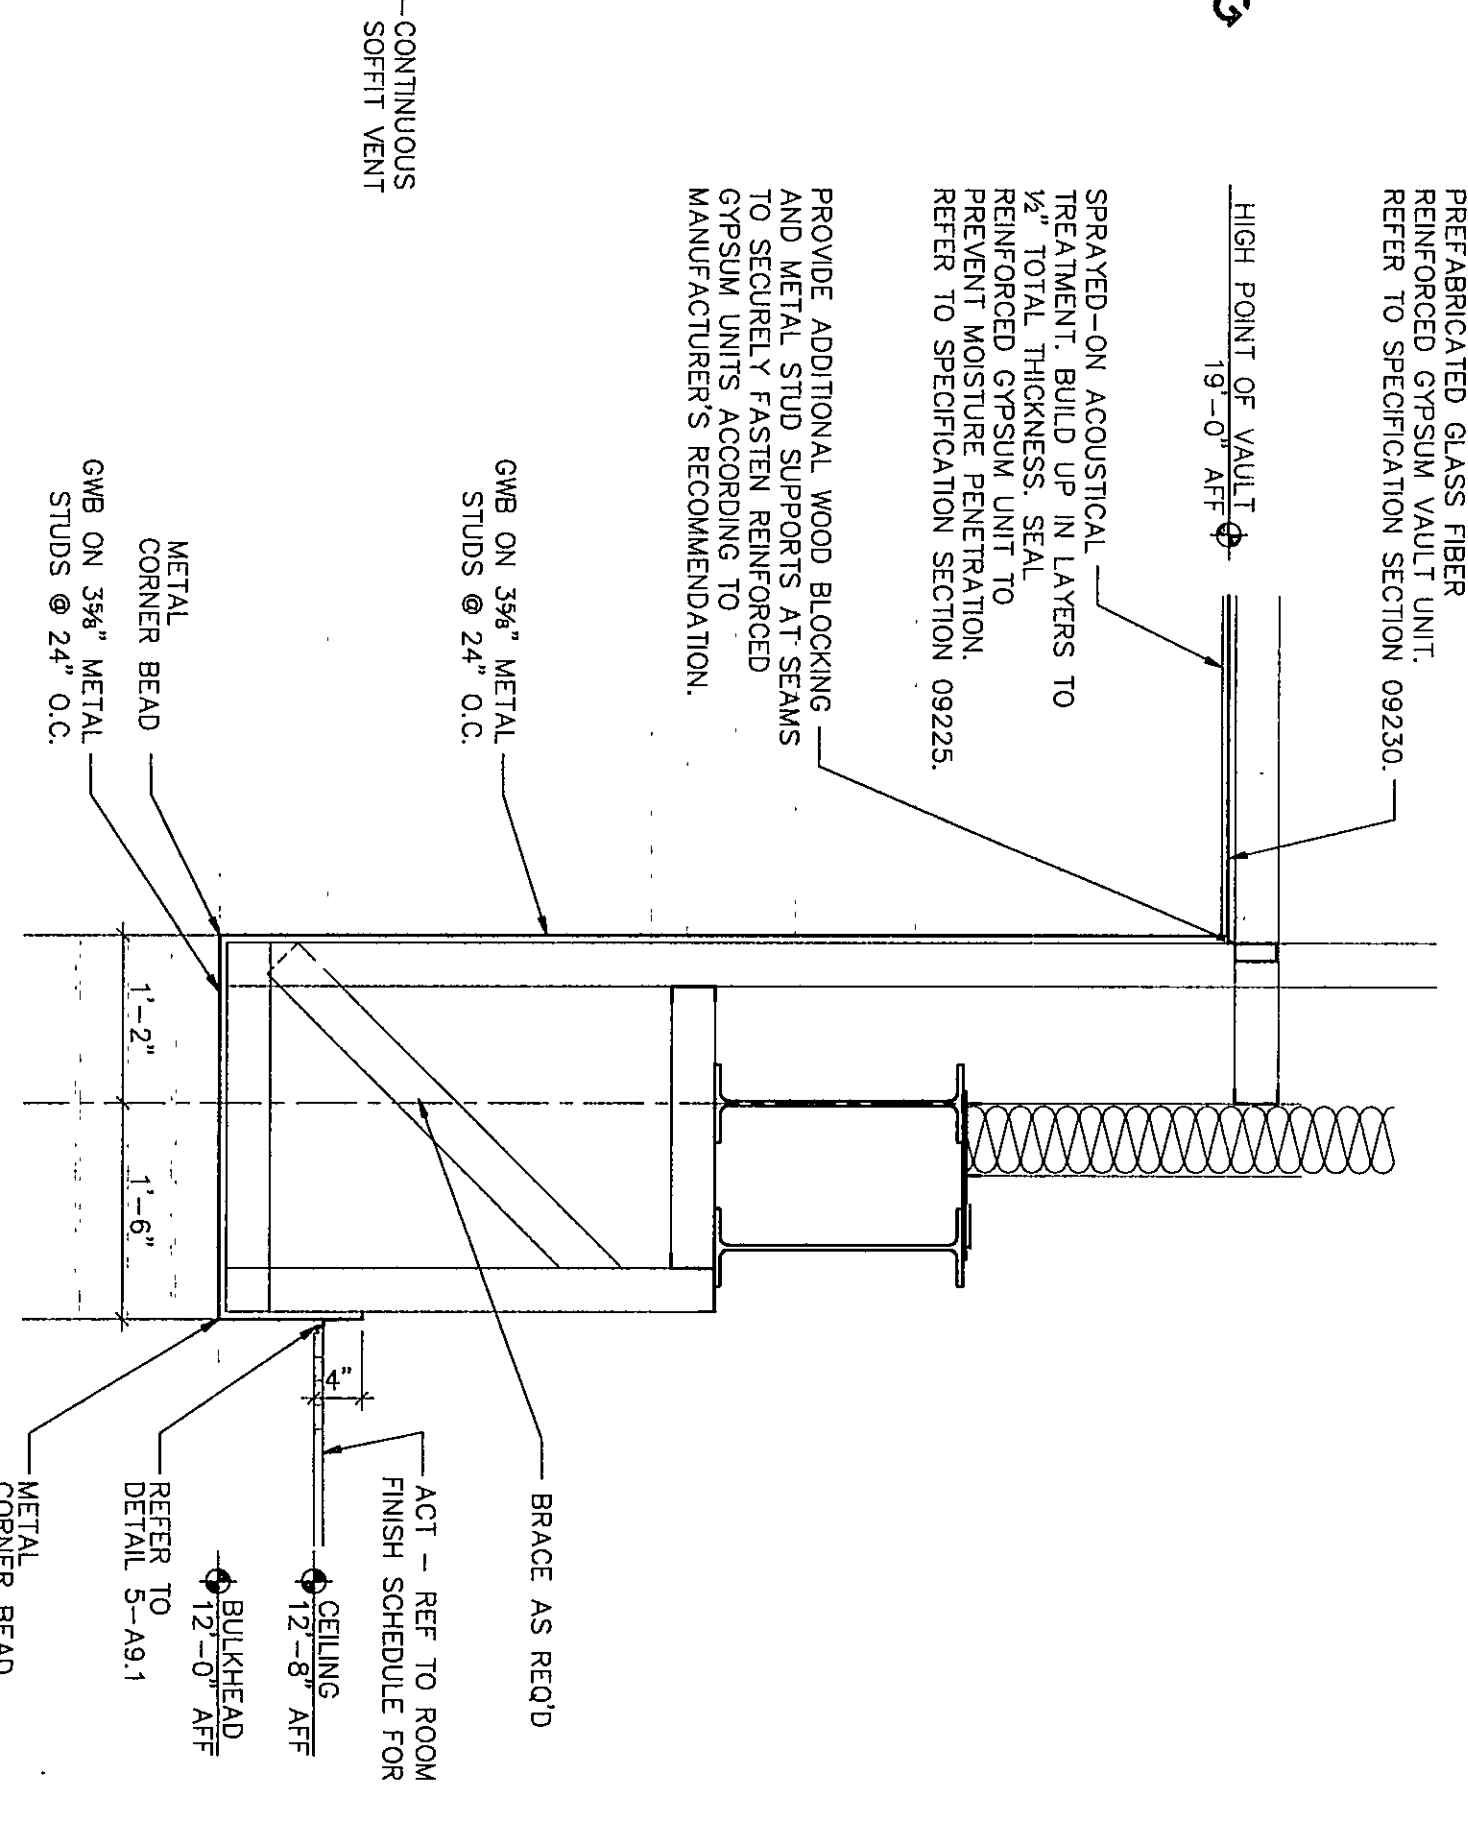


2
BULKHEAD DETAIL
3/4" = 1'-0"

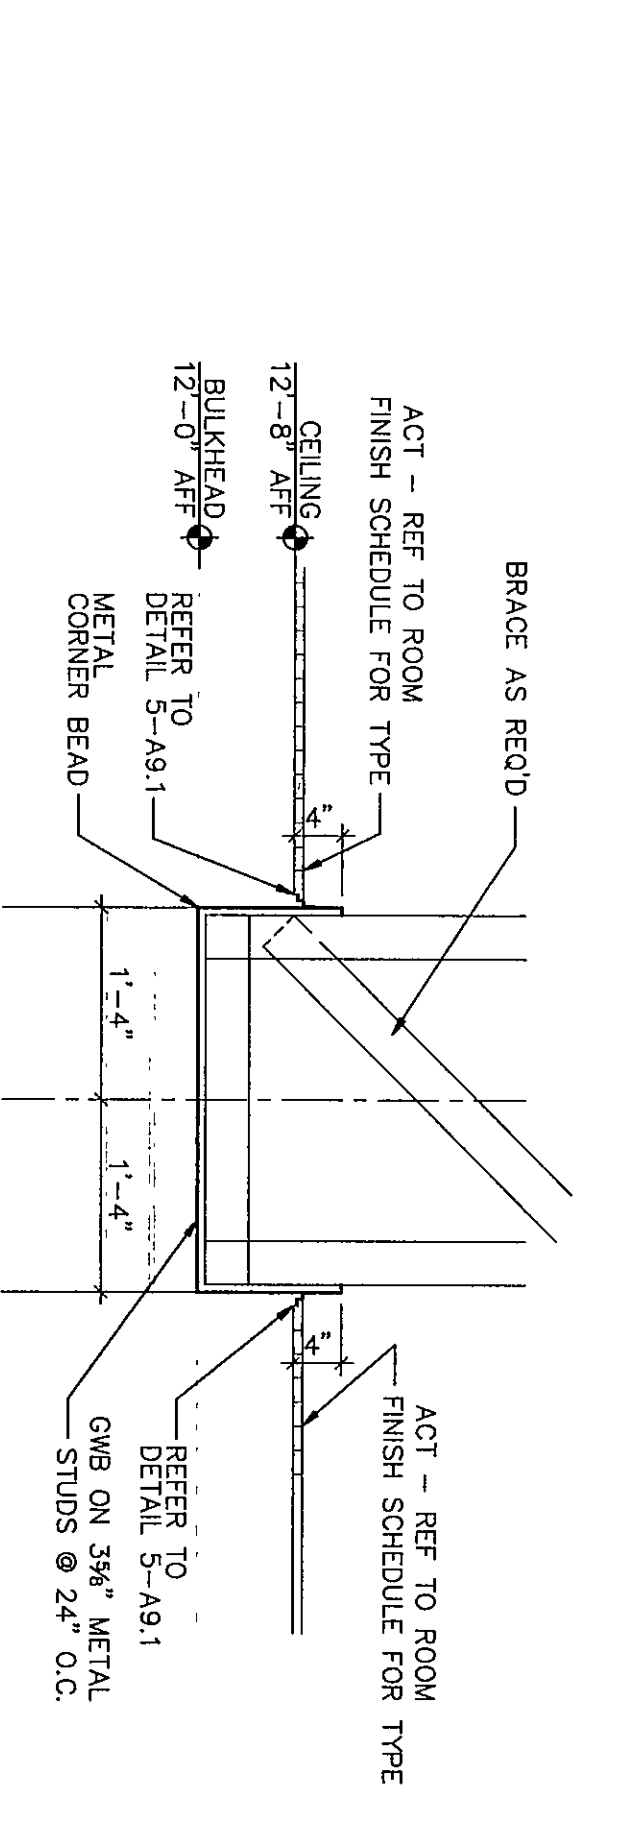


3
BULKHEAD DETAIL
3/4" = 1'-0"

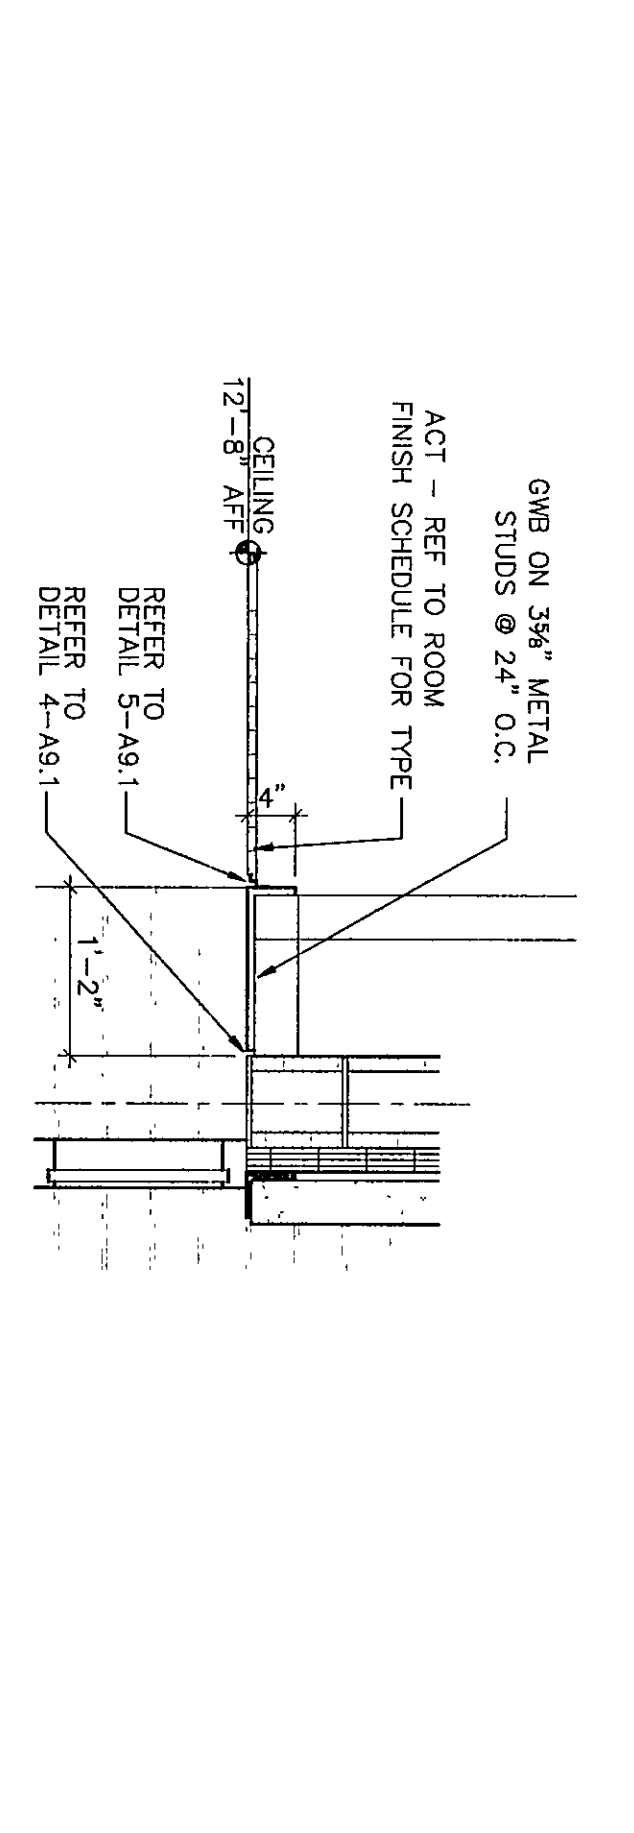

4
BULKHEAD DETAIL
3/4" = 1'-0"

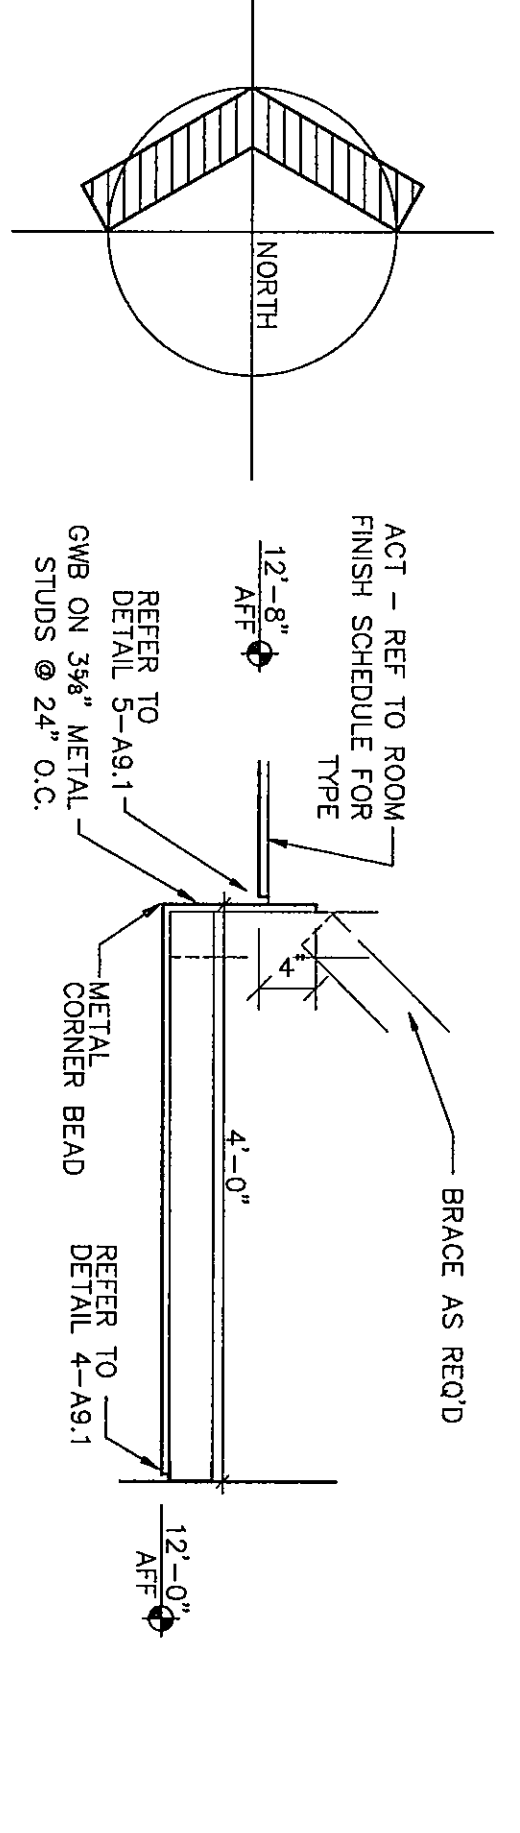

5
BULKHEAD DETAIL
3/4" = 1'-0"

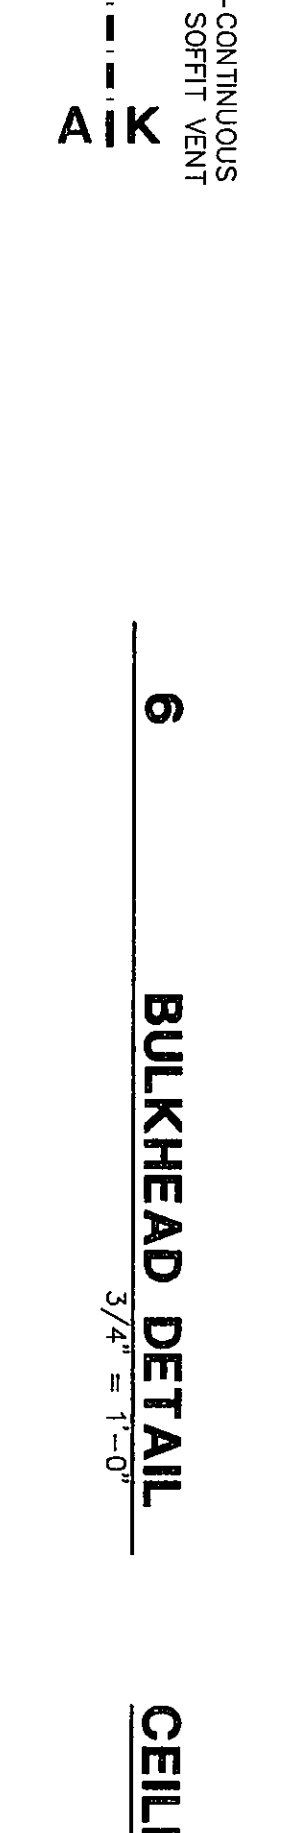

6
BULKHEAD DETAIL
3/4" = 1'-0"

ROOM LEGEND "K"

ROOM NO.	ROOM NAME	AREA	CEILING HEIGHT
K101	NOT USED	1366	WARS
K102	STUDENT DINING	378	9'-4"
K103	RESOURCE/CAREER CENTER	378	9'-4"
K104	RECEPTIONIST	96	9'-4"
K105	RECEPTIONIST	96	9'-4"
K106	CONFERENCE	233	9'-4"
K107	CONFERENCE	233	9'-4"
K108	SECRETARY	261	9'-4"
K109	SECRETARY	261	9'-4"
K110	WORKROOM	288	9'-4"
K111	STORAGE	288	9'-4"
K112	STORAGE	288	9'-4"
K113	CENTRAL STORAGE	446	9'-4"
K114	CORRIDOR OFFICE	155	9'-4"
K115	CORRIDOR OFFICE	155	9'-4"
K116	CORRIDOR OFFICE	188	9'-4"
K117	CORRIDOR OFFICE	204	9'-4"

REFLECTED CEILING PLAN LEGEND

	LIGHT FIXTURE - REFER TO ELECTRICAL
	SPEAKER - REFER TO ELECTRICAL
	LOUVER/GRILLE - REFER TO MECHANICAL
	SLOT DIFFUSER - REFER TO MECHANICAL
	ACOUSTICAL CEILING TILE (ACT) - REFER TO ROOM FINISH SCHEDULE FOR TYPES
	GYPSUM WALLBOARD (GWB)
	EXTERIOR INSULATION FINISH SYSTEM (EIFS)
	CEMENT PLASTER (PLAS)
	PAINTED EXPOSED STRUCTURE (PES)
	CONTROL JOINT REFER TO DETAIL 12-A9.2

GENERAL CEILING NOTES

1. ALTERNATE - SLOPED CEILING PROJECTION SURFACES AND LIGHTING SIMILAR TO DETAIL 12-A9.1 ARE TO BE PROVIDED UNLESS AN ALTERNATIVE BID. TYPICAL AT CLASSROOM LOCATIONS UNLESS NOTED OTHERWISE. REFER TO ALTERNATIVES SPECIFICATION SECTION 0100.
2. UNLESS NOTED OTHERWISE, PROVIDE LEVEL CEILING GRIDS AT 9'-4" A.F.F. AT CLASSROOM LOCATIONS UNLESS NOTED OTHERWISE. TYPICAL AT CLASSROOM LOCATIONS UNLESS NOTED OTHERWISE. REFER TO ELECTRICAL DRAWINGS FOR LIGHTING REQUIREMENTS.
3. PROVIDE A REVIEW DETAIL FROM AT ALL LOCATIONS WHERE GYPSUM WALLBOARD IS USED TO PROVIDE FINISH SCHEDULE FOR TYPE. REFER TO DETAIL 12-A9.1.
4. PROVIDE A SHADOW WARDING AT THE FULL PERIMETER OF ALL ACOUSTICAL CEILING TILE (ACT) CEILING. TYPICAL UNLESS NOTED OTHERWISE. REFER TO DETAIL 12-A9.1. REFER TO SPECIFICATION SECTION 09510.


CEILING PLAN UNIT K

DRAWN BY: GJE COMM. NO.: 95067.00
CHECKED BY: JHJ DATE: APRIL 21, 1997

A9.16

REVISIONS NO. DATE

Fanning/Howey Associates, Inc.
Architects Engineers Consultants

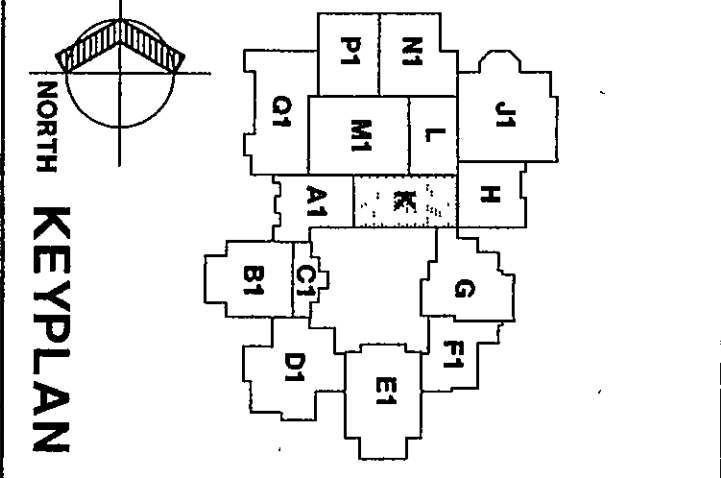

THE NEW CHESTERTON HIGH SCHOOL FOR THE DUNELAND SCHOOL CORPORATION CHESTERTON, INDIANA

COPYRIGHT 1997 BY FANNING/HOWEY ASSOCIATES, INC.