

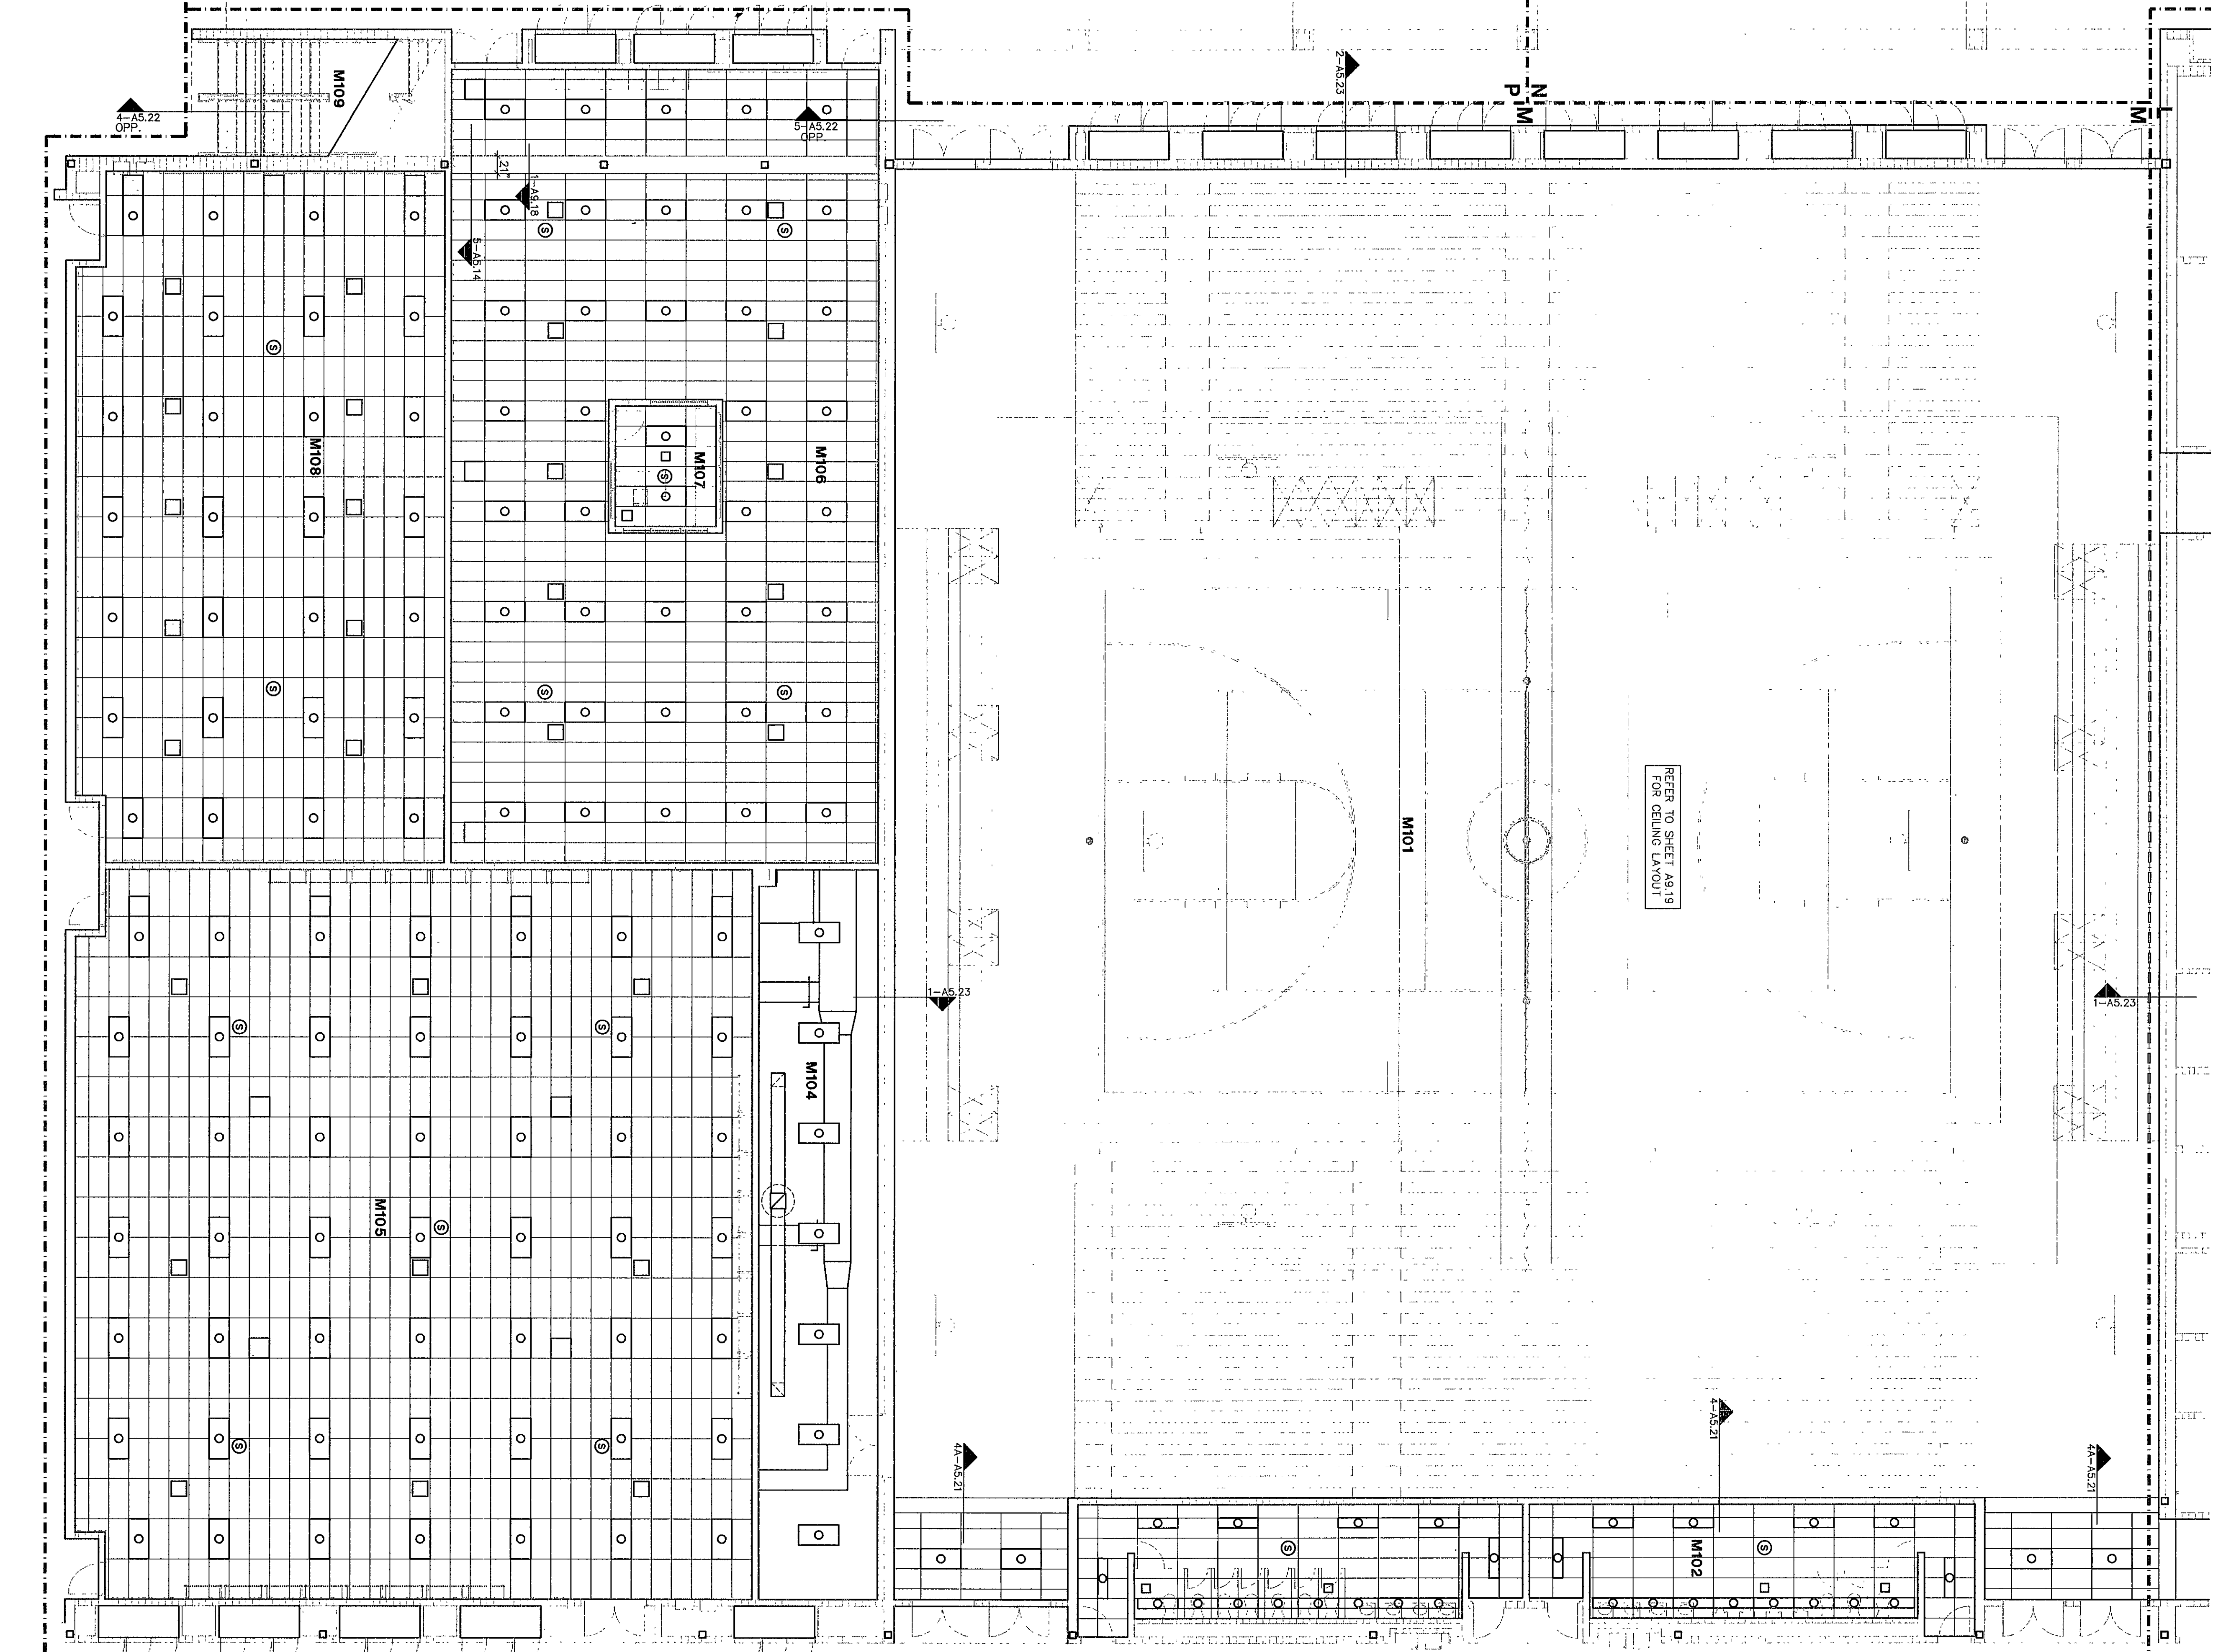
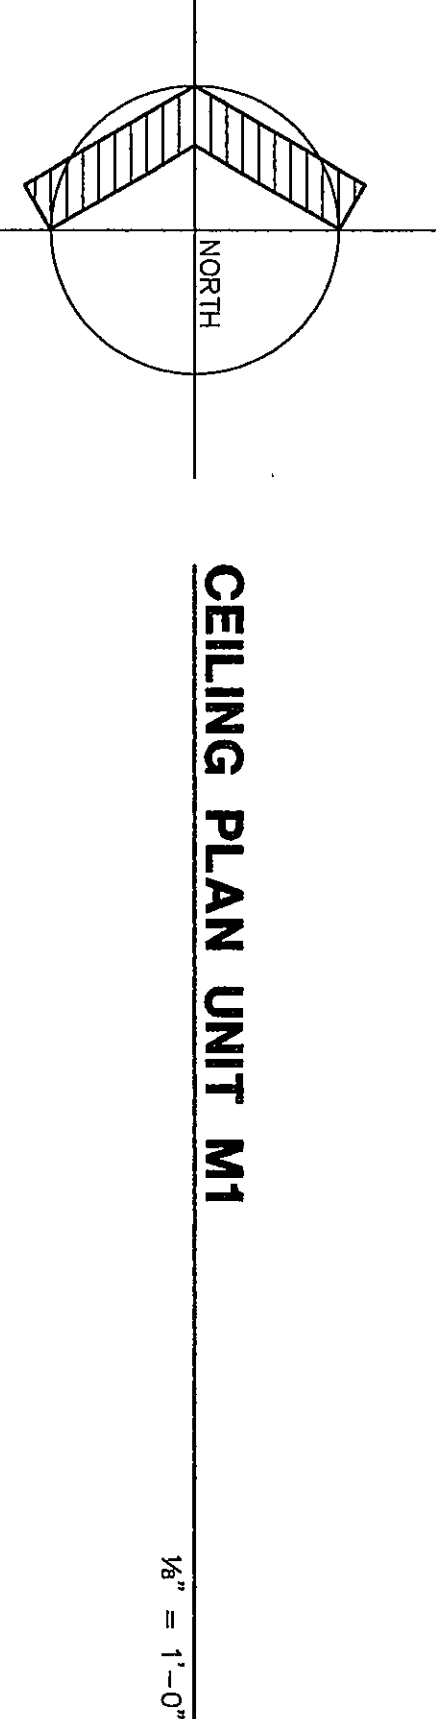


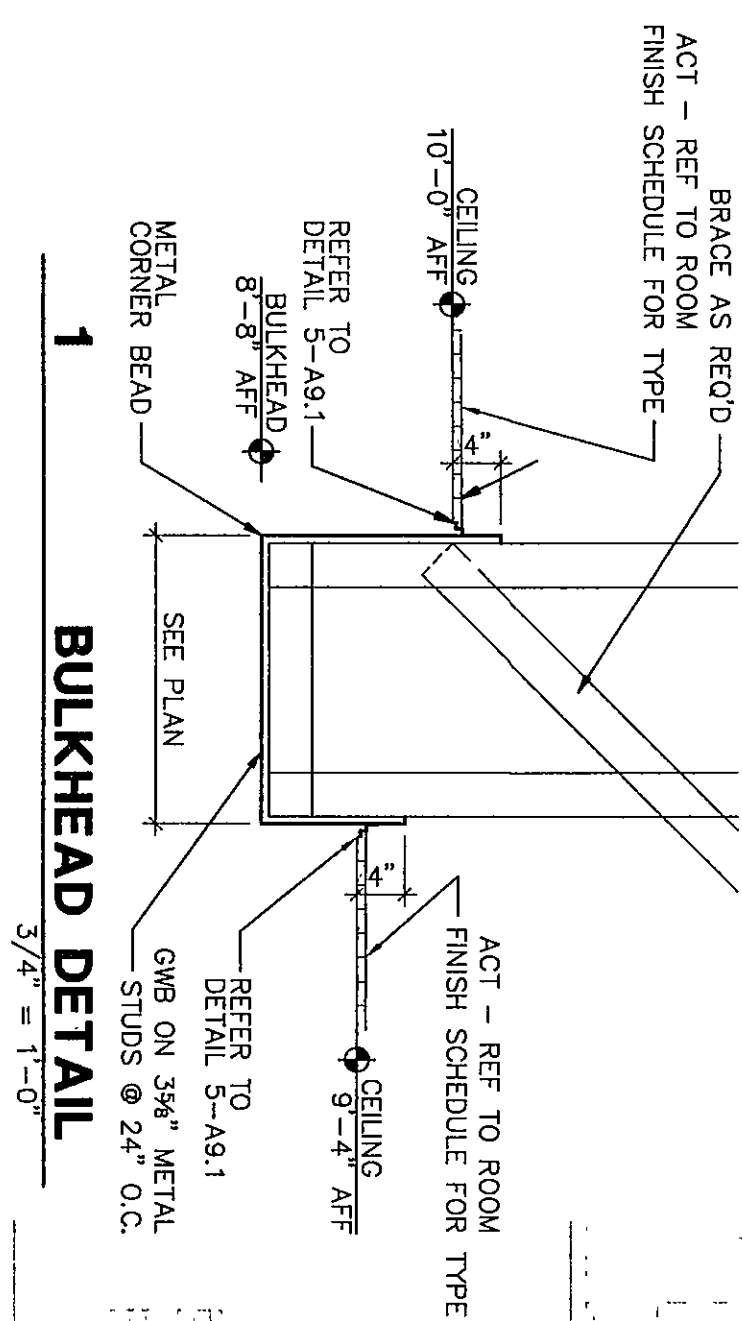

ROOM LEGEND "M"


ROOM NO.	ROOM NAME	AREA S.F.	CEILING HEIGHT
M101	GYMNASIUM	17084	9'-4"
M102	MEN'S TOILET	442	9'-4"
M103	WOMEN'S TOILET	442	9'-4"
M104	STORAGE	853	10'-0"
M105	OFFICE	3241	10'-0"
M106	OFFICE	1205	9'-6"
M107	OFFICE	1205	9'-6"
M108	OFFICE	1205	9'-6"
M109	OFFICE	1205	9'-6"
M110	OFFICE	1205	9'-6"

REFLECTED CEILING PLAN LEGEND

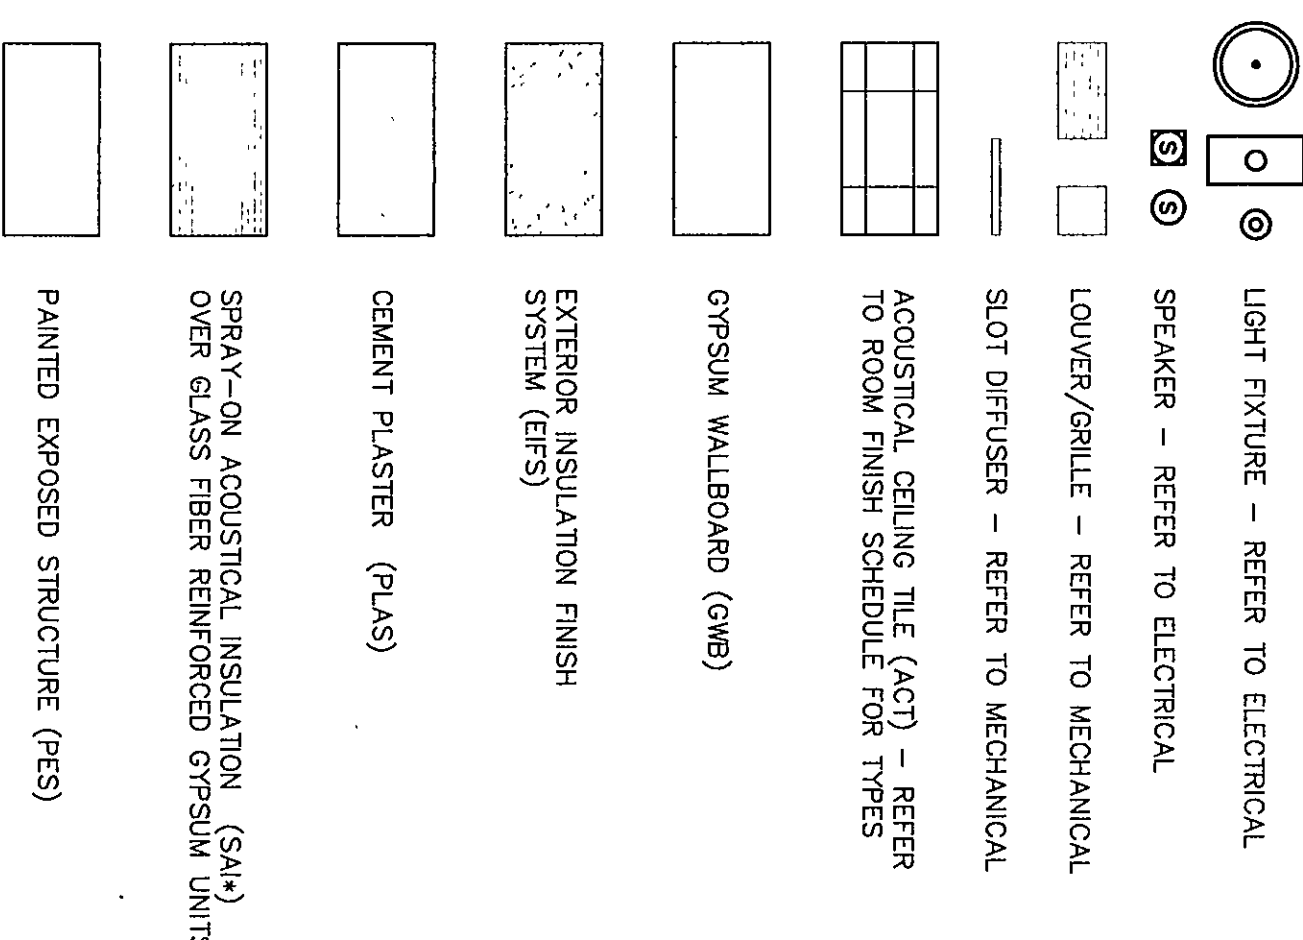


GENERAL CEILING NOTES

1. ALTERNATE - SLOPED CEILING PROJECTION SURFACES AND LIGHTING SIMILAR TO DETAIL 12-A9.1 ARE TO BE PROVIDED UNDER AN ALTERNATIVE BID. TYPICAL AT CLASSROOM LOCATIONS UNLESS NOTED OTHERWISE. REFER TO ALTERNATIVES SPECIFICATION SECTION 01030.
2. UNDER THE BASE BID, PROVIDE LEAK-CEILING GROSS AT 9'-4" A.F.F. WITH 1/2" MINIMUM SLOPE FOR DRAINAGE. PROVIDE TYPICAL AT CLASSROOM LOCATIONS UNLESS NOTED OTHERWISE. REFER TO ELECTRICAL DRAWINGS FOR DRAINAGE RECOMMENDATIONS.
3. PROVIDE A REVEAL DRAWING, TYPICAL AT ALL LOCATIONS WHERE GYPSUM OR OTHER FINISHES ARE TO BE APPLIED. PROVIDE TYPICAL AT CLASSROOM LOCATIONS UNLESS NOTED OTHERWISE. REFER TO DETAIL 4-A9.1. REFER TO SPEC SECTION 09220.
4. PROVIDE A SHOWN JOINT AT THE FULL PERIMETER OF ALL ACOUSTICAL CEILING TILE (ACT) CEILINGS. TYPICAL UNLESS NOTED OTHERWISE. REFER TO DETAIL 5-A9.1. REFER TO SPECIFICATION SECTION 09510.

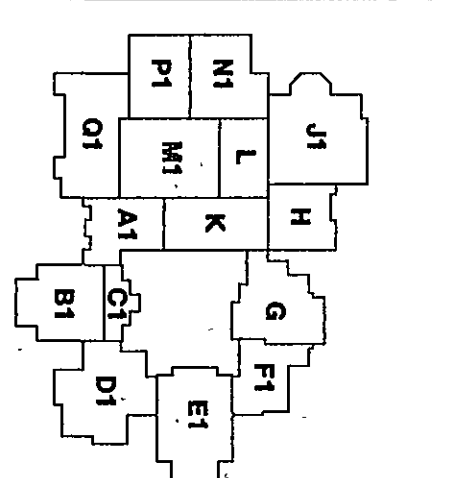

THE NEW
CHESTERTON HIGH SCHOOL
FOR THE
DUNELAND SCHOOL CORPORATION
CHESTERTON, INDIANA

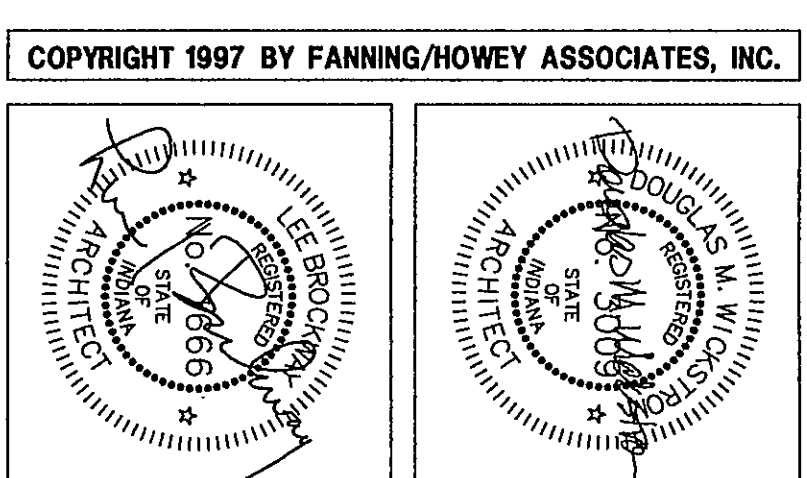

Fanning/Howey Associates, Inc.
Architects Engineers Consultants

CEILING PLAN UNIT M1

DRAWN BY: GJE COMM. NO.: 95067.00
CHECKED BY: JHU DATE: APRIL 21, 1997

A9.18

REVISIONS NO. DATE

06-L-A-191-M

CHESTERTON HIGH SCHOOL
95067.00