


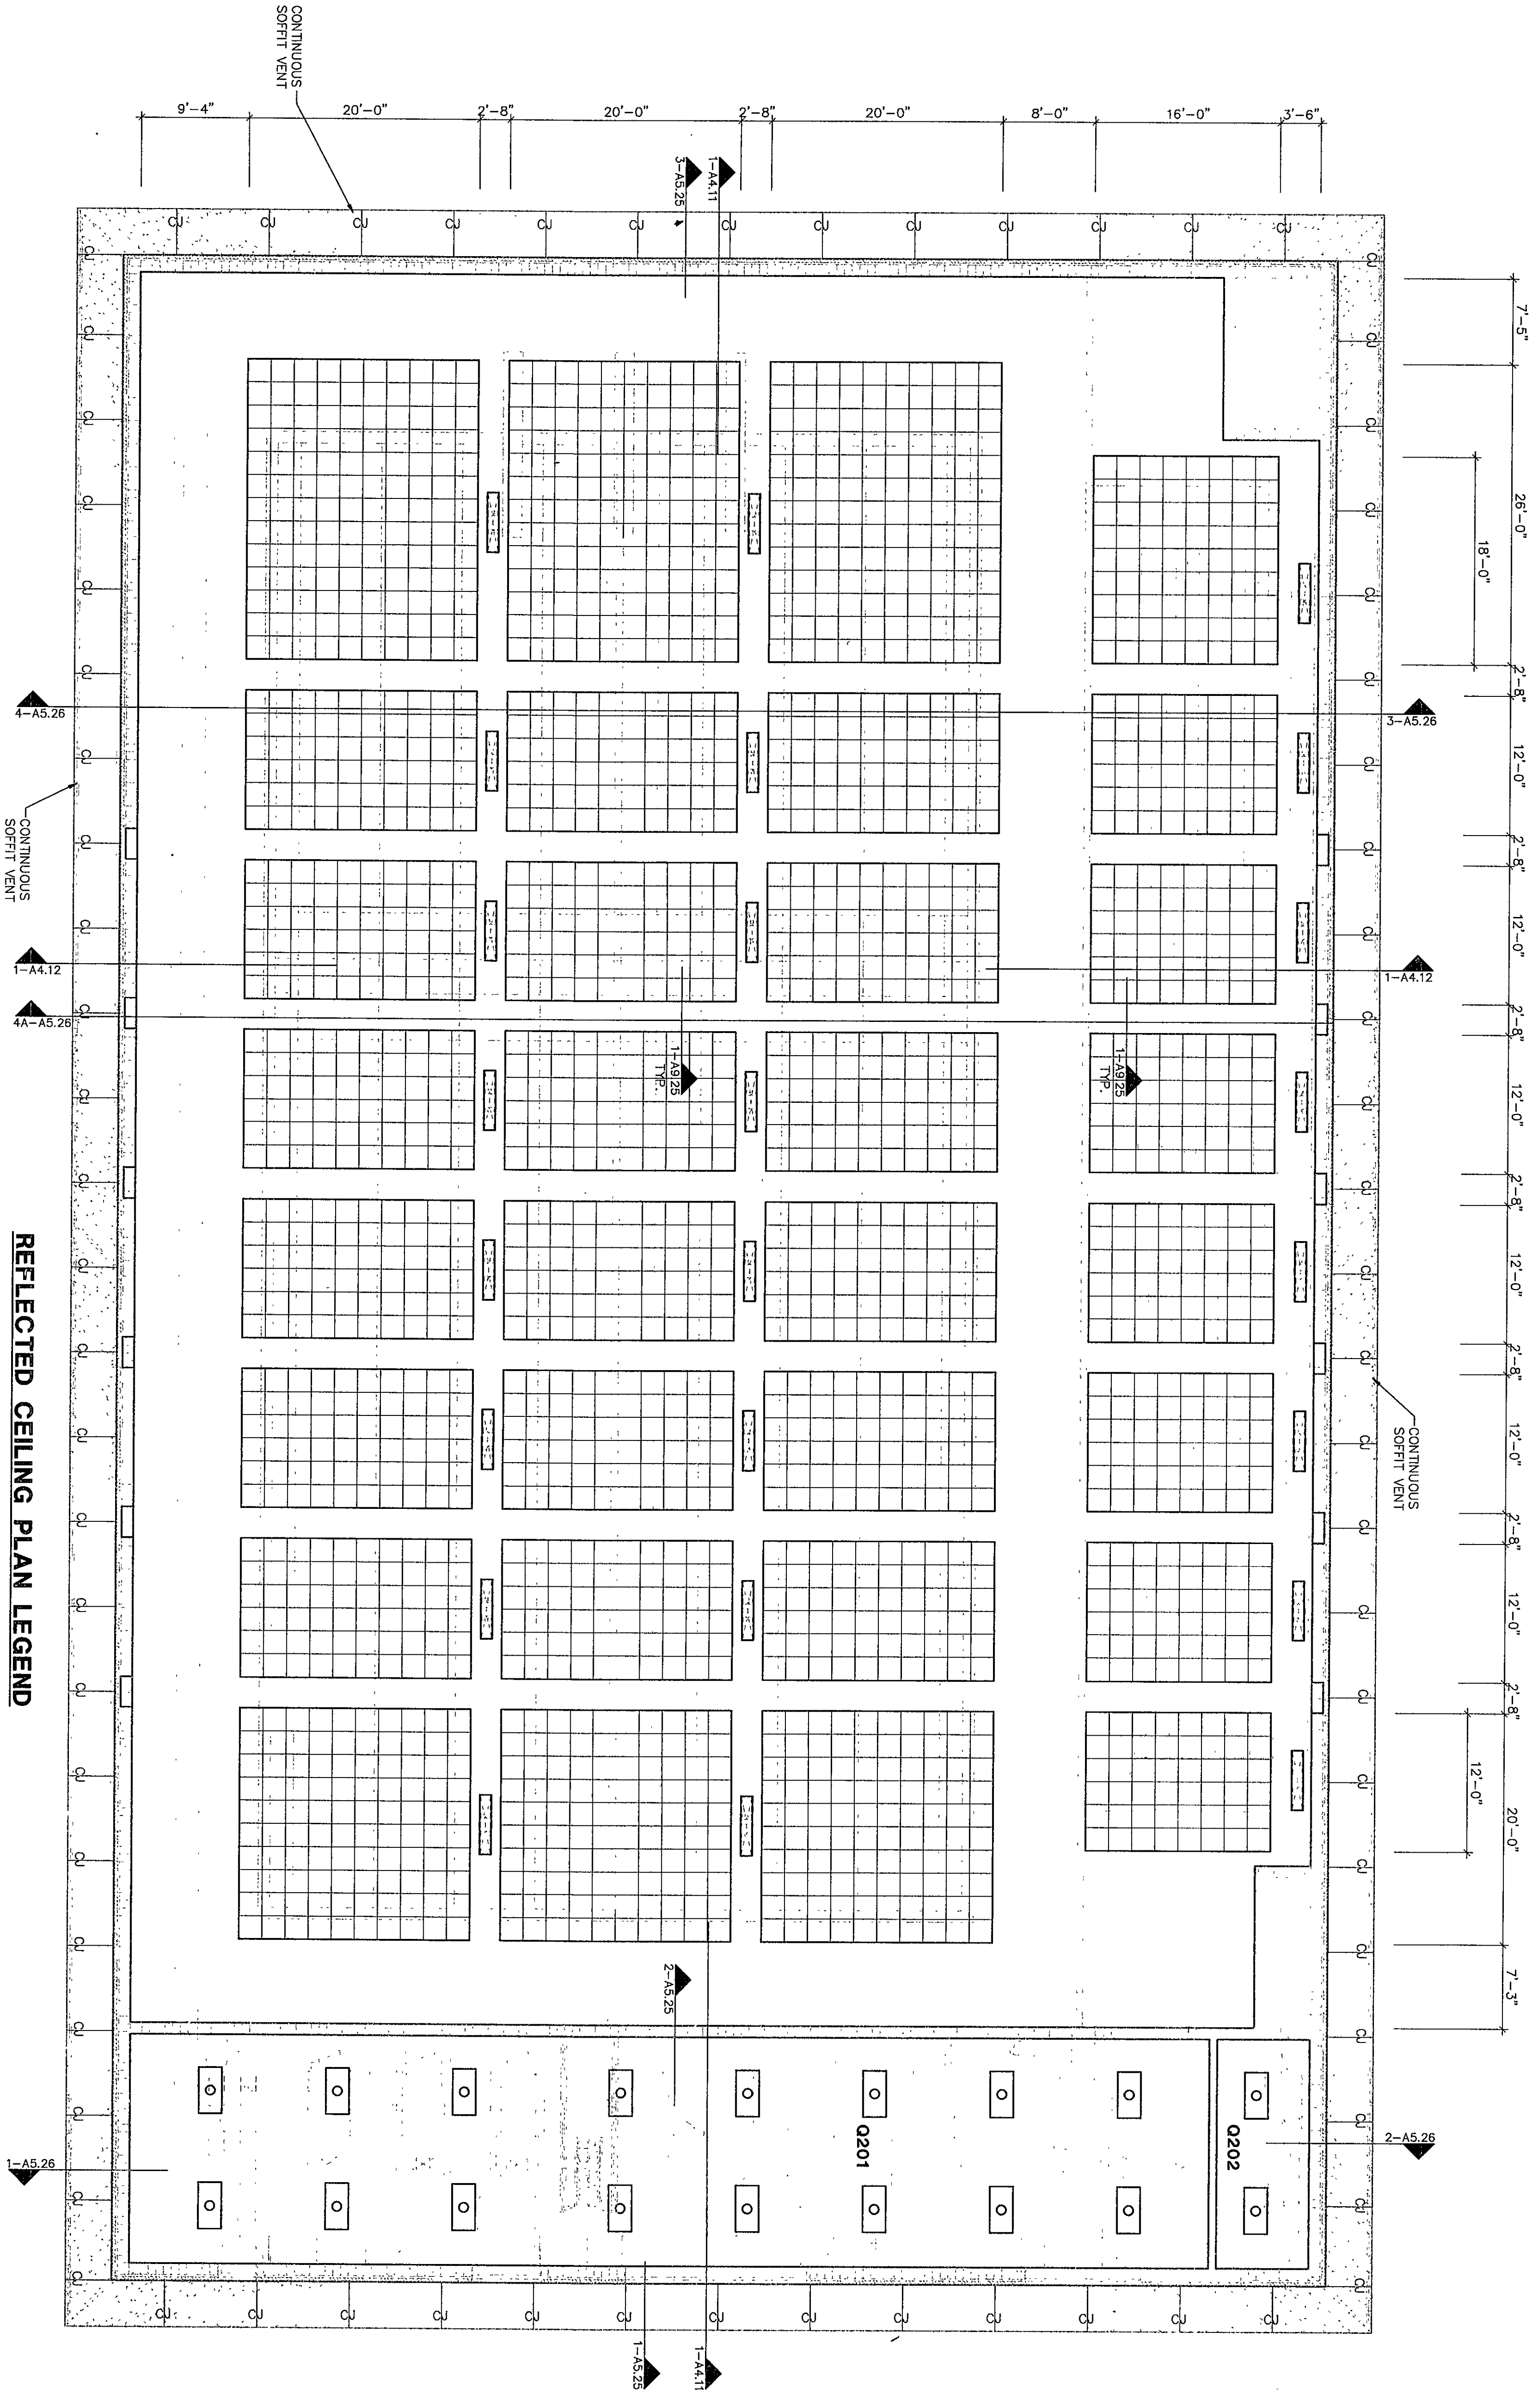

REFLECTED CEILING PLAN LEGEND


- LIGHT FIXTURE - REFER TO ELECTRICAL
- SPEAKER - REFER TO ELECTRICAL
- LOUVER/GRIFF - REFER TO MECHANICAL
- SLOT DIFFUSER - REFER TO MECHANICAL
- ACoustical CEILING TILE (ACT) - REFER TO ROOM FINISH SCHEDULE FOR TYPES
- GYPSUM WALLBOARD (GWB)
- EXTERIOR INSULATION FINISH SYSTEM (EIFS)
- CEMENT PLASTER (PLAS)
- SPRAY-ON ACOUSTICAL INSULATION (SMA) OVER GLASS FIBER REINFORCED GYPSUM UNITS
- PAINTED EXPOSED STRUCTURE (PES)
- CONTROL JOINT REFER TO DETAIL 12-A9.2

ROOM LEGEND "Q2"

ROOM	AREA
0201	CEILING
0202	MEZZANINE
0203	MECHANICAL ROOM
0204	MECHANICAL ROOM



CEILING PLAN UNIT Q2

1/8" = 1'-0"

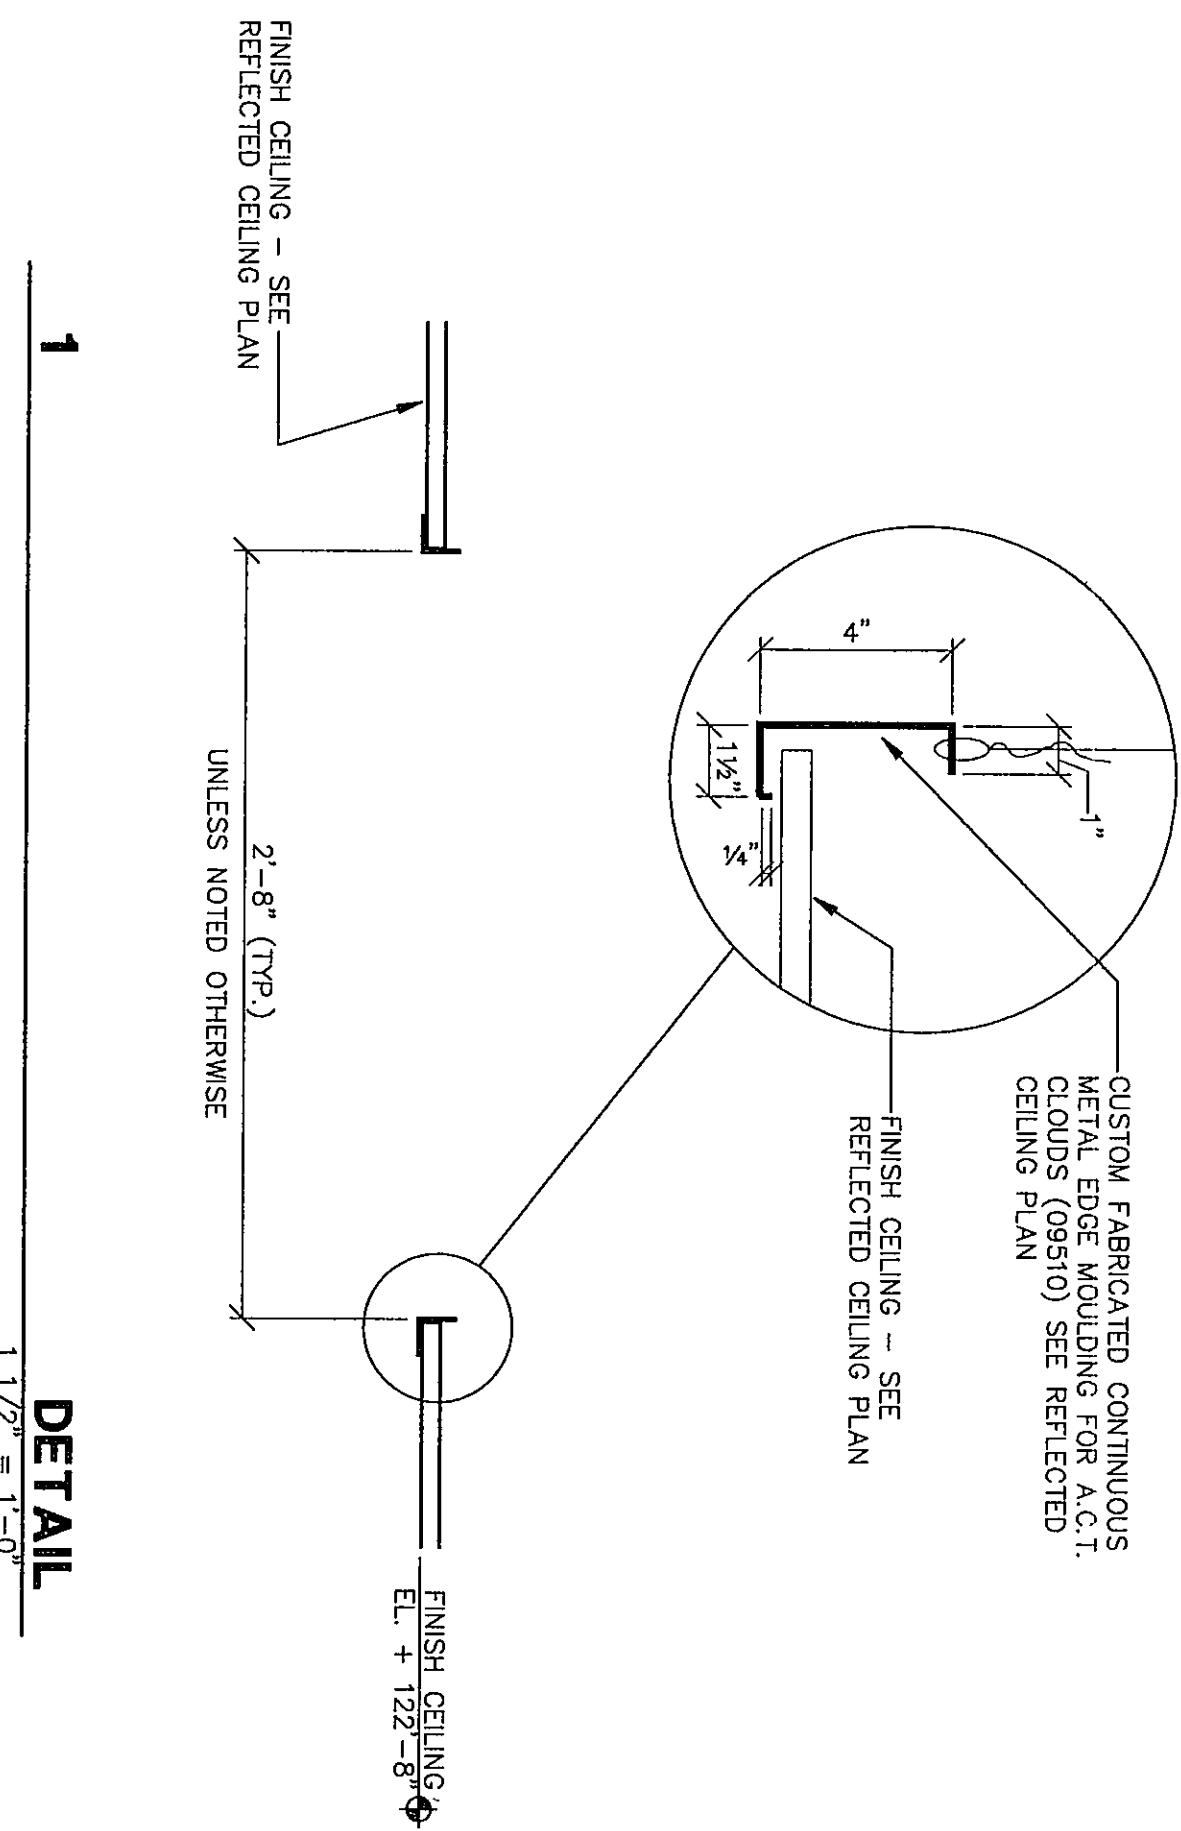


DETAIL 1

1 1/2" = 1'-0"

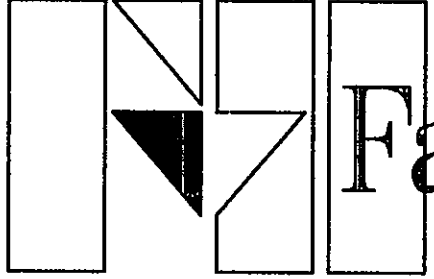
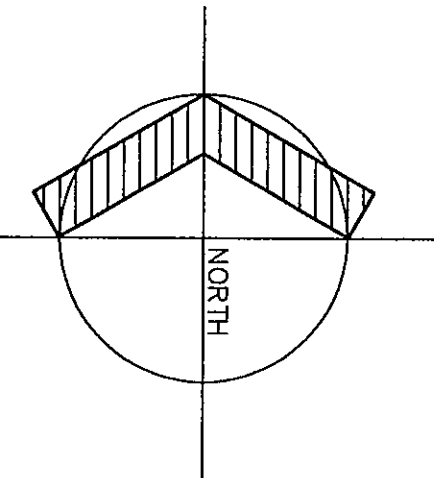


Fanning/Howey Associates, Inc.
Architects Engineers Consultants

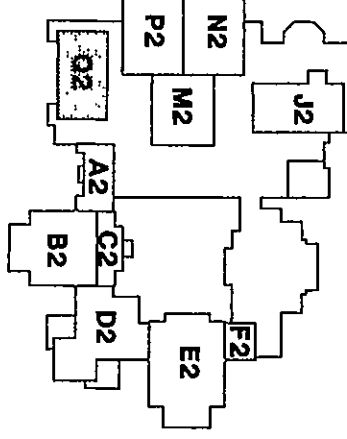

THE NEW
CHESTERTON HIGH SCHOOL
FOR THE
DUNELAND SCHOOL CORPORATION
CHESTERTON, INDIANA

COPYRIGHT 1997 BY FANNING/HOWEY ASSOCIATES, INC.

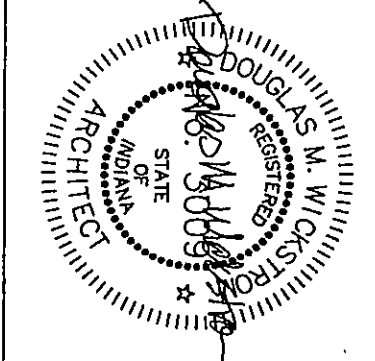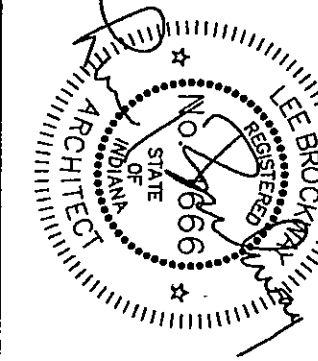

CEILING PLAN UNIT Q2	
DRAWN BY: JHJ	COMM. NO.: 95067.00
CHECKED BY: GJE	DATE: APRIL 21, 1997
A9.25	
REVISIONS NO. DATE	

CHESTERTON HIGH SCHOOL
5/3/97/JO

07-A-171