



ENLARGED TENNIS COURT PLAN


SCALE: 1" = 20'-0"

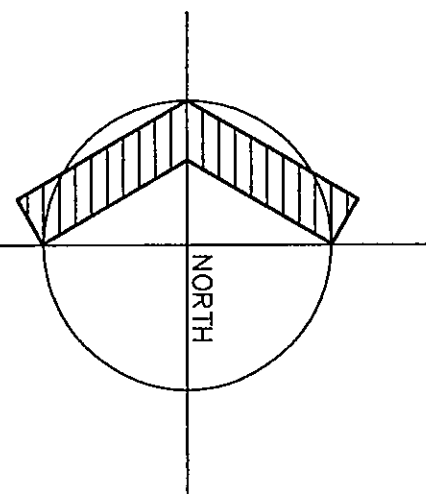


PLAN

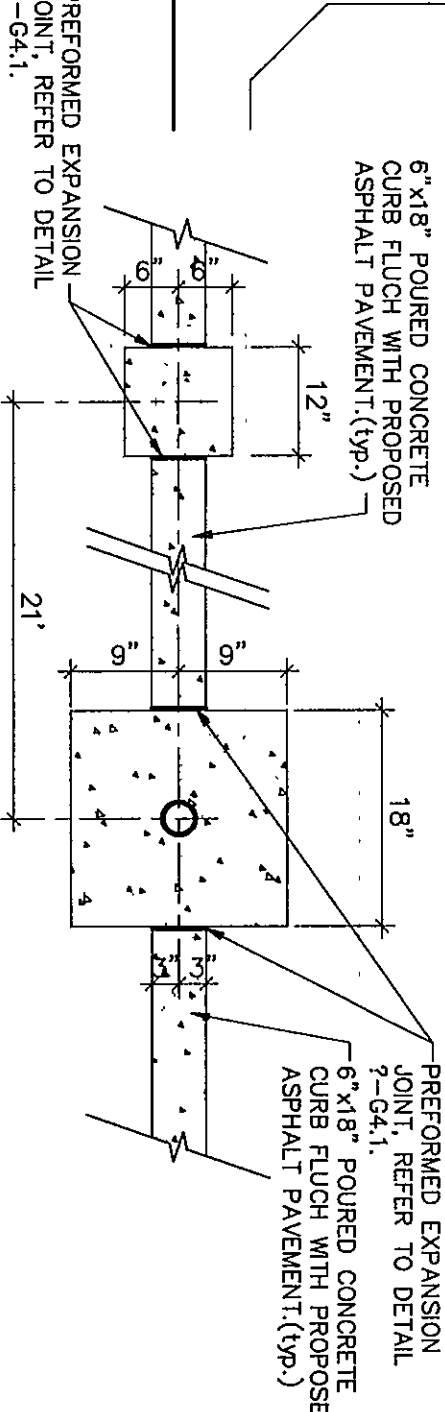


1 TENNIS NET FOOTING/TIE DOWN DETAIL

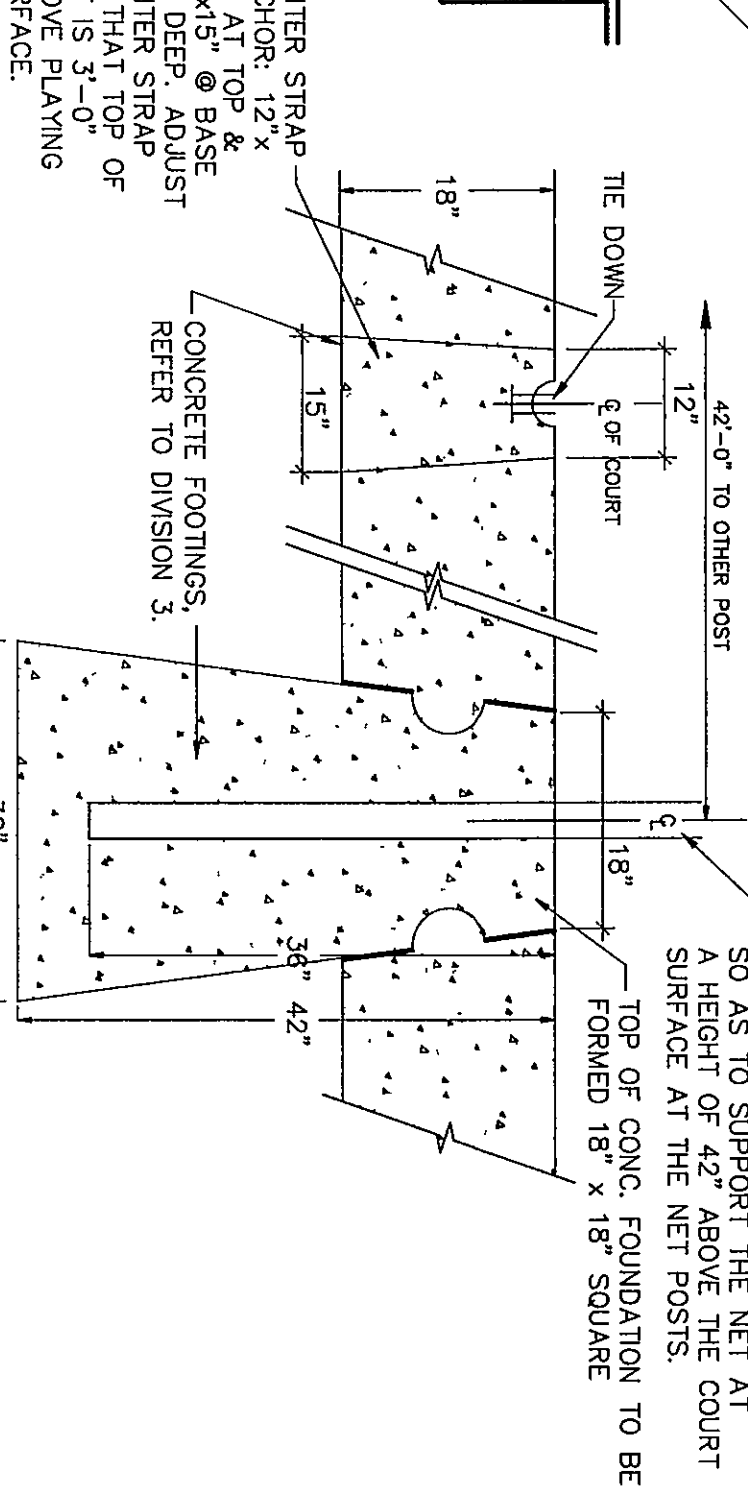


2 TENNIS COURT PVMT.

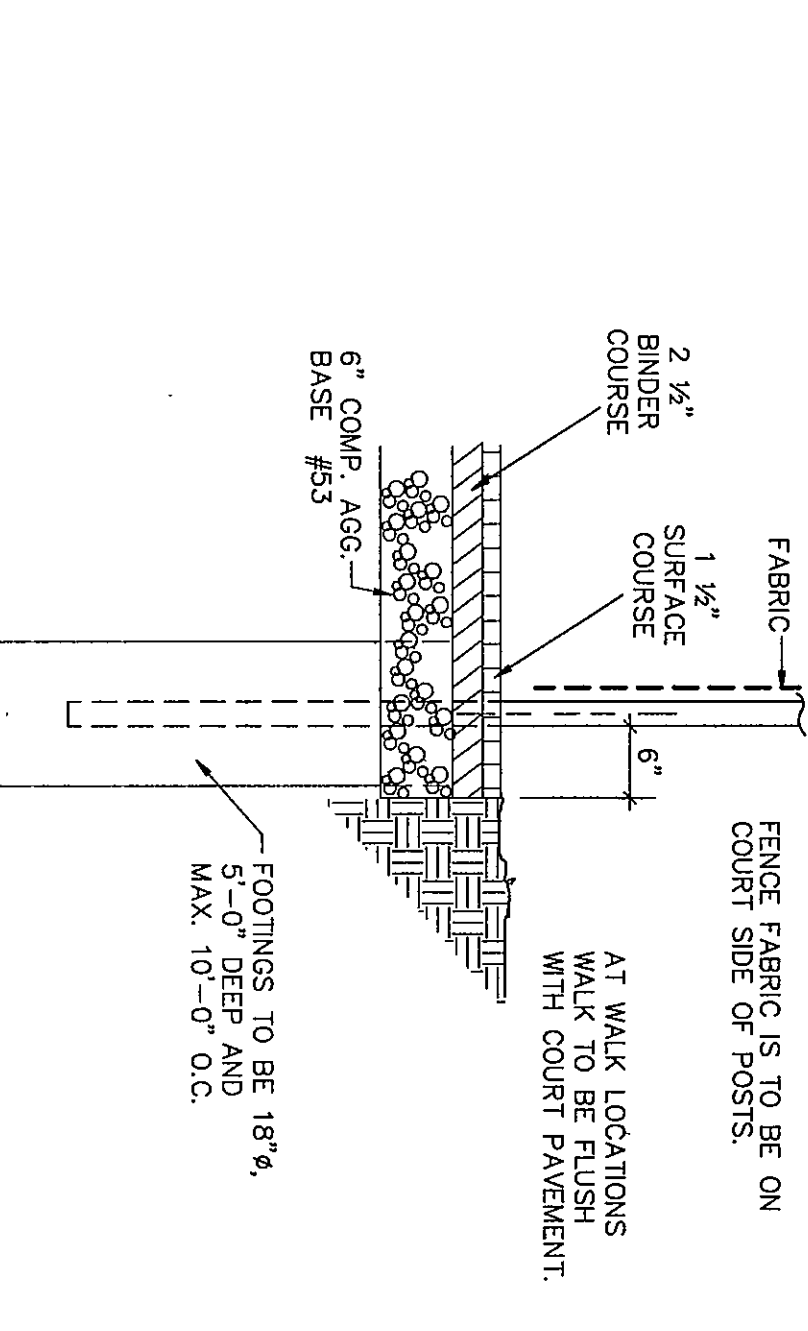

3 TENNIS COURT FENCE

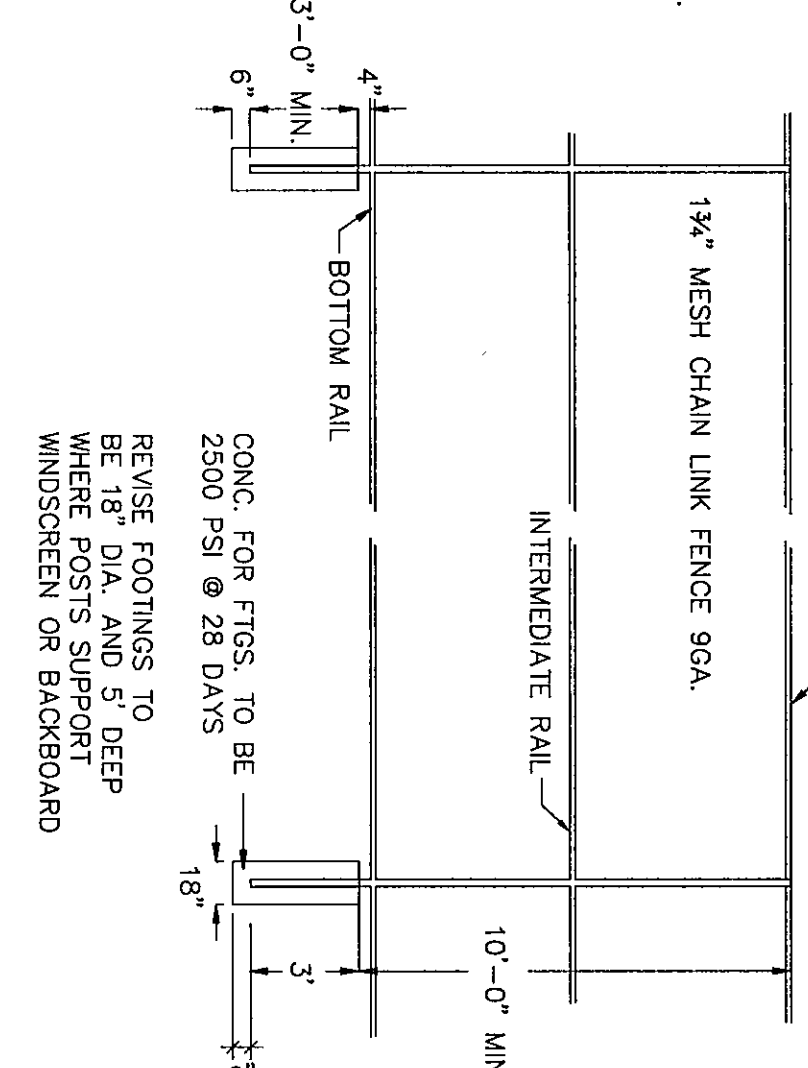


4 TENNIS COURT BACKBOARD ATTACHMENT

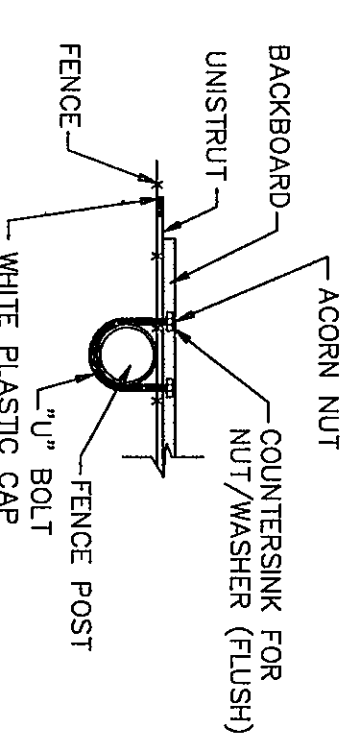

NO SCALE


NOTES

1. TENNIS NET/POSTS. PROVIDE 12 SETS. REFER TO DETAIL 1 FOR TYPICAL STRIPING LAYOUT. POSTS ARE TO HAVE INTERIOR WIND MECHANISM. 3\"/>
- 2. EQUIPMENT AS MANUFACTURED BY COURT-1; CANADA (PHONE 1-800-363-2591) \"92-10\" 3\" SQUARE BACKBOARD. 1\" DIA. POSTS. 70\" HIGH. NET WITH 7\" MESH. CENTER STRAP COMPLETE WITH PIPE ANCHOR AND SNAPS. OPEN WEAVE. 8\" HIGH WINDSCREENING WITH \"220\" SELF-LOCKING TRAPS.
- 3. REFER TO SPEC SECTION 02511 FOR TENNIS COURT PAINTING SYSTEM.
- 4. PROVIDE A 1\"-6\" HIGH COURT NUMBER AT EACH COURT. ATTACH NUMBERS TO THE FENCE. LOCATION OF NUMBERS TO BE PER OWNERS DIRECTIONS.
- 5. REFER TO THE SITE ELECTRICAL PLAN FOR NOTES REGARDING THE ELECTRICAL OUTLETS AND LIGHT POLES.

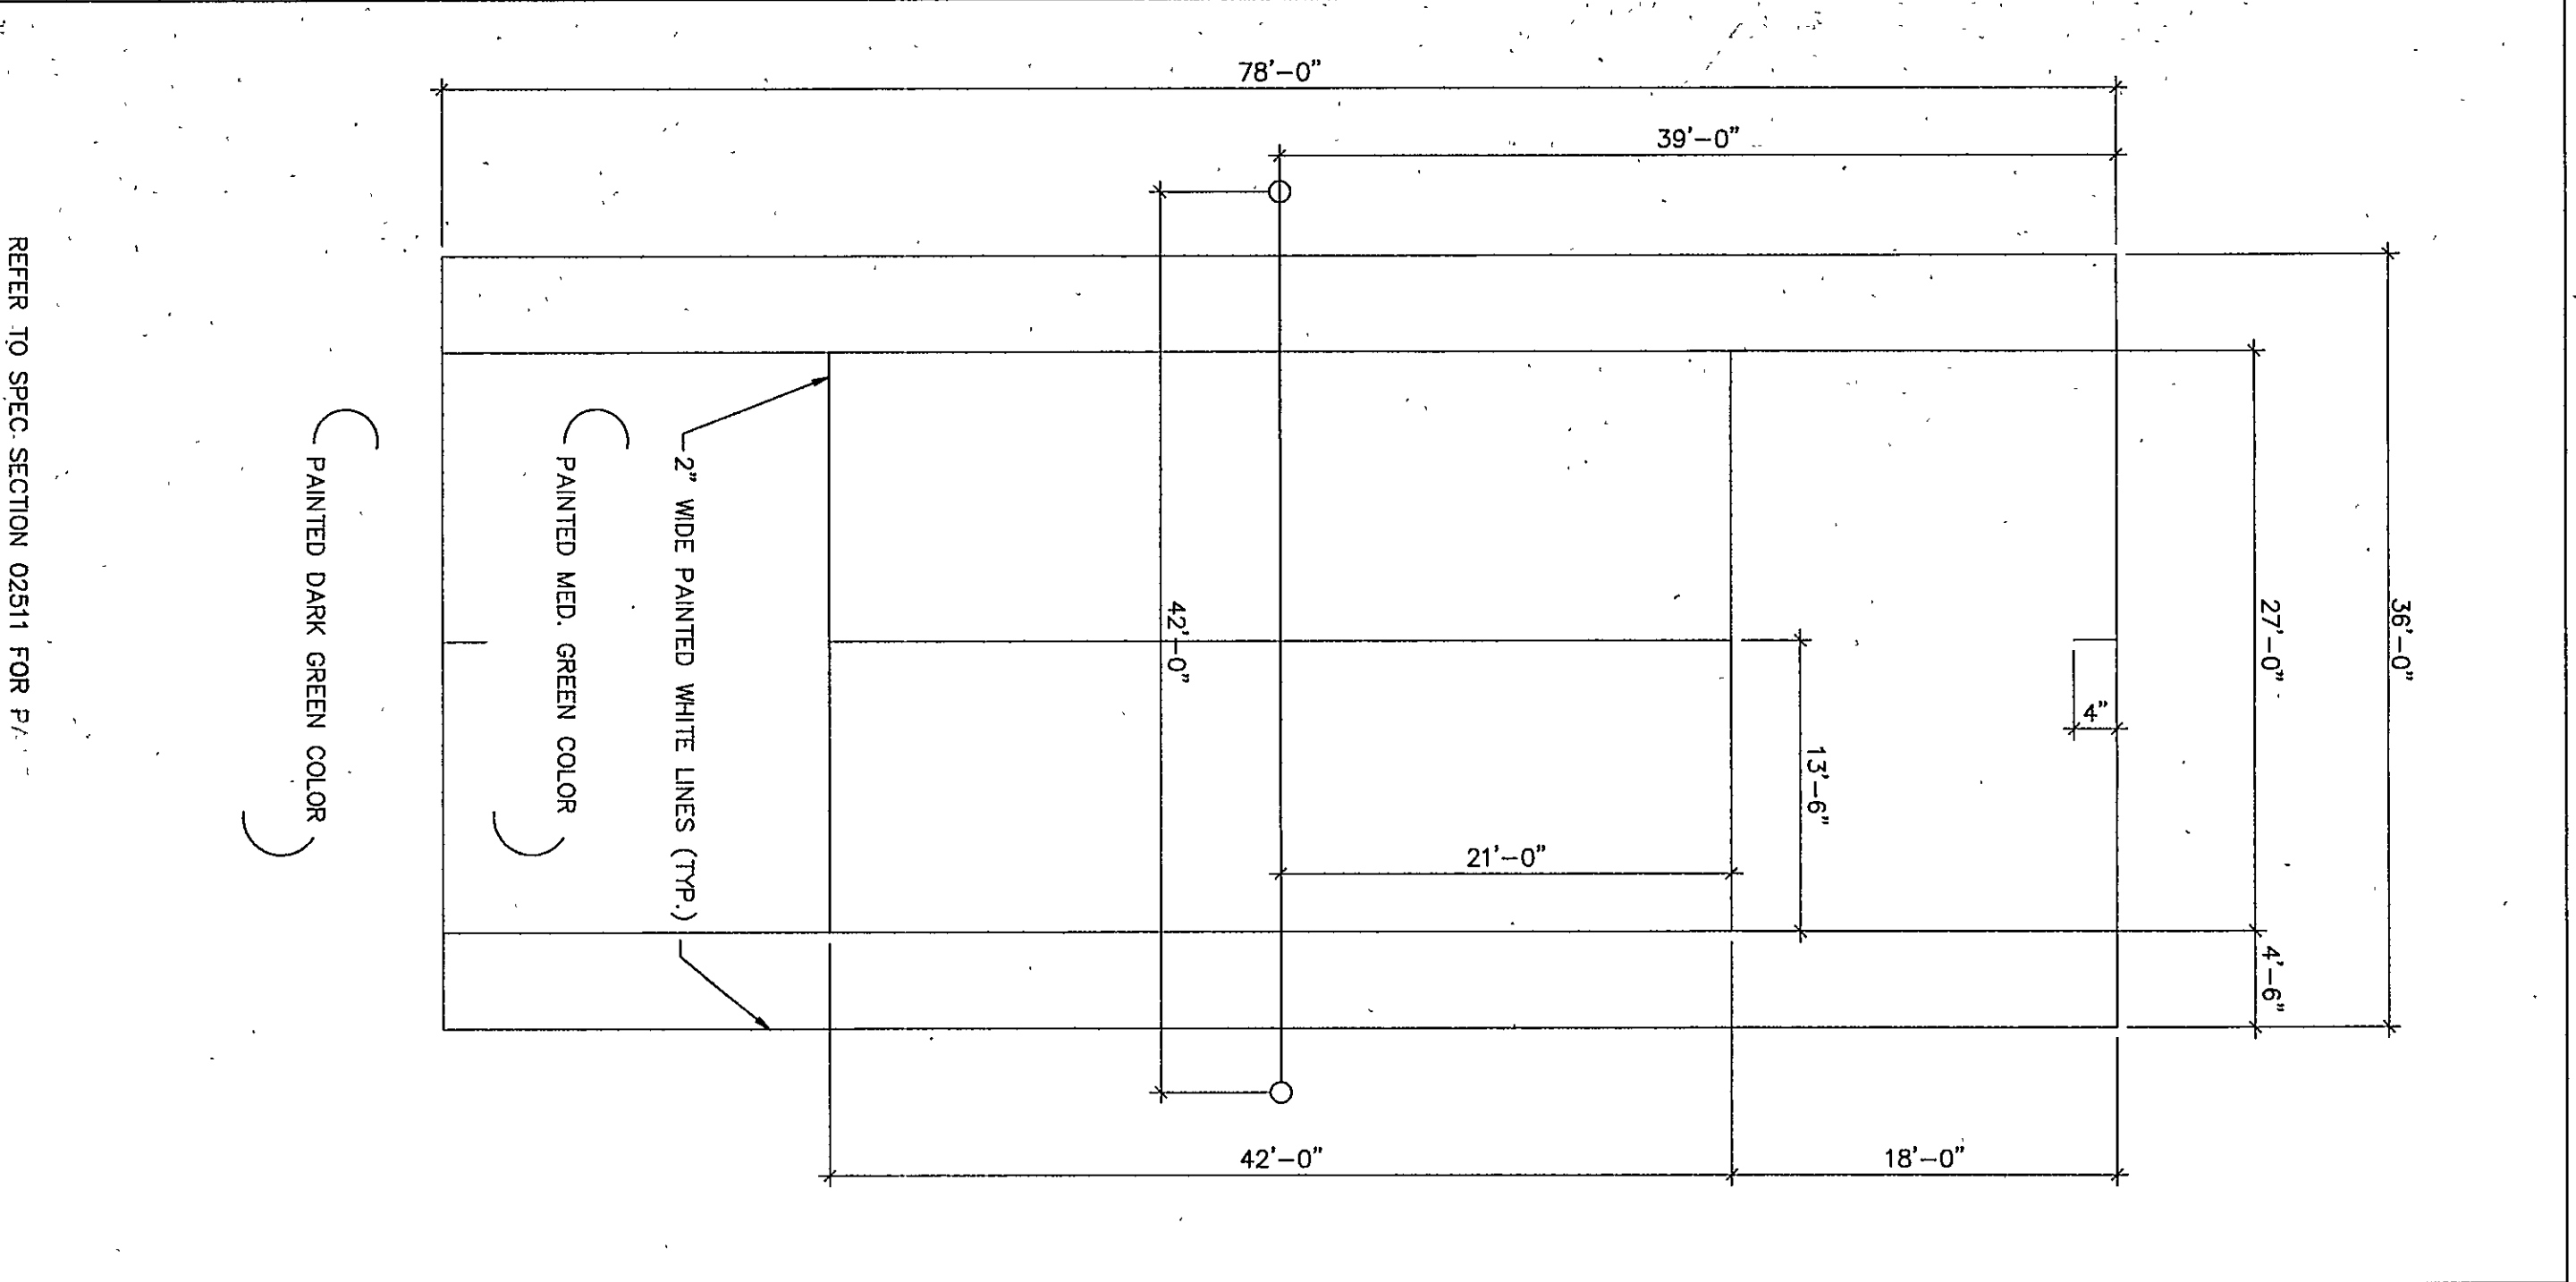

8 TENNIS CT

THE NEW  
**CHESTERTON HIGH SCHOOL**  
FOR THE  
DUNELAND SCHOOL CORPORATION  
CHESTERTON, INDIANA

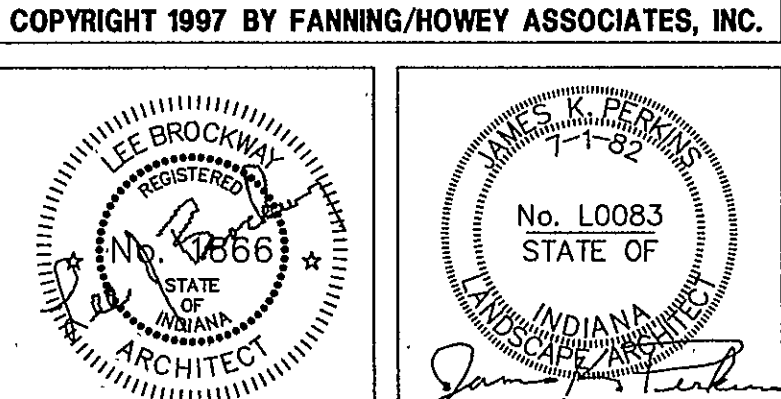

**Fanning/Howey Associates, Inc.**  
Architects Engineers Consultants

ENLARGED TENNIS COURTS	
DRAWN BY: STU	COMM. NO: 95067.00
CHECKED BY: JKP	DATE: APRIL 21, 1997
REVISIONS NO. DATE	
G3.13	

CHESTERTON HIGH SCHOOL  
95067.00 PHASE 2