
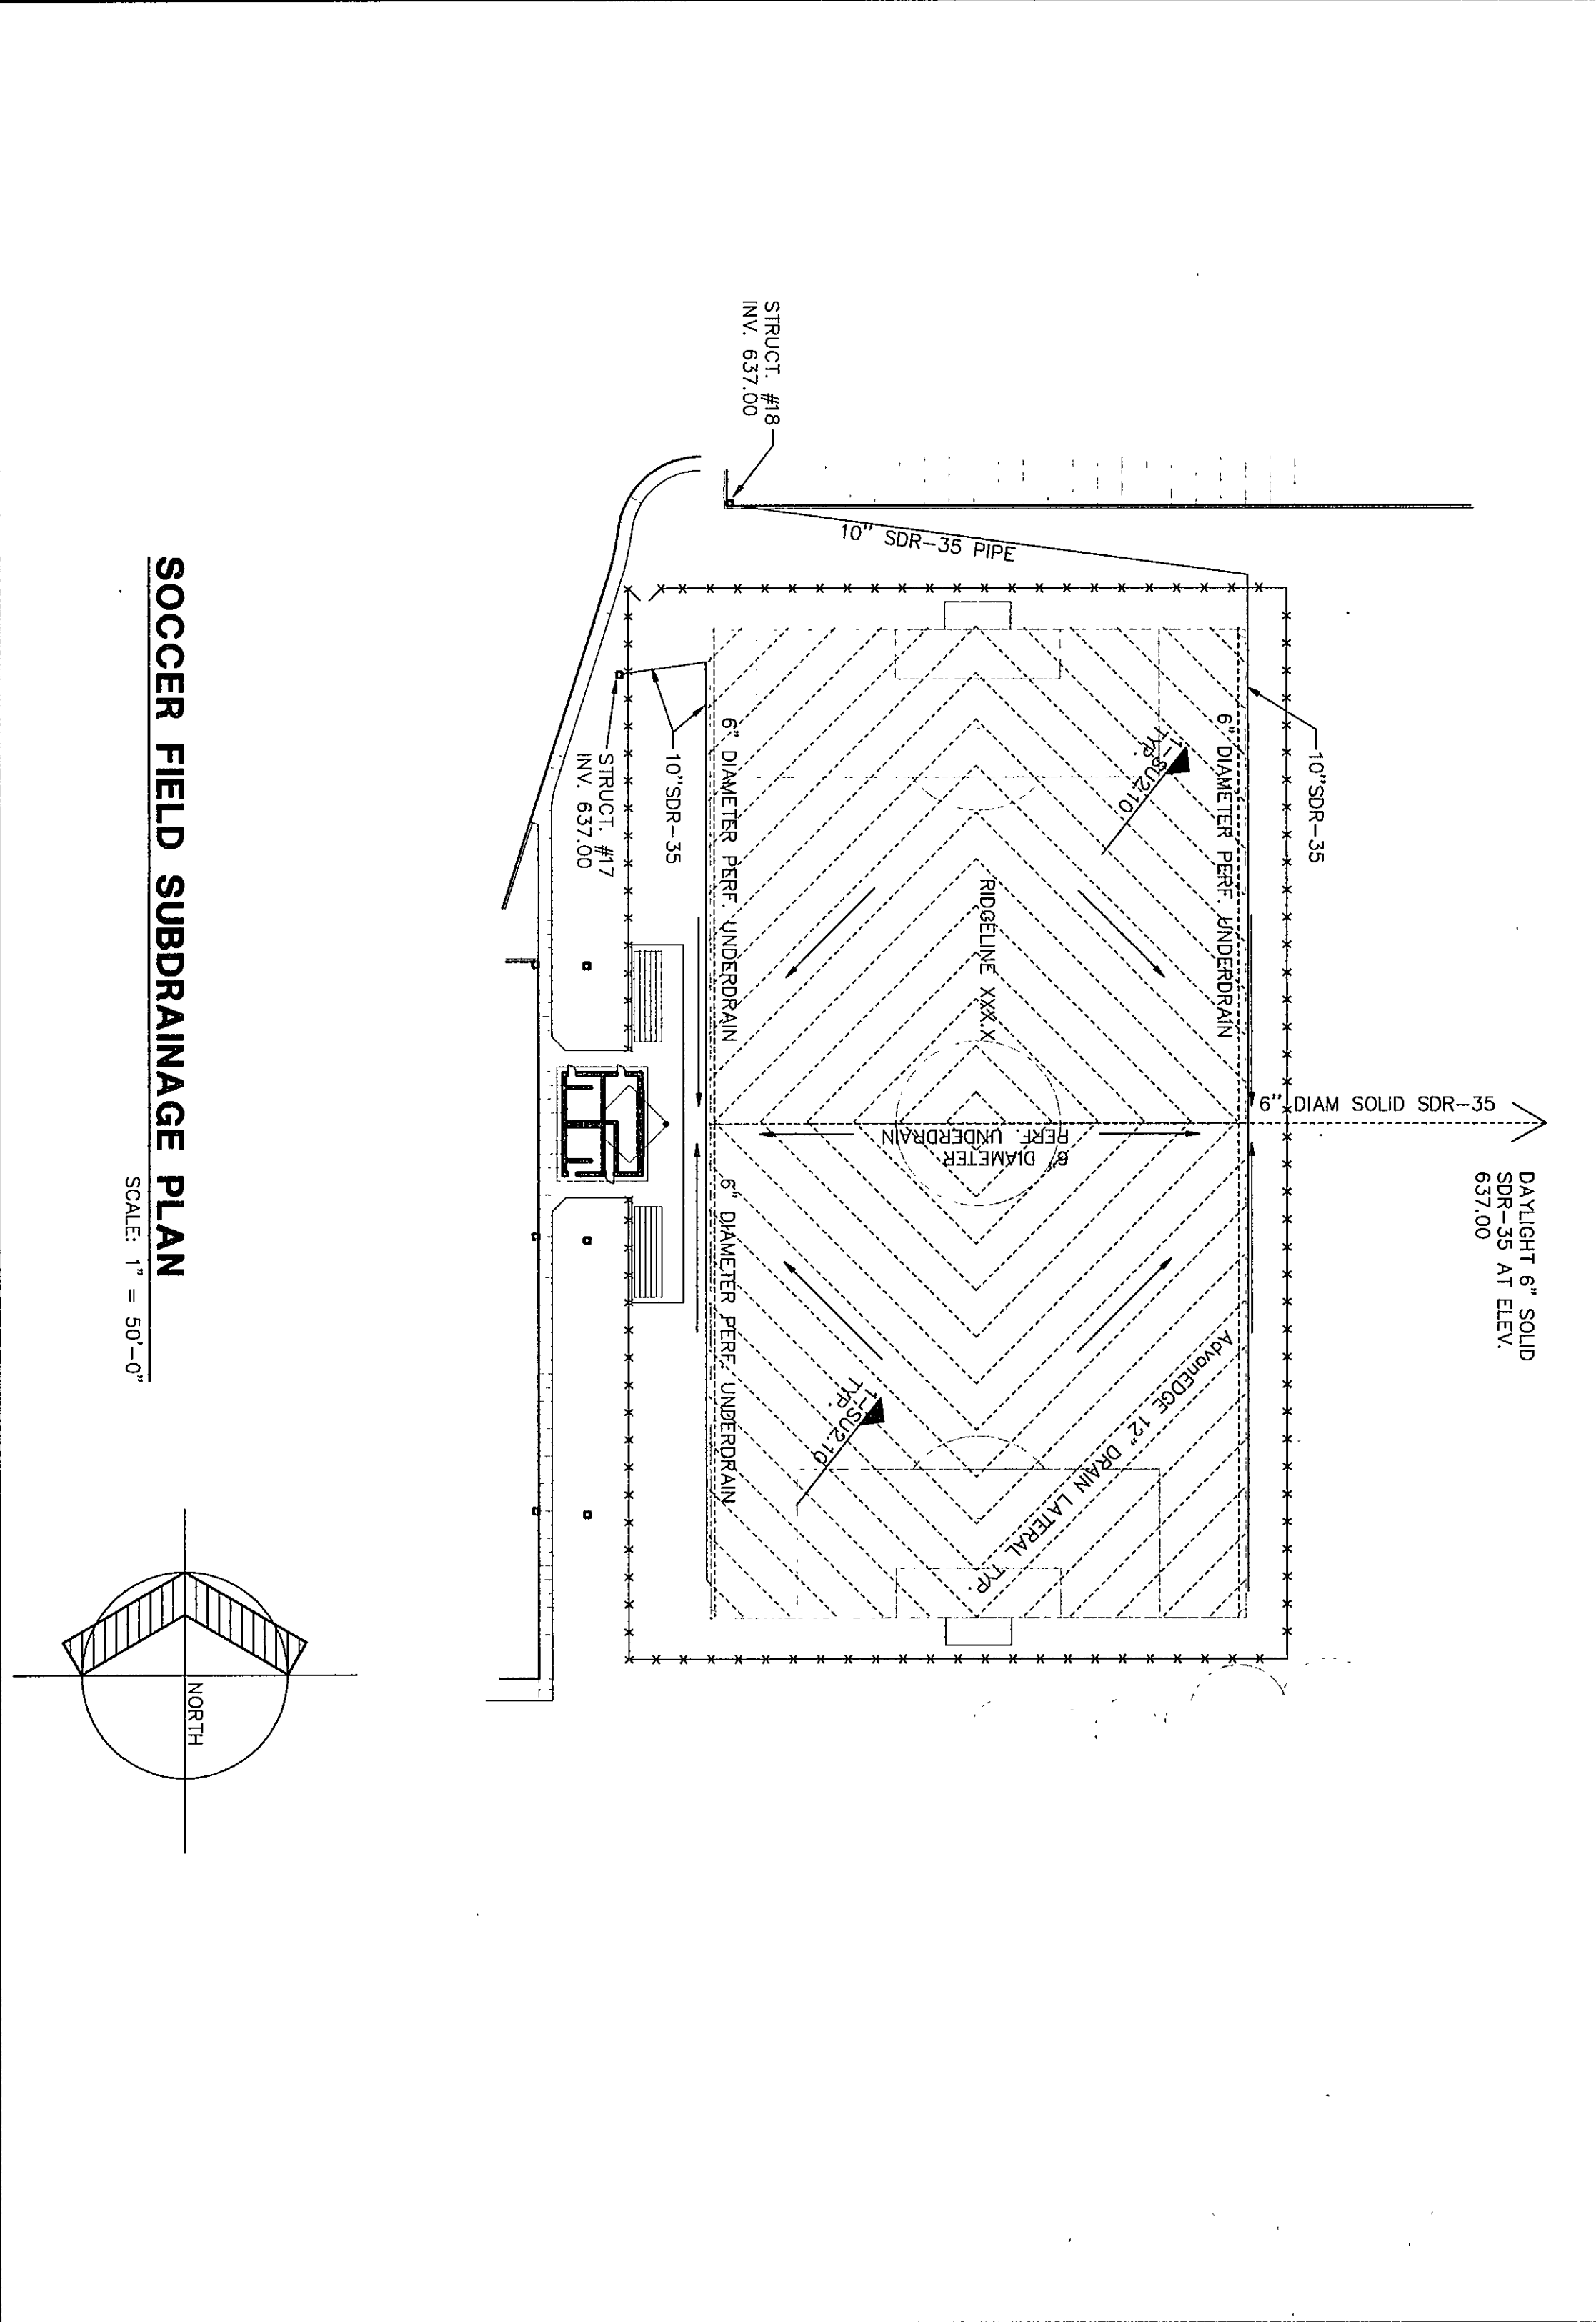
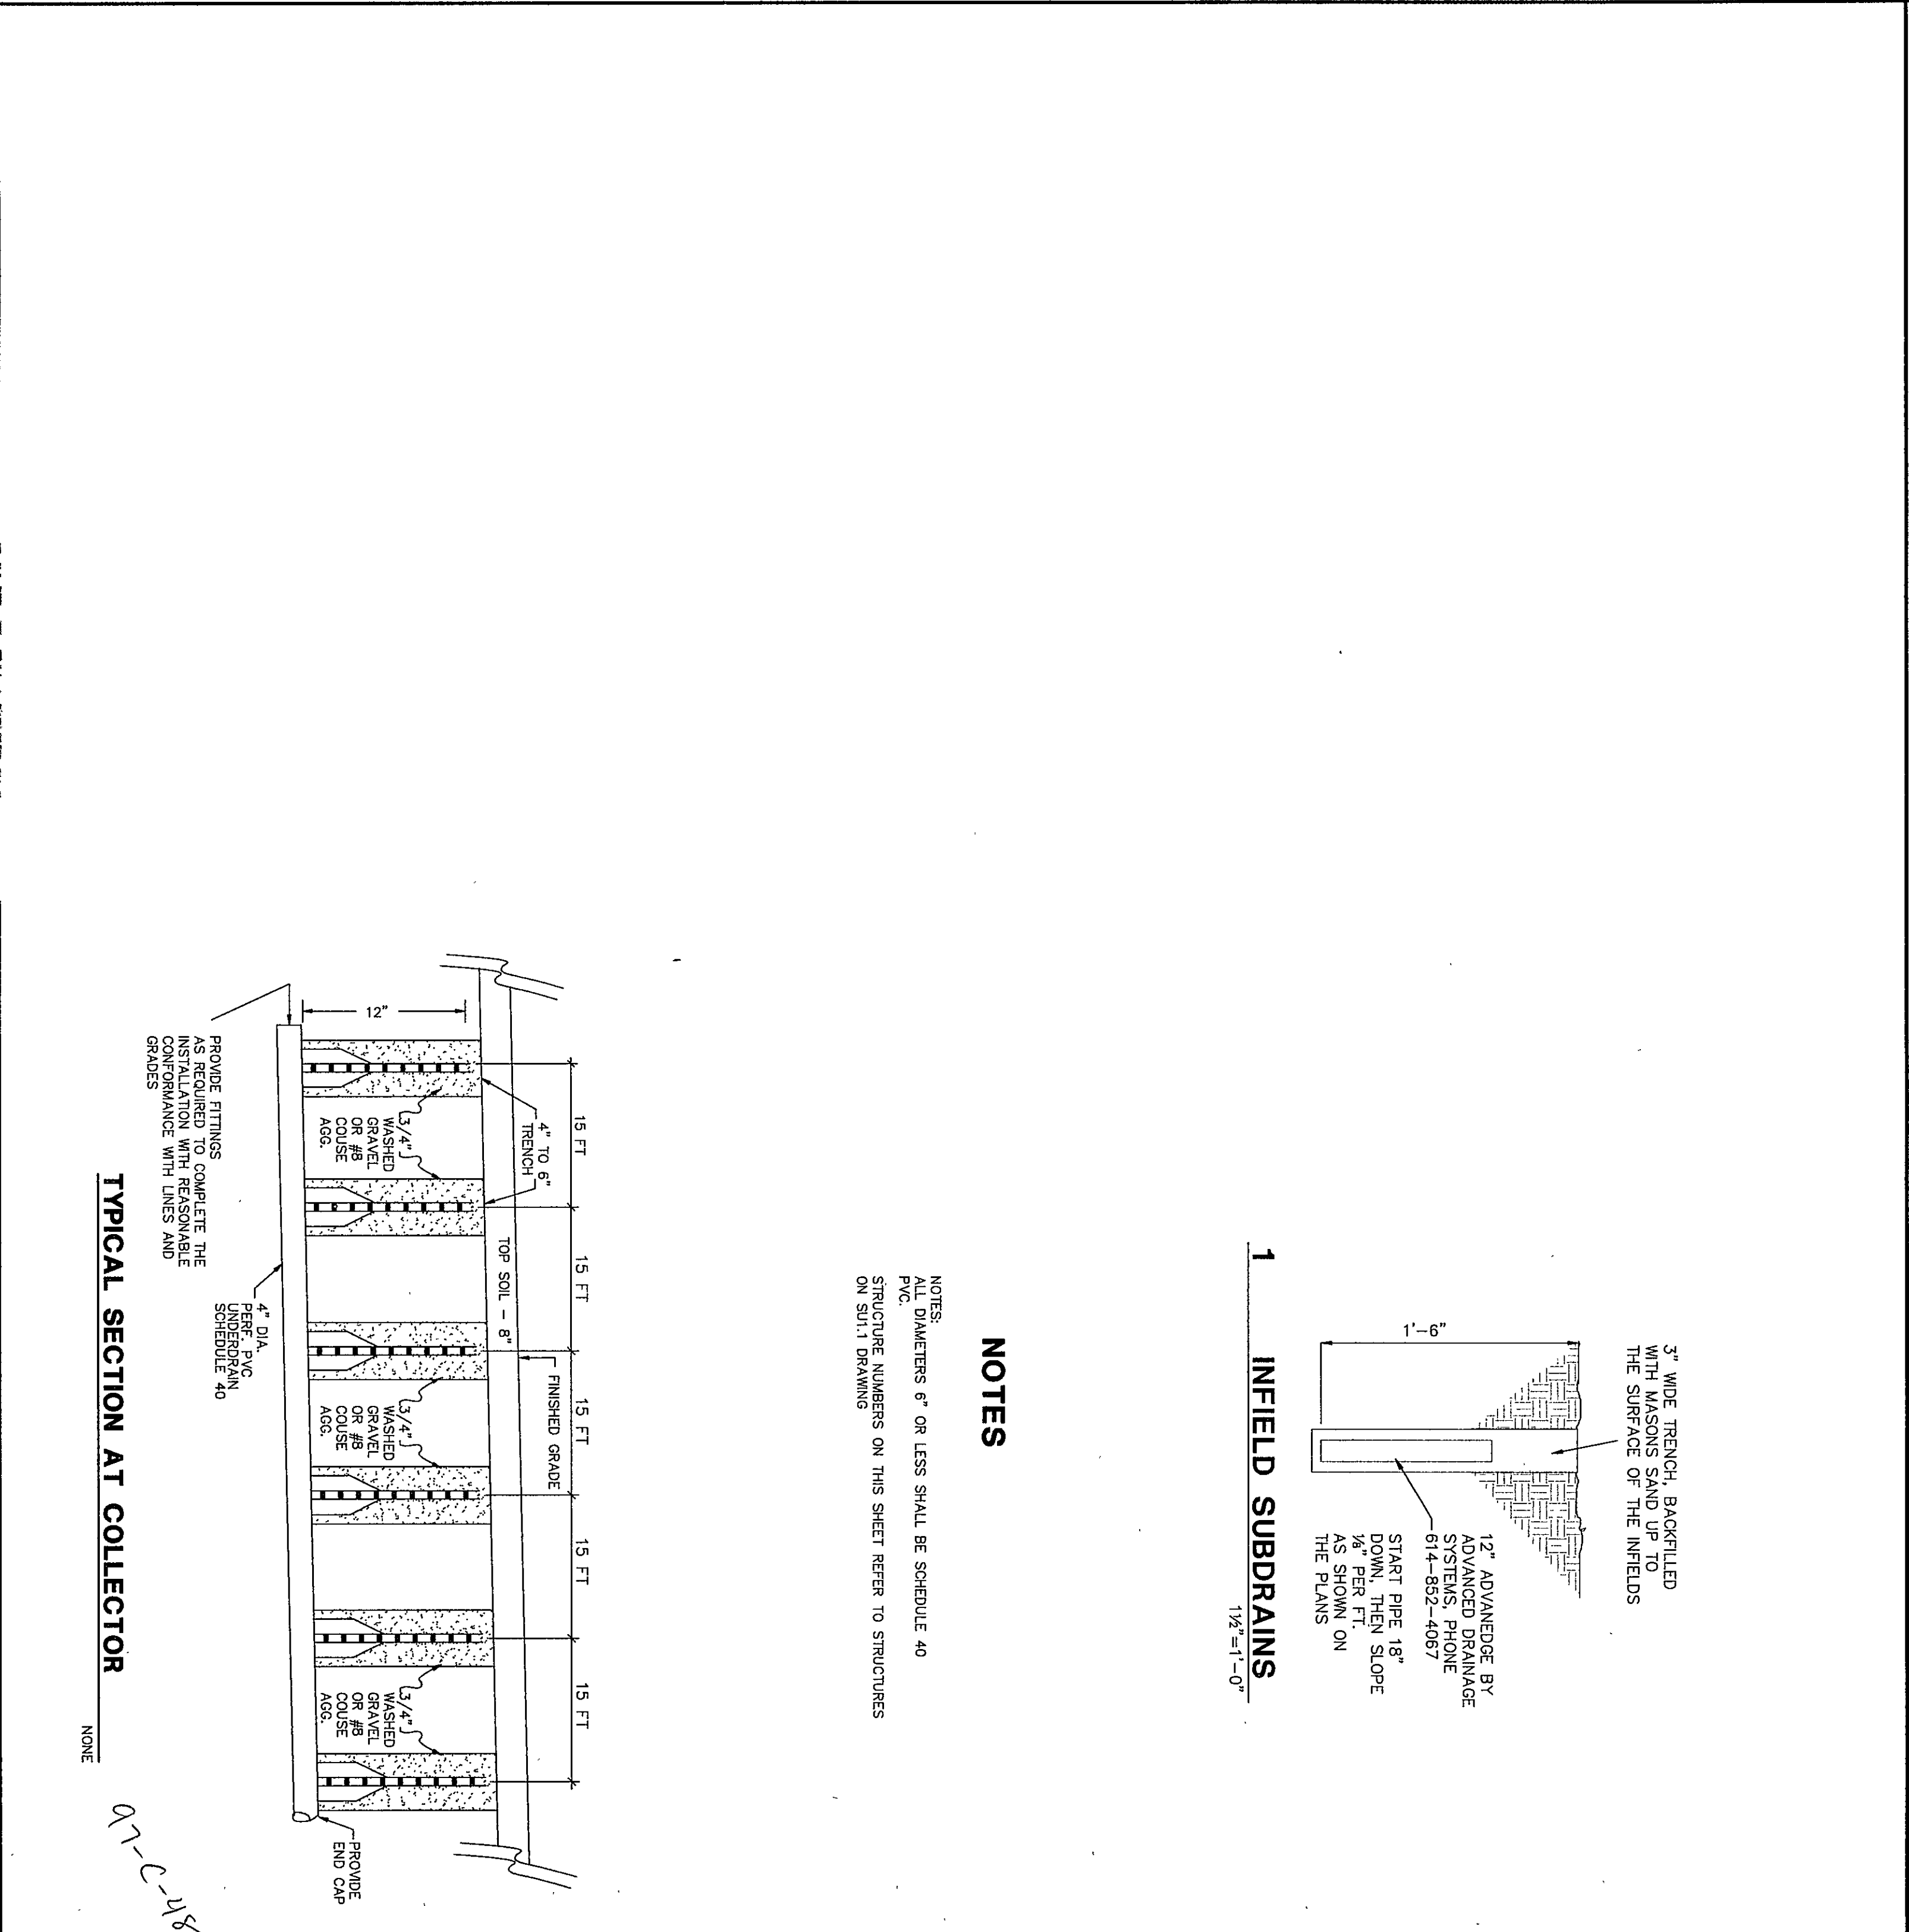


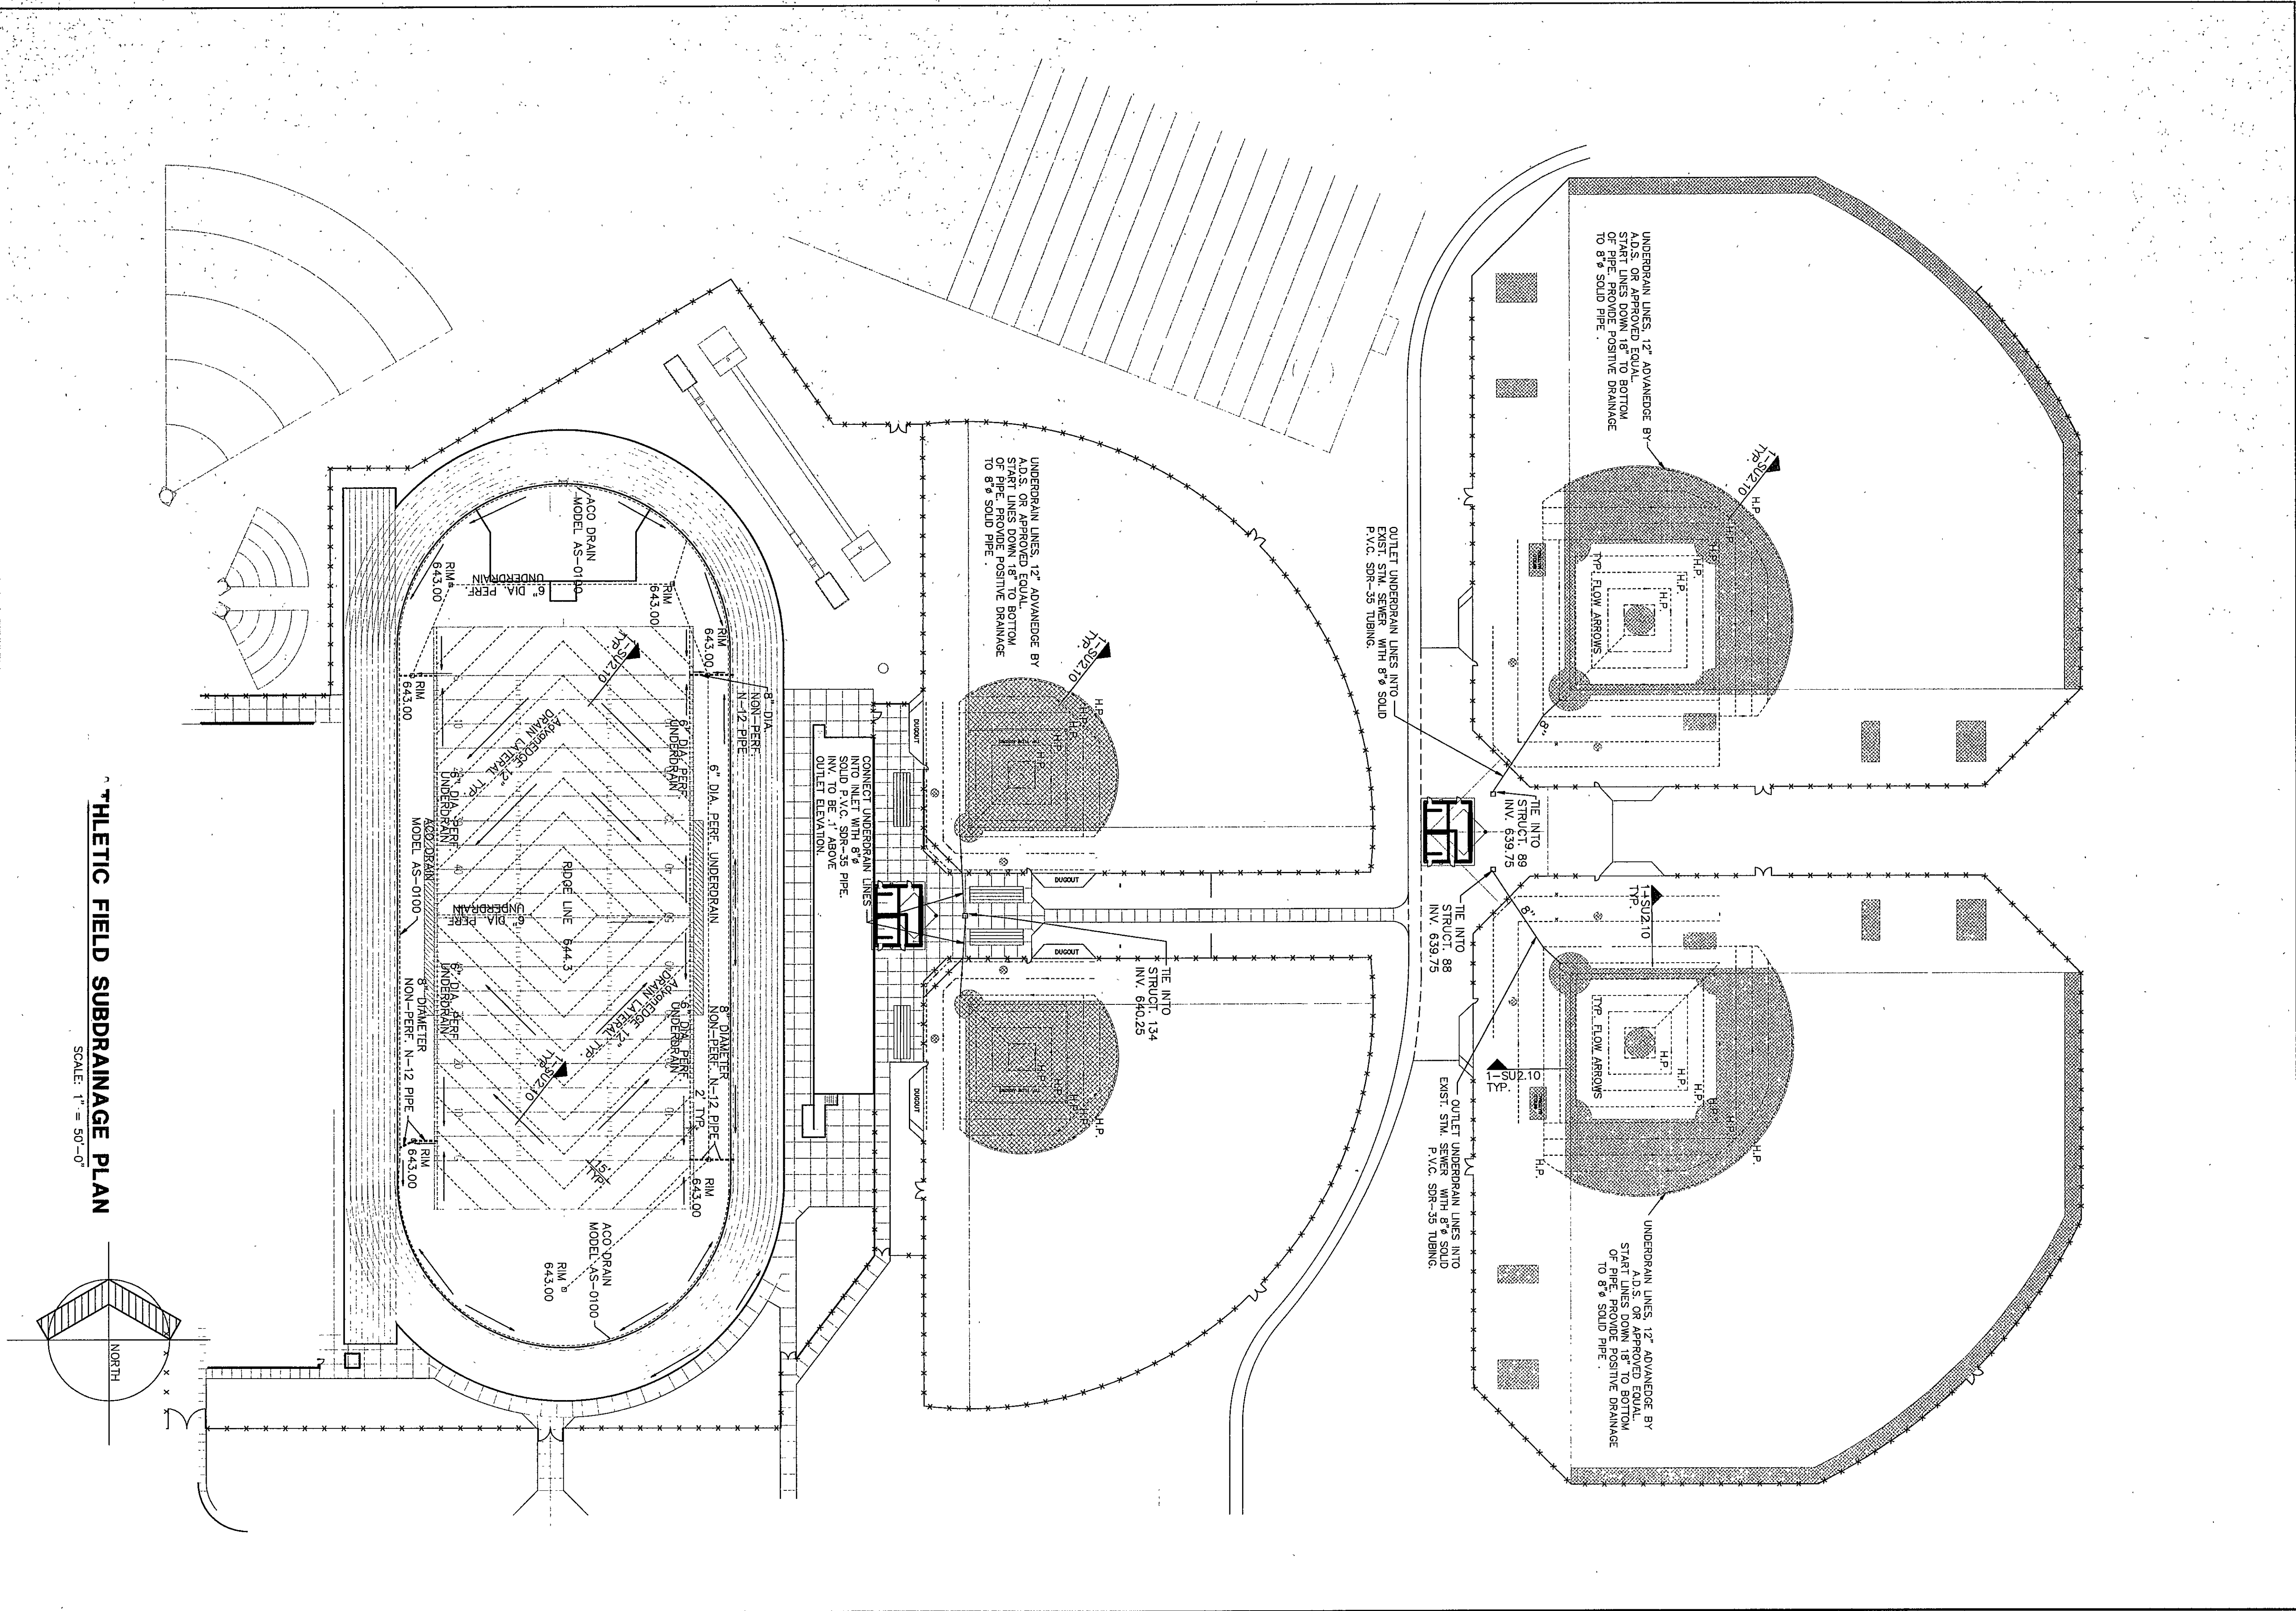


SUBDRAINAGE PLAN

DRAWN BY: STU/CDH COMM. NO.: 95067.00
 CHECKED BY: JKP DATE: APRIL 21, 1997

SU2.10

REVISIONS NO. DATE

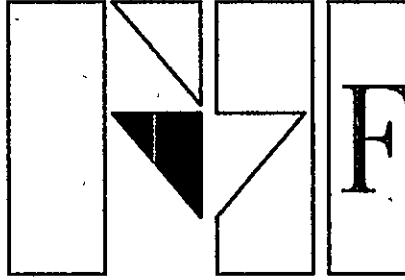

Fanning/Howey
Associates, Inc.

Architects Engineers Consultants

THE NEW
CHESTERTON HIGH SCHOOL
 FOR THE
 DUNELAND SCHOOL CORPORATION
 CHESTERTON, INDIANA

COPYRIGHT 1997 BY FANNING/HOWEY ASSOCIATES, INC.

