

REVISIONS	DATE	BY	DESCRIPTION
1	2/13/98	WKS	REVISED FOR NEW WORK
2	2/13/98	WKS	REVISED FOR NEW WORK
3	2/13/98	WKS	REVISED FOR NEW WORK
100	2/13/98	WKS	REVISED FOR NEW WORK



ELECTRICAL GENERAL NOTES

1. ALL WORK SHALL BE IN ACCORDANCE WITH NATIONAL, STATE, AND LOCAL CODES IN FORCE AT THE TIME OF BIDDING, INCLUDING, BUT NOT LIMITED TO, THE INDIANA CONSTRUCTION RULES AND NATIONAL ELECTRICAL CODE.
2. DRAWINGS ARE DIAGRAMMATIC AND GENERALLY INDICATIVE OF WORK REQUIRED. BASED ON PRELIMINARY CASE WORK AND COUNTER DIMENSIONS, THE CONTRACTOR SHALL VERIFY ALL DIMENSIONS AND LOCATIONS OF ALL ELECTRICAL EQUIPMENT PRIOR TO INSTALLATION OF ROUGH-IN'S. WHERE REQUIRED, ELECTRICAL EQUIPMENT SHALL BE INSTALLED IN ACCORDANCE WITH THE INDIANA ELECTRICAL CODE AND ACCORDANT CASE WORK, COUNTERS AND OTHER EQUIPMENT AT NO ADDITIONAL COST TO THE OWNER.
3. THE ELECTRICAL CONTRACTOR SHALL VISIT THE SITE PRIOR TO SUBMITTING A BID AND SHALL BE RESPONSIBLE FOR VERIFYING ALL DIMENSIONS AND LOCATIONS OF ALL ELECTRICAL EQUIPMENT PRIOR TO SUBMITTING A BID. THE CONTRACTOR SHALL BE RESPONSIBLE FOR VERIFYING ALL DIMENSIONS AND LOCATIONS OF ALL ELECTRICAL EQUIPMENT PRIOR TO SUBMITTING A BID. THE CONTRACTOR SHALL BE RESPONSIBLE FOR VERIFYING ALL DIMENSIONS AND LOCATIONS OF ALL ELECTRICAL EQUIPMENT PRIOR TO SUBMITTING A BID.
4. THE ELECTRICAL CONTRACTOR SHALL BE RESPONSIBLE FOR VERIFYING ALL DIMENSIONS AND LOCATIONS OF ALL ELECTRICAL EQUIPMENT PRIOR TO SUBMITTING A BID. THE CONTRACTOR SHALL BE RESPONSIBLE FOR VERIFYING ALL DIMENSIONS AND LOCATIONS OF ALL ELECTRICAL EQUIPMENT PRIOR TO SUBMITTING A BID. THE CONTRACTOR SHALL BE RESPONSIBLE FOR VERIFYING ALL DIMENSIONS AND LOCATIONS OF ALL ELECTRICAL EQUIPMENT PRIOR TO SUBMITTING A BID.
5. MAINTAIN ACCURATE RECORDS OF ALL CHANGES MADE DURING CONSTRUCTION. PROVIDE THE OWNER WITH A COMPLETE SET OF AS-BUILT DRAWINGS UPON COMPLETION OF THE PROJECT, INCLUDING ALL FIELD CHANGES.
6. PROVIDE ALL REQUIRED LABOR, MATERIALS, EQUIPMENT, AND CONTRACTOR SERVICES ON THE DOMAINS COMPLETE WITH ALL RELATED WORK AND VALUE. THE CONTRACTOR SHALL BE RESPONSIBLE FOR VERIFYING ALL DIMENSIONS AND LOCATIONS OF ALL ELECTRICAL EQUIPMENT PRIOR TO SUBMITTING A BID. THE CONTRACTOR SHALL BE RESPONSIBLE FOR VERIFYING ALL DIMENSIONS AND LOCATIONS OF ALL ELECTRICAL EQUIPMENT PRIOR TO SUBMITTING A BID.
7. COORDINATE ALL WORK WITH OWNER AND OTHER CONTRACTORS AS REQUIRED.
8. CONTRACTOR SHALL PROVIDE LUG KITS AND FUSED DISCONNECT SWITCHES AT FAN COOL UNIT AND CABINET HEATER AS REQUIRED.
9. REMOVE ALL WIRES NOT REUSED FOR NEW CONSTRUCTION.

NEW PANEL-D

120/208V, 3P, 4W, 200A M.L.O.

LITG - CONFERENCE RM.	20A	2	20A	ROPTS. - CONFERENCE RM.
LITG - PRIN. OFF./WORK RM.	20A	3	20A	ROPTS. - PRINCIPAL OFFICE
LITG - GENERAL OFFICE	20A	4	20A	ROPTS. - WORK RM./GEN. OFF.
LITG - WAITING, NURSE, HALL	20A	5	20A	ROPTS. - GENERAL OFFICE
LITG - EXTERIOR CANOPY	20A	6	20A	ROPTS. - WAITING
FC-1	20A	7	20A	ROPTS. - NURSES OFFICE
PLUG MOLD RMS. 202 THRU 205 20A	20A	8	20A	PLUG MOLD EAST WALL RM. 203
PLUG MOLD RMS. 202 THRU 205 20A	20A	9	20A	PLUG MOLD EAST WALL RM. 203
PLUG MOLD RMS. 202 THRU 205 20A	20A	10	20A	PLUG MOLD EAST WALL RM. 202
SPARE	20A	11	20A	PLUG MOLD EAST WALL RM. 202
SPARE	20A	12	20A	PLUG MOLD EAST WALL RM. 204
SPARE	20A	13	20A	PLUG MOLD EAST WALL RM. 204
SPARE	20A	14	20A	PLUG MOLD EAST WALL RM. 204
SPARE	20A	15	20A	PLUG MOLD EAST WALL RM. 204
SPARE	20A	16	20A	PLUG MOLD EAST WALL RM. 205
SPARE	20A	17	20A	PLUG MOLD EAST WALL RM. 205
SPARE	20A	18	20A	PLUG MOLD EAST WALL RM. 205
SPARE	20A	19	20A	PLUG MOLD EAST WALL RM. 205
SPARE	20A	20	20A	PLUG MOLD EAST WALL RM. 205
SPACE	20A	21	20A	SPACE
SPACE	20A	22	20A	SPACE
SPACE	20A	23	20A	SPACE
SPACE	20A	24	20A	SPACE
SPACE	20A	25	20A	SPACE
SPACE	20A	26	20A	SPACE
SPACE	20A	27	20A	SPACE
SPACE	20A	28	20A	SPACE
SPACE	20A	29	20A	SPACE
SPACE	20A	30	20A	SPACE
SPACE	20A	31	20A	SPACE
SPACE	20A	32	20A	SPACE
SPACE	20A	33	20A	SPACE
SPACE	20A	34	20A	SPACE
SPACE	20A	35	20A	SPACE
SPACE	20A	36	20A	SPACE
SPACE	20A	37	20A	SPACE
SPACE	20A	38	20A	SPACE
SPACE	20A	39	20A	SPACE
SPACE	20A	40	20A	SPACE
SPACE	20A	41	20A	SPACE
SPACE	20A	42	20A	SPACE
SPACE	20A	43	20A	SPACE
SPACE	20A	44	20A	SPACE
SPACE	20A	45	20A	SPACE
SPACE	20A	46	20A	SPACE
SPACE	20A	47	20A	SPACE
SPACE	20A	48	20A	SPACE
SPACE	20A	49	20A	SPACE
SPACE	20A	50	20A	SPACE

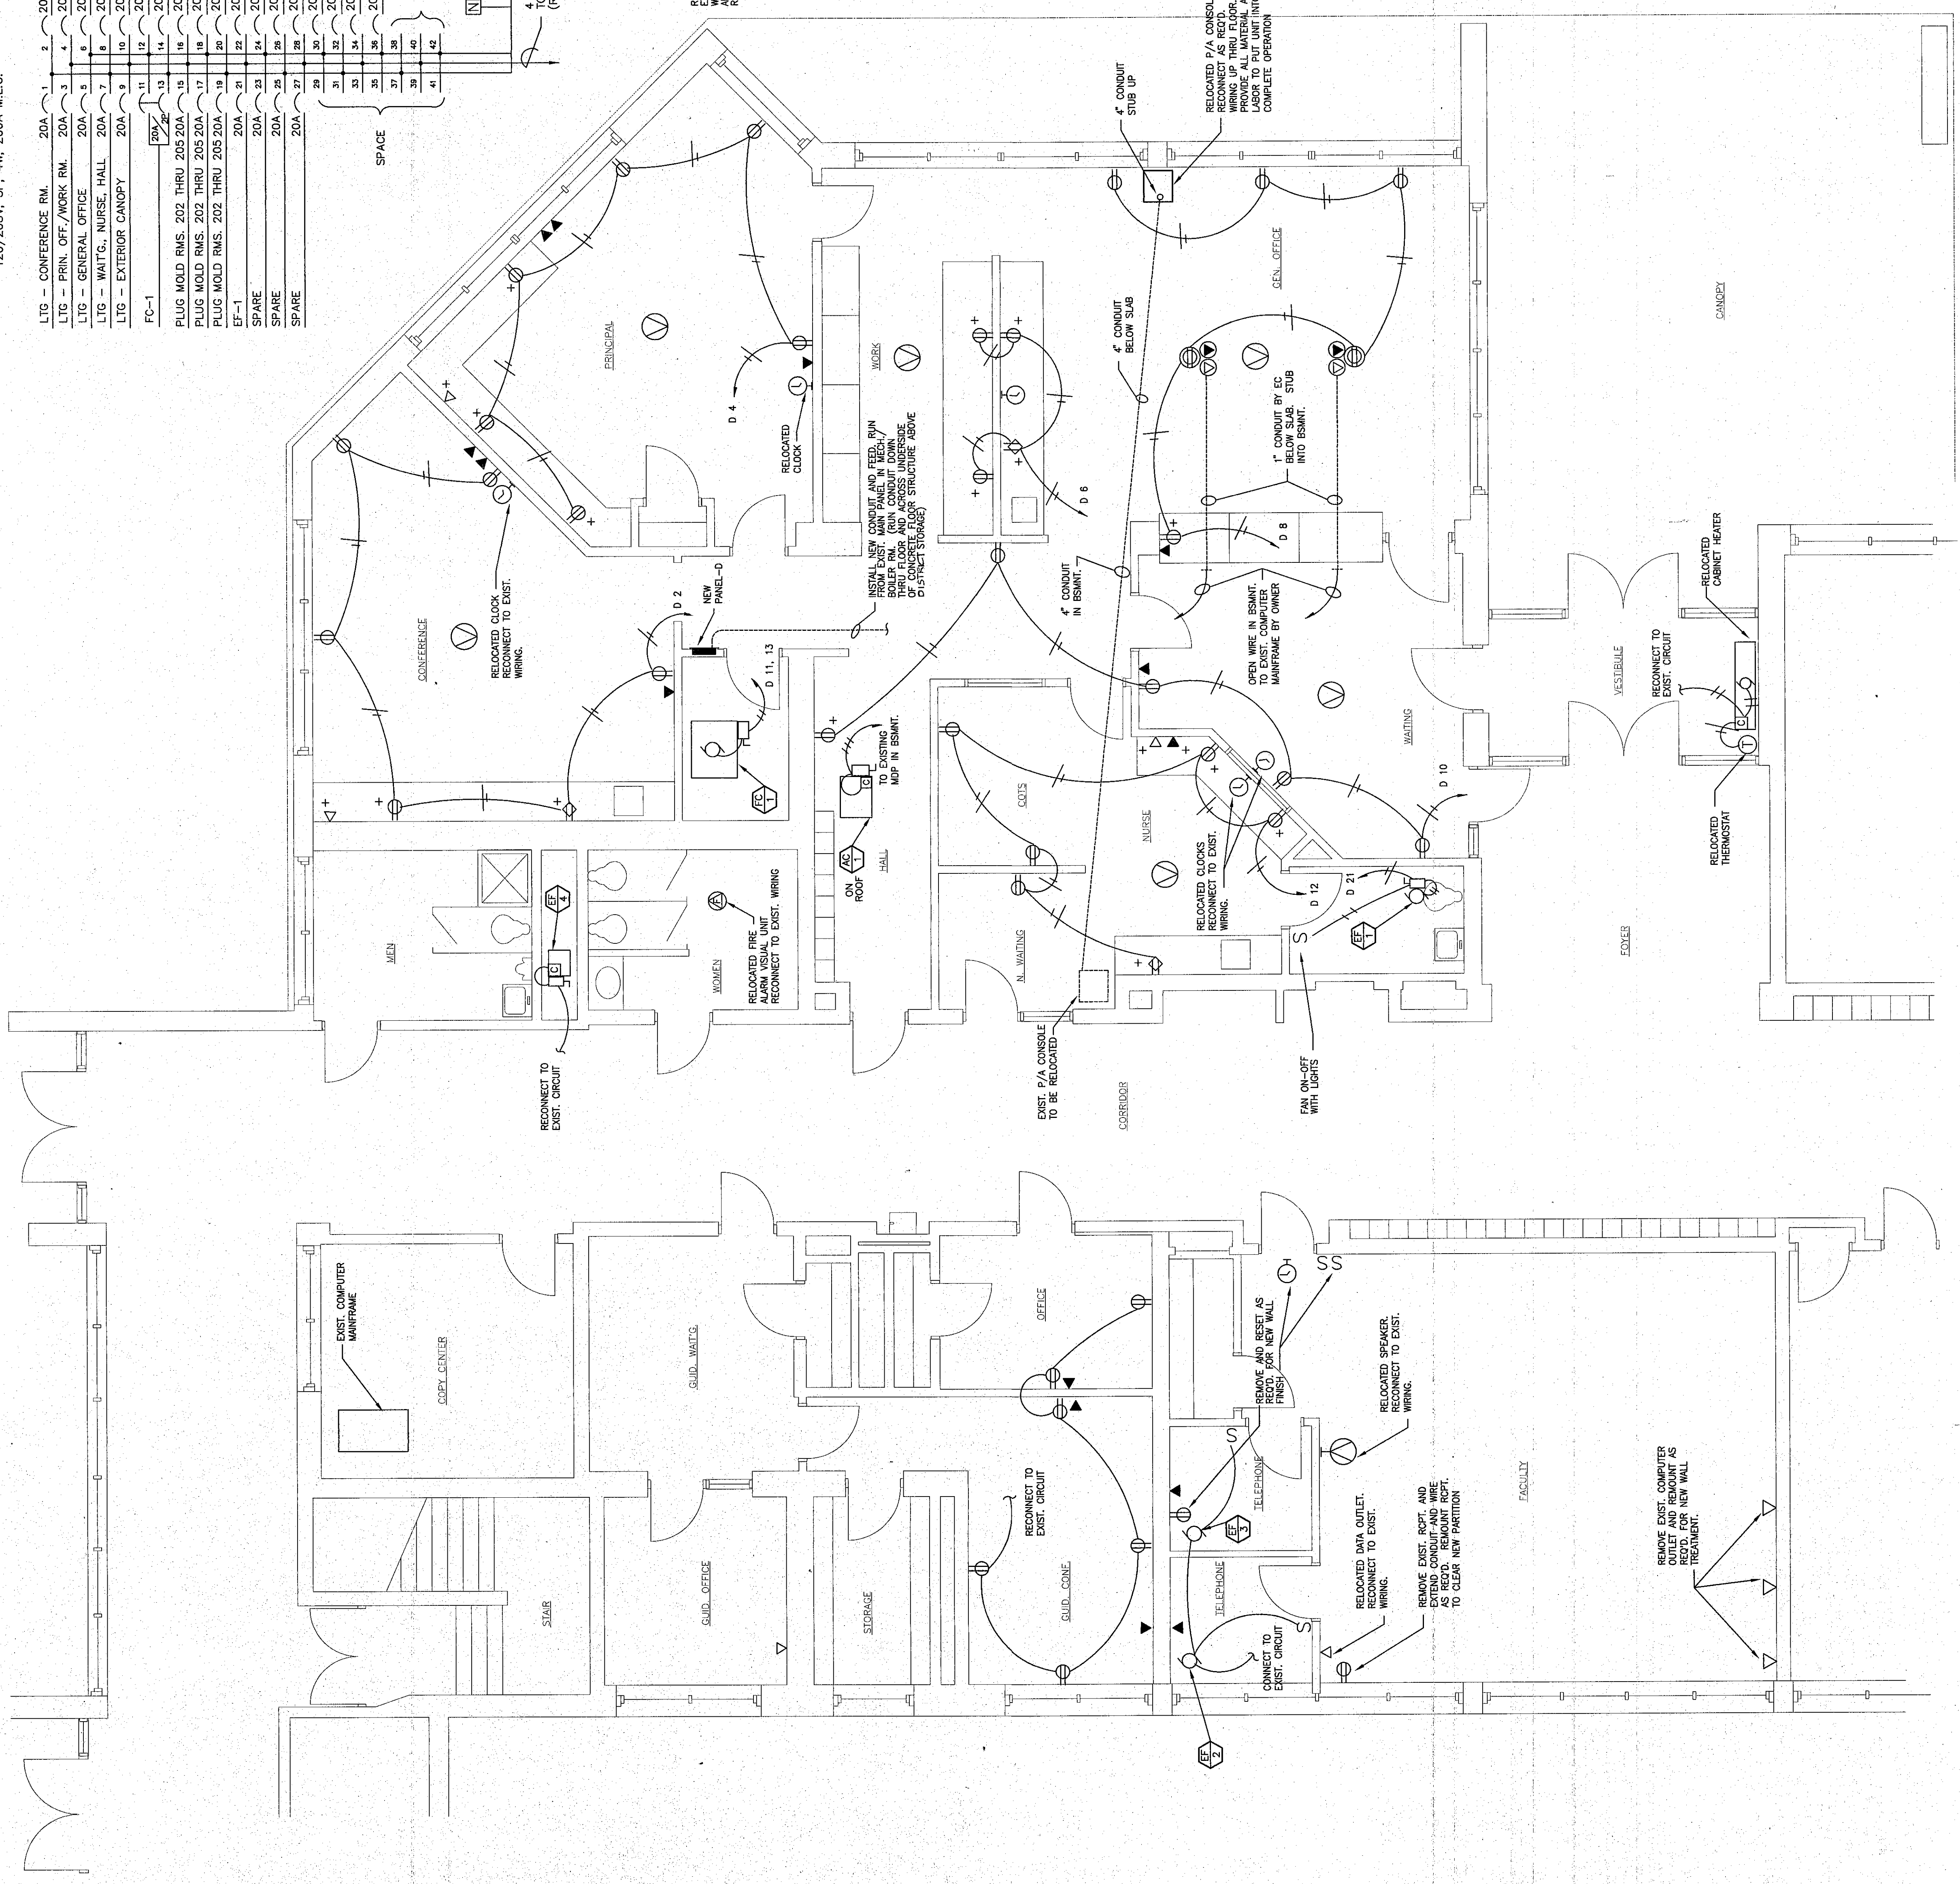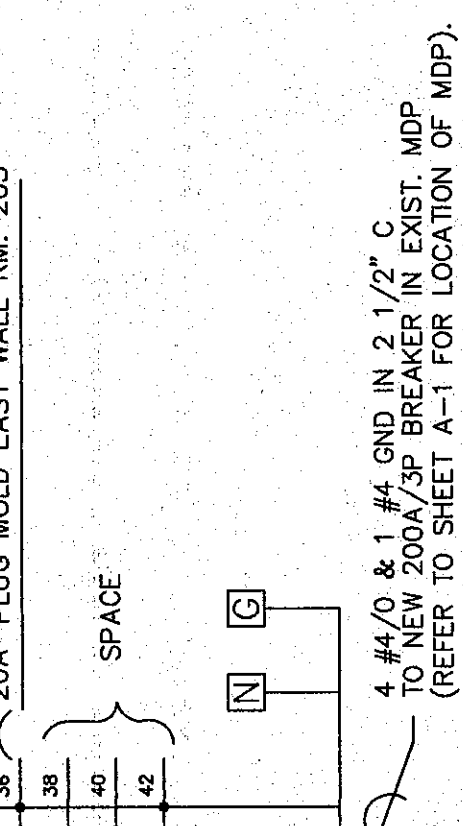

PARTIAL UPPER LEVEL POWER PLAN
SCALE: 1/8" = 1'-0"



YOST P/A CONSOLE E-NOTE:
Present P/A console was installed new during the summer of 1994 by Liberty Sound & Electronics, Inc., 2315 Lincolnway West, South Bend, Indiana 46619; Udo Chad Randart; (219) 232-6977. Scope of P/A console/equipment relocation includes: relocation of P/A console/equipment to new location of unit and new addition specified location; installation of new junction boxes and new 4" dia. PVC conduit for relocation of P/A branch circuit/zone wiring; splicing and extending circuit/zone wiring; running of new 120 V power feed to new P/A console location; relocating AM/FM antenna feed; and testing relocated system for proper operation.

POWER PLAN
SCALE: 1/4" = 1'-0"

