
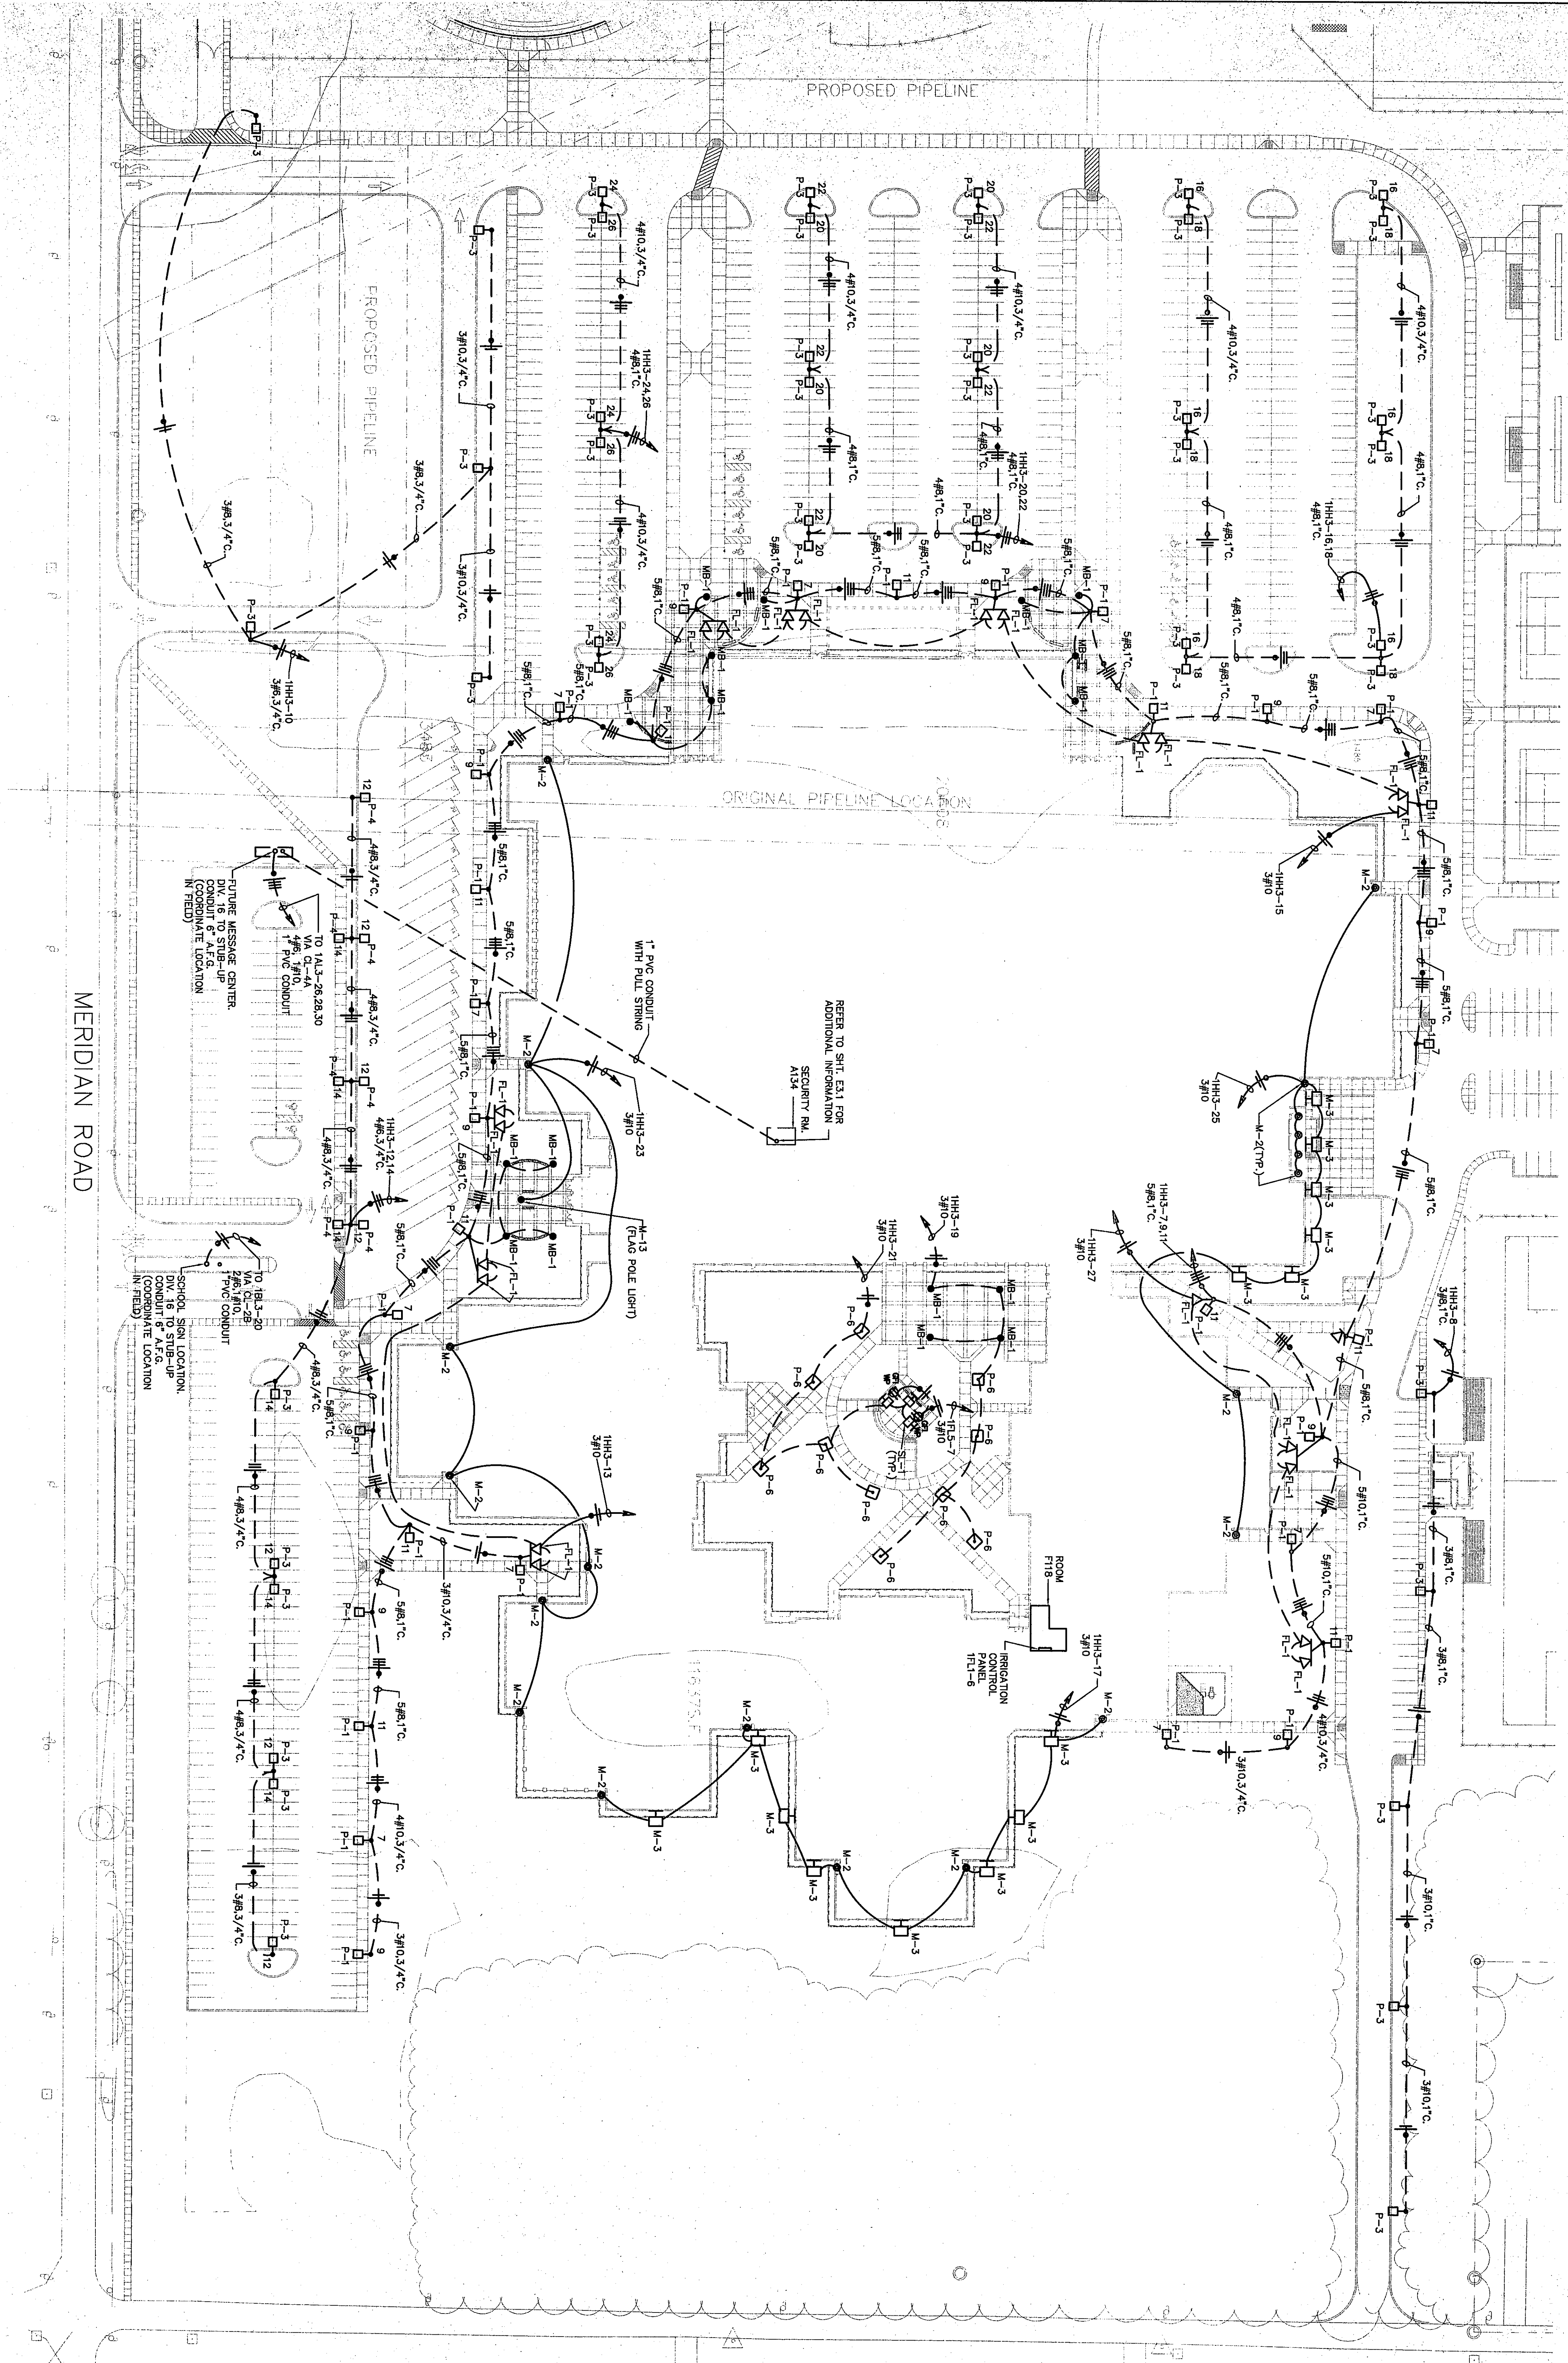


ELECTRICAL SITE PLAN - AREA 1
SCALE 1" = 50'

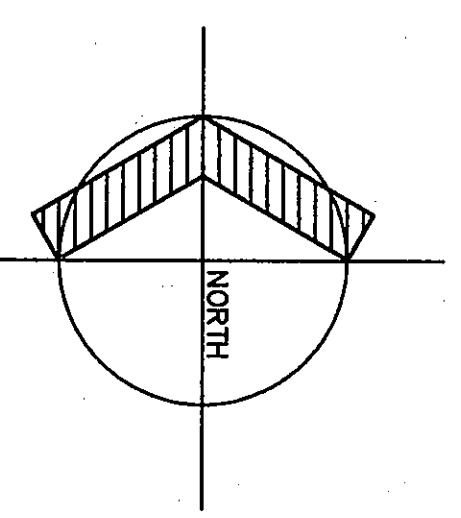

07-E-18

ELECTRICAL SITE PLAN - AREA 1			Fanning/Howey Associates, Inc. Architects Engineers Consultants	THE NEW CHESTERTON HIGH SCHOOL FOR THE DUNELAND SCHOOL CORPORATION CHESTERTON, INDIANA	COPYRIGHT 1997 BY FANNING/HOWEY ASSOCIATES, INC.	
DRAWN BY: MRS	COMM. NO.: 95067.00					
CHECKED BY: WBH	DATE: APRIL 21, 1997					
E2.2						