




81

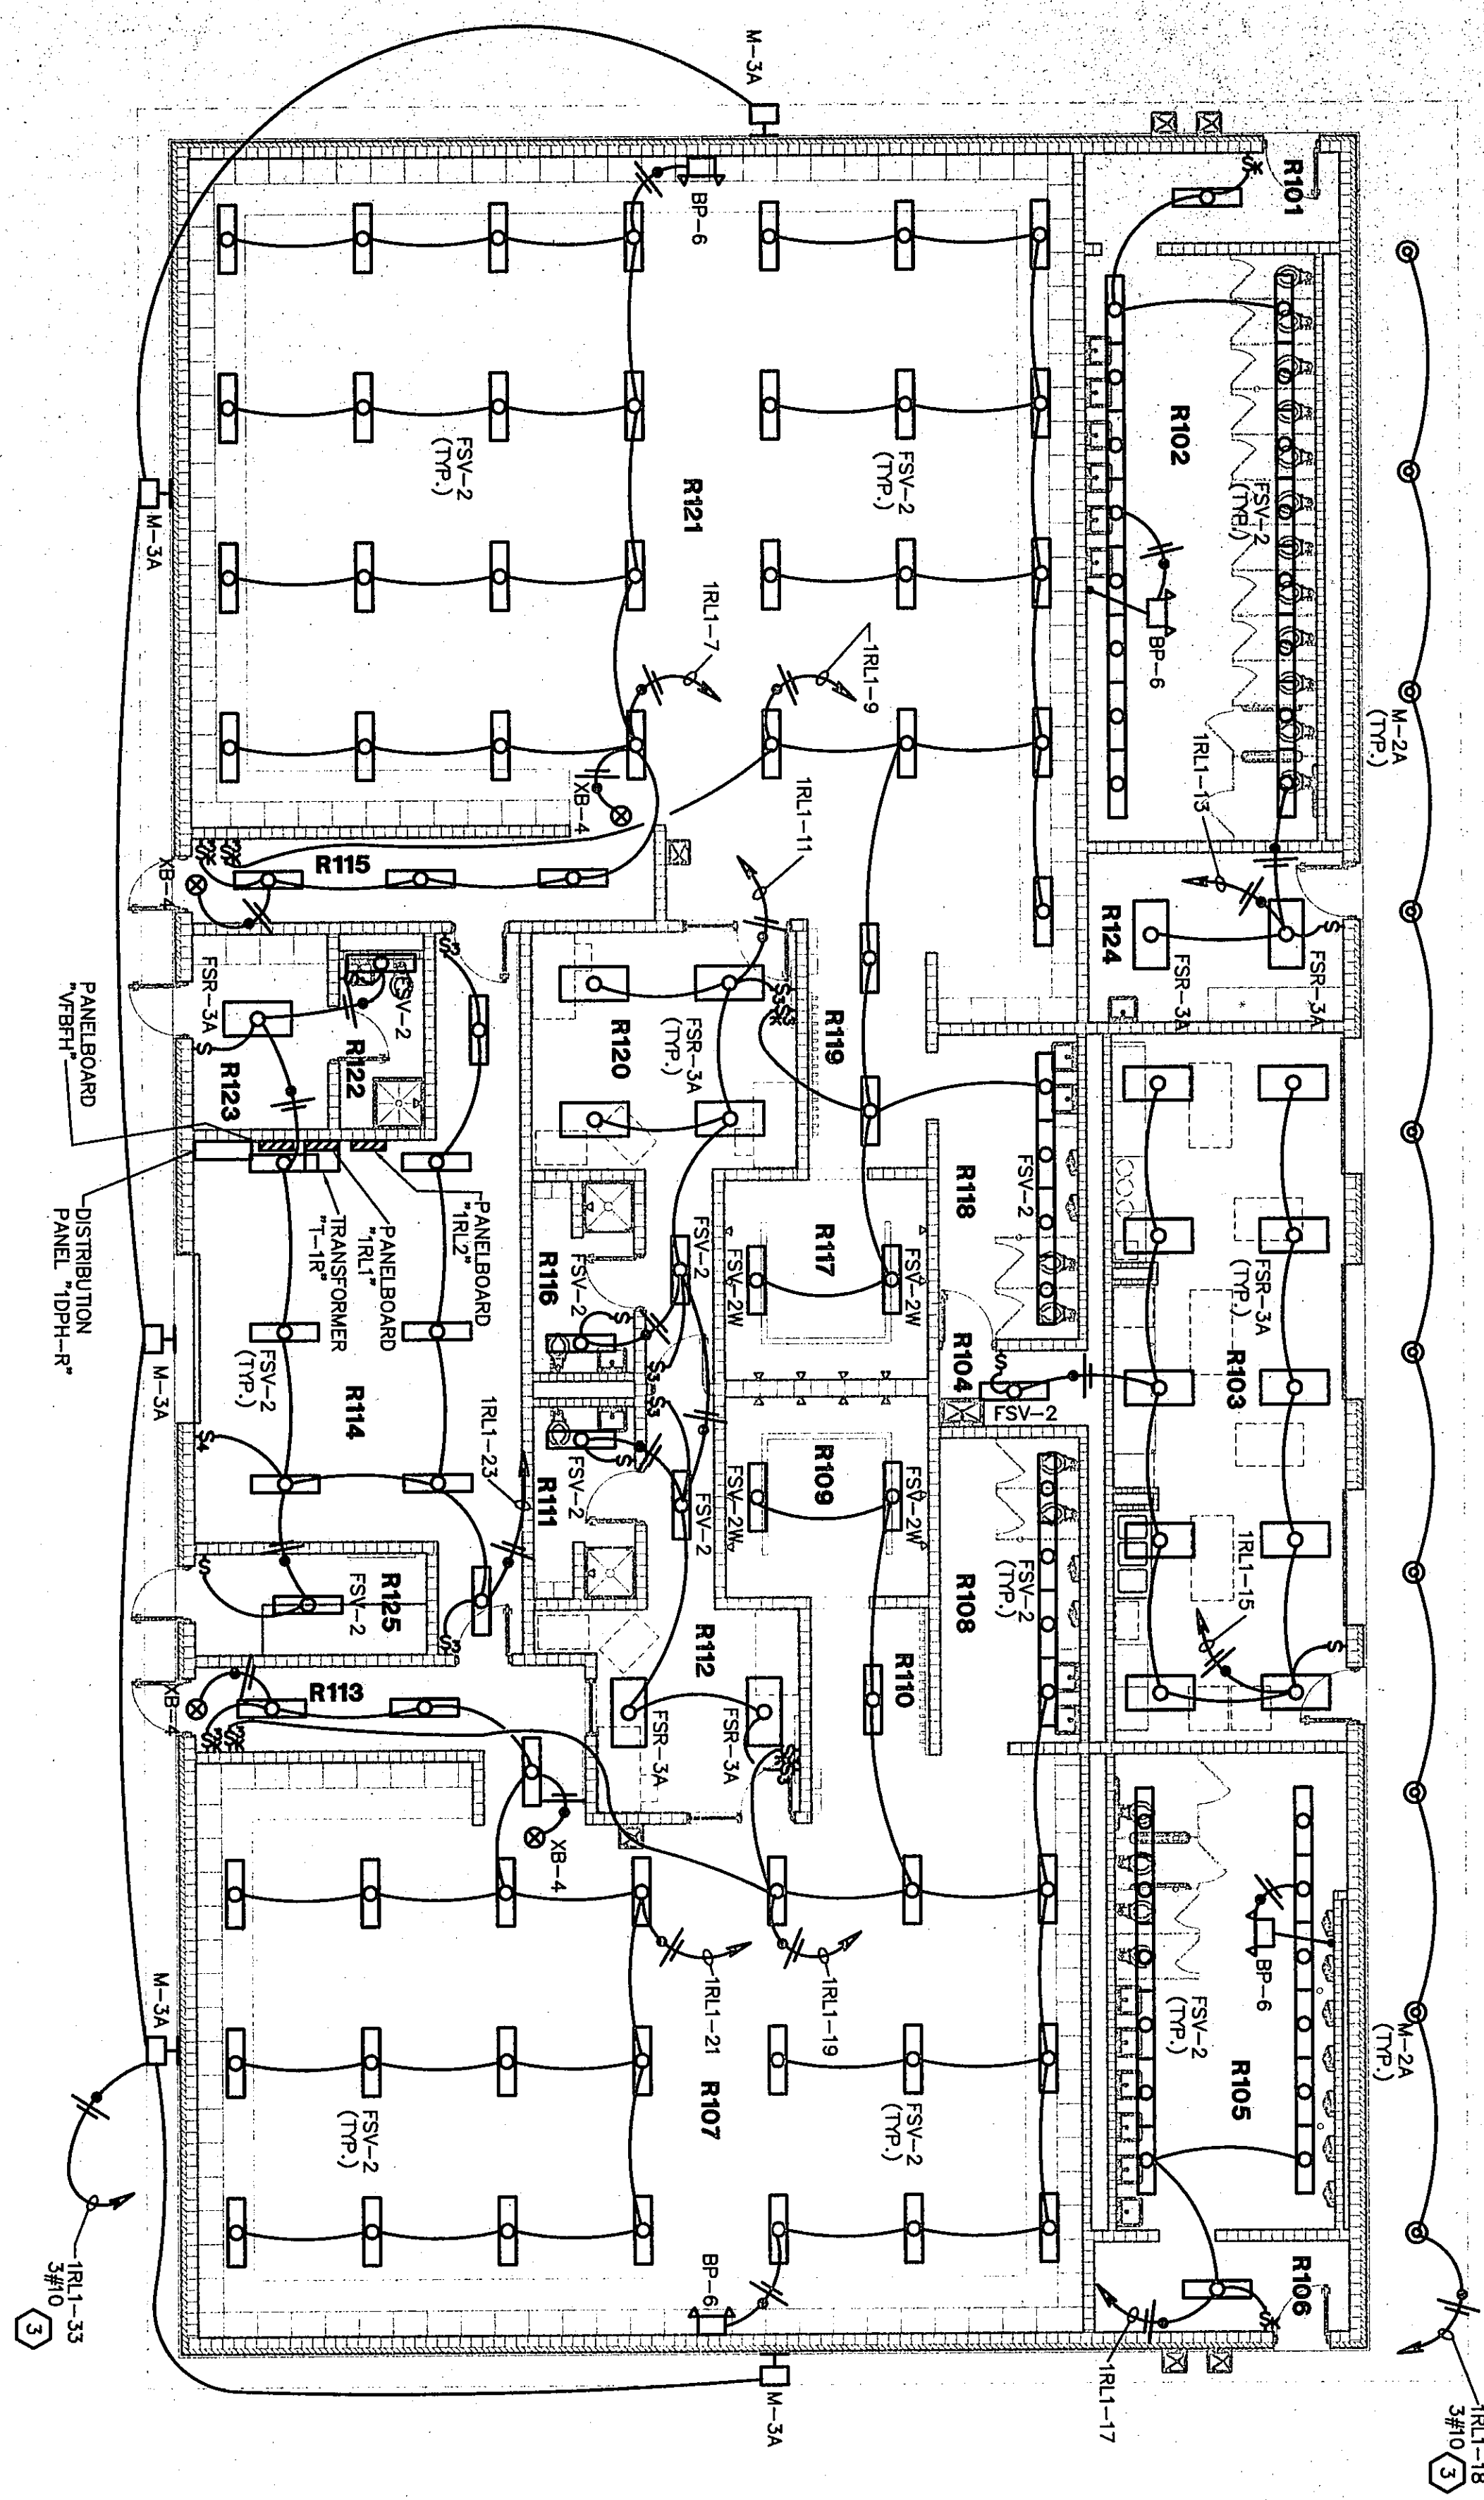

FOOTBALL BUILDING UNIT R
LIGHTING PLAN
SCALE 1/8" = 1'-0"

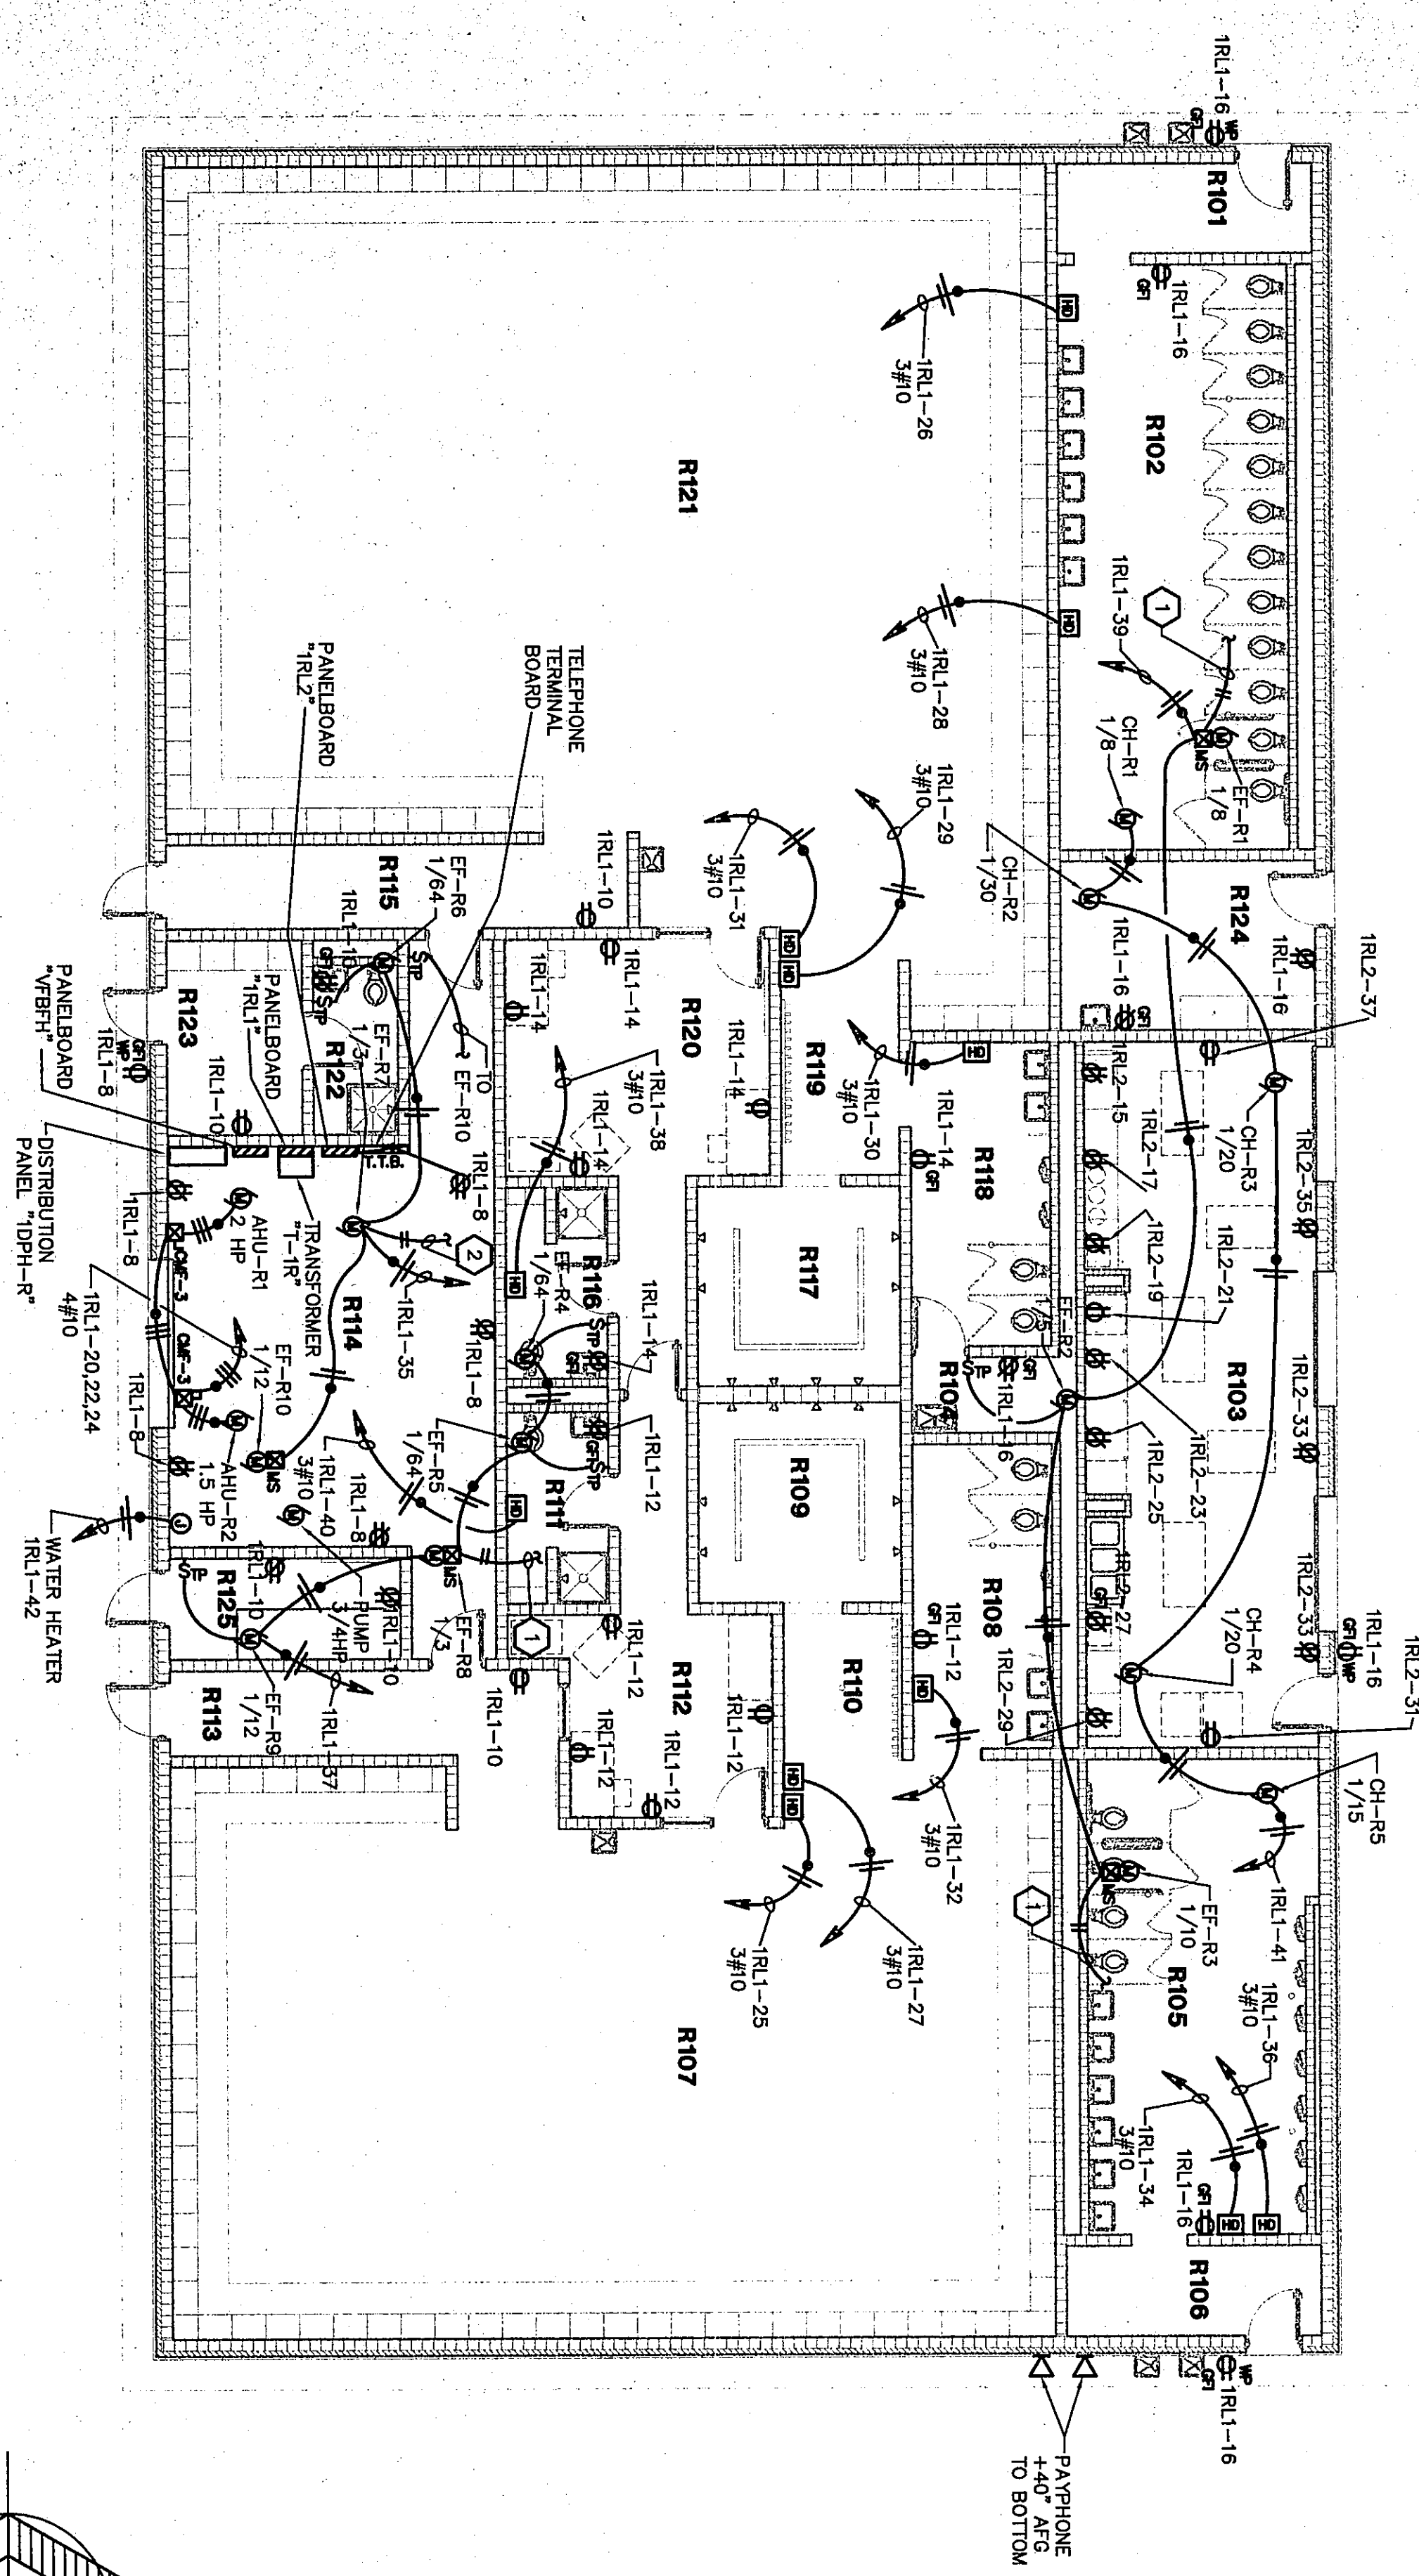

FOOTBALL BUILDING UNIT R
POWER PLAN
SCALE 1/8" = 1'-0"

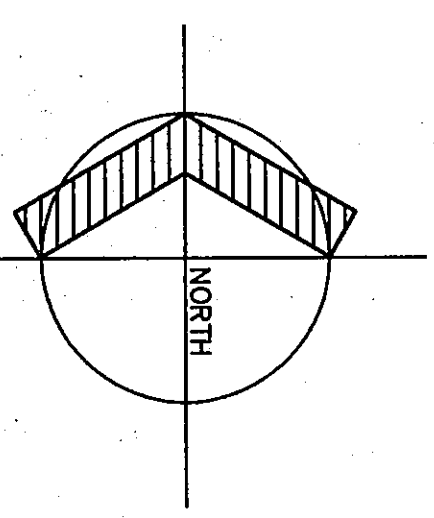

PLAN NOTES:

- 1 PROVIDE EXHAUST FAN STARTER WITH A 277V. COIL WIRE COIL TO THE SMOKE SWITCH LEG AS THE LIGHT FIXTURES IN ROOM R108.
- 2 PROVIDE EXHAUST FAN STARTER WITH A 277V. COIL WIRE COIL TO THE SMOKE SWITCH LEG AS THE LIGHT FIXTURES IN ROOM R118.
- 3 RUN CIRCUIT THRU PHOTO-CELL.
- 4 UNLESS OTHERWISE NOTED ALL EQUIPMENT IS PRE-WIRED AND INSTALLED BY UNIT MANUFACTURER.

ROOM LEGEND "R"	
ROOM NO.	AREA S.F.
R101 VESTIBULE	80
R102 WOMEN'S TOILET	471
R103 CONCESSIONS	568
R104 MEN'S TOILET	371
R105 LOCKER ROOM	807
R106 LOCKER ROOM	1100
R107 LOCKER ROOM	1142
R108 SHOWER	61
R109 SHOWER	204
R110 OFFICE	142
R111 PASSAGE	313
R112 PASSAGE	66
R113 PASSAGE	142
R114 SHOWER	270
R115 SHOWER	88
R116 SHOWER	270
R117 SHOWER	50
R118 LOCKER ROOM	92
R119 LOCKER ROOM	92
R120 LOCKER ROOM	92
R121 LOCKER ROOM	92
R122 LOCKER ROOM	92
R123 LOCKER ROOM	92
R124 LOCKER ROOM	92

LIGHTING PLAN


POWER PLAN

FOOTBALL TICKET BOOTH
SCALE 1/8" = 1'-0"

LIGHTING PLAN


POWER PLAN

RADIO TOWER AND TRANSMITTER ROOM
SCALE 1/8" = 1'-0"

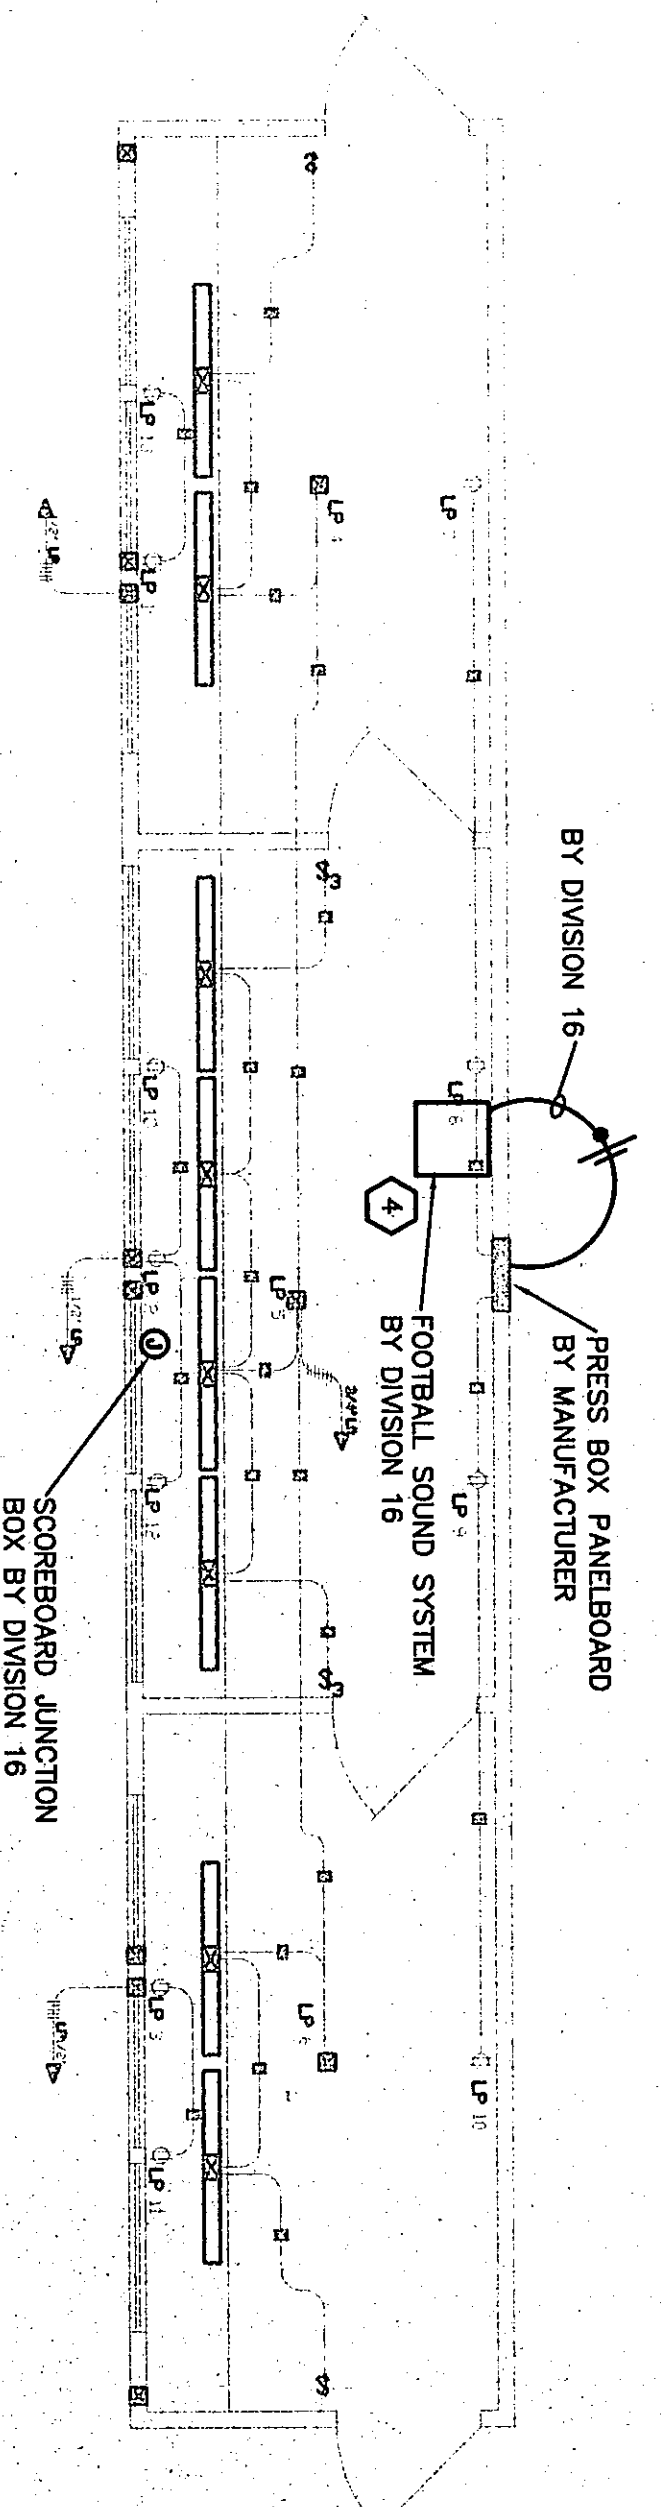

PRE-MANUFACTURED FOOTBALL PRESS BOX - UNIT R
SCALE 1/8" = 1'-0"

COPYRIGHT 1997 BY FANNING/HOWEY ASSOCIATES, INC.

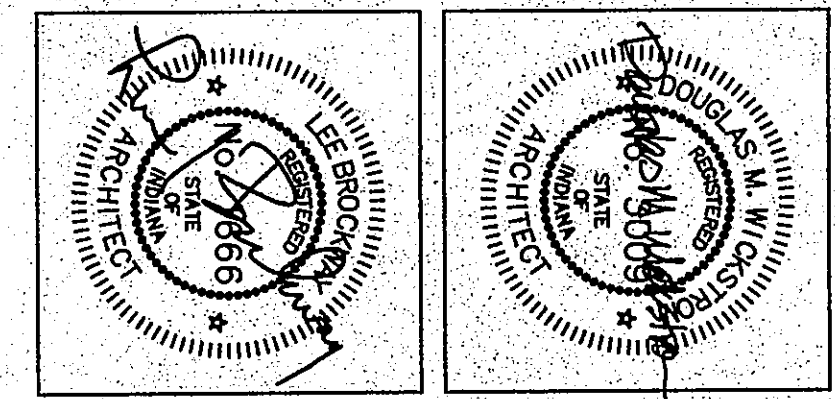

THE NEW
CHESTERTON HIGH SCHOOL
FOR THE
DUNELAND SCHOOL CORPORATION
CHESTERTON, INDIANA

Fanning/Howey Associates, Inc.
Architects Engineers Consultants

SITE BUILDINGS	
DRAWN BY: MRS	COMM. NO.: 95067.00
CHECKED BY: MBH	DATE: APRIL 21, 1997
E2.5	
REVISIONS NO. DATE	
CHESTERTON HIGH SCHOOL 95067.00	