



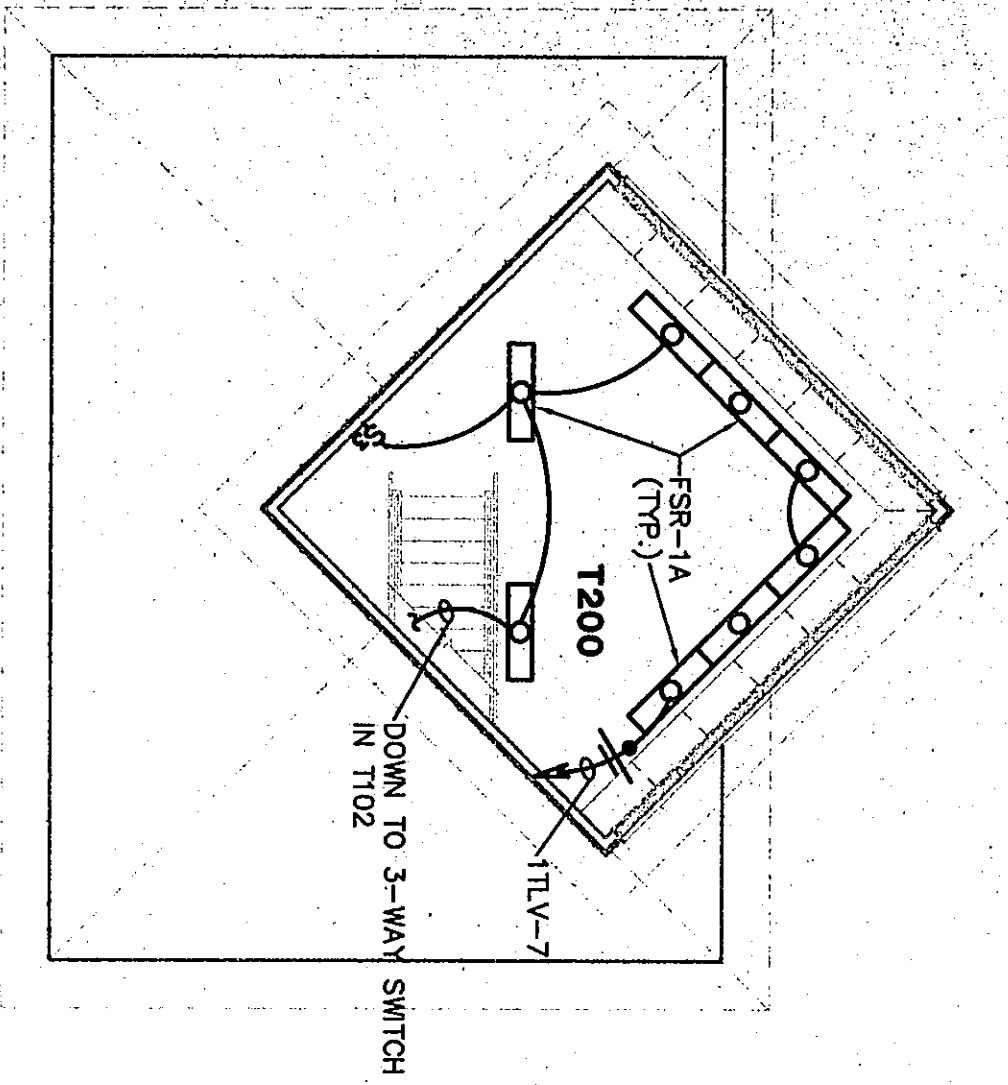


SECOND FLOOR SOFTBALL BUILDING
LIGHTING PLAN
SCALE 1/8" = 1'-0"

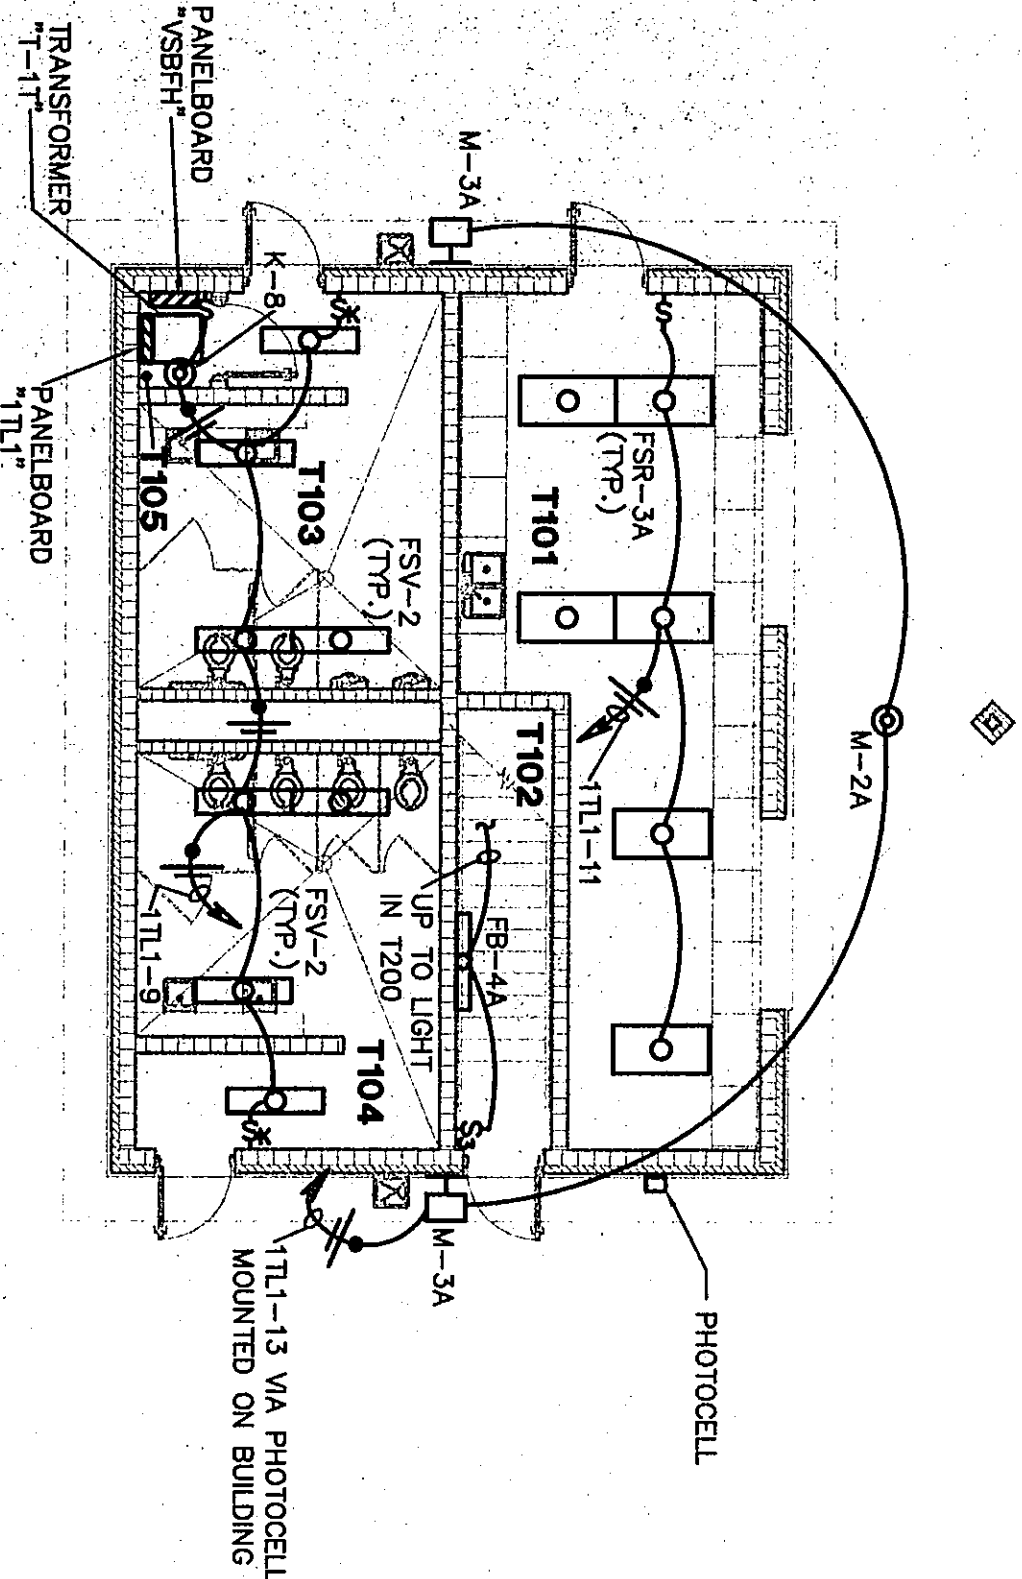


FIRST FLOOR SOFTBALL BUILDING
LIGHTING PLAN
SCALE 1/8" = 1'-0"


ROOM NO.	ROOM NAME	AREA S.F.	CEILING HEIGHT
T101	CONCESSIONS	353	8'-8"
T102	STAIR	73	8'-8"
T103	MEN'S TOILET	189	8'-8"
T104	WOMEN'S TOILET	203	8'-8"
T105	PRESS BOX	351	8'-8"

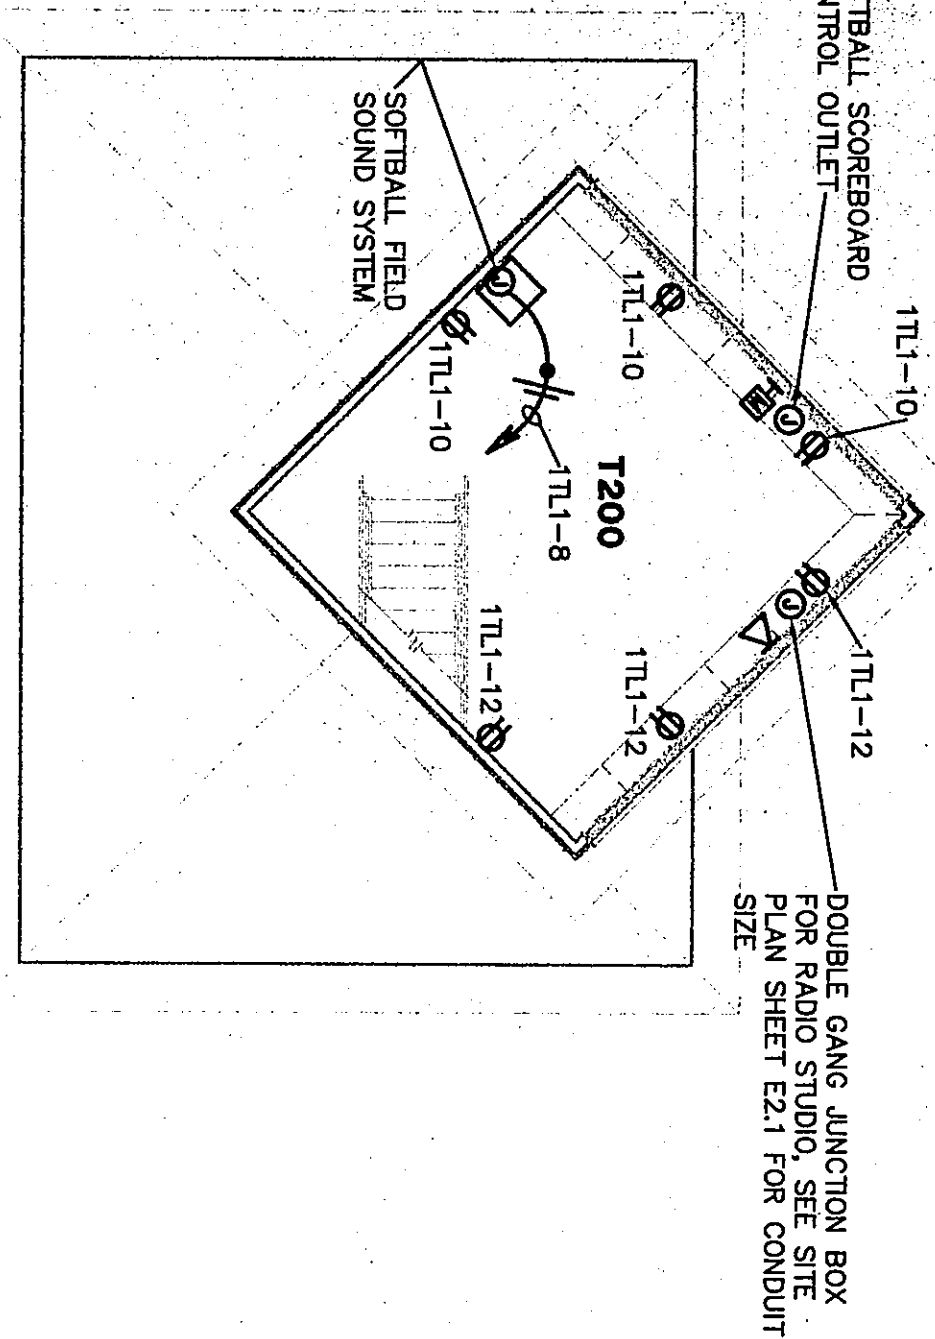


SECOND FLOOR SOFTBALL BUILDING
POWER PLAN
SCALE 1/8" = 1'-0"

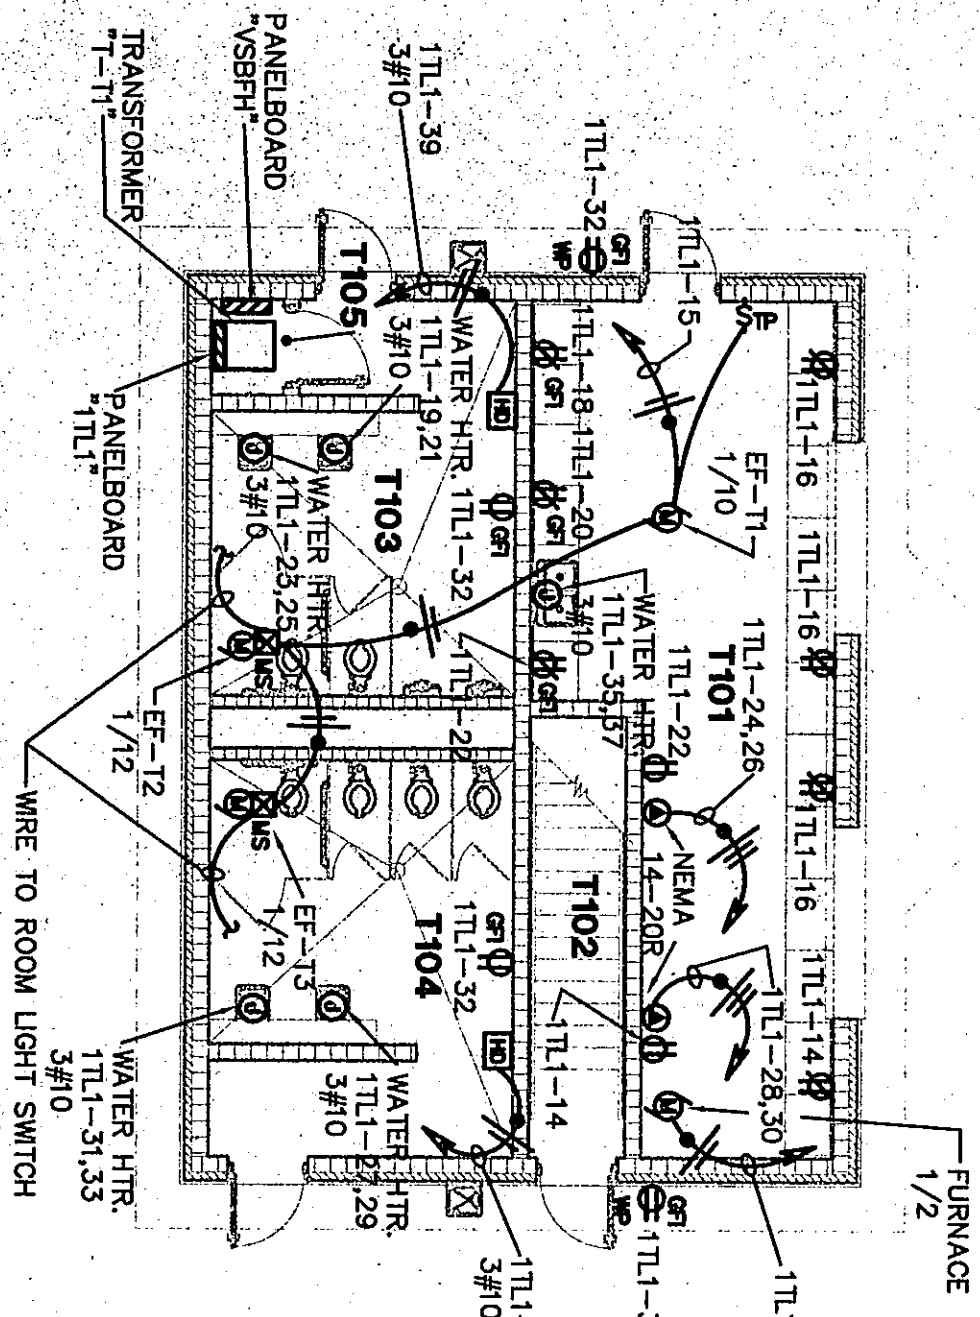

FIRST FLOOR SOFTBALL BUILDING
POWER PLAN
SCALE 1/8" = 1'-0"

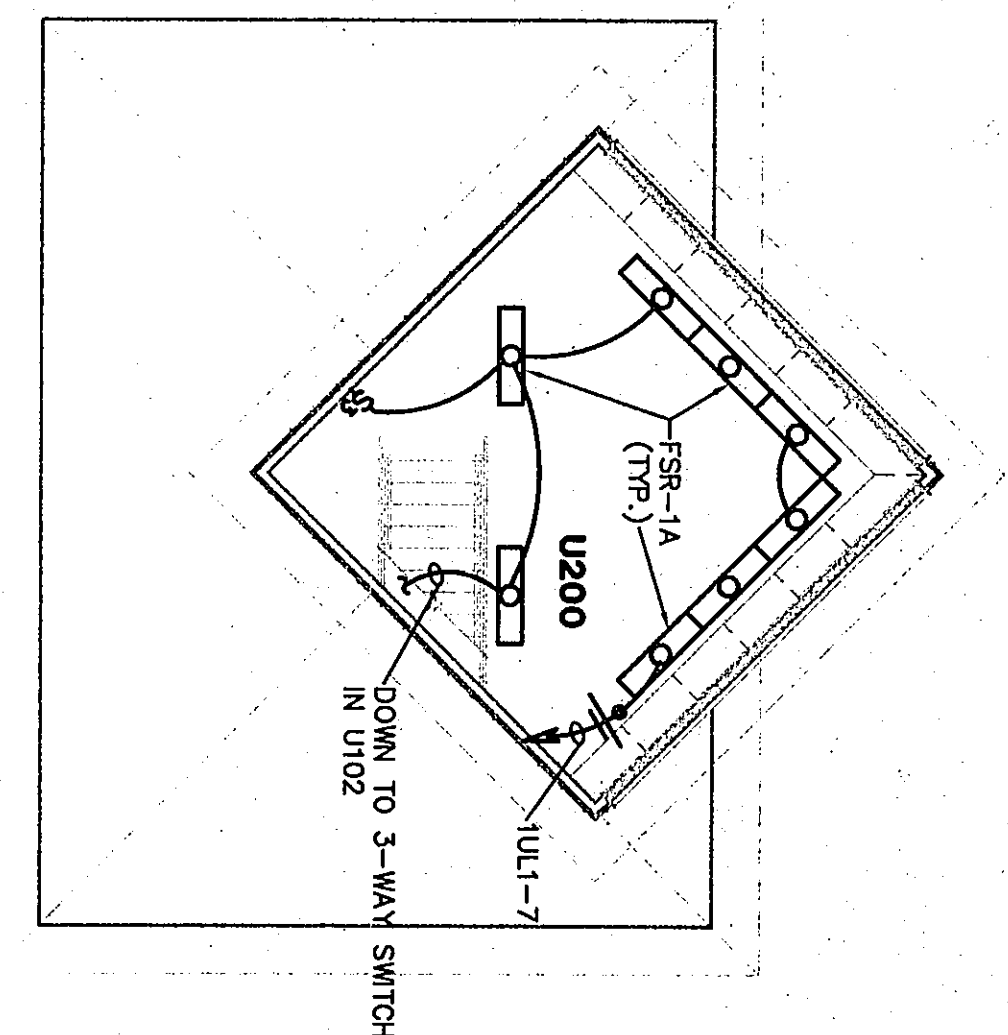


SECOND FLOOR BASEBALL BUILDING
LIGHTING PLAN
SCALE 1/8" = 1'-0"

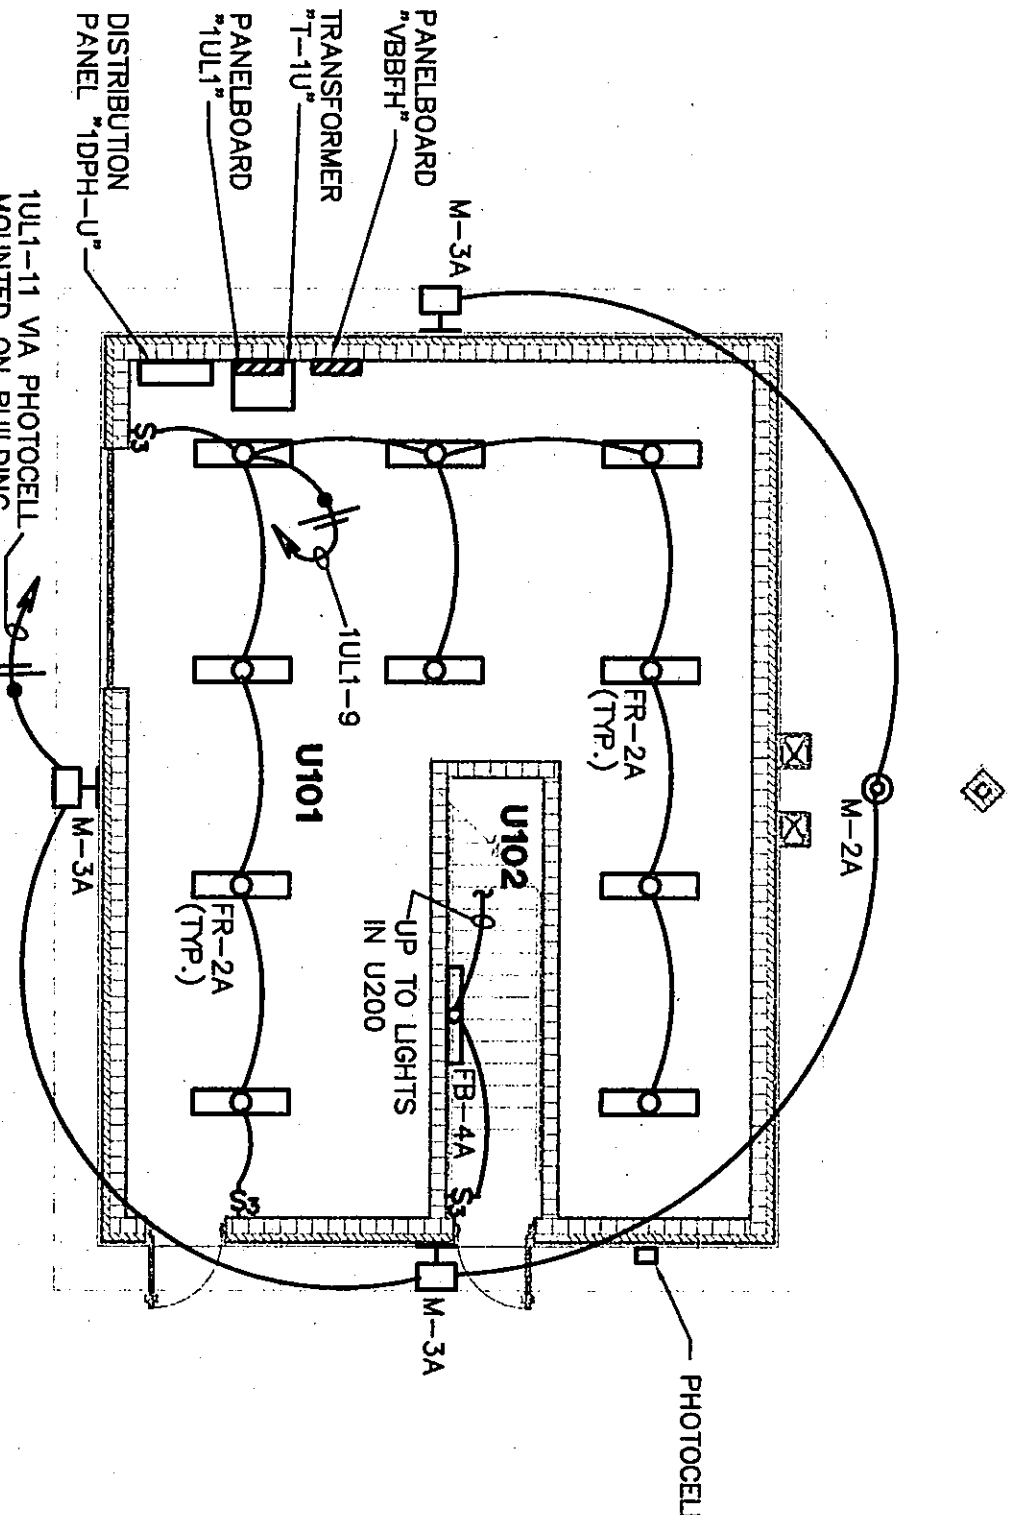


FIRST FLOOR BASEBALL BUILDING
LIGHTING PLAN
SCALE 1/8" = 1'-0"


ROOM NO.	ROOM NAME	AREA S.F.	CEILING HEIGHT
U101	STORAGE	626	8'-8"
U102	STAIR	73	8'-8"
U103	PRESS BOX	351	8'-8"

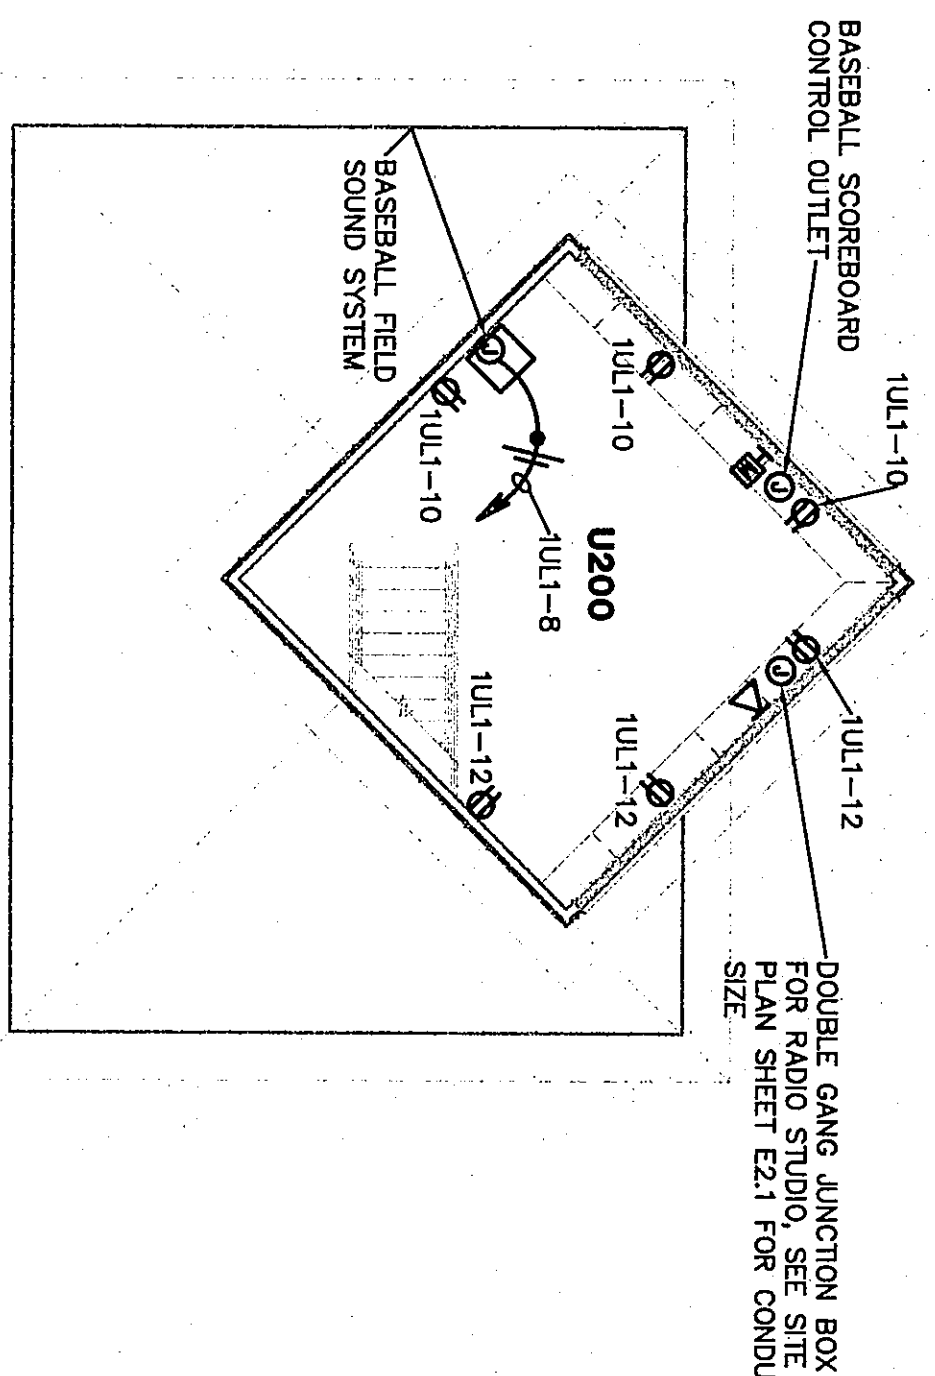


SECOND FLOOR BASEBALL BUILDING
POWER PLAN
SCALE 1/8" = 1'-0"

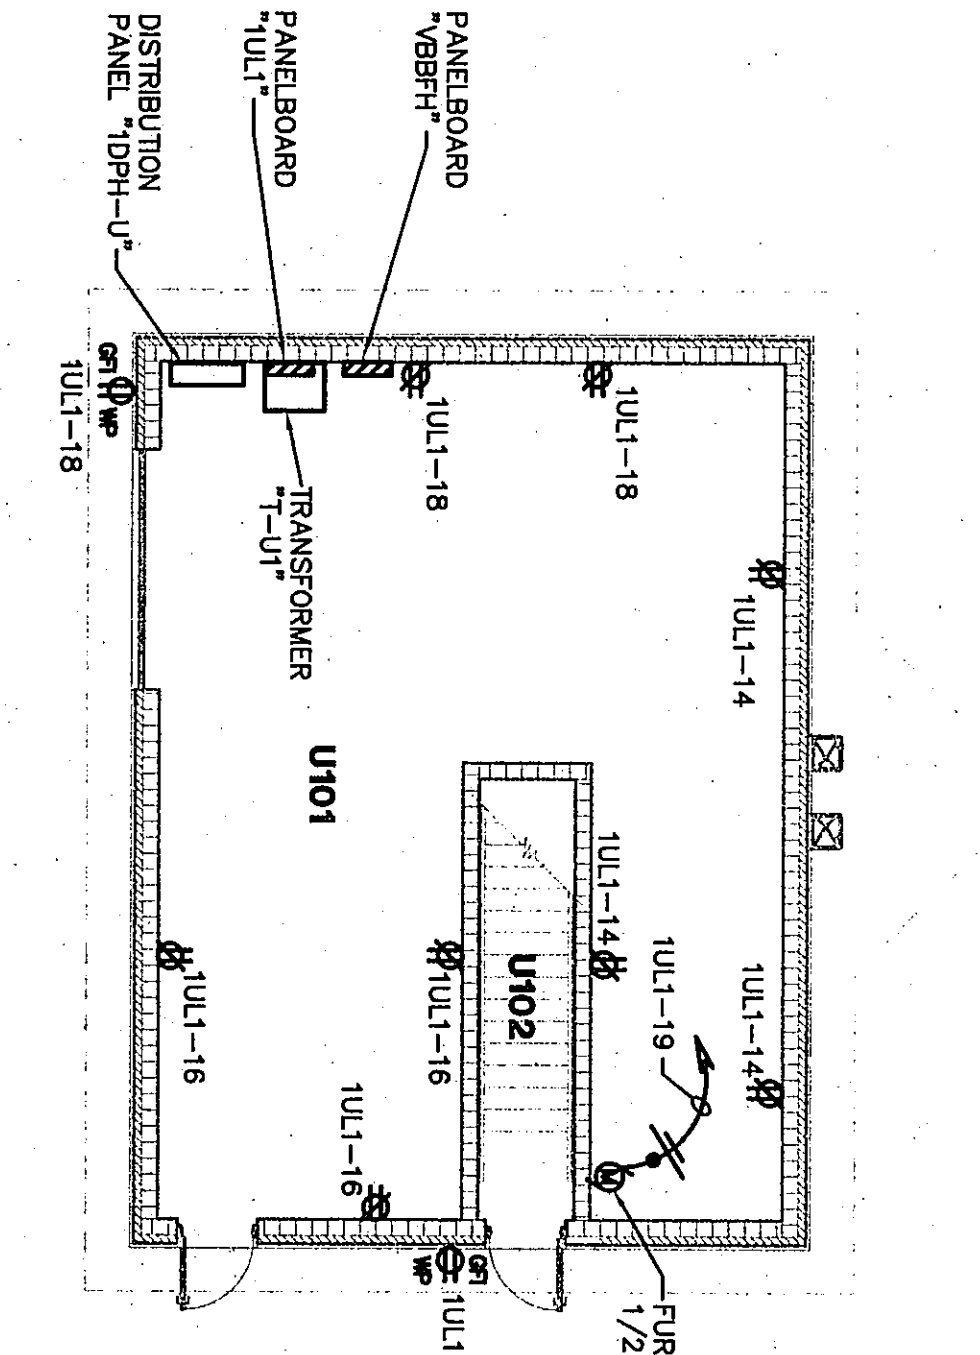

FIRST FLOOR BASEBALL BUILDING
POWER PLAN
SCALE 1/8" = 1'-0"

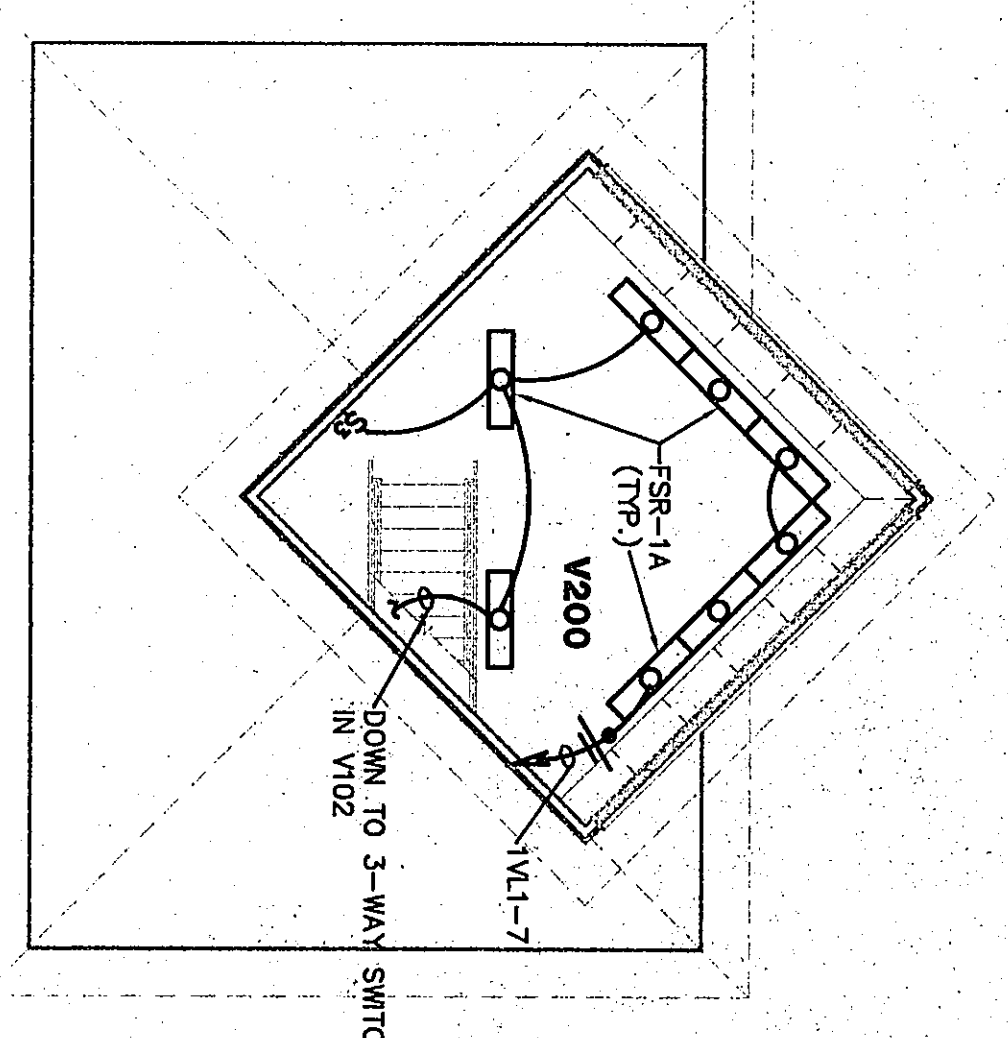


SECOND FLOOR SOCCER BUILDING
LIGHTING PLAN
SCALE 1/8" = 1'-0"

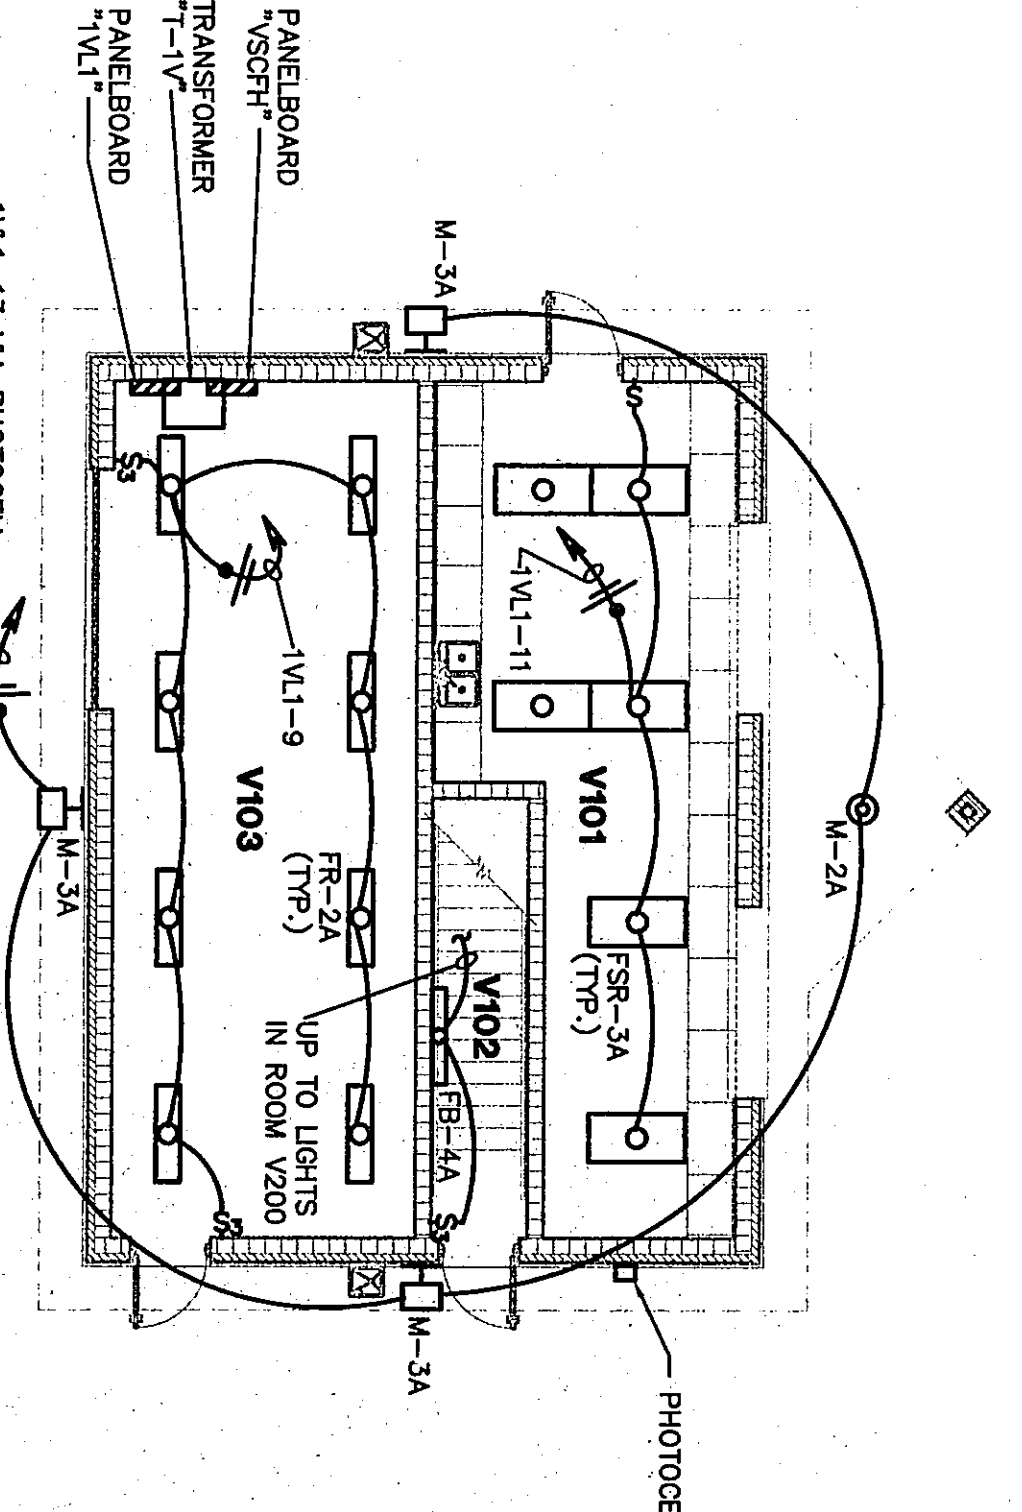


FIRST FLOOR SOCCER BUILDING
LIGHTING PLAN
SCALE 1/8" = 1'-0"

ROOM NO.	ROOM NAME	AREA S.F.	CEILING HEIGHT
V101	CONCESSIONS	353	8'-8"
V102	STAIR	73	8'-8"
V103	STORAGE	482	8'-8"
V104	PRESS BOX	351	8'-8"

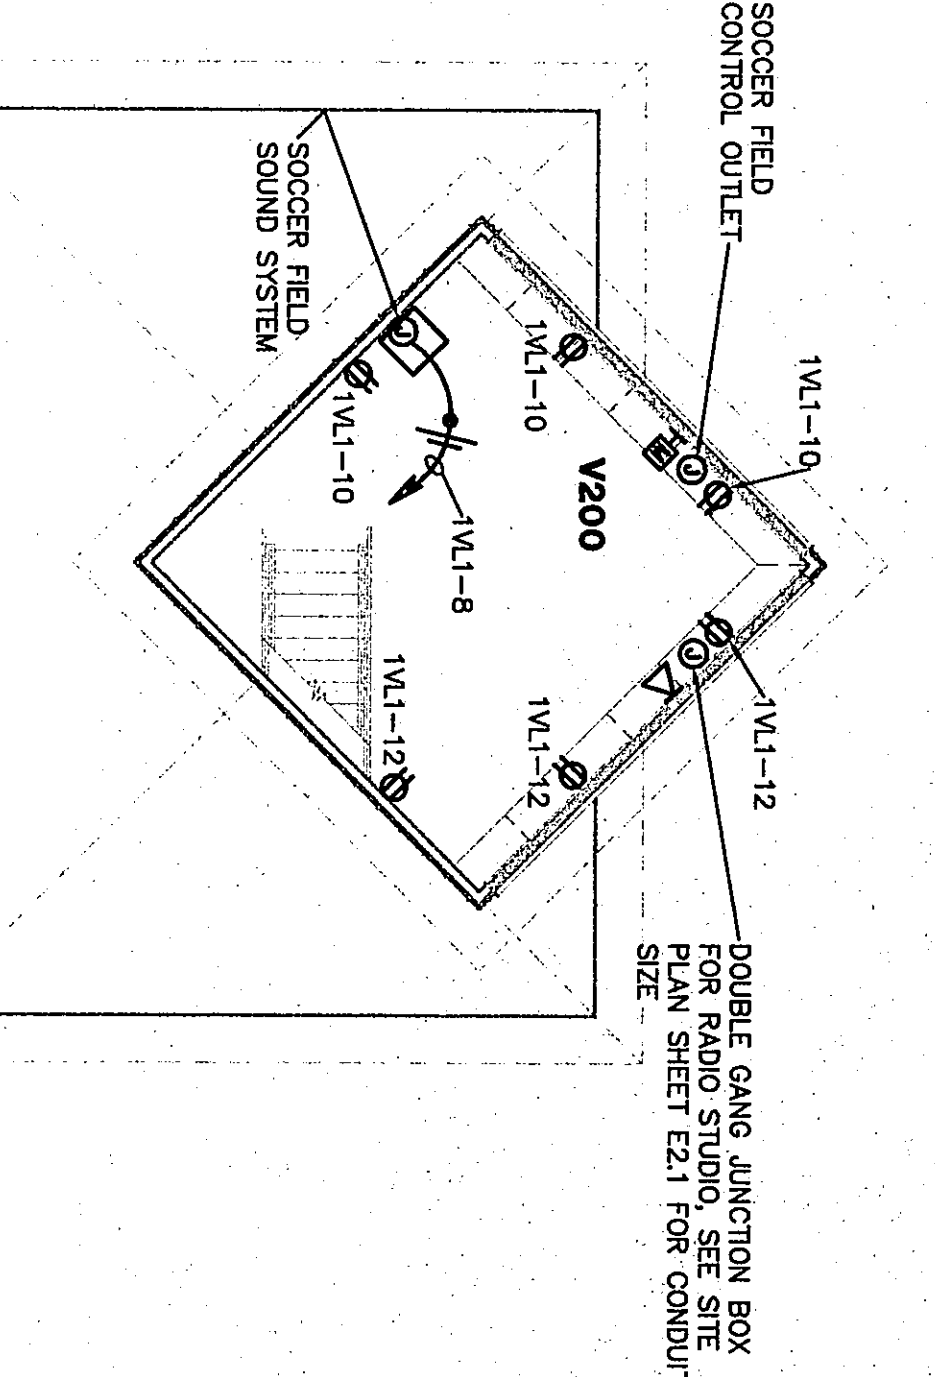

SECOND FLOOR SOCCER BUILDING
POWER PLAN
SCALE 1/8" = 1'-0"

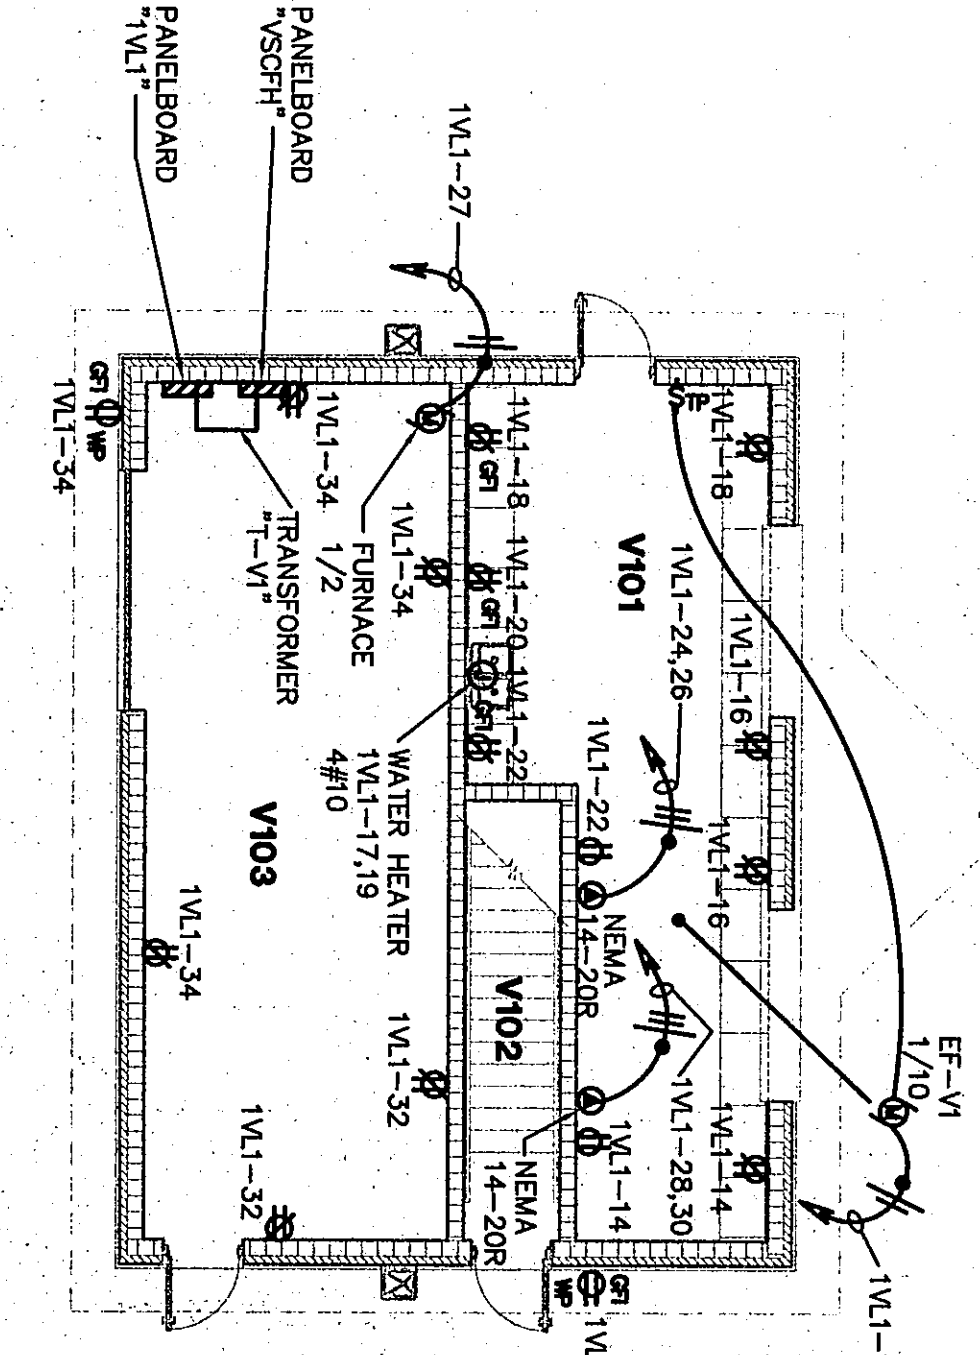

FIRST FLOOR SOCCER BUILDING
POWER PLAN
SCALE 1/8" = 1'-0"

SITE BUILDINGS

DRAWN BY: MRS

COMM. NO.: 95067.00

CHECKED BY: WSH

DATE: APRIL 21, 1997

E2.7

REVISIONS NO. DATE

Fanning/Howey

Associates, Inc.

Architects Engineers Consultants

THE NEW

CHESTERTON HIGH SCHOOL

FOR THE

DUNELAND SCHOOL CORPORATION

CHESTERTON, INDIANA

COPYRIGHT 1997 BY FANNING/HOWEY ASSOCIATES, INC.