


21

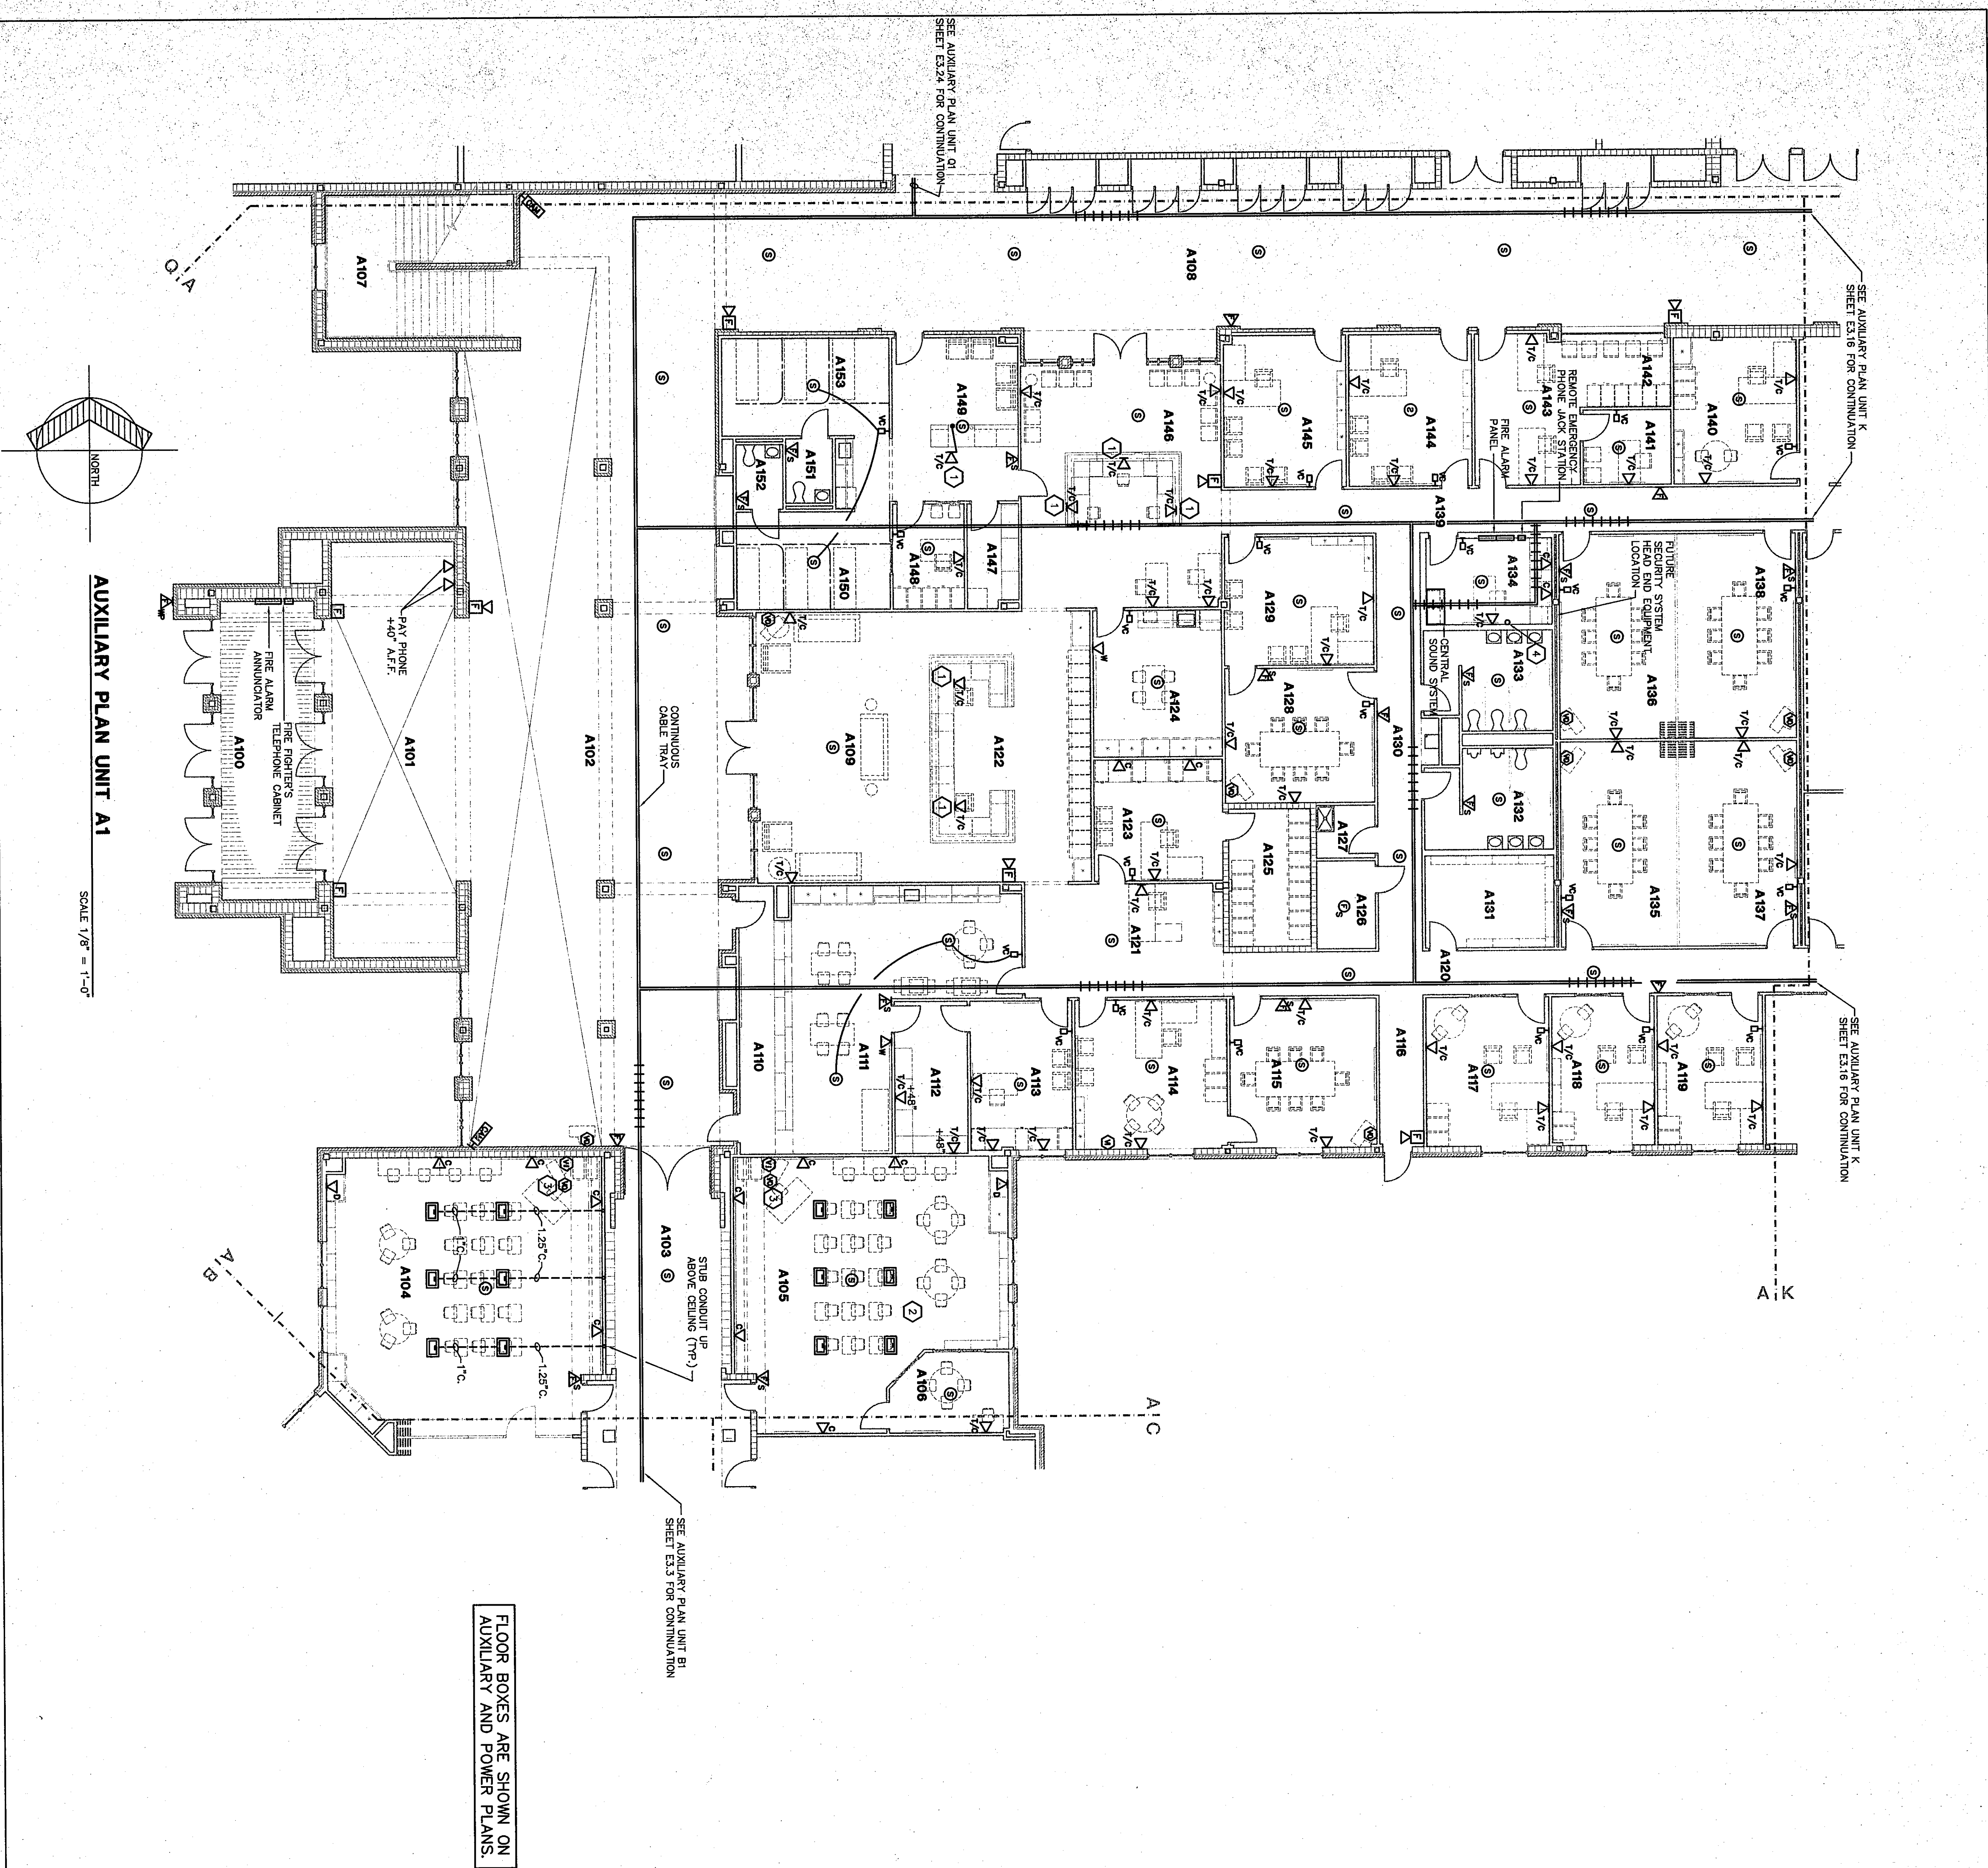

FLOOR BOXES ARE SHOWN ON
AUXILIARY AND POWER PLANS.

PLAN NOTES:

1. STAIR CONDUIT UP THIRD FLOOR AND INTO CHASE OF CASINO. MOUNT TELEPHONE/COMPUTER DETAIL 6/E1.10.
2. REFER TO ROOM A104 FOR TYPICAL DATA CONDUIT ROUTING AND SIZE FOR EACH FLOOR BOX.
3. REFER TO VIDEO ROUGH-IN AND TELEVISION RECEPTACLE LOCATION, DETAIL 6/E1.5 AND 9/E1.5 FOR ADDITIONAL INFORMATION.
4. 1 INCH PVC CONDUIT STAIR-UP 6 INCHES ABOVE FINISH FLOOR FOR FUTURE MESSAGE CENTER. REFER TO SHEET E2.2 FOR ADDITIONAL INFORMATION.

ROOM LEGEND "A1"


ROOM NO.	ROOM NAME	AREA S.F.	CEILING HEIGHT
A100	VESTIBULE	727	10'-0"
A101	RECEPTION	358	10'-0"
A102	COMMONS	358	10'-0"
A103	COMMONS	358	10'-0"
A104	COMMONS	358	10'-0"
A153	COMMONS	358	10'-0"

AUXILIARY PLAN UNIT A1

DRAWN BY: MRS. COMM. NO.: 95067.00
CHECKED BY: WBH DATE: APRIL 21, 1997

E3.1

REVISIONS NO. DATE

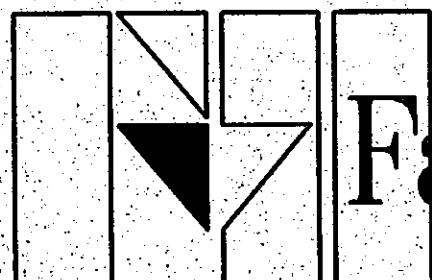

Fanning/Howey Associates, Inc.
Architects Engineers Consultants



THE NEW
CHESTERTON HIGH SCHOOL
FOR THE
DUNELAND SCHOOL CORPORATION
CHESTERTON, INDIANA

COPYRIGHT 1997 BY FANNING/HOWEY ASSOCIATES, INC.

