


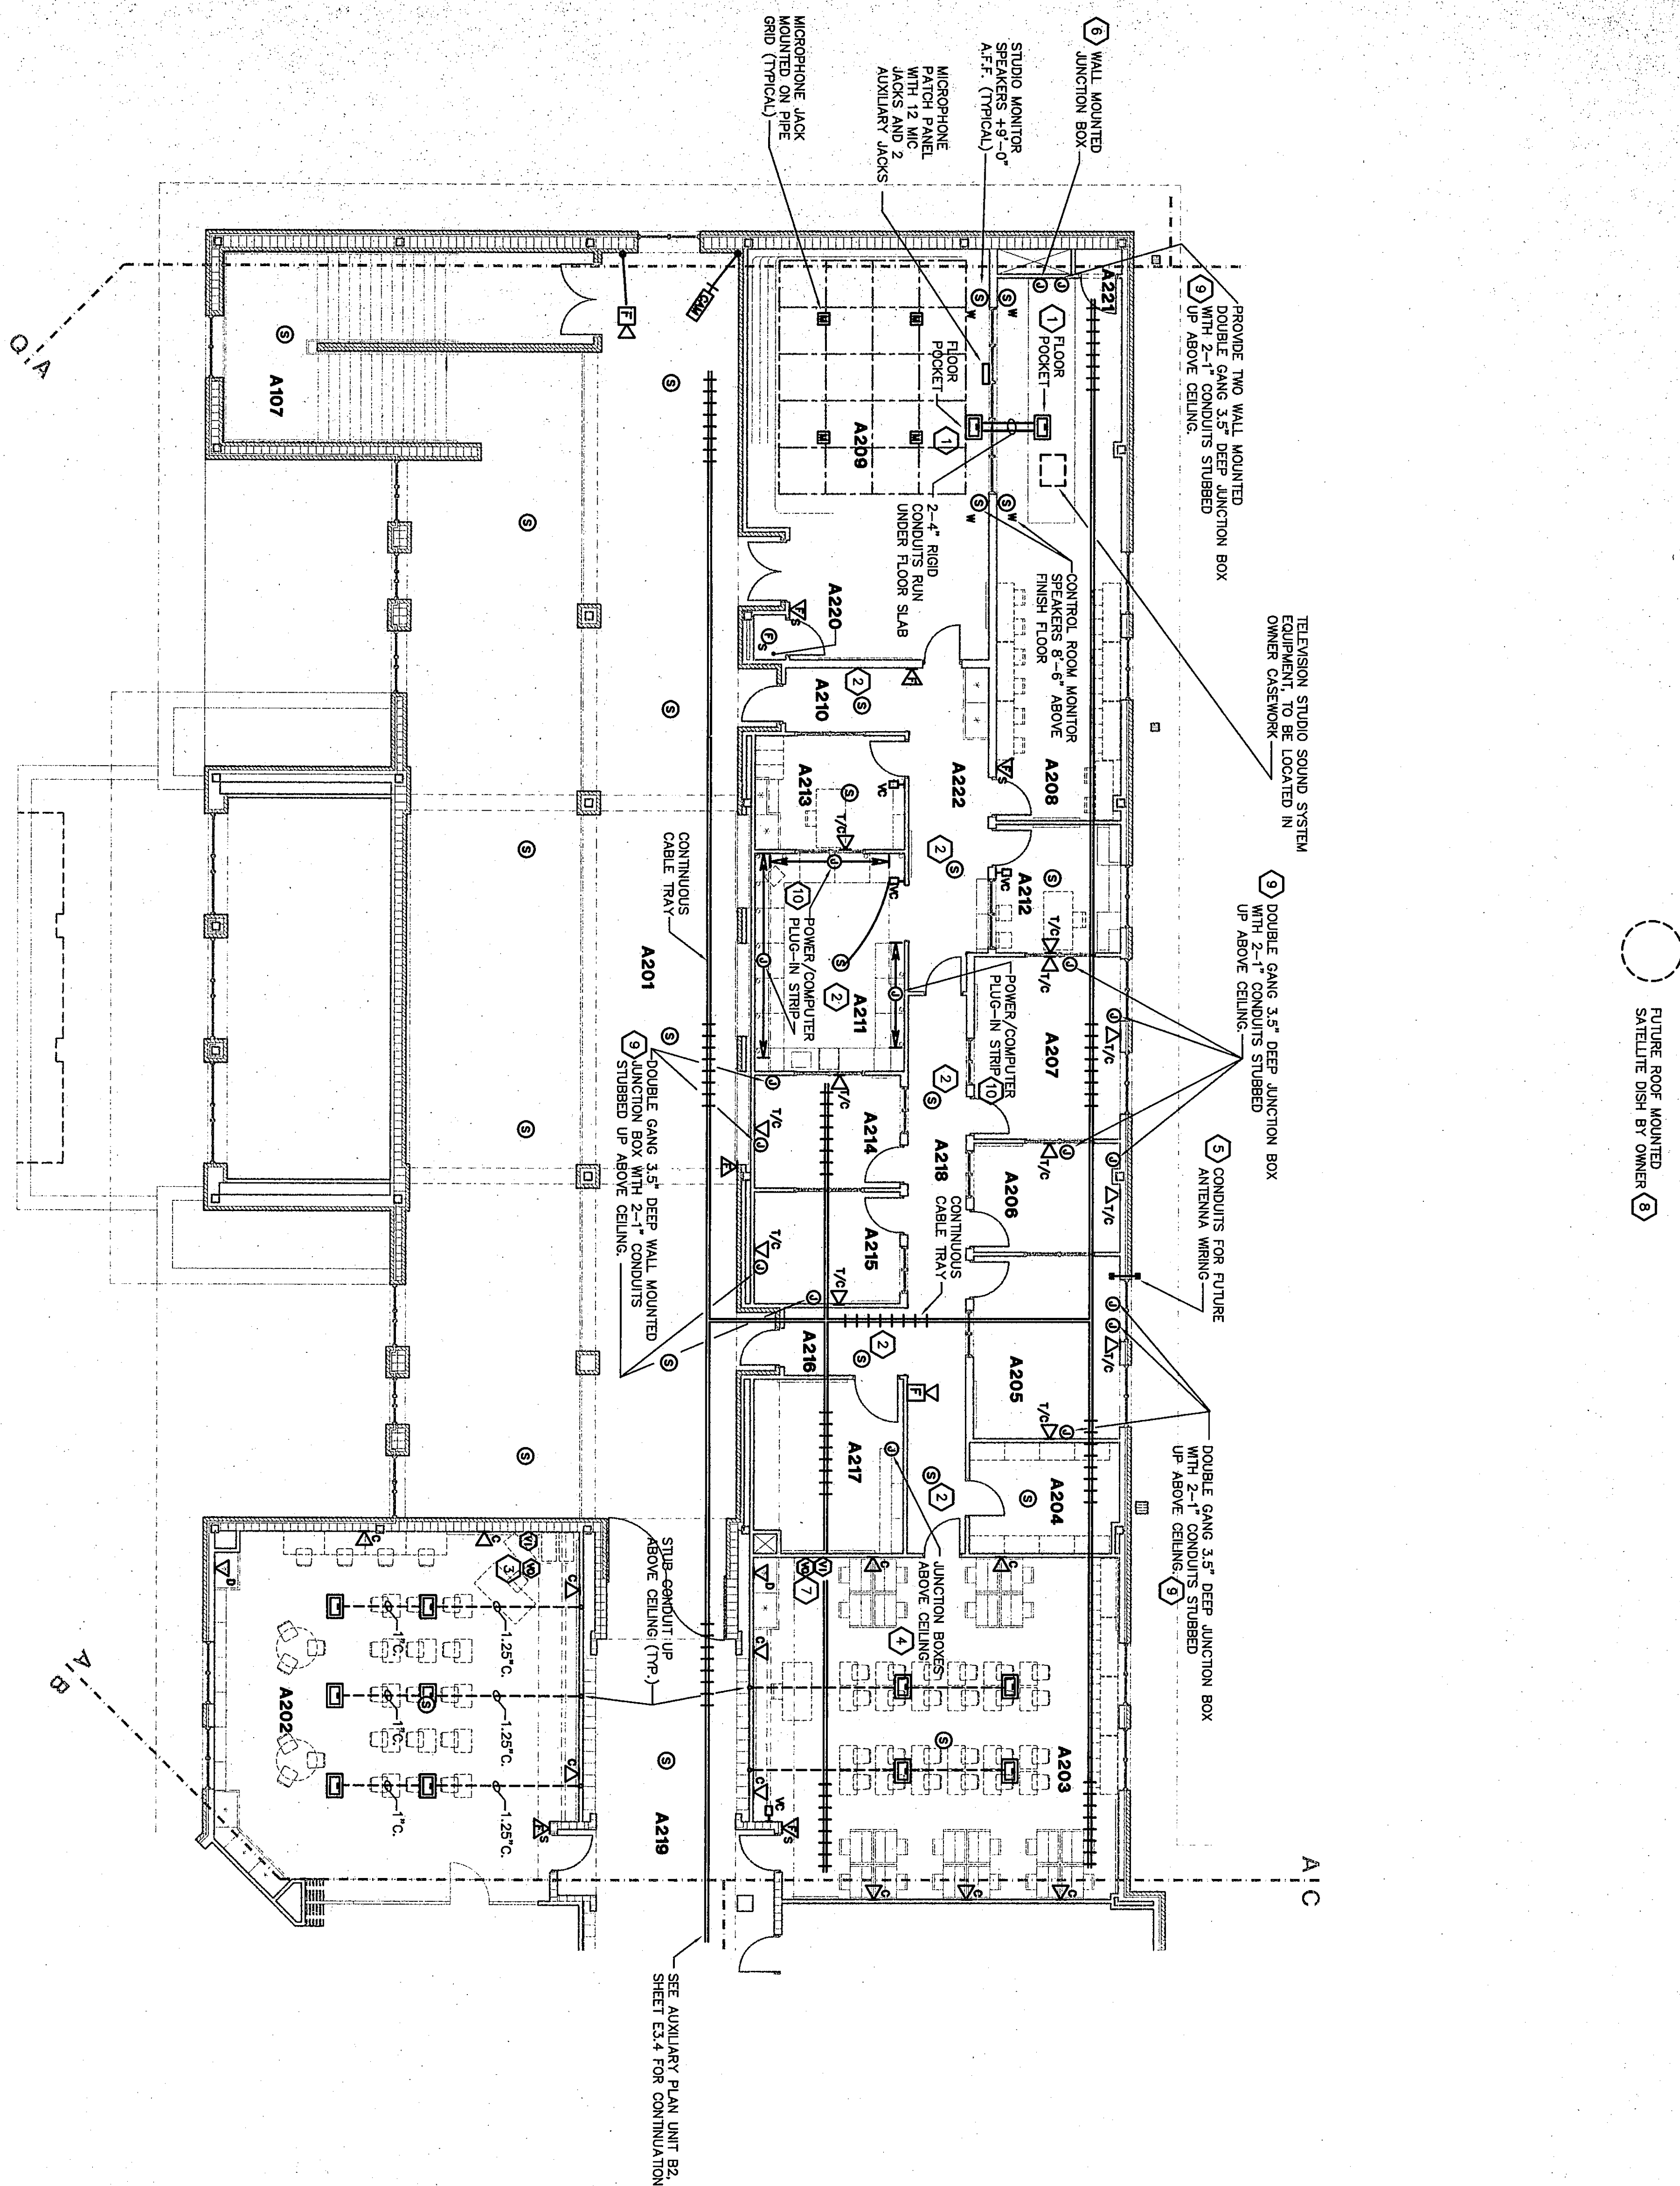

AUXILIARY PLAN UNIT A2


SCALE 1/8" = 1'-0"

ROOM LEGEND "A2"			
ROOM NO.	ROOM NAME	AREA S.F.	CEILING HEIGHT
A201	CORRIDOR	1552	9'-4"
A202	CLASSROOM	960	9'-4"
A203	CLASSROOM	960	9'-4"
A204	LIBRARY	120	9'-4"
A205	TV STUDIO	207	9'-4"
A206	STUDIO	119	9'-4"
A207	STUDIO	510	9'-4"
A208	CONTROL ROOM	697	9'-4"
A209	STUDIO AREA	240	9'-4"
A210	STUDIO	121	9'-4"
A211	STUDIO	122	9'-4"
A212	STUDIO	123	9'-4"
A213	STUDIO	62	9'-4"
A214	STUDIO	239	9'-4"
A215	CORRIDOR	339	10'-0"
A216	CORRIDOR	11	9'-4"
A217	ELECTRICAL CLOSET	9	9'-4"
A218	CORRIDOR	183	9'-4"
A219	CORRIDOR		
A220	CORRIDOR		
A221	CORRIDOR		
A222	CORRIDOR		

FLOOR BOXES ARE SHOWN ON
AUXILIARY AND POWER PLANS.


PLAN NOTES:

1. PROVIDE A FLOOR POCKET EQUAL TO AULMAN MODEL NUMBER "FF7014" WITH NO INTERIOR DEVICES. PROVIDE A PULL STRING IN EACH 4 INCH CONDUIT FOR FUTURE USE. SEE DETAIL 9/E1.5.
2. DIVISION 16 SHALL PROVIDE A CENTRAL SOUND SYSTEM SPEAKER THAT IS THE SAME AS THE ONE PROVIDED IN THE CENTRAL SOUND SYSTEM RACK. THE SPEAKER WILL BE WIRED BY OWNER.
3. REFER TO VIDEO ROUGH-IN AND TELEVISION RECEPTACLE LOCATION DETAILS 9/E1.5 AND 9/E1.5 FOR ADDITIONAL INFORMATION.
4. LABEL EACH RADIO STUDIO JUNCTION BOX ABOVE CEILING ACCORDING TO THE AREA IT SERVES. SEE SITE AND AUXILIARY DRAWINGS FOR CONDUIT SIZES TO:
 1. AUDITORIUM CONTROL BOOTH
 2. AUDITORIUM ORCHESTRA PIT
 3. CENTER
 4. CENTER
 5. CENTER
 6. SWIMMING POOL
 7. VARSITY FOOTBALL
 8. VARSITY FOOTBALL
 9. VARSITY FOOTBALL
 10. VARSITY FOOTBALL
 11. VARSITY FOOTBALL
 12. TRANSFER BUILDING
5. STUDY THREE 2 INCH CONDUITS FROM THE EXTERIOR WALL AT 10'-4" ABOVE FINISH FLOOR. CAP THE CONDUIT ON BOTH ENDS FOR FUTURE USE BY OWNER.
6. RUN A 2 INCH CONDUIT FROM JUNCTION BOX TO ABOVE CEILING OF ROOM A203. RUN A 2 INCH CONDUIT FROM JUNCTION BOX TO ABOVE CEILING OF ROOM A209 MEDIA DISTRIBUTION.
7. UNDER THE BASE AND MOUNT VIDEO OUTLET ON NORTH WALL AT 18 INCHES ABOVE FINISH FLOOR. UNDER THE CEILING ALTERNATE BID MOUNT THE VIDEO OUTLET IN THE SLOPE PROJECTION SURFACE PER DETAIL 9/E1.5.
8. RUN A 1.25 INCH CONDUIT TO ROOM D109 FOR FUTURE USE.
9. MOUNT JUNCTION BOX AT 18 INCHES ABOVE FINISH FLOOR.
10. SEE DETAIL 2/E1.10 FOR MOUNTING REQUIREMENTS.

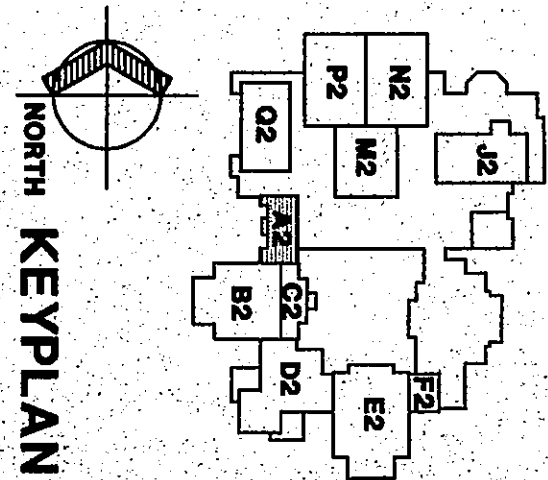

KEY PLAN

THE NEW
CHESTERTON HIGH SCHOOL
FOR THE
DUNELAND SCHOOL CORPORATION
CHESTERTON, INDIANA

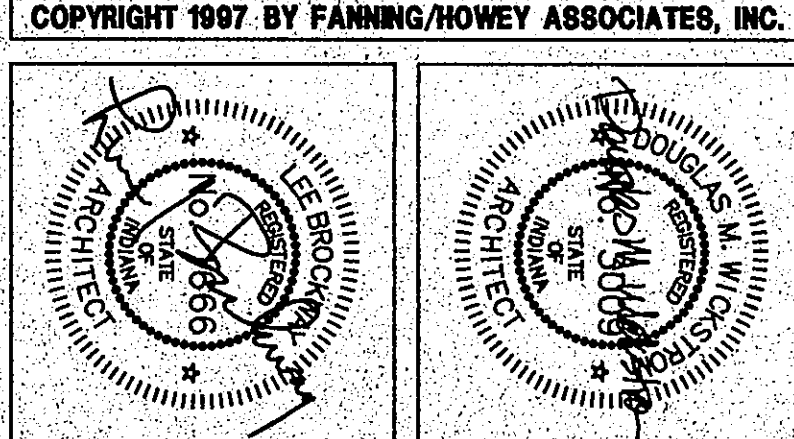

Fanning/Howey Associates, Inc.
Architects Engineers Consultants

AUXILIARY PLAN UNIT A2	
DRAWN BY: MRS	COMM. NO.: 95067.00
CHECKED BY: WBH	DATE: APRIL 21, 1997
REVISIONS NO. DATE	
E3.2	

CHESTERTON HIGH SCHOOL
95067.00