


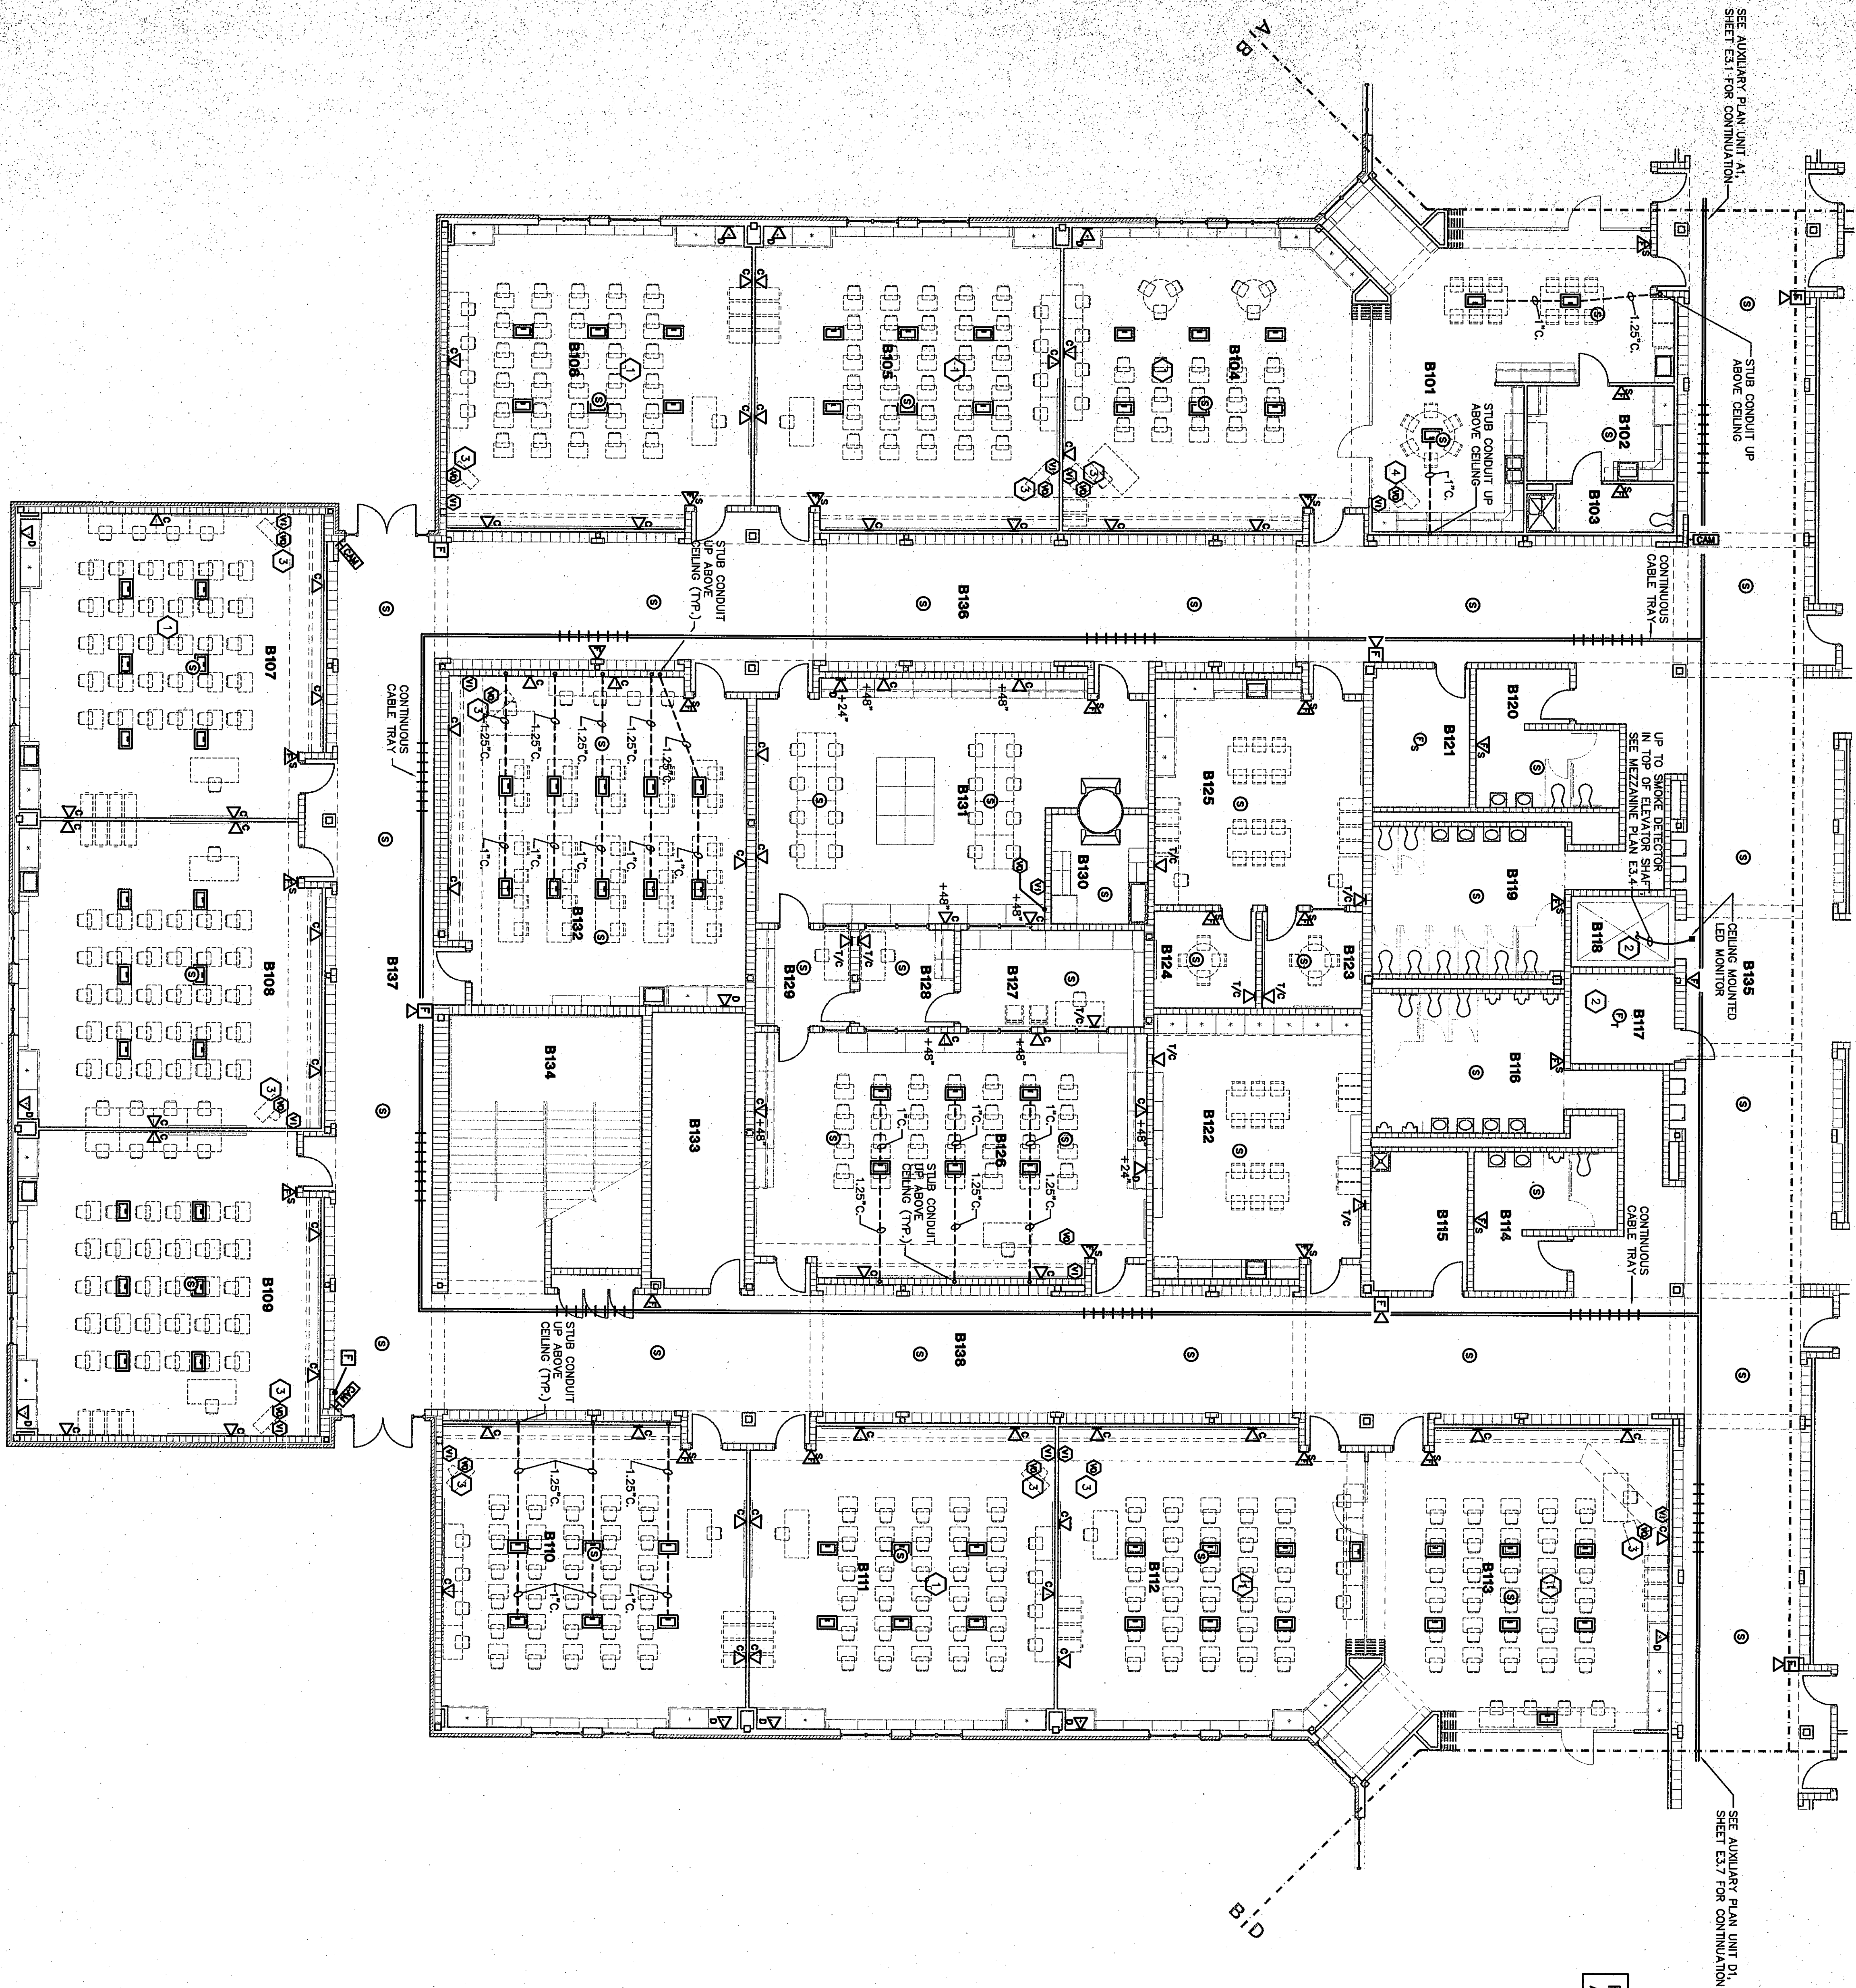

AUXILIARY PLAN UNIT B1

SCALE 1/8" = 1'-0"

PLAN NOTES:

- 1. REFER TO ROOM B110 FOR TYPICAL CONDUIT SIZE TO EACH FLOOR BOX.
- 2. SEE POWER PLAN UNIT B1, SHEET E3.3 FOR ELEVATOR PIT AND ELEVATOR CONTROL ROOM REQUIREMENTS.
- 3. REFER TO WOOD ROUGH-IN AND TERMINATION RECEPTACLE LOCATION, DETAILS 9/E1.5 AND 9/E1.5 FOR ADDITIONAL INFORMATION.

FLOOR BOXES ARE SHOWN ON  
AUXILIARY AND POWER PLANS.


| ROOM LEGEND "B1" |                    |           |
|------------------|--------------------|-----------|
| ROOM NO.         | ROOM NAME          | AREA S.F. |
| B101             | LIFE SKILLS        | 743       |
| B102             | HEALTH MAINTENANCE | 149       |
| B103             | TOILET             | 149       |
| B104             | CLASSROOM          | 989       |
| B105             | CLASSROOM          | 972       |
| B106             | CLASSROOM          | 987       |
| B107             | CLASSROOM          | 987       |
| B108             | CLASSROOM          | 972       |
| B109             | CLASSROOM          | 987       |
| B110             | CLASSROOM          | 972       |
| B111             | CLASSROOM          | 989       |
| B112             | CLASSROOM          | 989       |
| B113             | CLASSROOM          | 989       |
| B114             | CLASSROOM          | 989       |
| B115             | CLASSROOM          | 989       |
| B116             | CLASSROOM          | 989       |
| B117             | CLASSROOM          | 989       |
| B118             | CLASSROOM          | 989       |
| B119             | CLASSROOM          | 989       |
| B120             | CLASSROOM          | 989       |
| B121             | CLASSROOM          | 989       |
| B122             | CLASSROOM          | 989       |
| B123             | CLASSROOM          | 989       |
| B124             | CLASSROOM          | 989       |
| B125             | CLASSROOM          | 989       |
| B126             | CLASSROOM          | 989       |
| B127             | CLASSROOM          | 989       |
| B128             | CLASSROOM          | 989       |
| B129             | CLASSROOM          | 989       |
| B130             | CLASSROOM          | 989       |
| B131             | CLASSROOM          | 989       |
| B132             | CLASSROOM          | 989       |
| B133             | CLASSROOM          | 989       |
| B134             | CLASSROOM          | 989       |
| B135             | CLASSROOM          | 989       |
| B136             | CLASSROOM          | 989       |
| B137             | CLASSROOM          | 989       |
| B138             | CLASSROOM          | 989       |

AUXILIARY PLAN UNIT B1


DRAWN BY: MRS COMM. NO.: 95067.00  
CHECKED BY: WRS DATE: APRIL 21, 1997

E3.3

REVISIONS NO. DATE

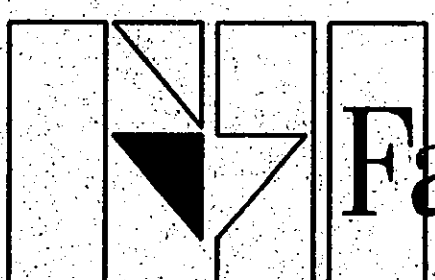

Fanning/Howey  
Associates, Inc.  
Architects Engineers Consultants

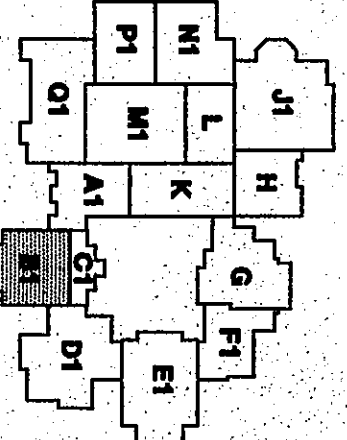

THE NEW  
CHESTERTON HIGH SCHOOL  
FOR THE  
DUNELAND SCHOOL CORPORATION  
CHESTERTON, INDIANA

COPYRIGHT 1997 BY FANNING/HOWEY ASSOCIATES, INC.

