



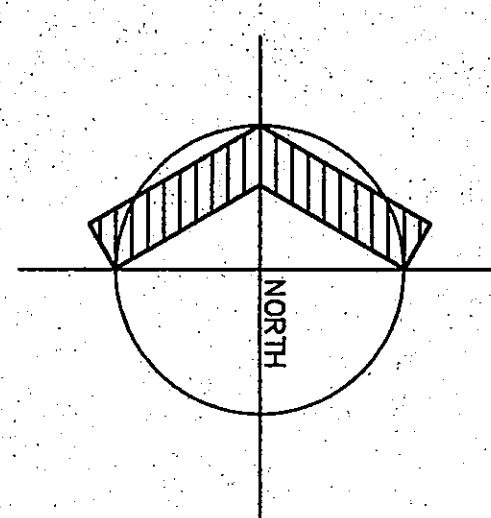

AUXILIARY PLAN UNIT B2

SCALE 1/8" = 1'-0"

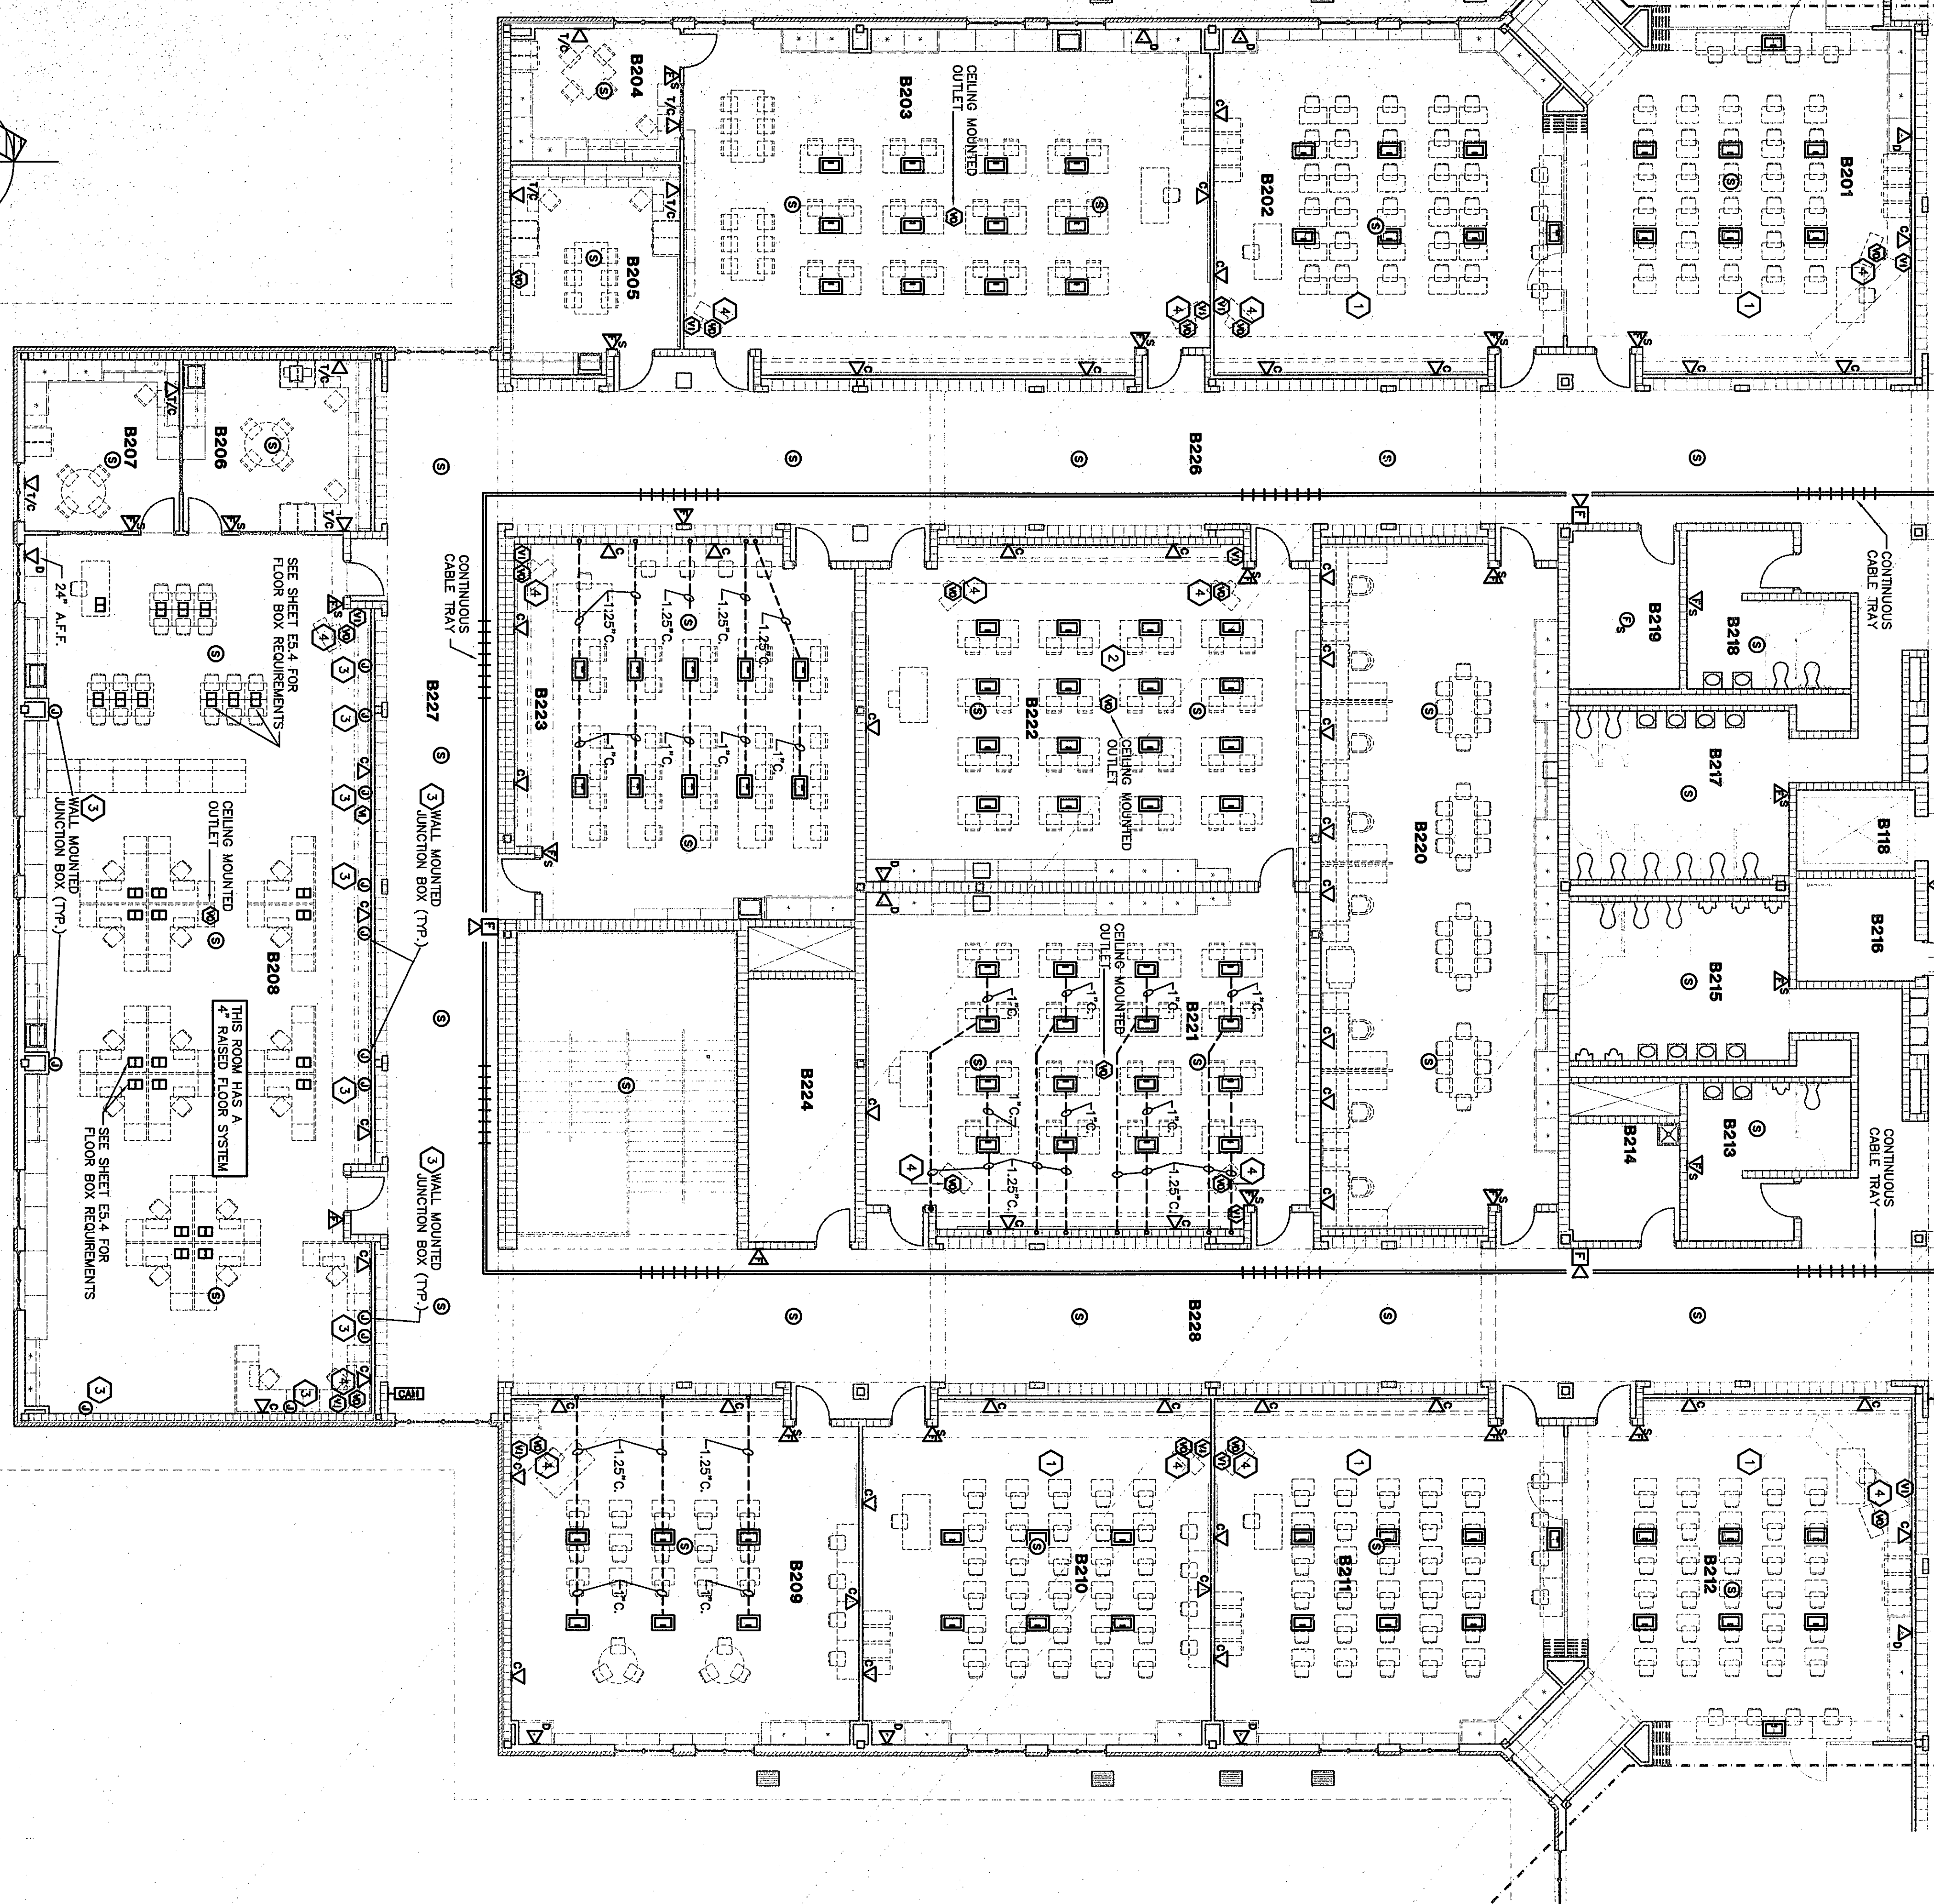

SEE AUXILIARY PLAN UNIT A2
SHEET E3.2 FOR CONTINUATION

SEE AUXILIARY PLAN UNIT D2
SHEET E3.7 FOR CONTINUATION


FLOOR BOXES ARE SHOWN ON
AUXILIARY AND POWER PLANS.

PLAN NOTES:

1. REFER TO ROOM B209 FOR TYPICAL DATA CONDUIT ROUTING AND CONDUIT SIZE TO EACH FLOOR BOX.
2. REFER TO ROOM B221 FOR TYPICAL DATA CONDUIT ROUTING AND CONDUIT SIZE TO EACH FLOOR BOX.
3. WALL MOUNTED JUNCTION BOX LOCATED ABOVE CONCRETE SLAB, 3" DEEP JUNCTION BOX WITH TWO 3/4" CONDUITS STUBBED UP ABOVE CEILING.
4. REFER TO WIRE ROLLS-IN AND TELEVISION RECEPTACLE LOCATION, DETAILS 9/E15 AND 9/E15 FOR ADDITIONAL INFORMATION.

ROOM LEGEND "B2"

ROOM NO.	ROOM NAME	AREA S.F.	CEILING HEIGHT
B201	CLASSROOM	986	11'-8"
B202	CLASSROOM	986	11'-8"
B203	CLASSROOM	1459	9'-4"
B204	LAB	182	9'-4"
B205	LAB	226	9'-4"
B206	WORKROOM	226	9'-4"
B207	OFFICE	217	9'-4"
B208	CLASSROOM LAB	2447	8'-0"
B209	CLASSROOM	972	8'-0"
B210	CLASSROOM	989	8'-0"
B211	CLASSROOM	177	8'-0"
B212	CLASSROOM	106	8'-0"
B213	JANITOR CLOSET	106	8'-0"
B214	TOILET	106	8'-0"
B215	TOILET	106	8'-0"
B216	TOILET	106	8'-0"
B217	TOILET	106	8'-0"
B218	TOILET	106	8'-0"
B219	TOILET	106	8'-0"
B220	TOILET	106	8'-0"
B221	TOILET	106	8'-0"
B222	TOILET	106	8'-0"
B223	TOILET	106	8'-0"
B224	TOILET	106	8'-0"
B225	TOILET	106	8'-0"
B226	TOILET	106	8'-0"
B227	TOILET	106	8'-0"
B228	TOILET	106	8'-0"

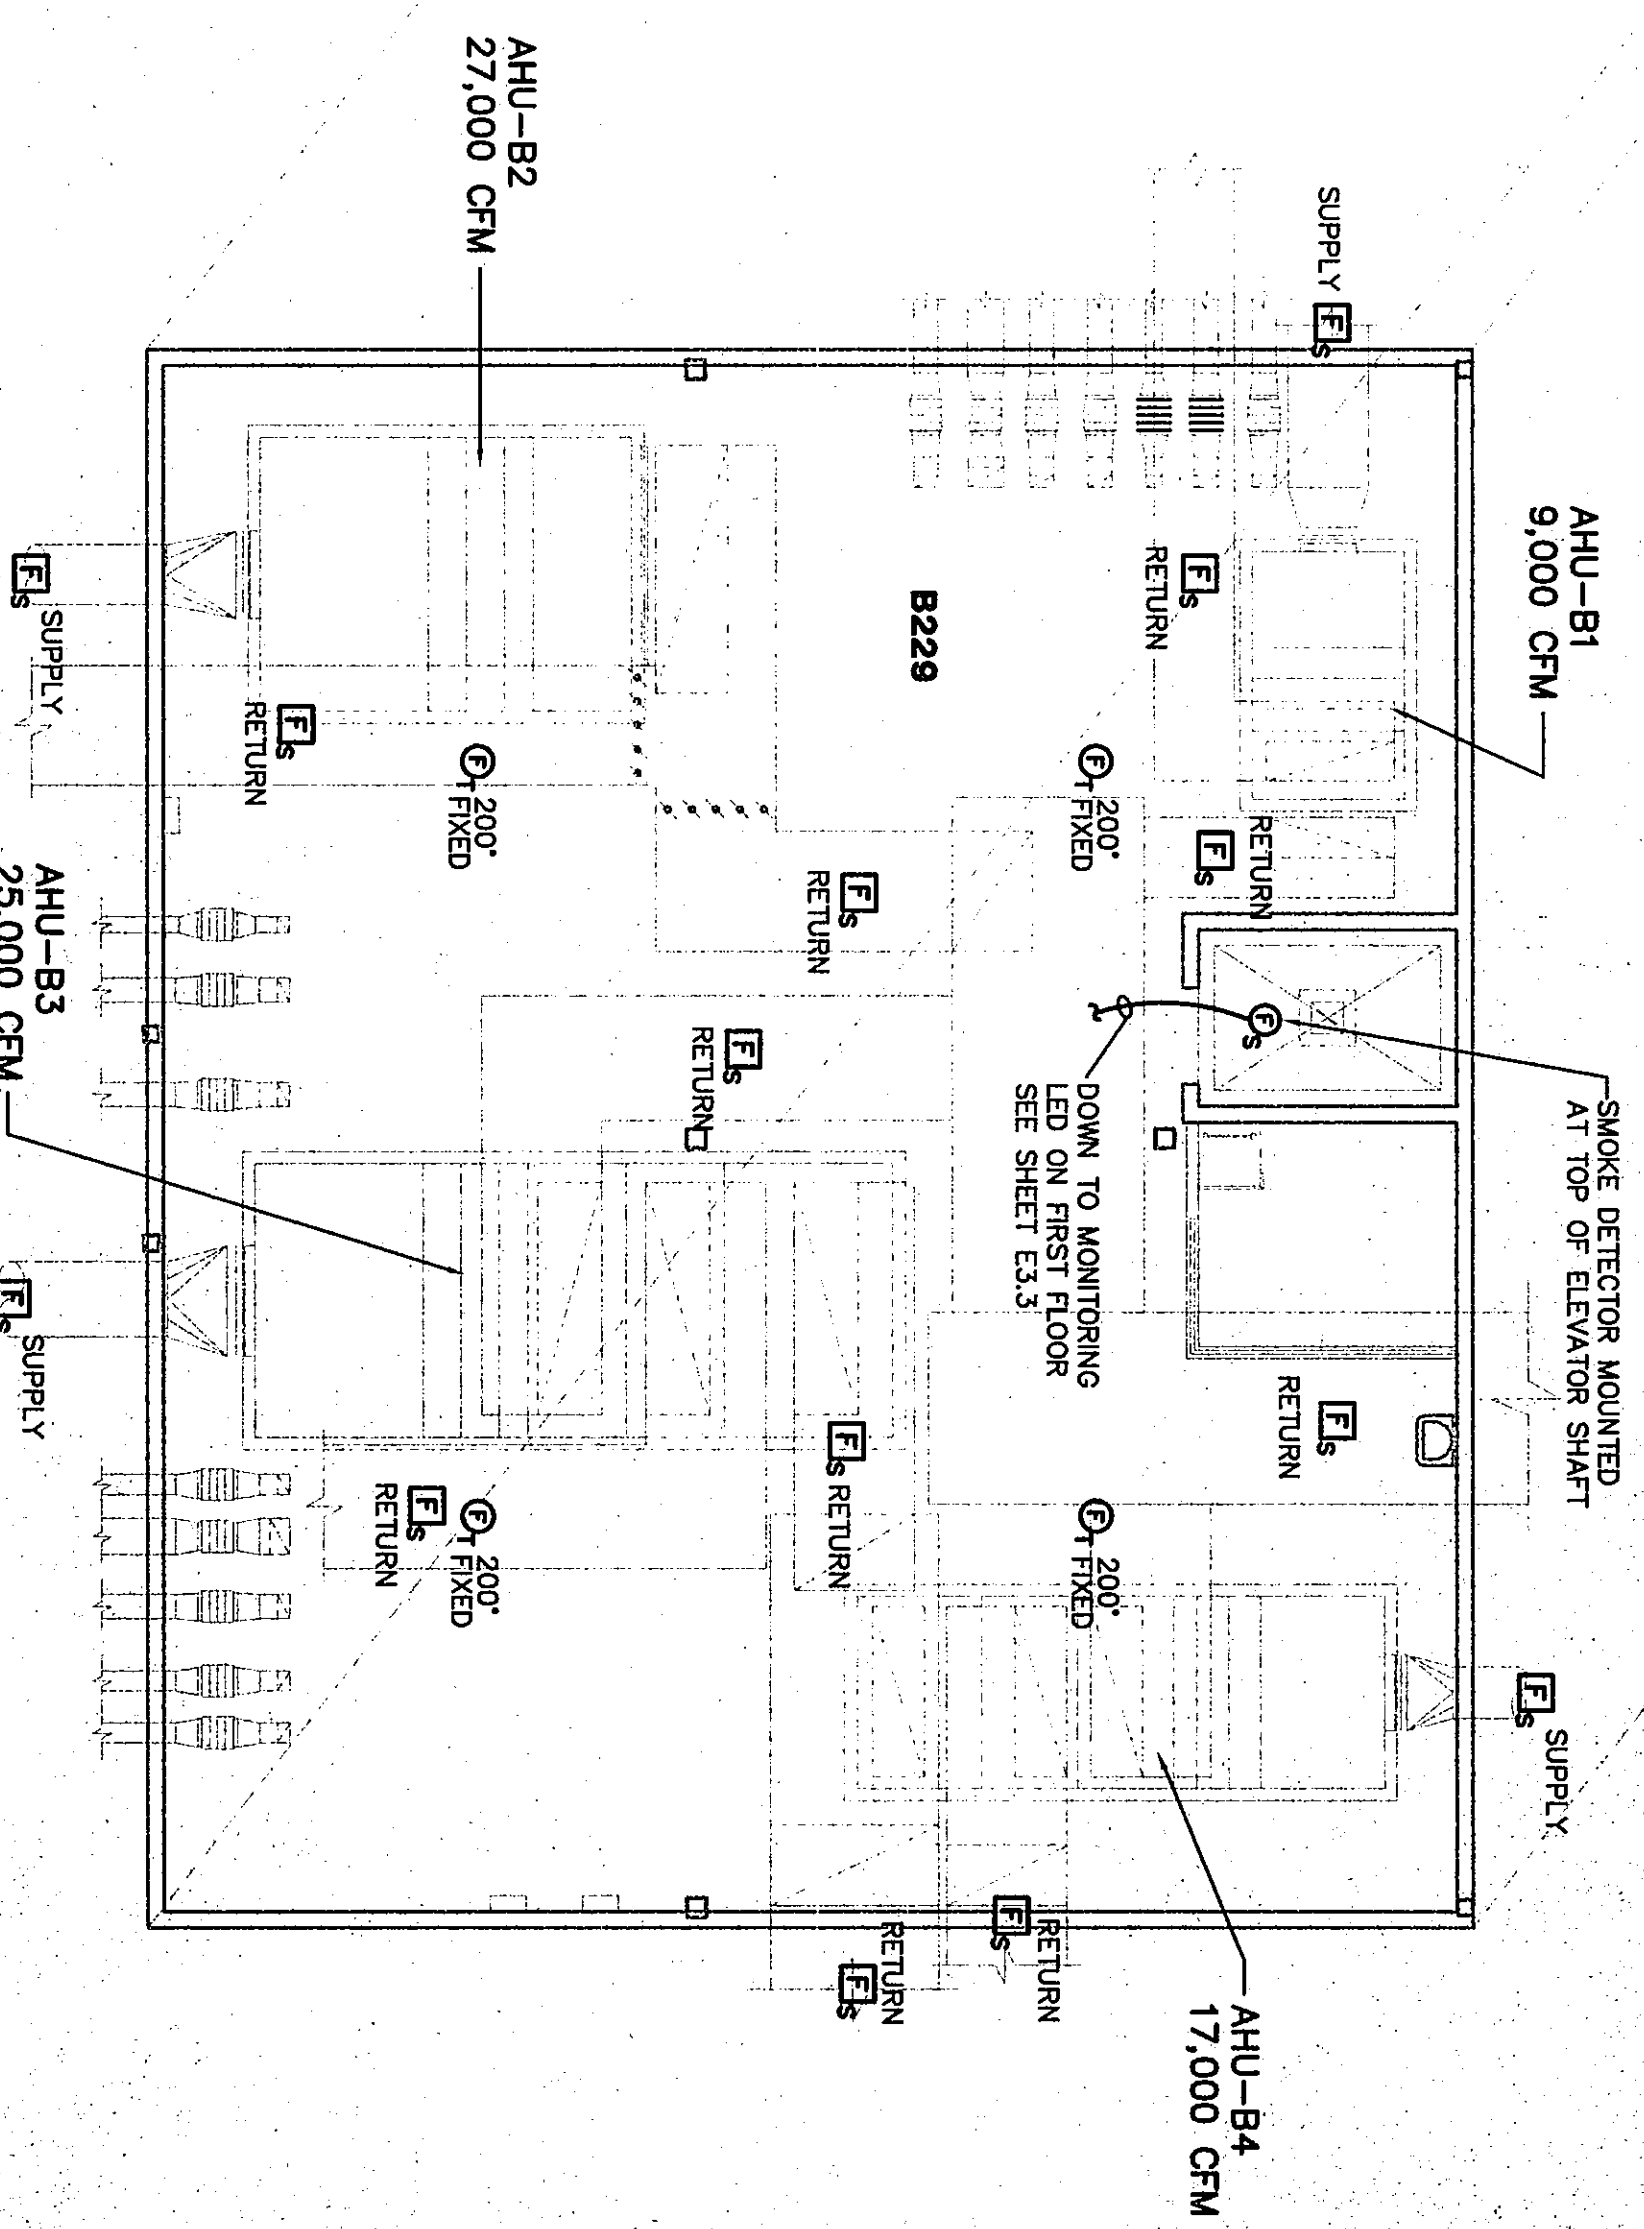

AUXILIARY MEZZANINE UNIT B

SCALE 1/8" = 1'-0"


AUXILIARY PLAN UNIT B2

DRAWN BY: MRS. COMM. NO.: 95067.00
CHECKED BY: WBH DATE: APRIL 21, 1997

E3.4

REVISIONS NO. DATE

Fanning/Howey Associates, Inc.
Architects Engineers Consultants

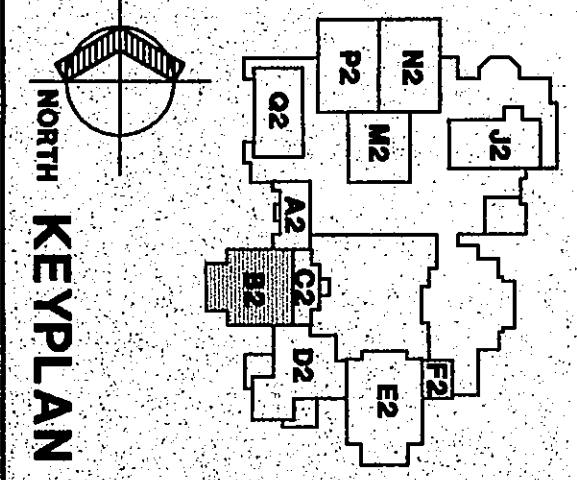

THE NEW
CHESTERTON HIGH SCHOOL
FOR THE
DUNELAND SCHOOL CORPORATION
CHESTERTON, INDIANA

COPYRIGHT 1997 BY FANNING/HOWEY ASSOCIATES, INC.