
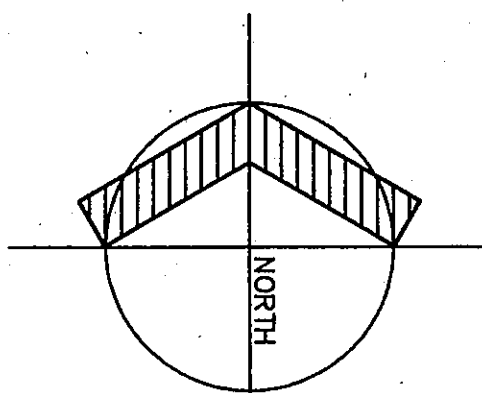


58


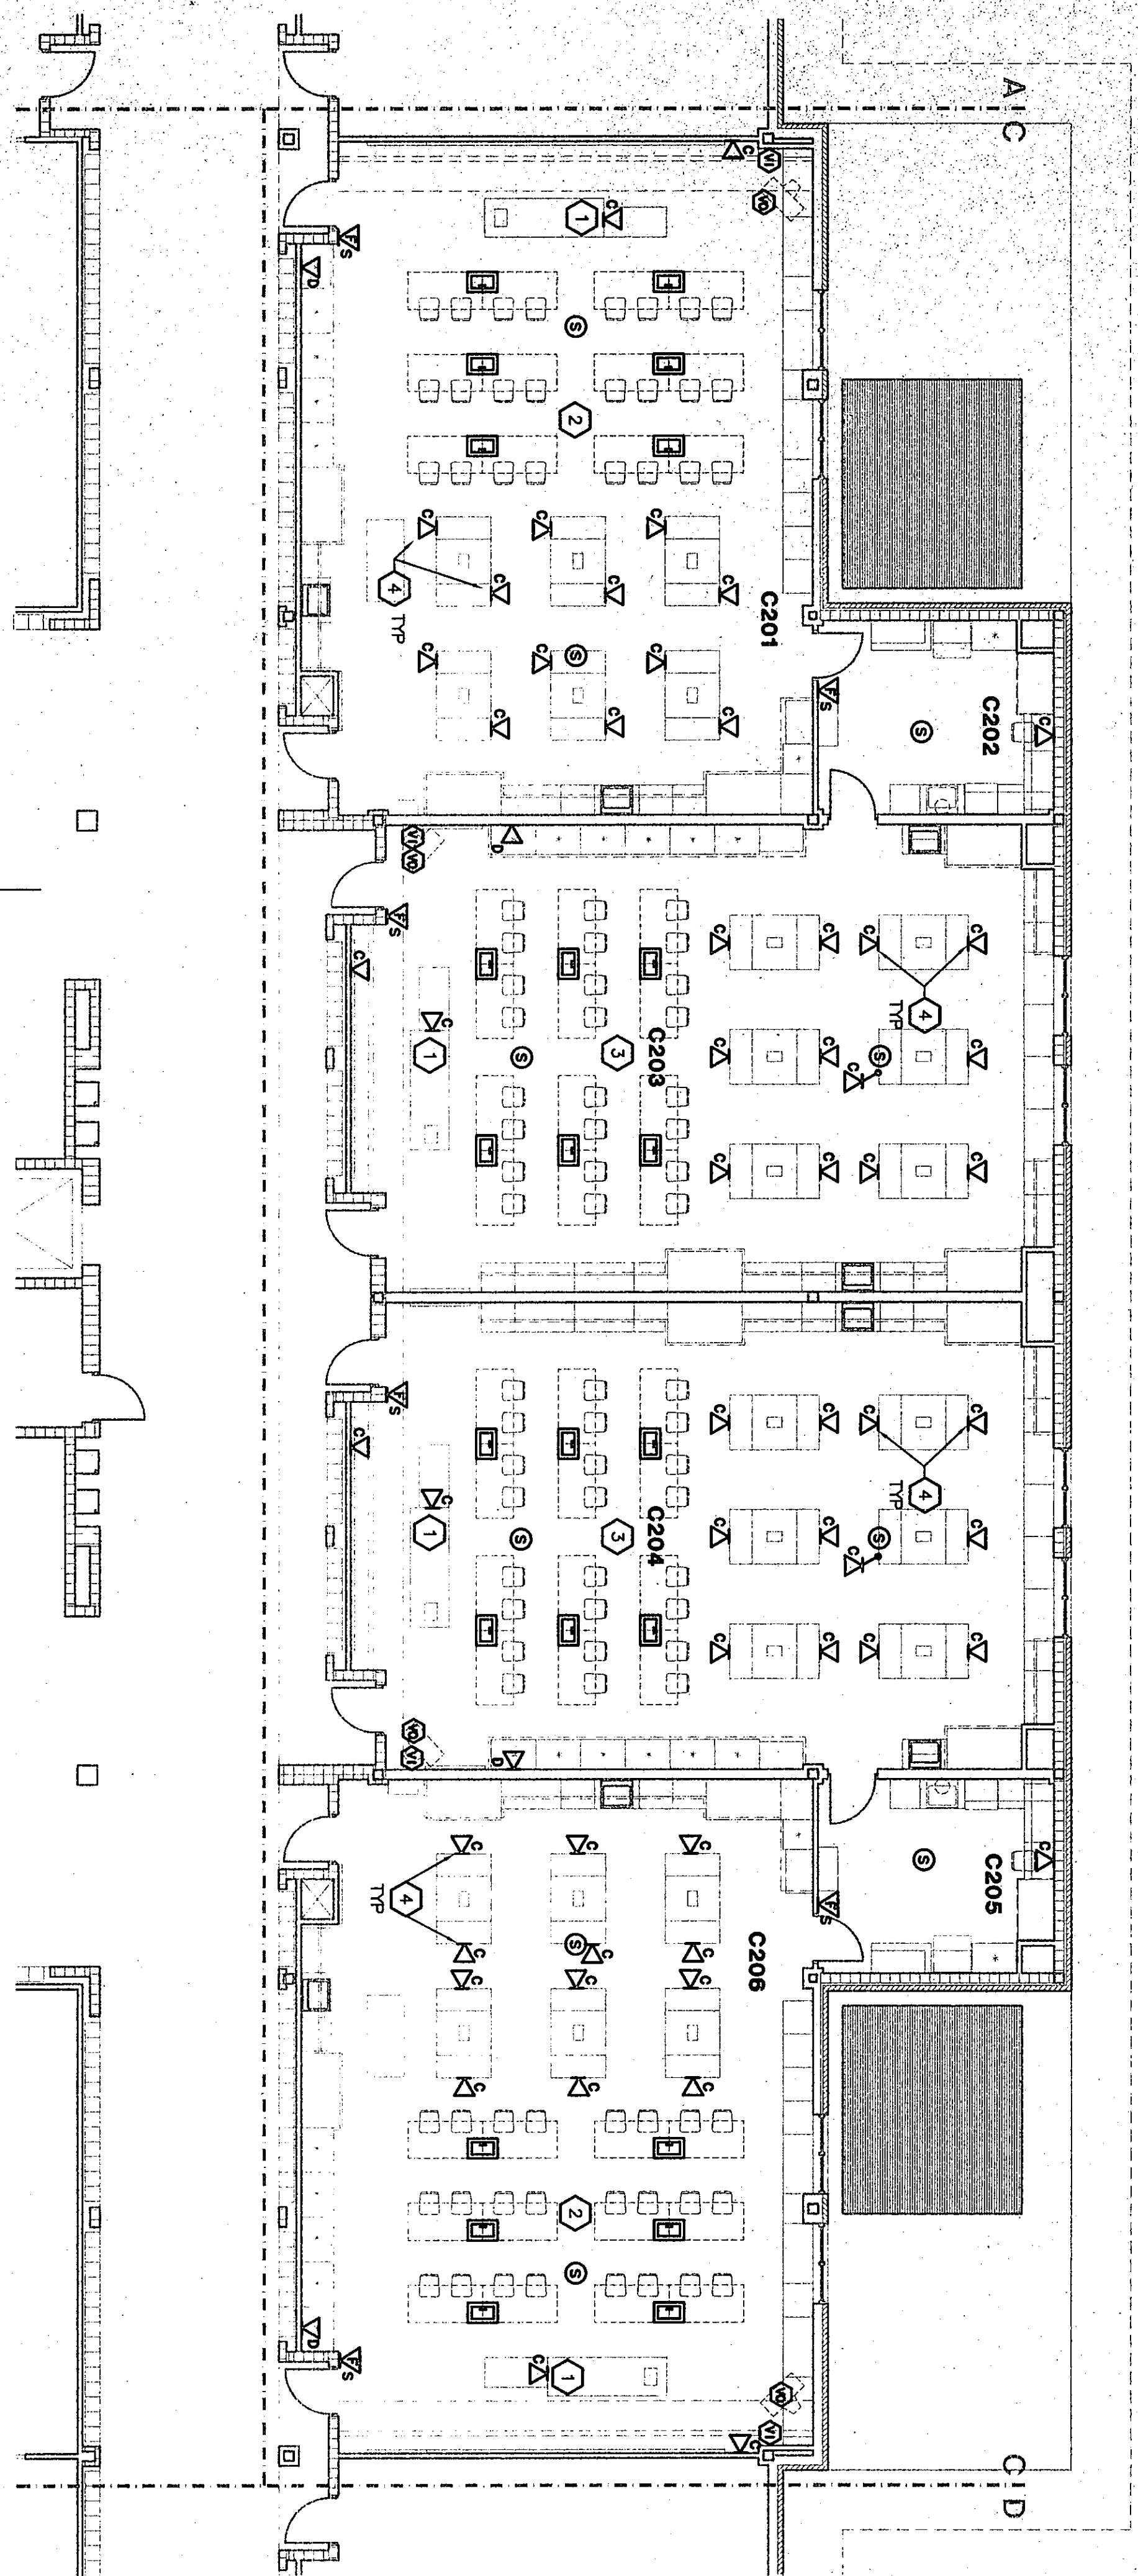


AUXILIARY PLAN UNIT C2

SCALE: 1/8" = 1'-0"

- PLAN NOTES:**
- 1 COMPUTER ROOM-IN LOCATED IN CASEWORK. CASWORK MANUFACTURER TO LOCATE AND CUT OUT FOR ELECTRICAL BACK BOX. VERIFY IN THE FIELD. SEE DETAIL 9/21.10.
  - 2 REERT TO ROOM C107 FOR TYPICAL DATA EACH FLOOR BOX. CONDUIT ROUTING AND CONDUIT SIZE FOR EACH FLOOR BOX.
  - 3 REERT TO ROOM C105 FOR TYPICAL DATA EACH FLOOR BOX. CONDUIT ROUTING AND CONDUIT SIZE FOR EACH FLOOR BOX.
  - 4 COMPUTER ROOM-IN LOCATED IN CASEWORK. CASWORK MANUFACTURER TO LOCATE AND CUT OUT FOR ELECTRICAL BACK BOX. VERIFY IN THE FIELD. SEE DETAIL 9/21.11.
- FLOOR BOXES ARE SHOWN ON AUXILIARY AND POWER PLANS.**


| ROOM LEGEND "C2" |             |           |                |
|------------------|-------------|-----------|----------------|
| ROOM NO.         | ROOM NAME   | AREA S.F. | CEILING HEIGHT |
| C201             | SCIENCE LAB | 1505      | 9'-4"          |
| C202             | PREP. ROOM  | 200       | 9'-4"          |
| C203             | SCIENCE LAB | 1438      | 9'-4"          |
| C204             | SCIENCE LAB | 1438      | 9'-4"          |
| C205             | PREP. ROOM  | 200       | 9'-4"          |
| C206             | SCIENCE LAB | 1505      | 9'-4"          |

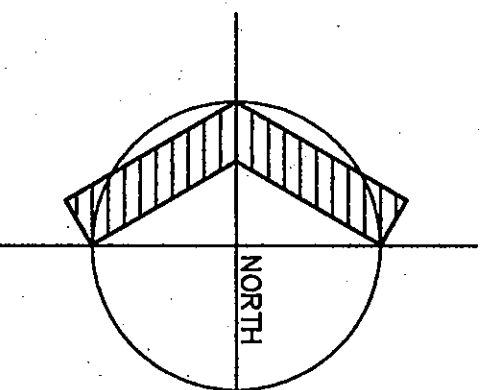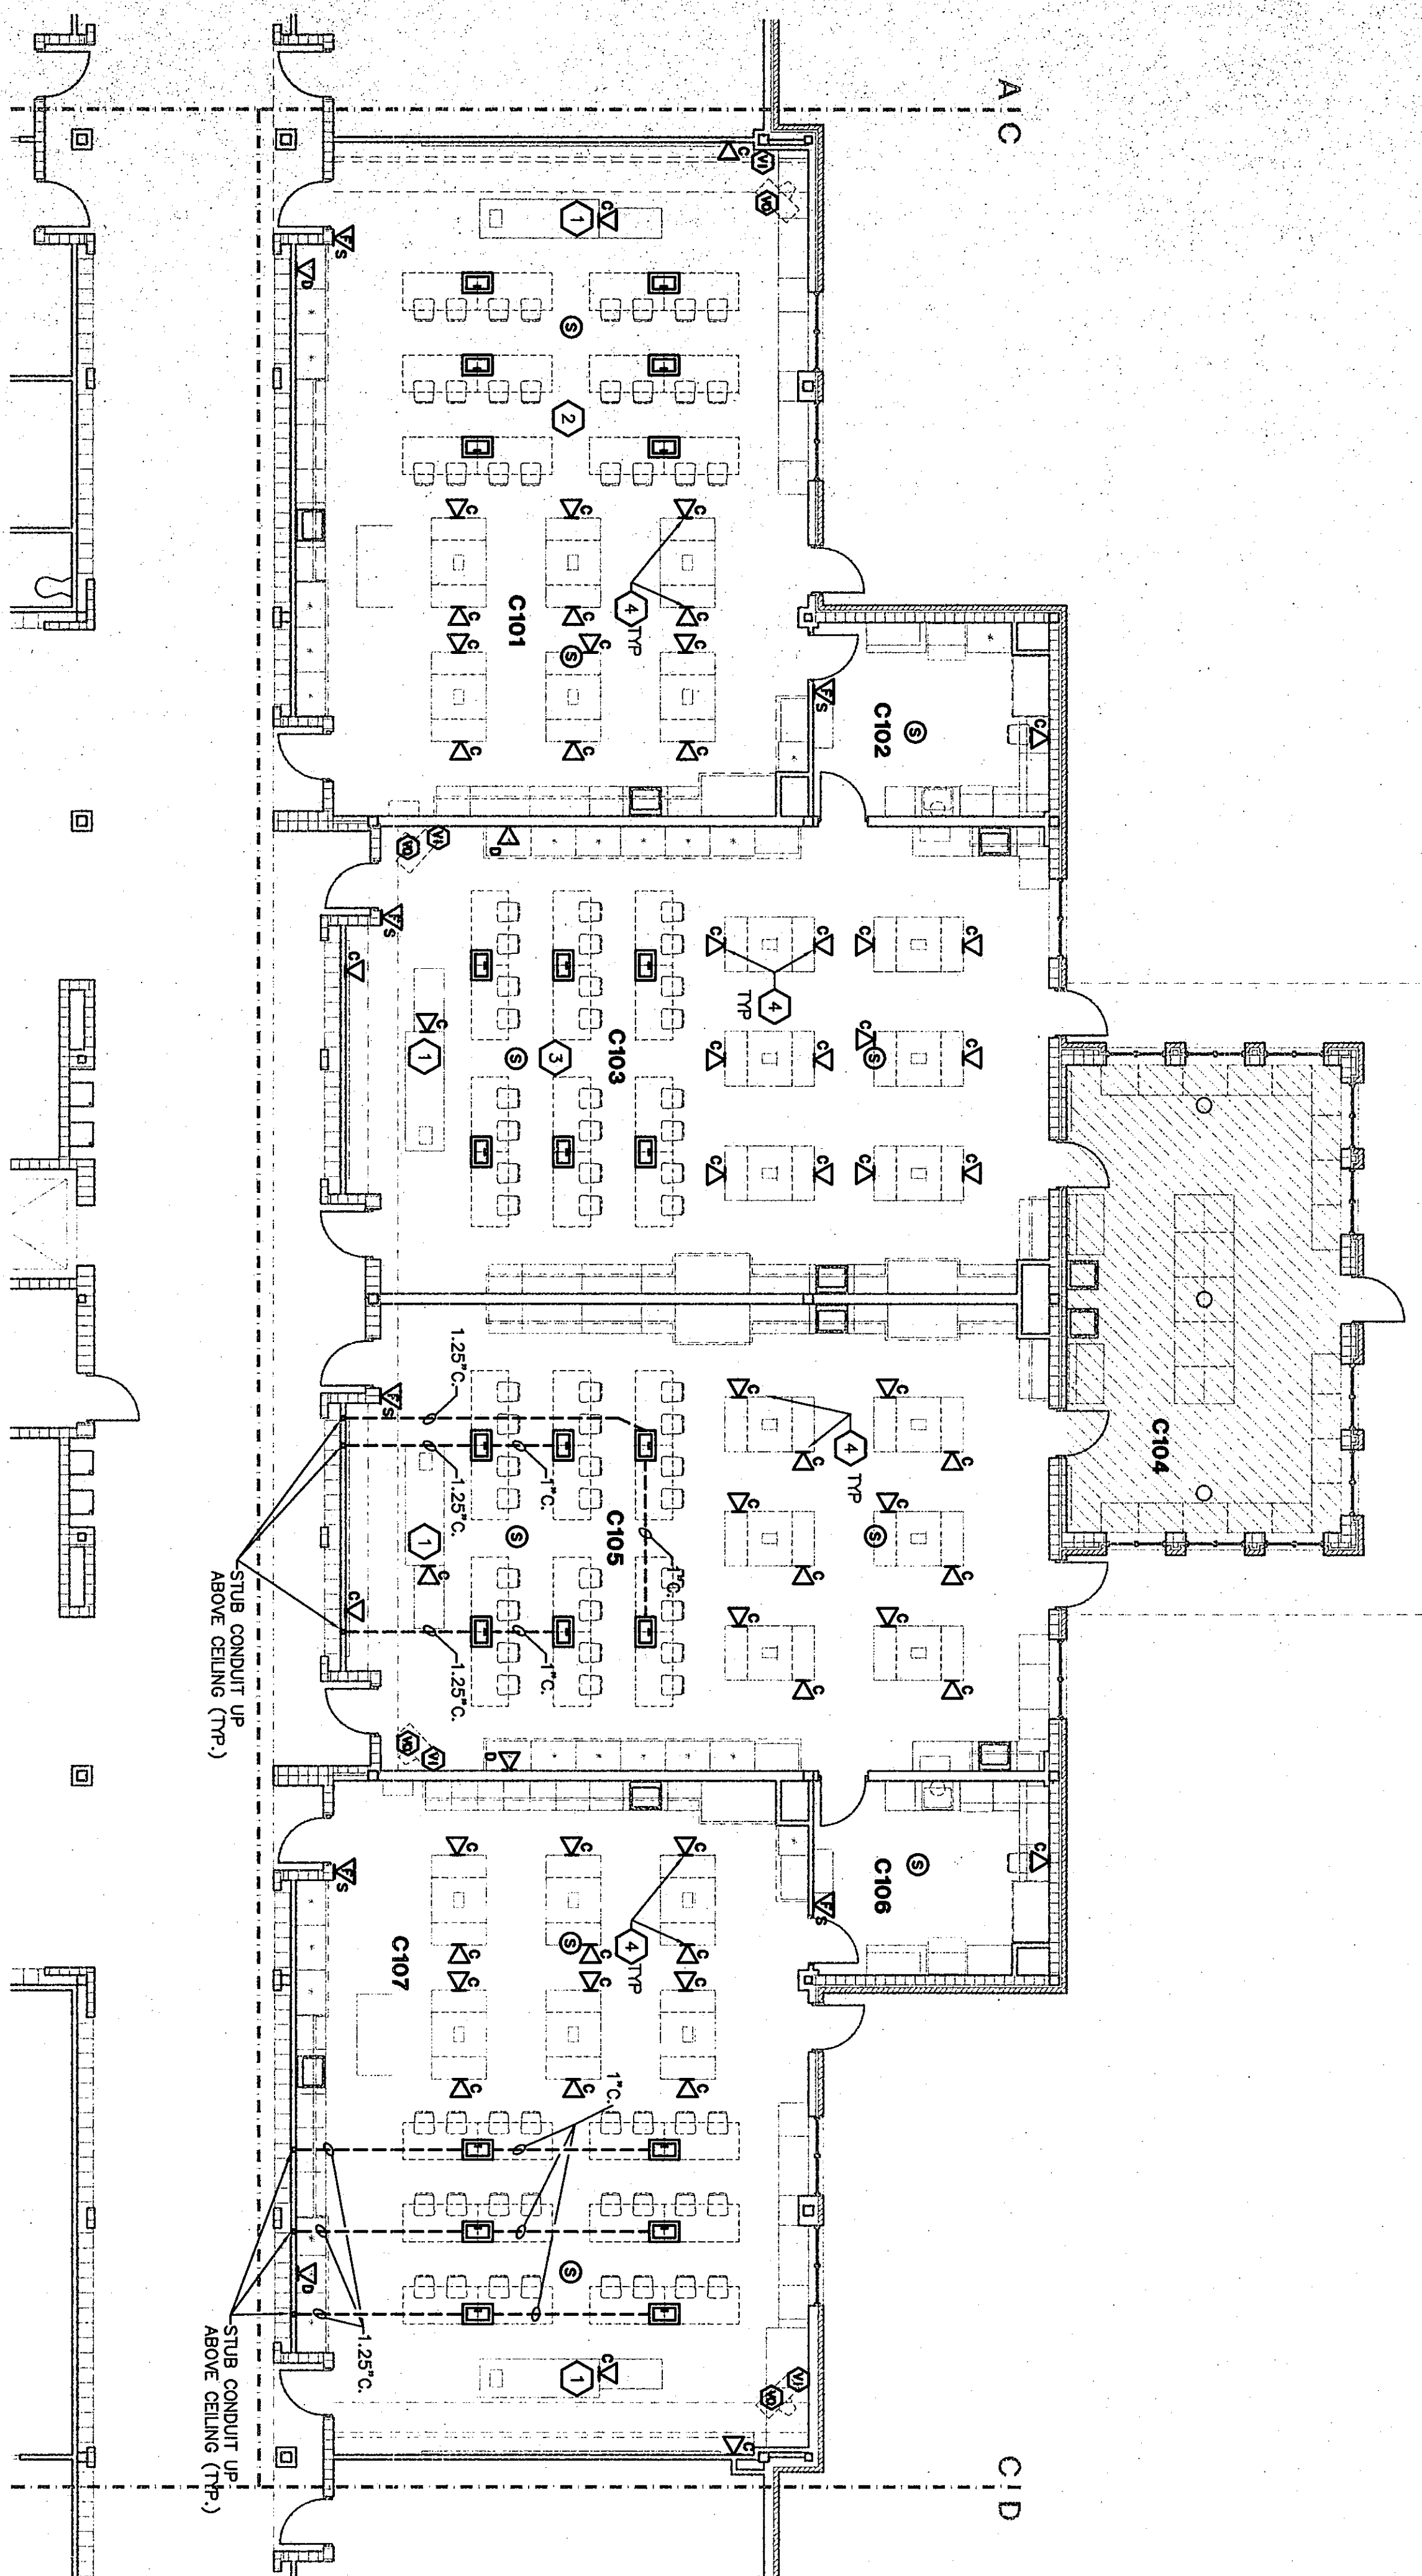

AUXILIARY PLAN UNIT C1


SCALE: 1/8" = 1'-0"

| ROOM LEGEND "C1" |             |           |                |
|------------------|-------------|-----------|----------------|
| ROOM NO.         | ROOM NAME   | AREA S.F. | CEILING HEIGHT |
| C101             | SCIENCE LAB | 1505      | 9'-4"          |
| C102             | PREP. ROOM  | 200       | 9'-4"          |
| C103             | SCIENCE LAB | 1441      | 9'-4"          |
| C104             | SCIENCE LAB | 1441      | 9'-4"          |
| C105             | PREP. ROOM  | 200       | 9'-4"          |
| C106             | SCIENCE LAB | 1505      | 9'-4"          |
| C107             | SCIENCE LAB | 1505      | 9'-4"          |

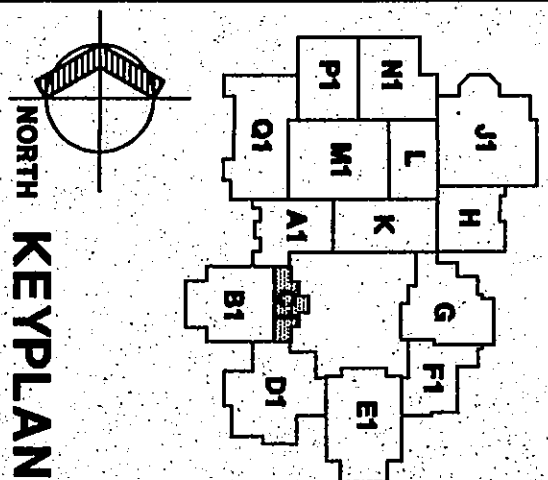

KEY PLAN

THE NEW  
**CHESTERTON HIGH SCHOOL**  
FOR THE  
DUNELAND SCHOOL CORPORATION  
CHESTERTON, INDIANA

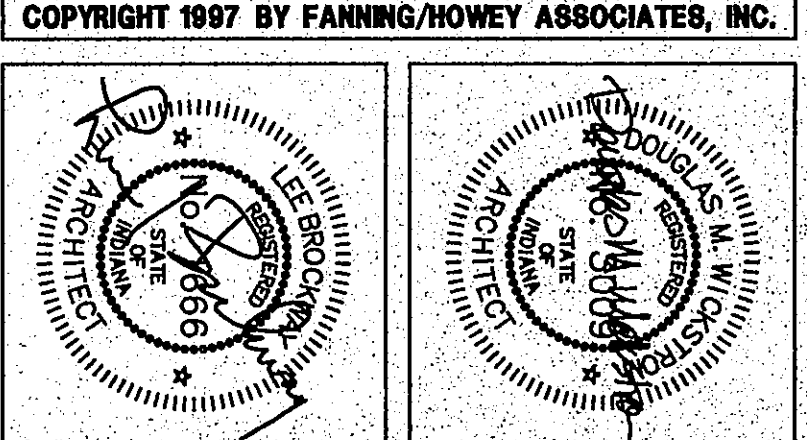

|                                  |                      |
|----------------------------------|----------------------|
| <b>AUXILIARY PLAN UNIT C1,C2</b> |                      |
| DRAWN BY: MRS                    | COMM. NO.: 95067.00  |
| CHECKED BY: WBH                  | DATE: APRIL 21, 1997 |
| <b>E3.5</b>                      | REVISIONS NO. DATE   |

**Fanning/Howey Associates, Inc.**  
Architects Engineers Consultants

01 E-23