


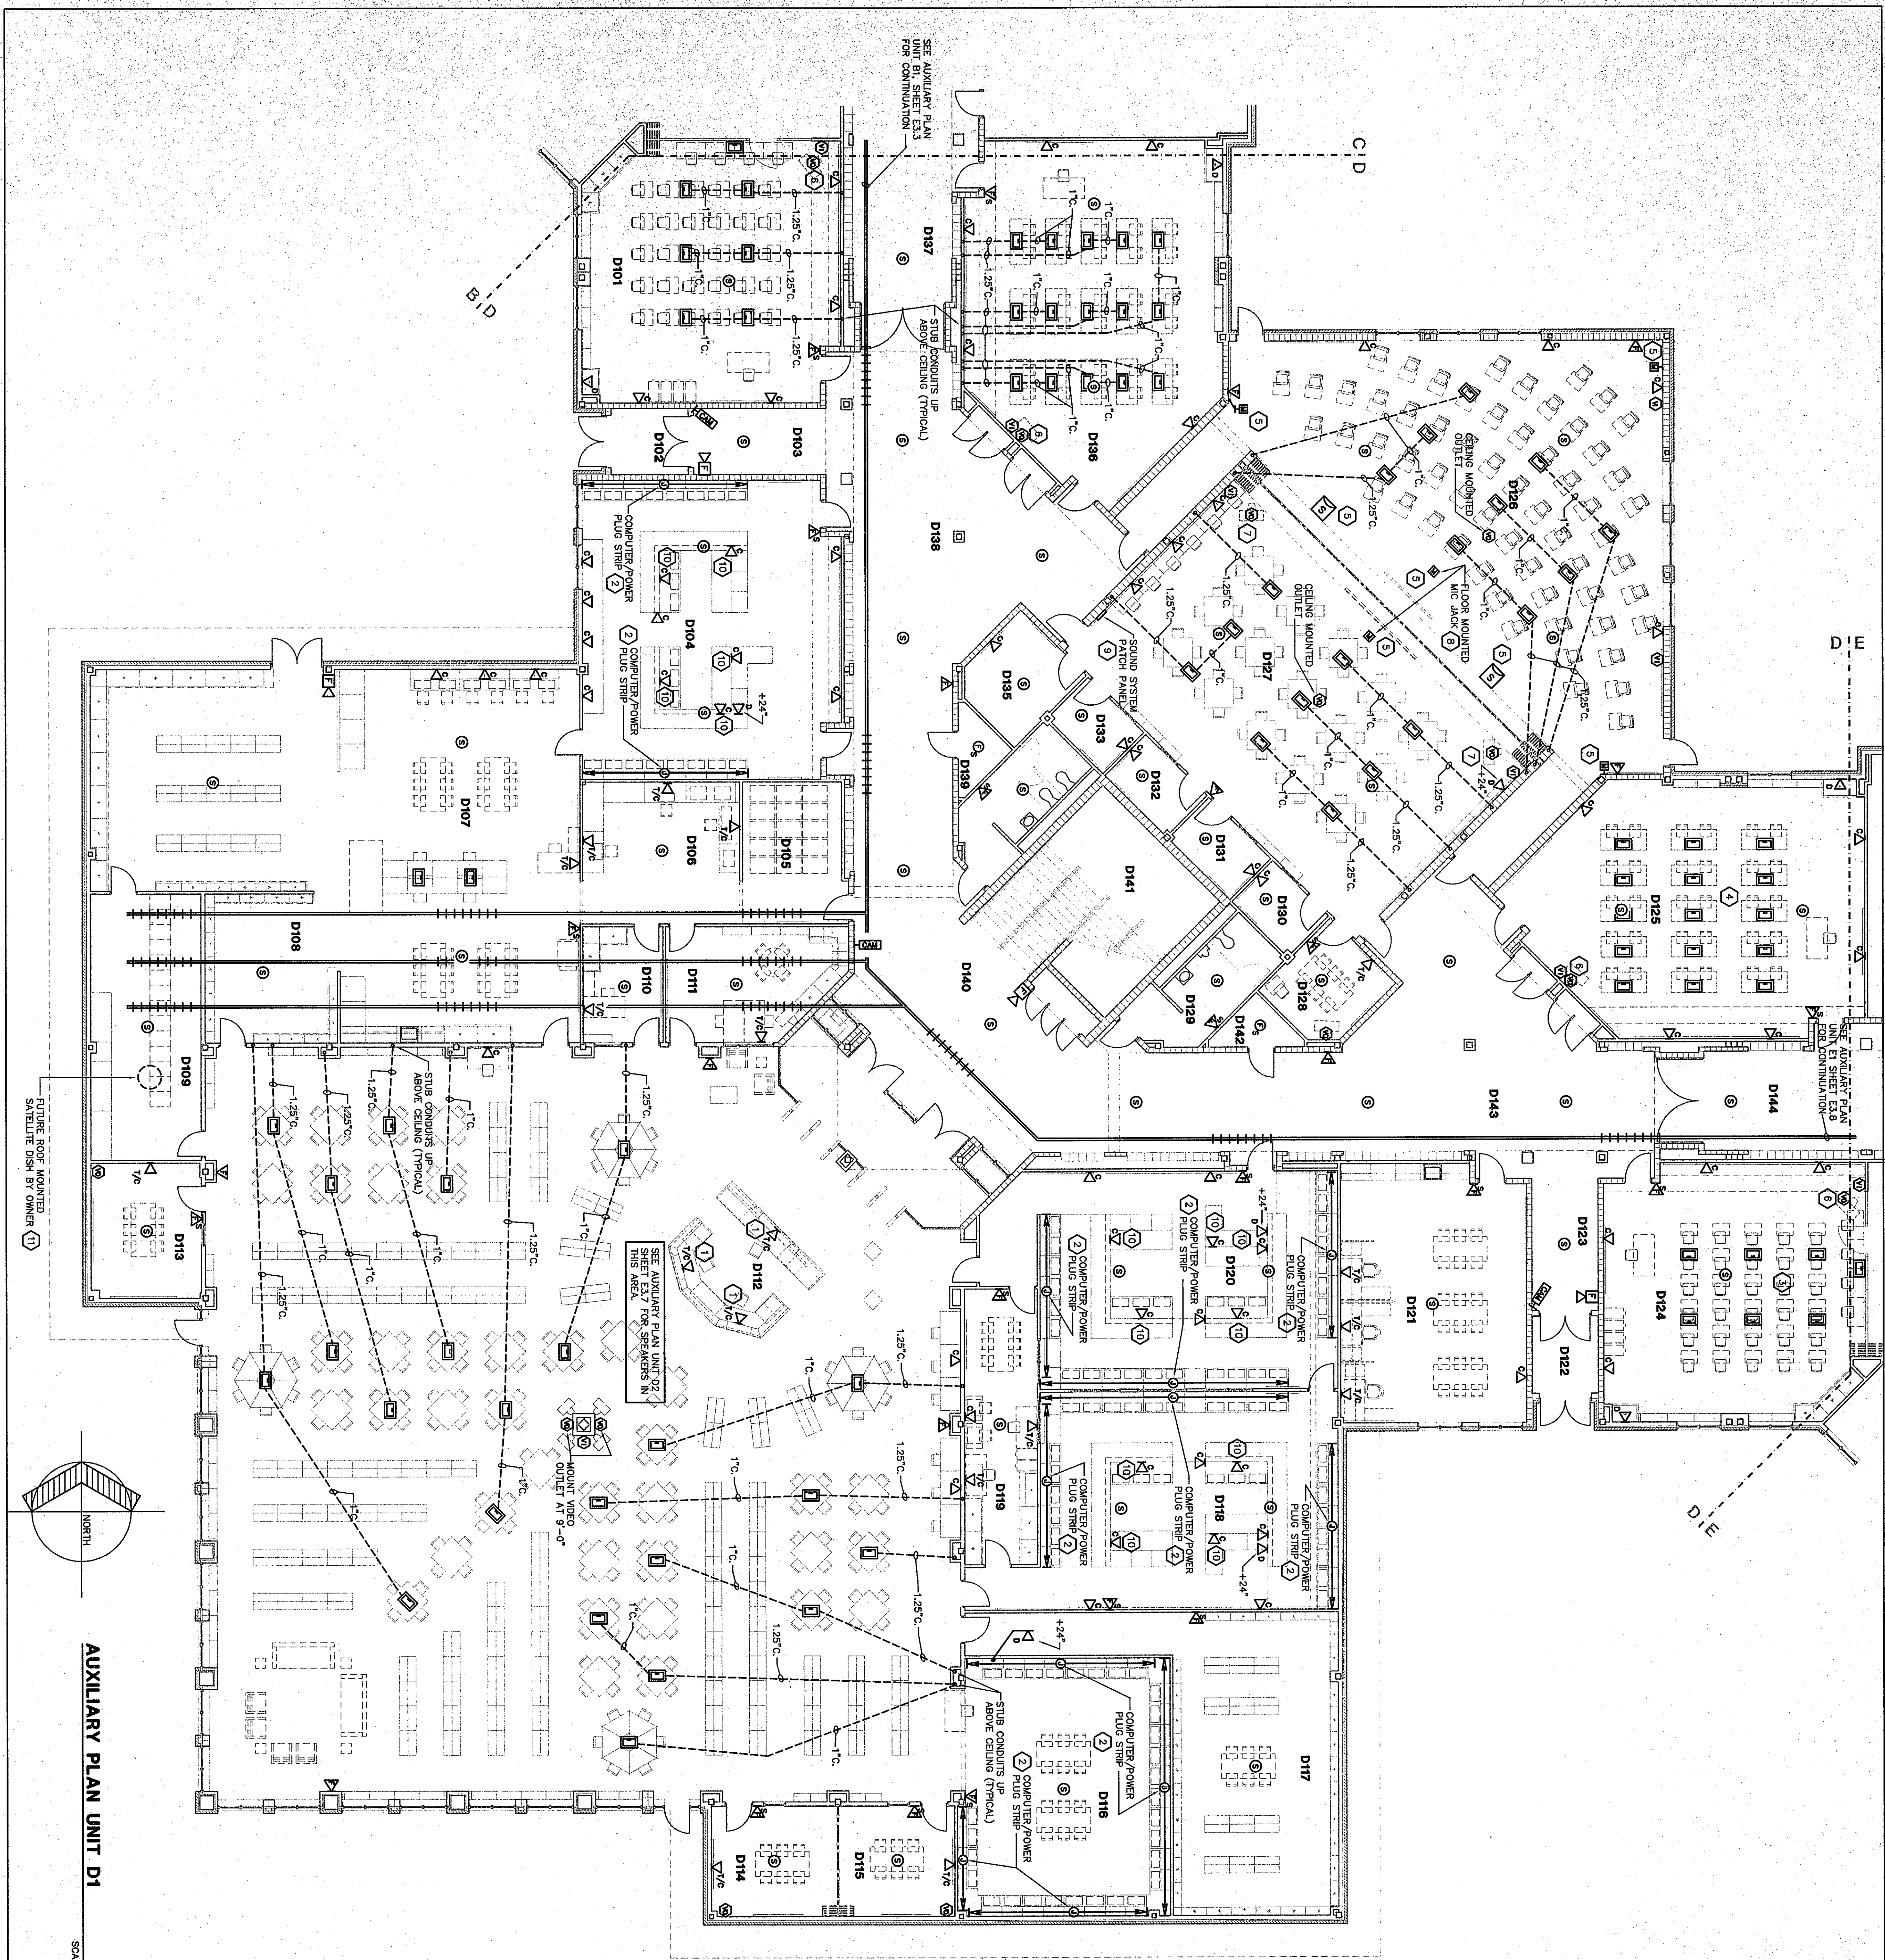

AUXILIARY PLAN UNIT D1

SCALE 1/8" = 1'-0"

| ROOM LEGEND "D1" |                     |           |                |
|------------------|---------------------|-----------|----------------|
| ROOM NO.         | ROOM NAME           | AREA S.F. | CEILING HEIGHT |
| D101             | CLASSROOM           | 959       | 9'-4"          |
| D102             | VESTIBULE           | 75        | 9'-4"          |
| D103             | CLASSROOM           | 128       | 10'-0"         |
| D104             | CLASSROOM           | 128       | 10'-0"         |
| D105             | CLASSROOM           | 200       | 9'-4"          |
| D106             | COMPUTER TECHNICIAN | 328       | 9'-4"          |
| D107             | COMPUTER TECHNICIAN | 288       | 9'-4"          |
| D108             | COMPUTER TECHNICIAN | 288       | 9'-4"          |
| D109             | COMPUTER TECHNICIAN | 433       | 9'-4"          |
| D110             | COMPUTER TECHNICIAN | 433       | 9'-4"          |
| D111             | COMPUTER TECHNICIAN | 219       | 9'-4"          |
| D112             | COMPUTER TECHNICIAN | 189       | 9'-4"          |
| D113             | COMPUTER TECHNICIAN | 189       | 9'-4"          |
| D114             | COMPUTER TECHNICIAN | 189       | 9'-4"          |
| D200             | COMPUTER TECHNICIAN | 189       | 9'-4"          |

FLOOR BOXES ARE SHOWN ON AUXILIARY AND POWER PLANS.

PLAN NOTES:

1. STUB CONDUIT UP THRU FLOOR AND INTO CHASE OF CASEWORK, FROM TELEPHONE/COMPUTER BACK BOX AT 18' ABOVE FINISH FLOOR. SEE DETAIL 9/21.10.
2. COMPUTER/POWER PLUG STRIP IS ALSO SHOWN ON POWER PLAN E3.6, ROOM D101 FOR TYPICAL CONDUIT SIZE TO EACH FLOOR BOX.
3. REFER TO ROOM D101 FOR TYPICAL CONDUIT SIZE TO EACH FLOOR BOX.
4. REFER TO ROOM D136 FOR TYPICAL CONDUIT SIZE TO PATCH PANEL IN ROOM D127.
5. WIRE SPEAKERS AND MICROPHONE JACKS IN ROOM D126 TO PATCH PANEL IN ROOM D127.
6. REFER TO VIDEO ROUGH-IN AND TELEVISION RECEPTACLE LOCATION, DETAILS 9/21.9 AND 9/21.5 FOR ADDITIONAL INFORMATION.
7. MOUNT VIDEO OUTLET IN CEILING.
8. PROVIDE A SINGLE GANG FLOOR BOX EQUAL TO HUBBELL B2414 WITH BRASS COVERPLATE. SEE SPECIFICATIONS.
9. SOUND SYSTEM PATCH PANEL FOR ROOM D126. REFER TO DETAIL 10/21.10 FOR ADDITIONAL INFORMATION.
10. MOUNT COMPUTER ROUGH-IN BOX PER DETAIL 1/1.10.
11. RUN A 1.25 INCH CONDUIT TO ROOM D109 FROM SATELLITE DISH.

