



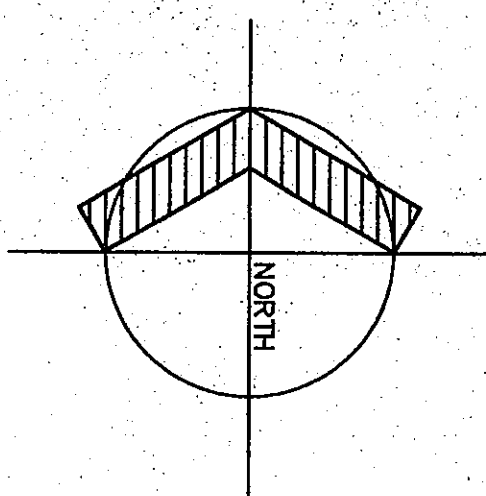

AUXILIARY PLAN UNIT D2

SCALE 1/8" = 1'-0"

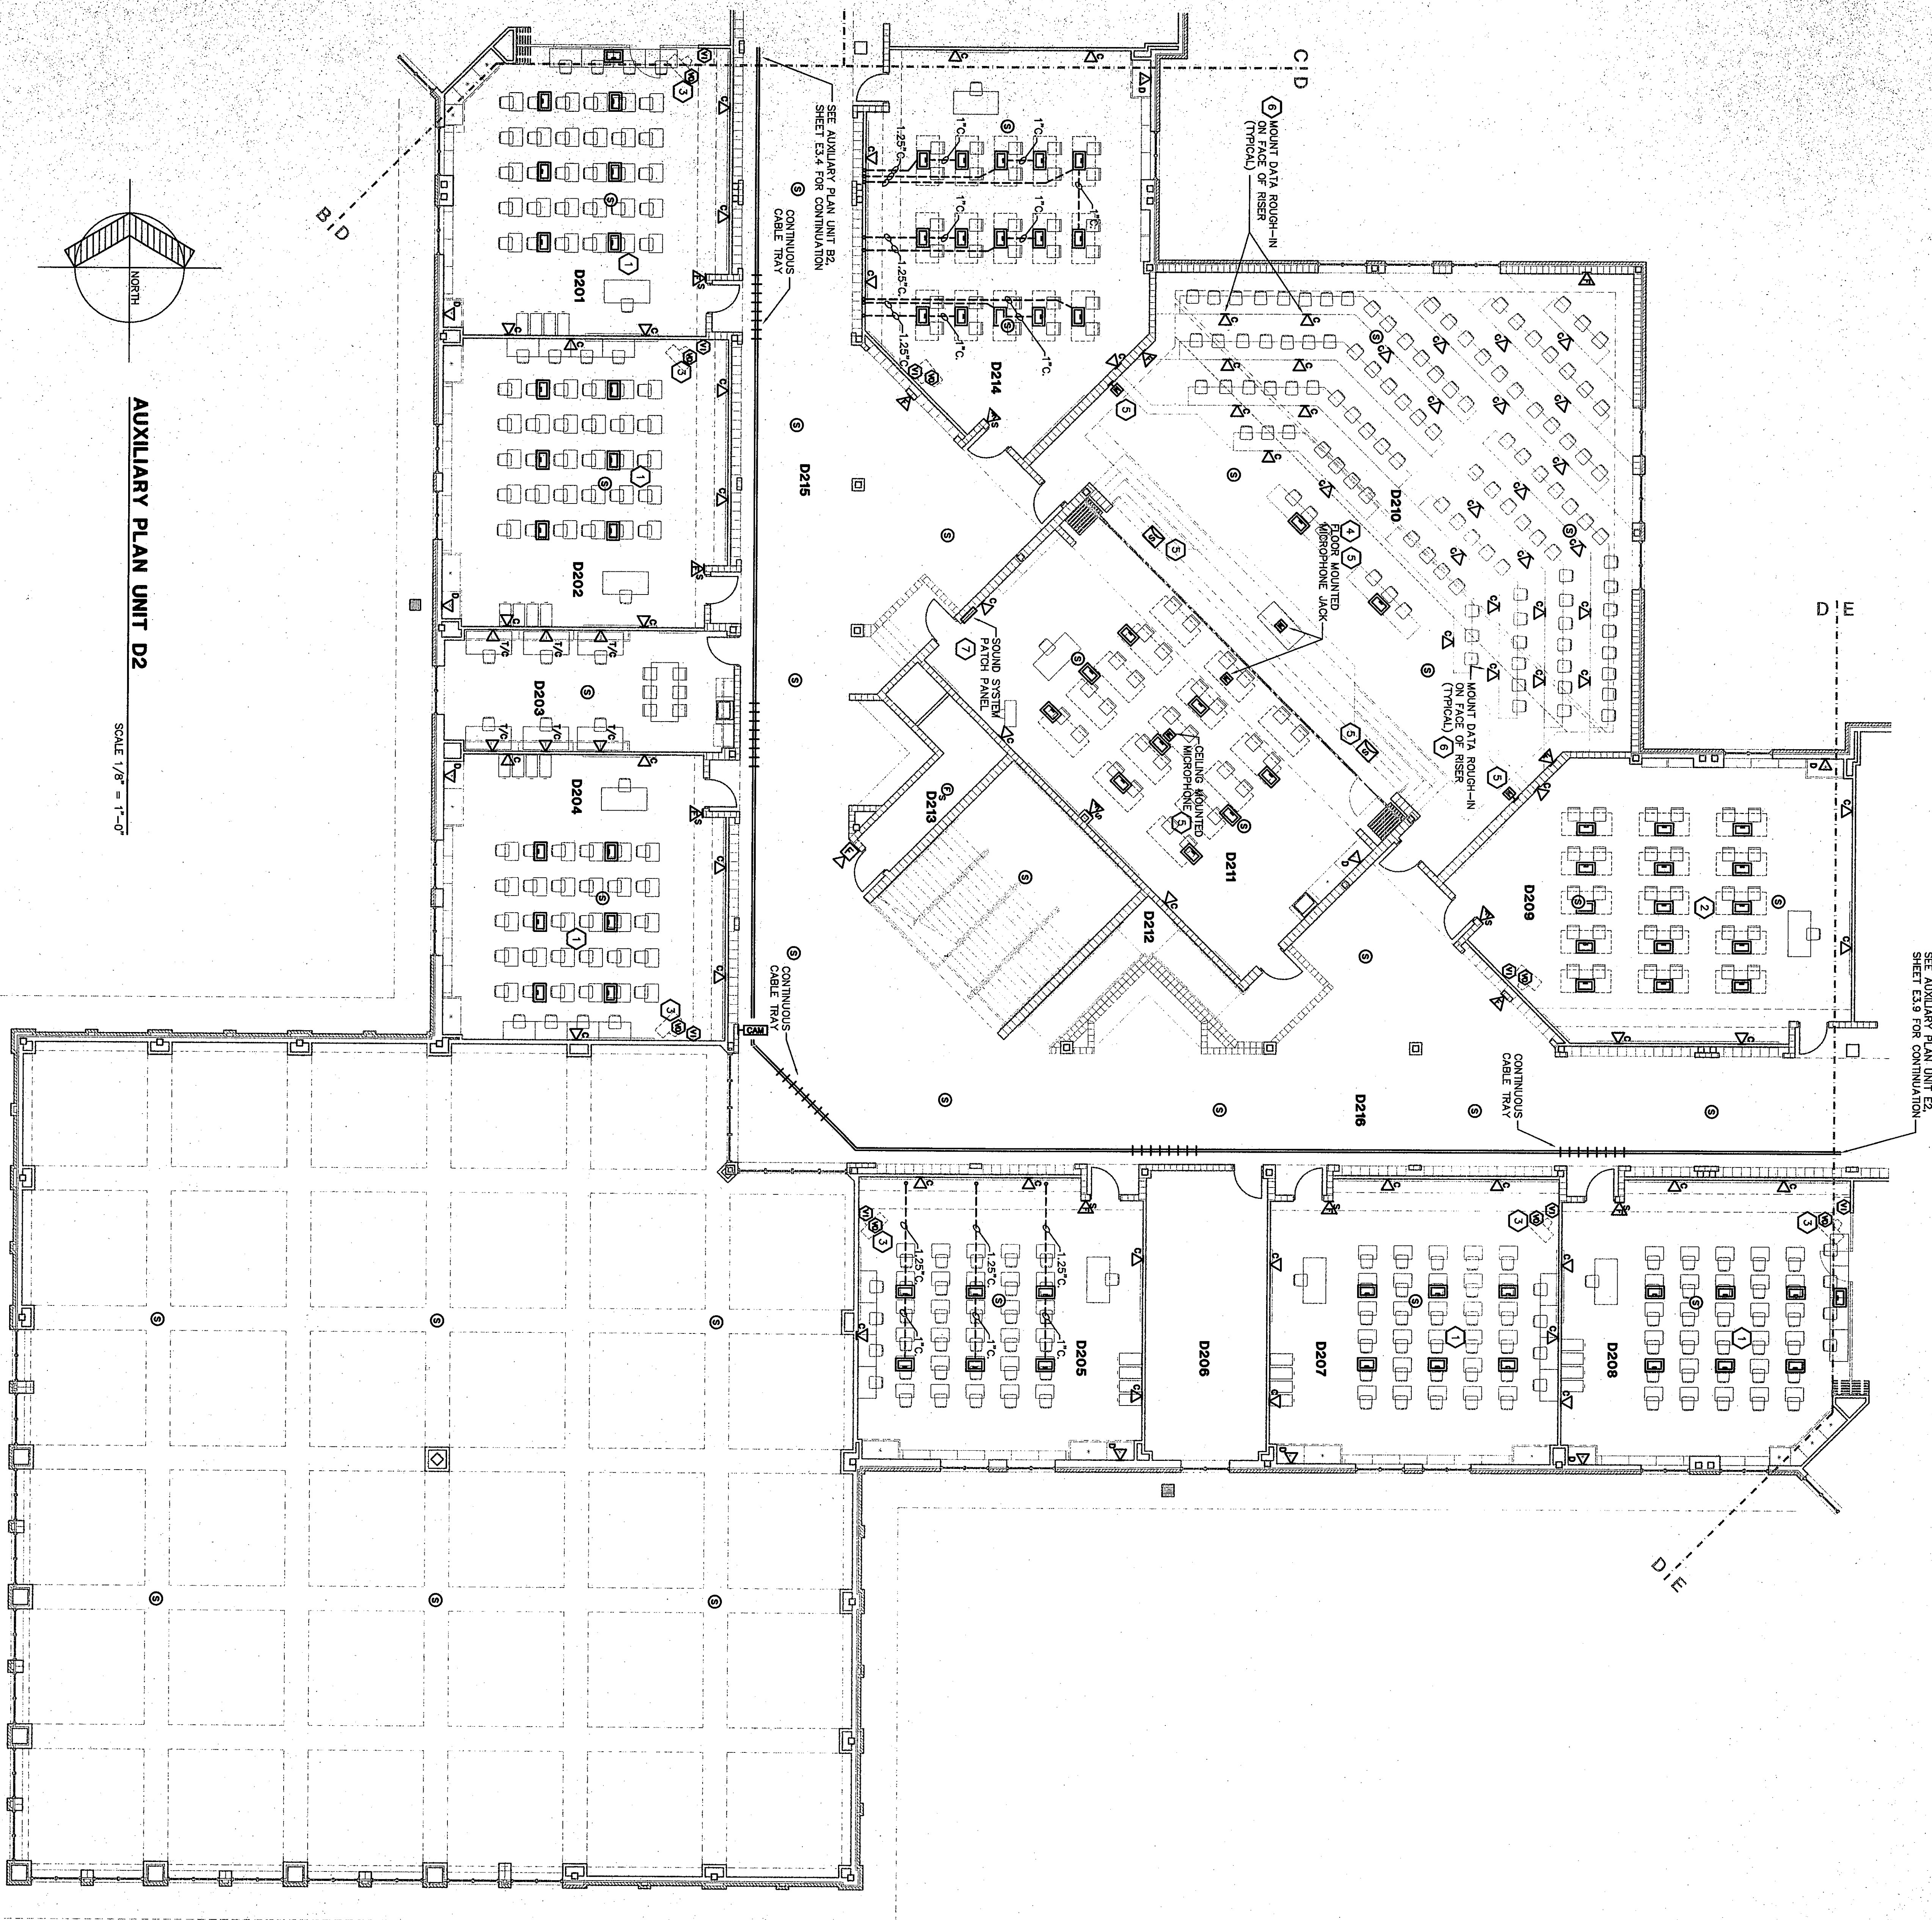

ROOM LEGEND "D2"

ROOM NO.	NAME	AREA	CEILING HEIGHT
D201	CLASSROOM	925	9'-4"
D202	CLASSROOM	925	9'-4"
D203	DEPARTMENTAL OFFICE	418	9'-4"
D204	CLASSROOM	931	9'-4"
D205	CLASSROOM	422	9'-4"
D206	STORAGE	972	9'-4"
D207	CLASSROOM	1185	9'-4"
D208	COMPUTER LAB	2888	13'-4"
D209	LARGE GROUP INSTRUCTION	2100	13'-4"
D210	INTERGRADED STUDY LAB	131	10'-0"
D211	ELECTRICAL ROOM	1185	10'-0"
D212	COMPUTER LAB	2052	10'-0"
D213	COMPUTER LAB	2052	10'-0"
D214	CORRIDOR	2052	10'-0"
D215	CORRIDOR	2052	10'-0"
D216	CORRIDOR	2052	10'-0"

FLOOR BOXES ARE SHOWN ON
AUXILIARY AND POWER PLANS.

PLAN NOTES:



1. REFER TO ROOM D205 FOR TYPICAL DATA CONDUIT ROUTING AND CONDUIT SIZE TO EACH FLOOR BOX.
2. REFER TO ROOM D214 FOR TYPICAL DATA CONDUIT ROUTING AND CONDUIT SIZE TO EACH FLOOR BOX.
3. REFER TO VIDEO ROUGH-IN AND TELEVISION RECEPTACLE LOCATION, DETAILS 9/E1.3 AND 9/E1.5 FOR ADDITIONAL INFORMATION.
4. PROVIDE A SINGLE GANG FLOOR BOX EQUAL TO HUBBELL D2414 WITH BRASS COVERPLATE. SEE SPECIFICATIONS.
5. WIRE SPEAKERS AND MICROPHONE JACKS IN ROOM D210 AND D211 TO PATCH PANEL IN ROOM D211.
6. SEE DETAIL 9/E1.10 FOR DATA ROUGH-IN REQUIREMENTS.
7. SOUND SYSTEM PATCH PANEL FOR ROOM D210. REFER TO DETAIL 10/E1.10 FOR ADDITIONAL INFORMATION.



KEY PLAN

THE NEW
CHESTERTON HIGH SCHOOL
FOR THE
DUNELAND SCHOOL CORPORATION
CHESTERTON, INDIANA

COPYRIGHT 1997 BY FANNING/HOWEY ASSOCIATES, INC.

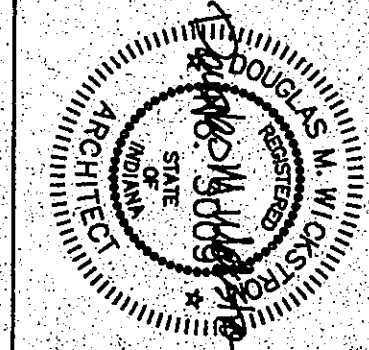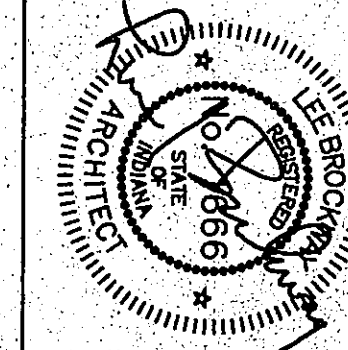

Fanning/Howey
Associates, Inc.
Architects Engineers Consultants

AUXILIARY PLAN UNIT D2

DRAWN BY: MRS. COMM. NO.: 95067.00
CHECKED BY: WBH DATE: APRIL 21, 1997

E3.7

REVISIONS NO. DATE