


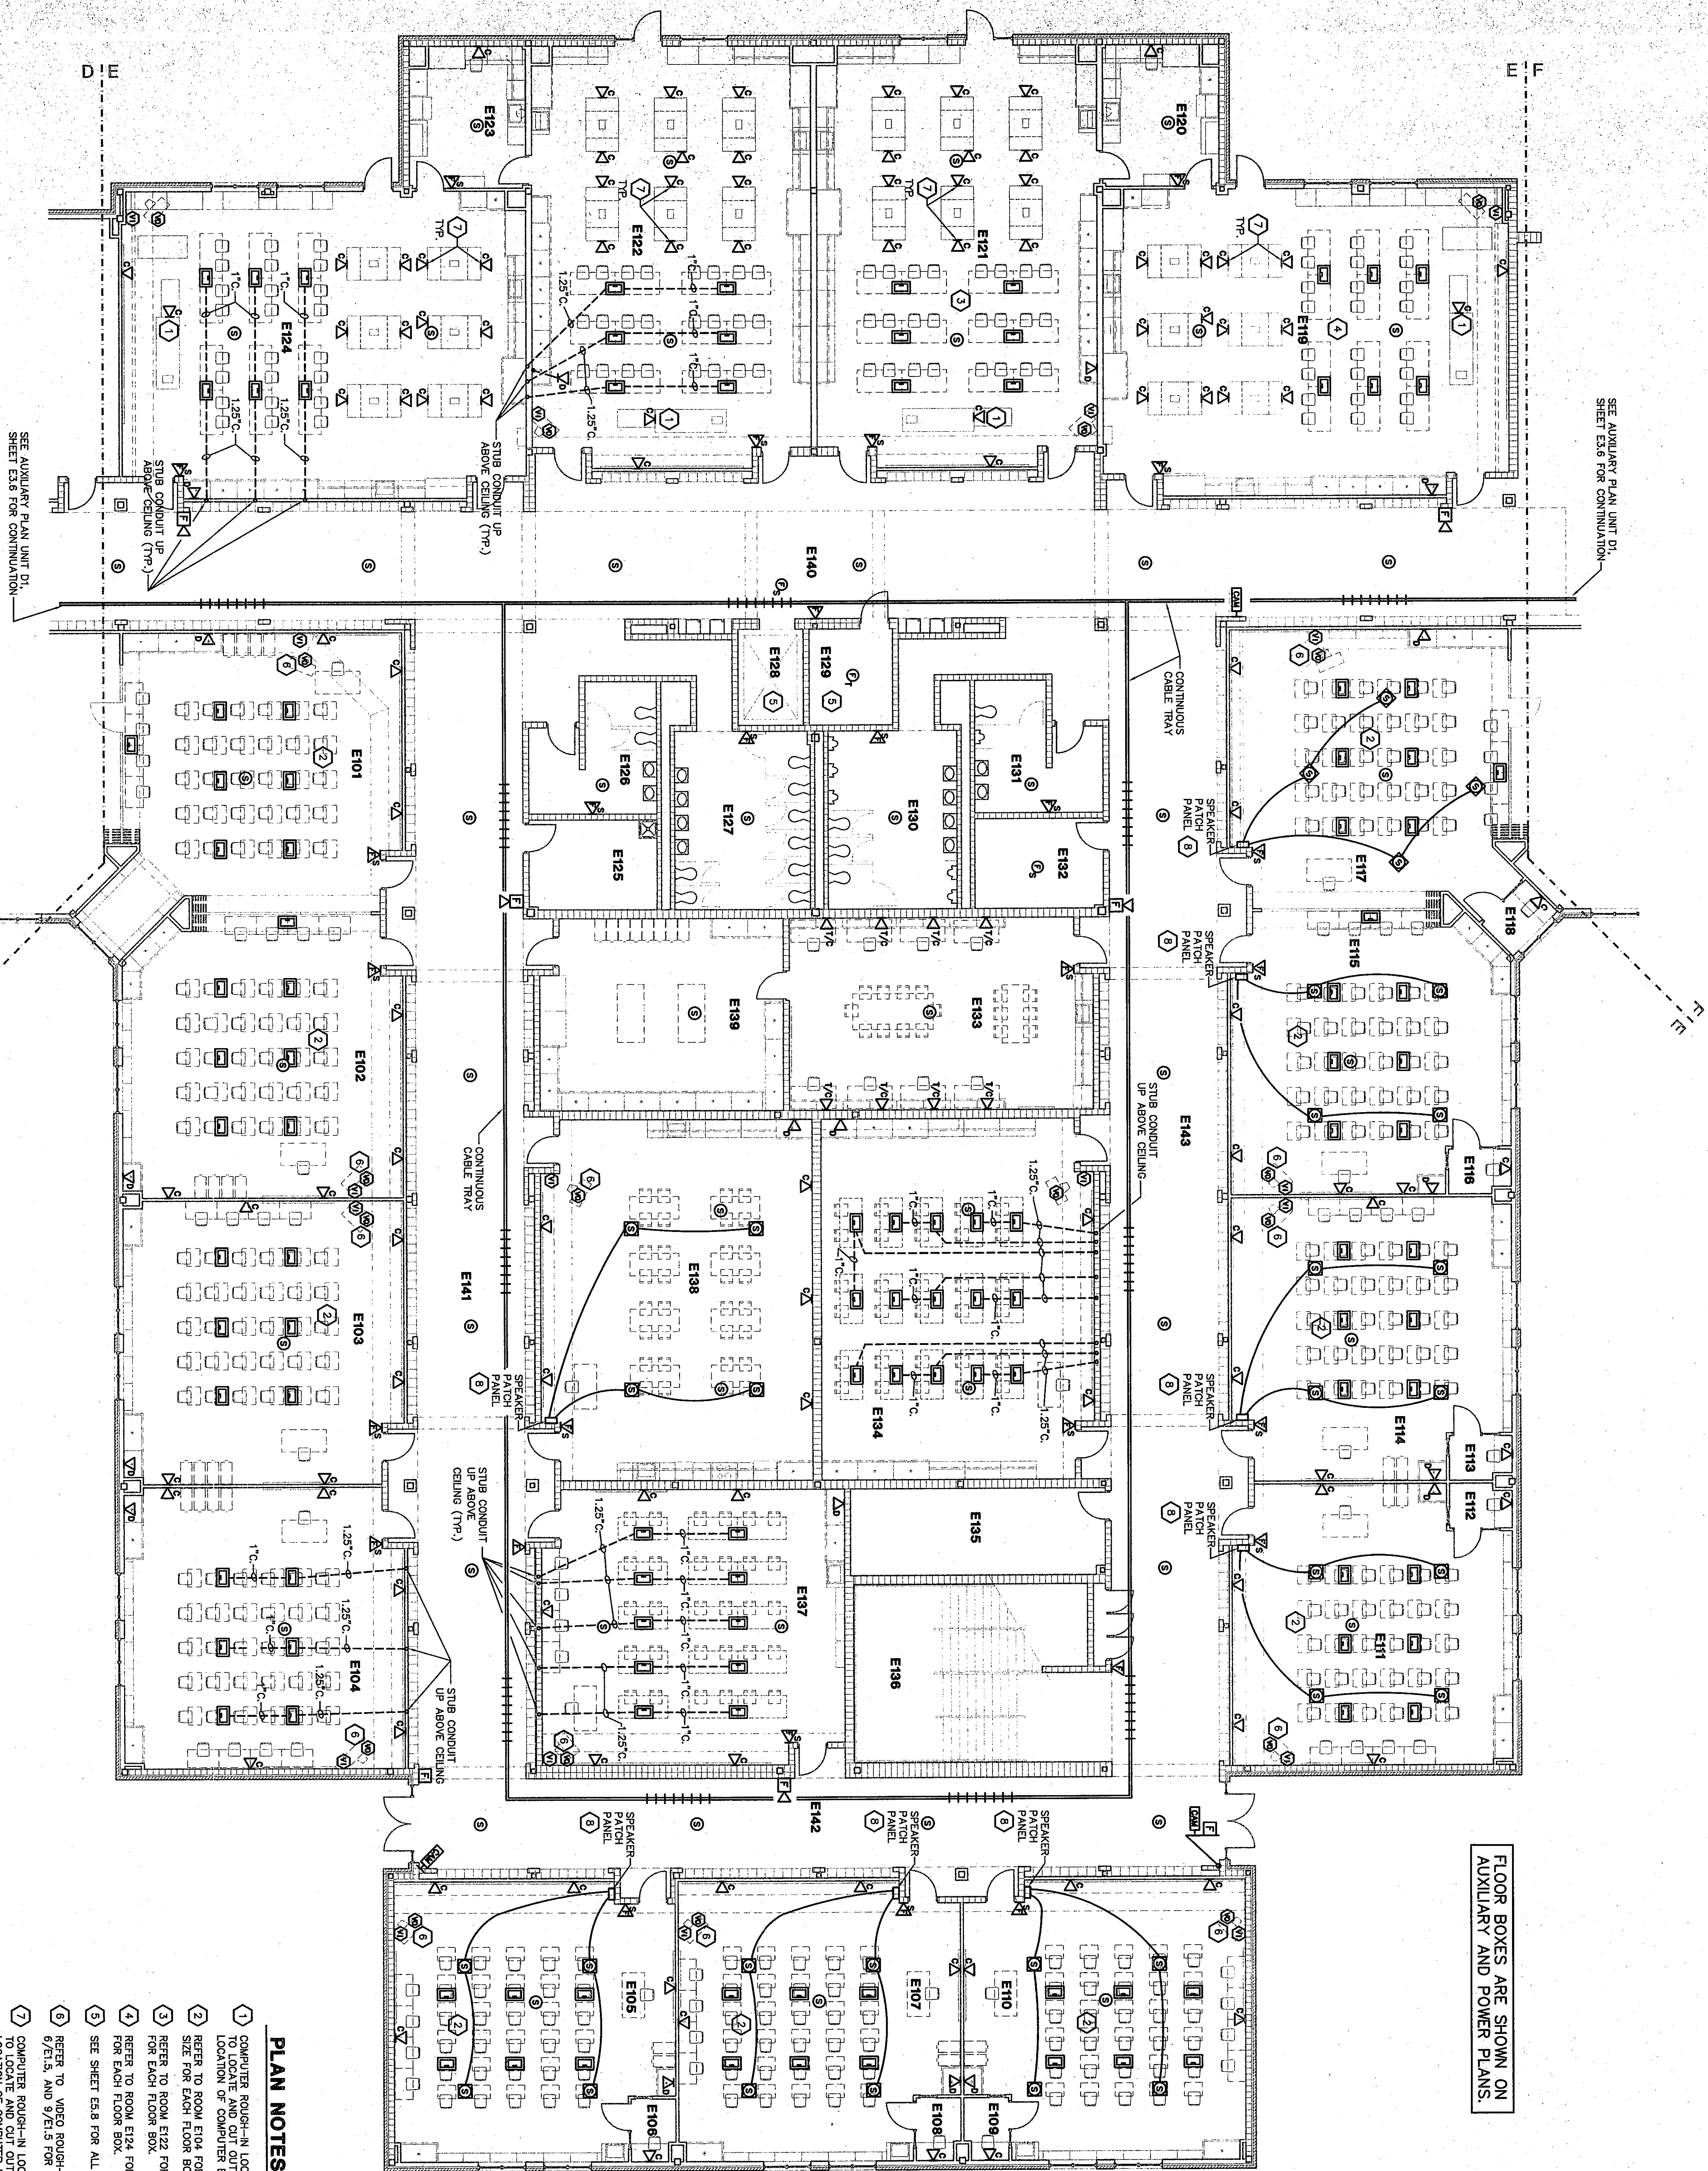


FLOOR BOXES ARE SHOWN ON
AUXILIARY AND POWER PLANS.


ROOM LEGEND "E1"		
ROOM NO.	ROOM NAME	AREA
E101	CLASSROOM	57.0
E102	CLASSROOM	57.0
E103	CLASSROOM	57.0
E104	CLASSROOM	57.0
E105	CLASSROOM	57.0
E106	CLASSROOM	57.0
E107	CLASSROOM	57.0
E108	CLASSROOM	57.0
E109	CLASSROOM	57.0
E110	CLASSROOM	57.0
E111	CLASSROOM	57.0
E112	CLASSROOM	57.0
E113	CLASSROOM	57.0
E114	CLASSROOM	57.0
E115	CLASSROOM	57.0
E116	CLASSROOM	57.0
E117	CLASSROOM	57.0
E118	CLASSROOM	57.0
E119	CLASSROOM	57.0
E120	CLASSROOM	57.0
E121	CLASSROOM	57.0
E122	CLASSROOM	57.0
E123	CLASSROOM	57.0
E124	CLASSROOM	57.0
E125	CLASSROOM	57.0
E126	CLASSROOM	57.0
E127	CLASSROOM	57.0
E128	CLASSROOM	57.0
E129	CLASSROOM	57.0
E130	CLASSROOM	57.0
E131	CLASSROOM	57.0
E132	CLASSROOM	57.0
E133	CLASSROOM	57.0
E134	CLASSROOM	57.0
E135	CLASSROOM	57.0
E136	CLASSROOM	57.0
E137	CLASSROOM	57.0
E138	CLASSROOM	57.0
E139	CLASSROOM	57.0
E140	CLASSROOM	57.0
E141	CLASSROOM	57.0
E142	CLASSROOM	57.0
E143	CLASSROOM	57.0

PLAN NOTES:

1. COMPUTER ROOM-IN LOCATED IN CASEWORK, CASEWORK MANUFACTURER TO LOCATE AND CUT OUT FOR ELECTRICAL BACK BOX. SEE DETAIL 5/E110.
2. REFER TO ROOM E104 FOR TYPICAL DATA CONDUIT ROUTING AND CONDUIT SIZE FOR EACH FLOOR BOX.
3. REFER TO ROOM E102 FOR TYPICAL DATA CONDUIT ROUTING AND SIZE FOR EACH FLOOR BOX.
4. REFER TO ROOM E124 FOR TYPICAL DATA CONDUIT ROUTING AND SIZE FOR EACH FLOOR BOX.
5. SEE SHEET E3.8 FOR ALL ELEVATOR TELEPHONE DATA REQUIREMENTS.
6. REFER TO VIDEO ROUGH-IN AND TELEVISION RECEPTACLE LOCATION DETAIL 6/E1.5, AND 6/E1.5 FOR ADDITIONAL INFORMATION.
7. COMPUTER ROOM-IN LOCATED IN CASEWORK, CASEWORK MANUFACTURER TO LOCATE AND CUT OUT FOR ELECTRICAL BACK BOX. VERIFY EXACT LOCATION OF COMPUTER BACK BOX IN THE FIELD. SEE DETAIL 4/E1.11.
8. SPEAKER PATCH PANEL. REFER TO DETAIL 10/E1.10 FOR ADDITIONAL INFORMATION.

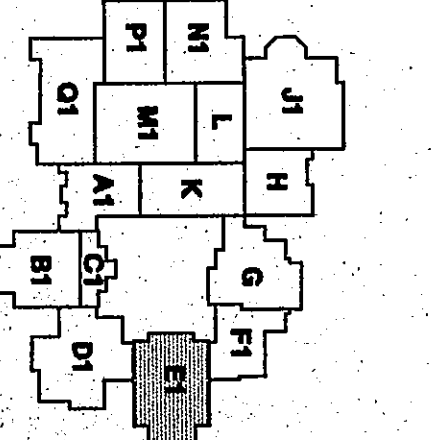

THE NEW
CHESTERTON HIGH SCHOOL
FOR THE
DUNELAND SCHOOL CORPORATION
CHESTERTON, INDIANA

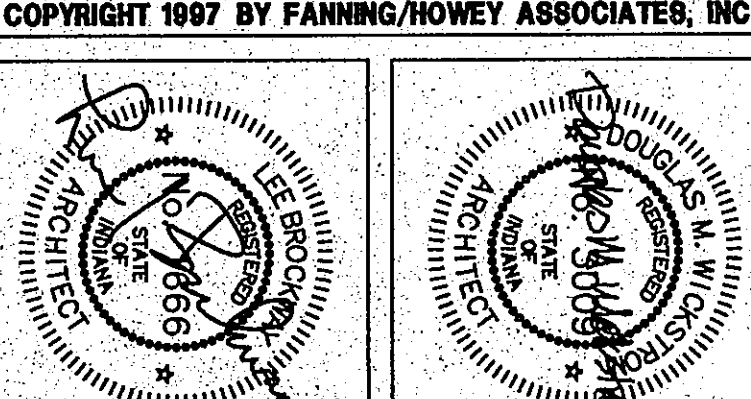

AUXILIARY PLAN UNIT E1

DRAWN BY: MRS. W.B.H.

CHECKED BY: W.B.H.

COMM. NO.: 95067.00

DATE: APRIL 21, 1997

E3.8

REVISIONS NO. DATE

Fanning/Howey

Associates, Inc.

Architects Engineers Consultants