


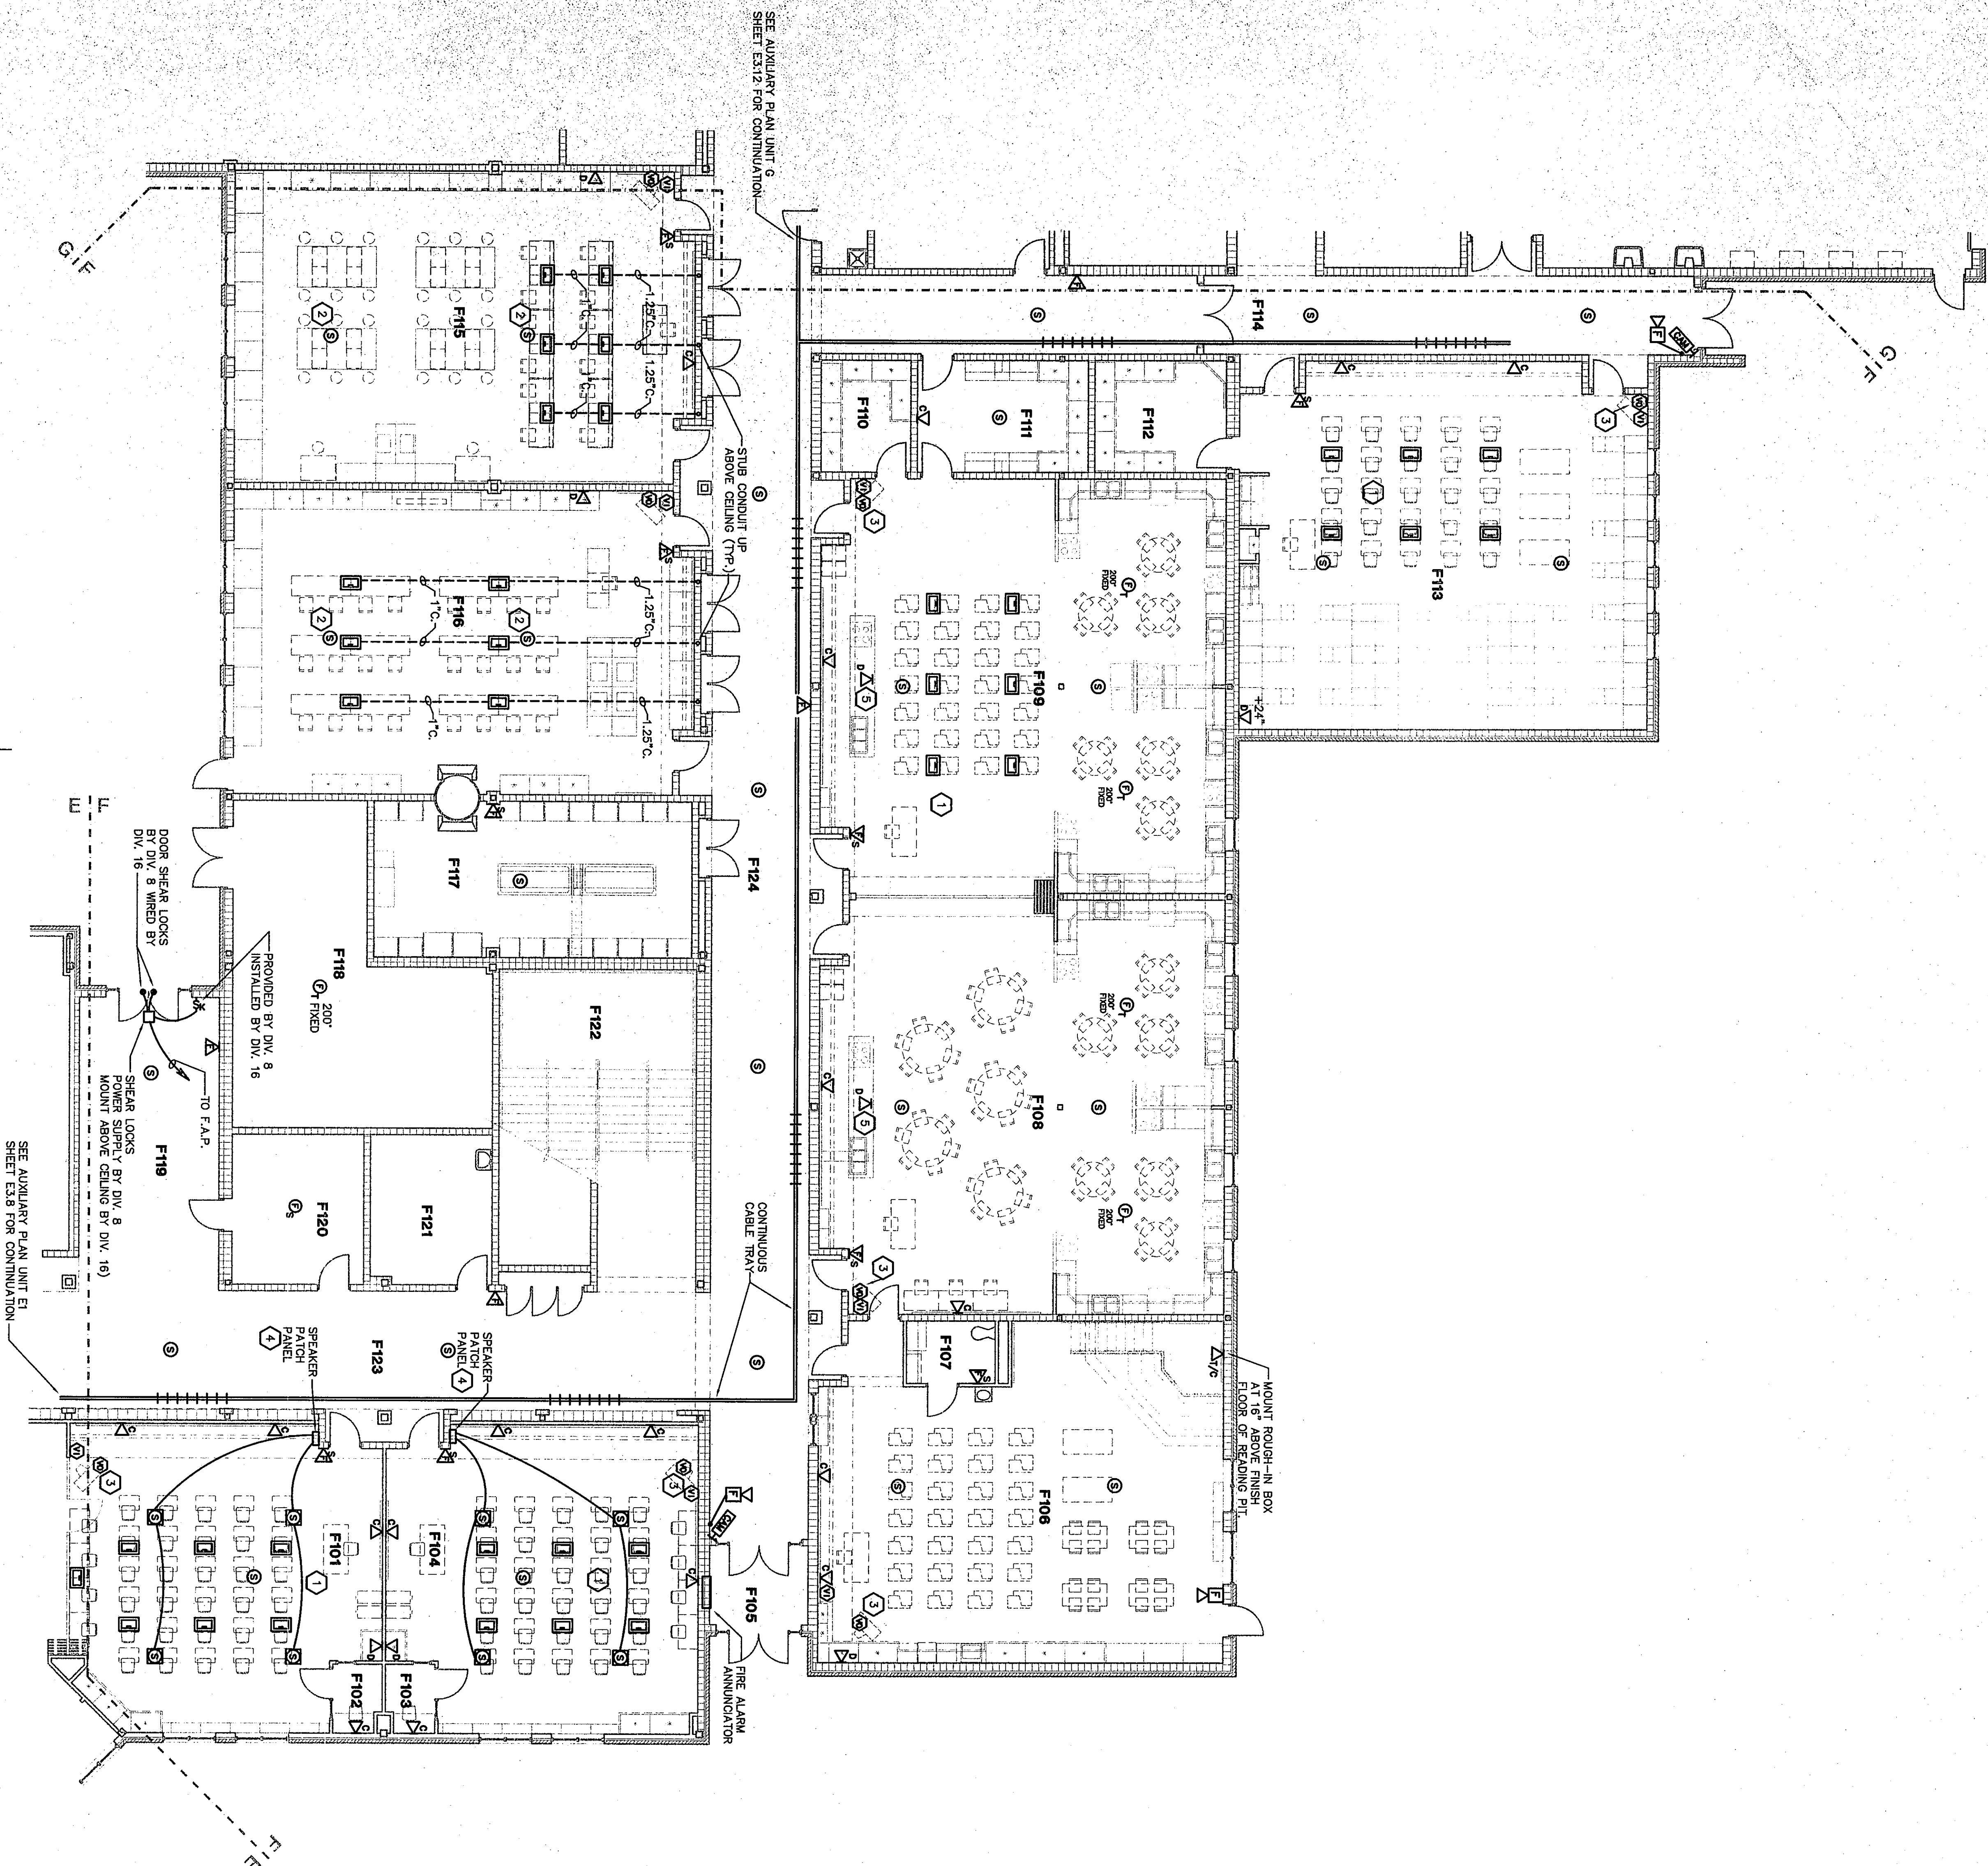

FLOOR BOXES ARE SHOWN ON
AUXILIARY AND POWER PLANS.

PLAN NOTES:


- 1 REFER TO ROOM F115 FOR TYPICAL DATA CONDUIT ROLLING AND CONDUIT SIZE TO EACH FLOOR BOX.
- 2 PROVIDE SPEAKER WITH A SURFACE ENCLOSURE AND MOUNT AT 11'-0" ABOVE FINISH FLOOR.
- 3 REFER TO VIDEO ROUGH-IN AND TELEVISION RECEPTACLE LOCATION, DETAILS 9/E/13 AND 9/E/19 FOR ADDITIONAL INFORMATION.
- 4 SPEAKER PATCH PANEL, REFER TO DETAIL 10/E/110 FOR ADDITIONAL INFORMATION.
- 5 MOUNT DATA ROUGH-IN IN DEMO CABINET. VERIFY EXACT LOCATION IN THE FIELD.

ROOM LEGEND "F1"		
ROOM NO.	ROOM NAME	AREA S.F. CEILING HEIGHT
F101	CLASSROOM	923 9'-4"
F102	RECORDING	33 9'-4"
F103	CLASSROOM	835 9'-4"
F104	CLASSROOM	1334 9'-4"
F105	CHILD DEVELOPMENT	5748 9'-4"
F106	LAB	1683 9'-4"
F107	LAB	104 9'-4"
F108	LAB	151 9'-4"
F109	LAB	1496 9'-4"
F110	LAB	1447 9'-4"
F111	LAB	1409 9'-4"
F112	LAB	688 10'-0"
F113	LAB	420 10'-0"
F114	LAB	185 10'-0"
F115	LAB	515 10'-0"
F116	LAB	1448 10'-0"
F117	LAB	313 10'-0"

AUXILIARY PLAN UNIT F1

SCALE 1/8" = 1'-0"

Fanning/Howey Associates, Inc.
Architects Engineers Consultants

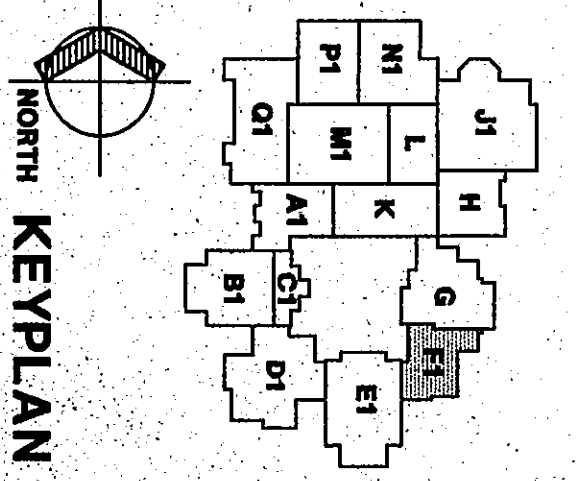

THE NEW
CHESTERTON HIGH SCHOOL
FOR THE
DUNELAND SCHOOL CORPORATION
CHESTERTON, INDIANA

COPYRIGHT 1997 BY FANNING/HOWEY ASSOCIATES, INC.

AUXILIARY PLAN UNIT F1

DRAWN BY: MRS COMM. NO.: 95067.00
CHECKED BY: WBH DATE: APRIL 21, 1997

E3.10

REVISIONS NO. DATE