
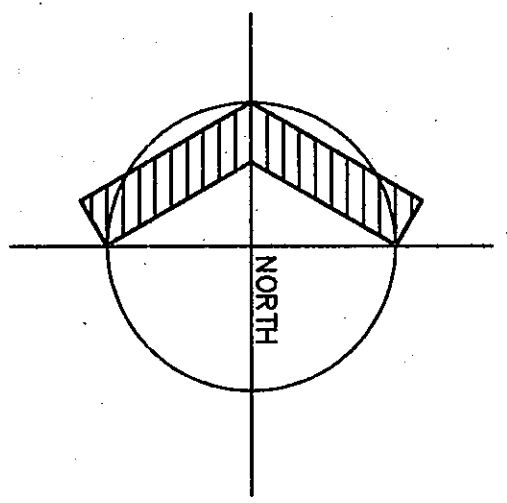


ROOM LEGEND "F1"			
ROOM NO.	ROOM NAME	AREA S.F.	CEILING HEIGHT
F201	CLASSROOM	922	9'-4"
F202	CLASSROOM	340	9'-4"
F203	STORAGE	823	10'-0"
F204	STORAGE		
F205	CLASSROOM		

- PLAN NOTES:**
- 1 REFER TO ROOM F204 FOR TYPICAL DATA CONDUIT ROUTING AND CONDUIT SIZE FOR EACH FLOOR BOX.
 - 2 REFER TO VIDEO ROUGH-IN AND TELEVISION RECEPTACLE LOCATION, DETAILS 6/E1.5 AND 9/E1.5 FOR ADDITIONAL INFORMATION.



FLOOR BOXES ARE SHOWN ON
AUXILIARY AND POWER PLANS.

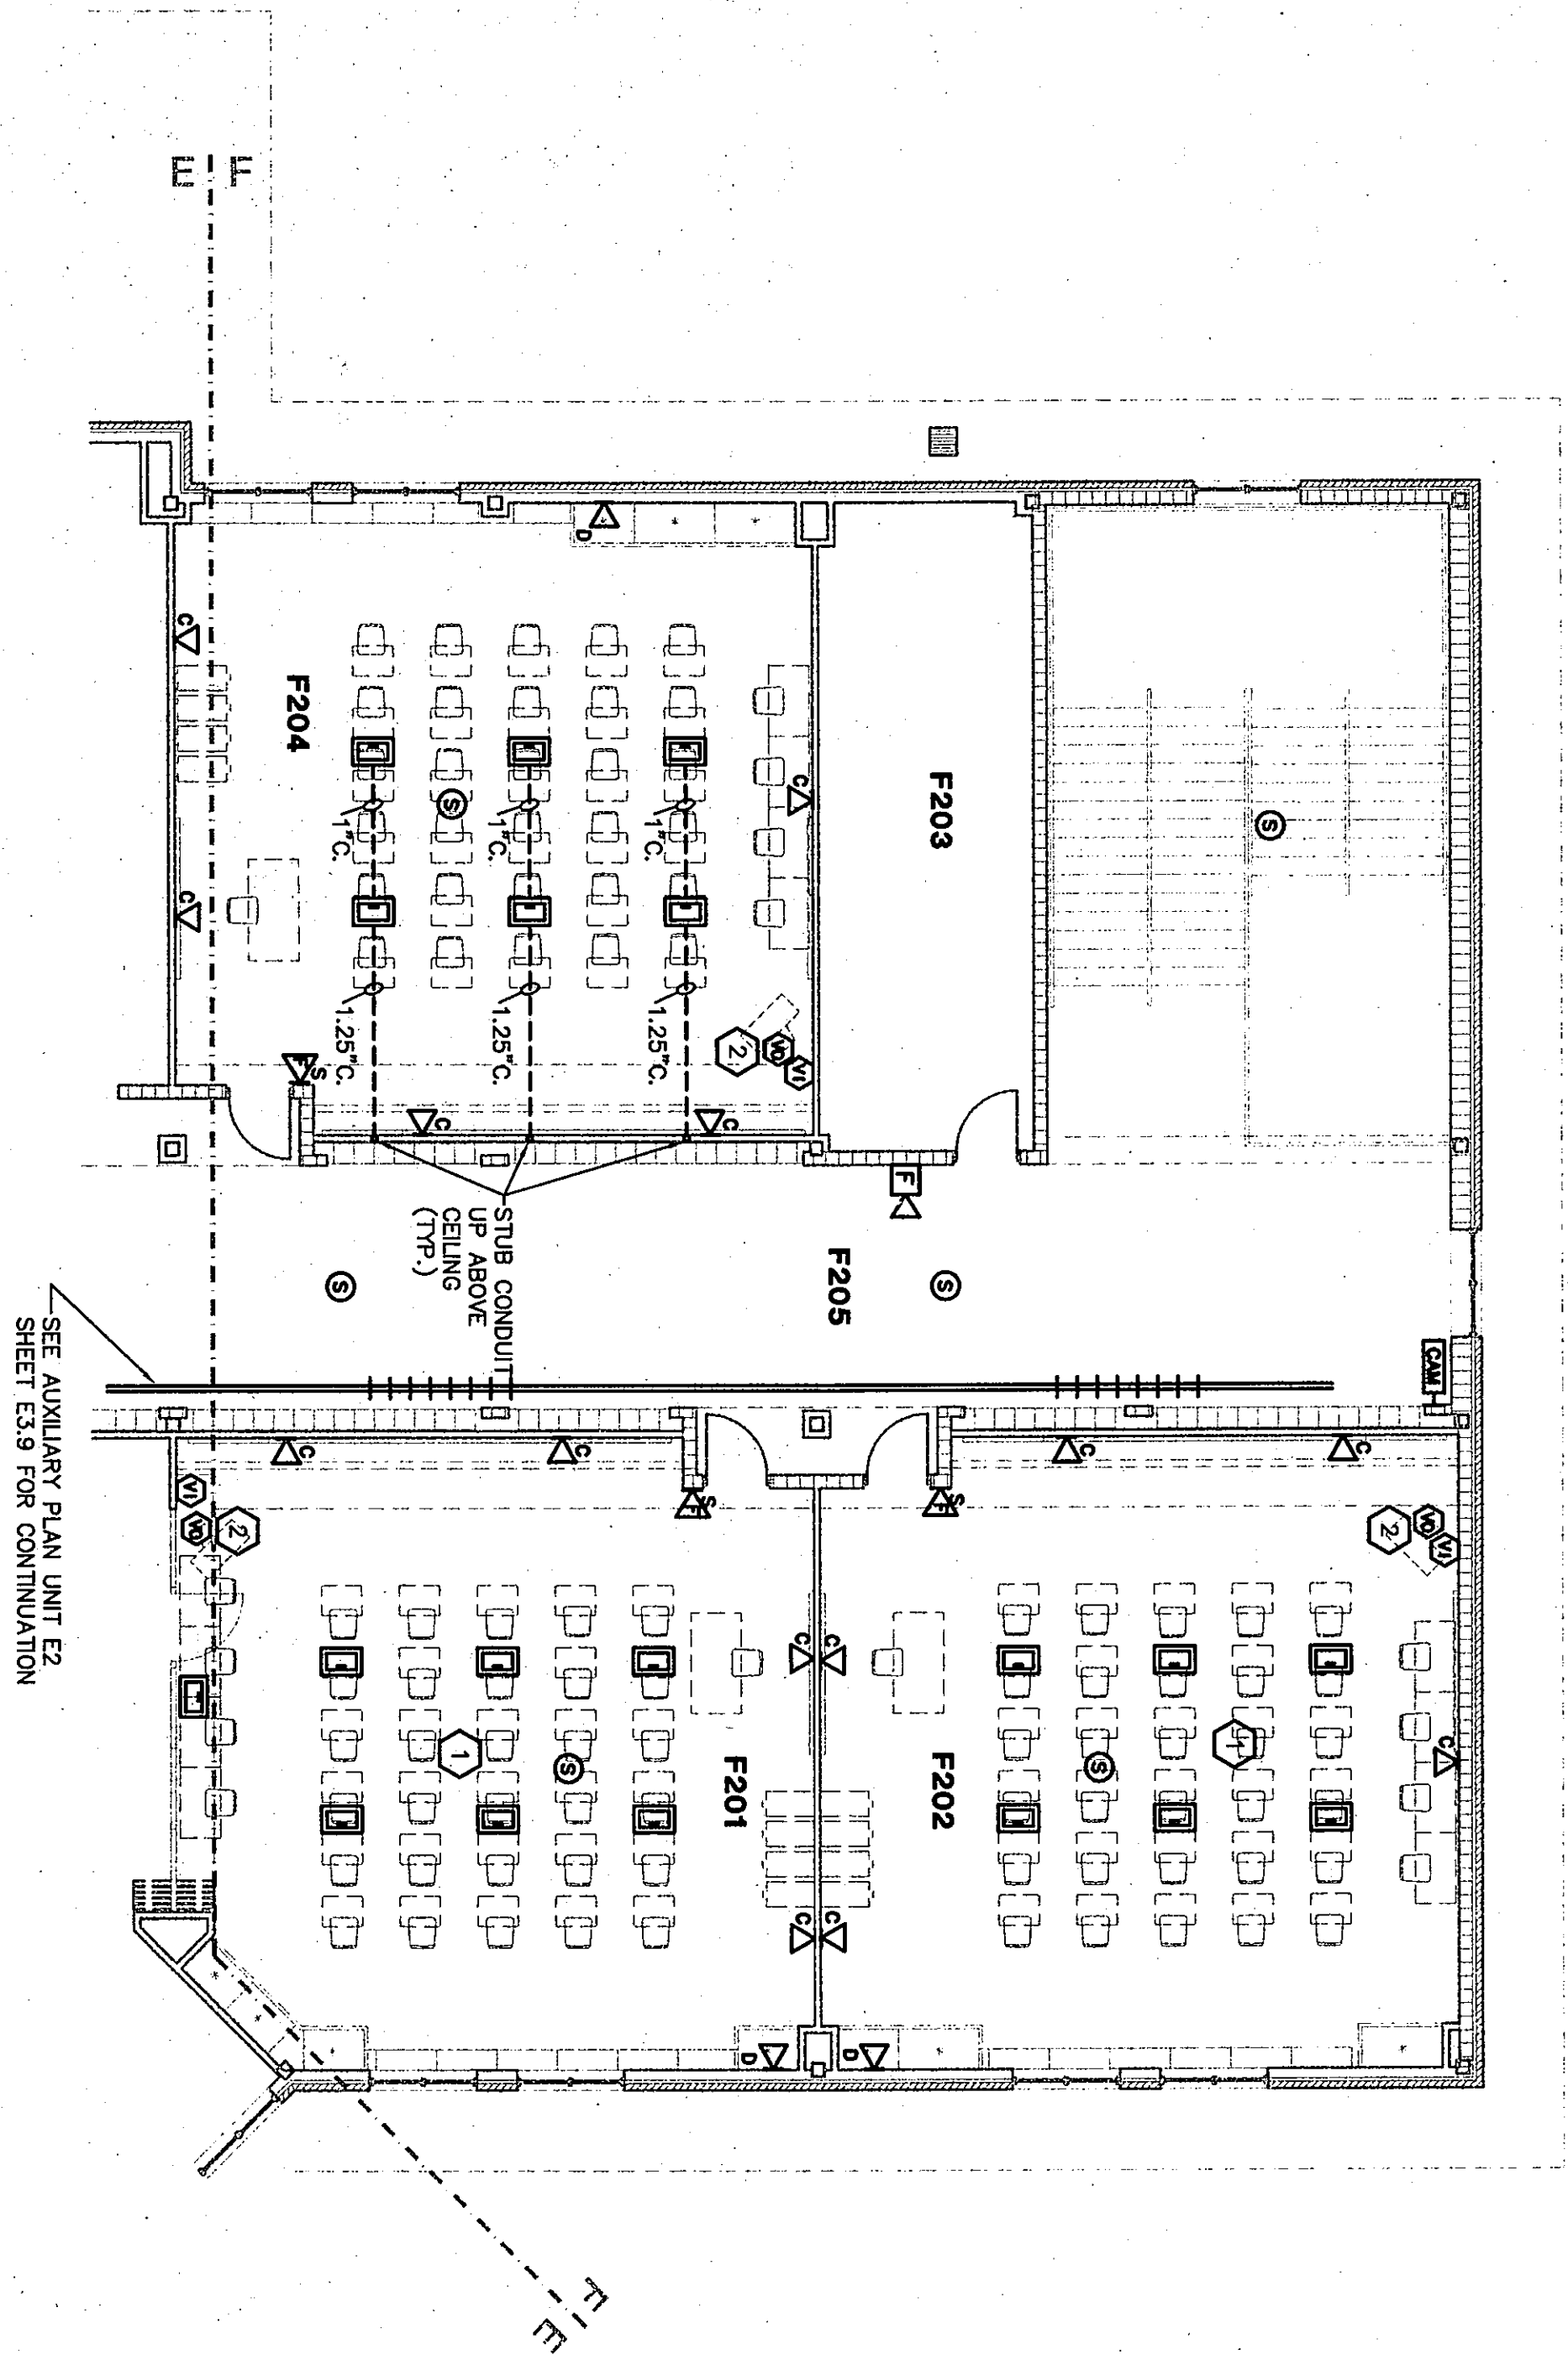


AUXILIARY PLAN UNIT F2

SCALE 1/8" = 1'-0"

COPYRIGHT 1997 BY FANNING/HOWEY ASSOCIATES, INC.

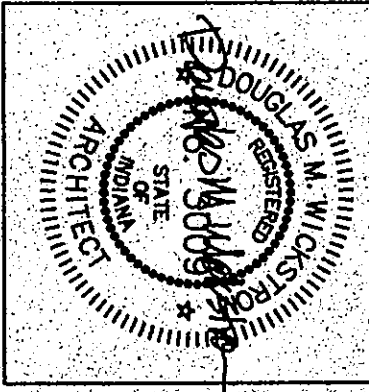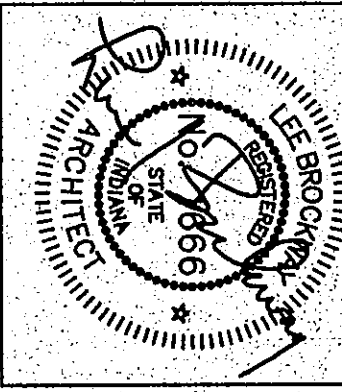

THE NEW
CHESTERTON HIGH SCHOOL
FOR THE
DUNELAND SCHOOL CORPORATION
CHESTERTON, INDIANA

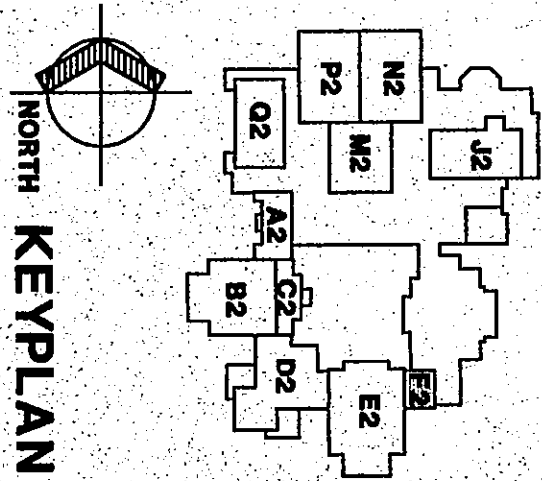

Fanning/Howey Associates, Inc.
Architects Engineers Consultants

AUXILIARY PLAN UNIT F2

DRAWN BY: MRS COMM. NO.: 95067.00
CHECKED BY: WBH DATE: APRIL 21, 1997

E3.11

REVISIONS NO. DATE

CHESTERTON HIGH SCHOOL
95067.00

01-E-29