



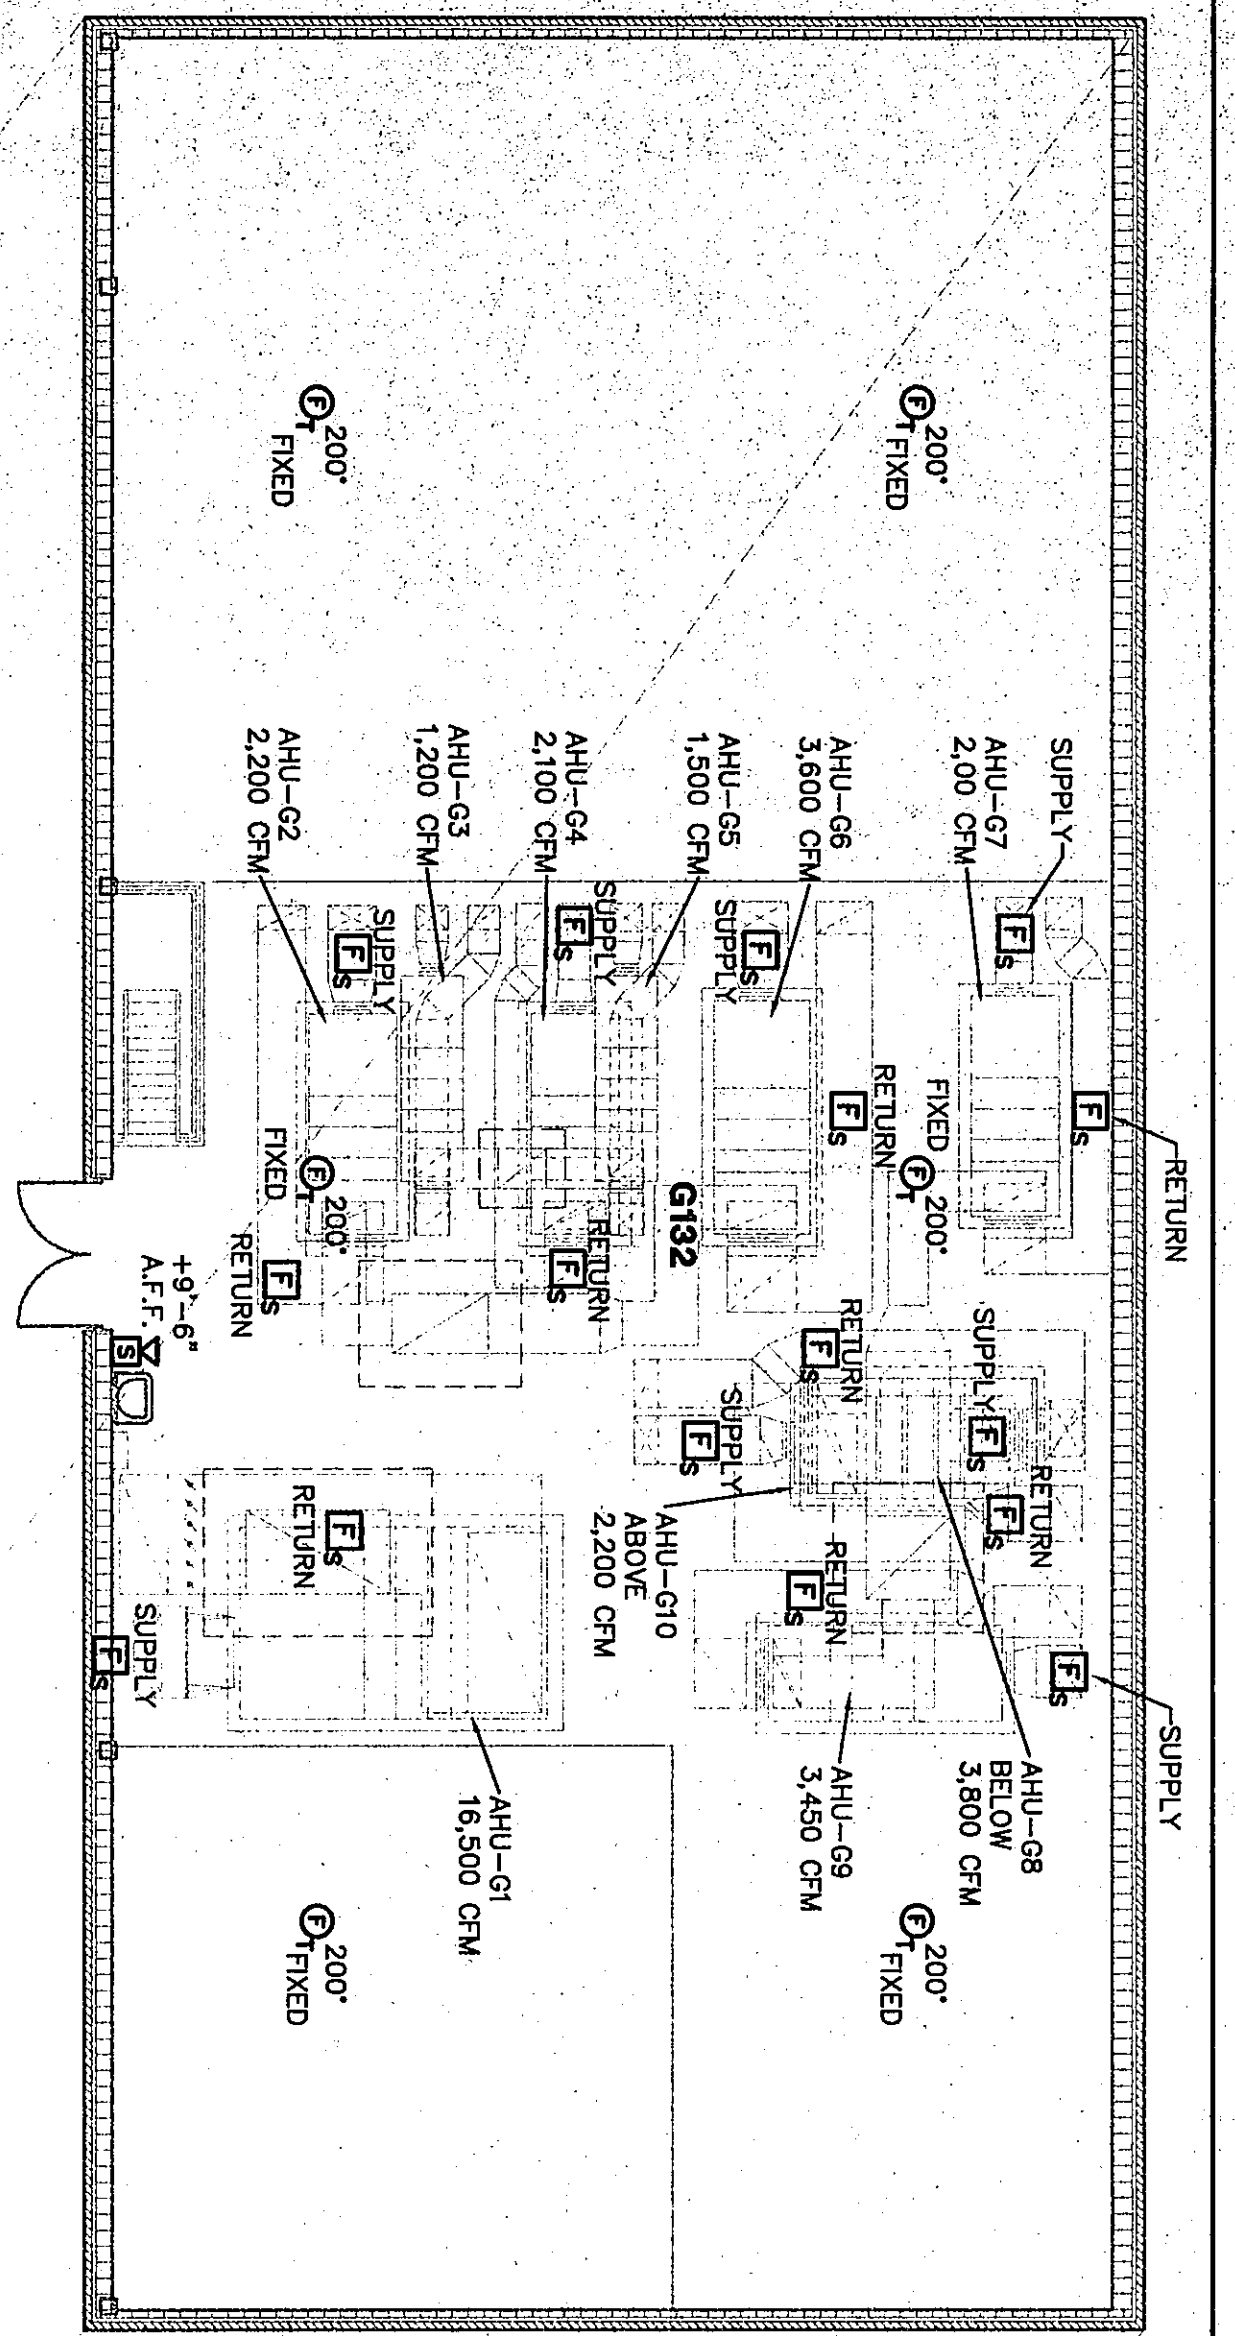

AUXILIARY PLAN MEZZANINE G

SCALE 1/8" = 1'-0"

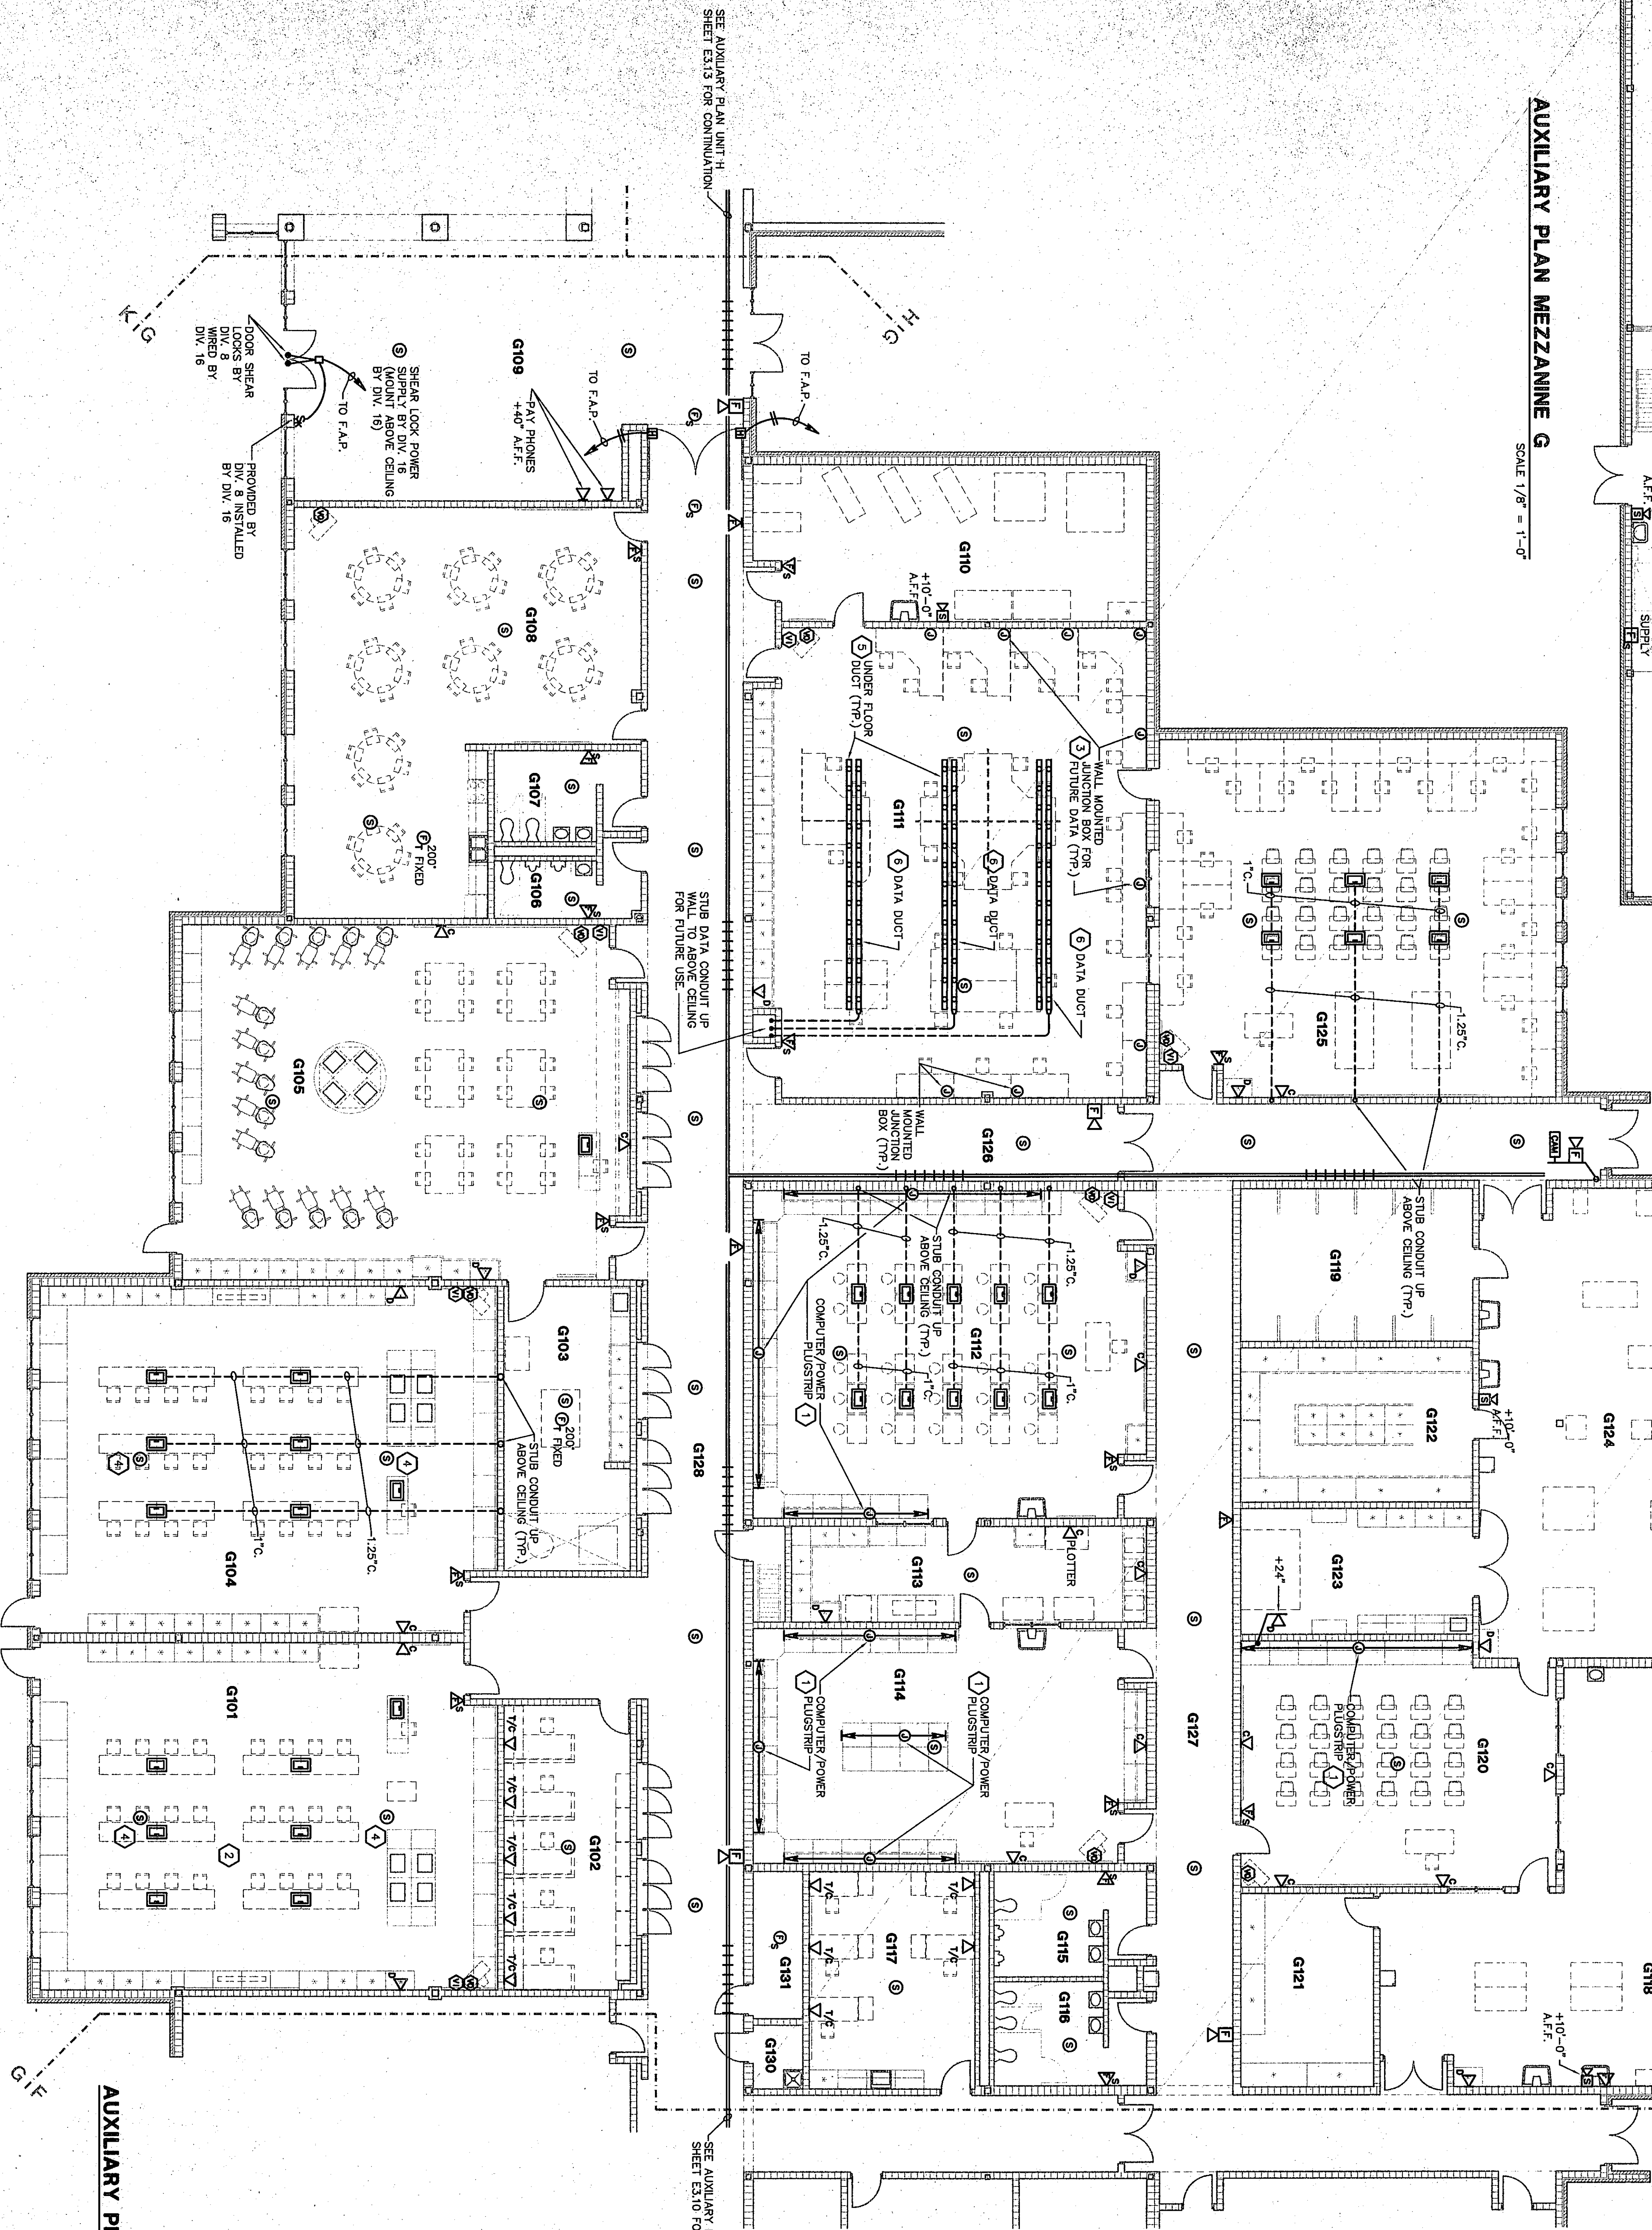

AUXILIARY PLAN UNIT G


SCALE 1/8" = 1'-0"

ROOM LEGEND "G1"			
ROOM NO.	ROOM NAME	AREA S.F.	CEILING HEIGHT
G101	20'20' LAB	1700	9'-4"
G102	OFFICE ROOM	389	9'-4"
G103	20'20' LAB	1700	9'-4"
G104	20'20' LAB	1700	9'-4"
G105	20'20' LAB	1700	9'-4"
G106	20'20' LAB	1700	9'-4"
G107	20'20' LAB	1700	9'-4"
G108	20'20' LAB	1700	9'-4"
G109	20'20' LAB	1700	9'-4"
G110	20'20' LAB	1700	9'-4"
G111	20'20' LAB	1700	9'-4"
G112	20'20' LAB	1700	9'-4"
G113	20'20' LAB	1700	9'-4"
G114	20'20' LAB	1700	9'-4"
G115	20'20' LAB	1700	9'-4"
G116	20'20' LAB	1700	9'-4"
G117	20'20' LAB	1700	9'-4"
G118	20'20' LAB	1700	9'-4"
G119	20'20' LAB	1700	9'-4"
G120	20'20' LAB	1700	9'-4"
G121	20'20' LAB	1700	9'-4"
G122	20'20' LAB	1700	9'-4"
G123	20'20' LAB	1700	9'-4"
G124	20'20' LAB	1700	9'-4"
G125	20'20' LAB	1700	9'-4"
G126	20'20' LAB	1700	9'-4"
G127	20'20' LAB	1700	9'-4"
G128	20'20' LAB	1700	9'-4"
G129	20'20' LAB	1700	9'-4"
G130	20'20' LAB	1700	9'-4"
G131	20'20' LAB	1700	9'-4"
G132	20'20' LAB	1700	9'-4"
G133	20'20' LAB	1700	9'-4"


FLOOR BOXES ARE SHOWN ON AUXILIARY AND POWER PLANS

PLAN NOTES:

1. COMPUTER/POWER PLUG STRIP IS ALSO SHOWN ON E3.12 SEE DETAIL 5/E/16 AND 2/E/10 FOR ADDITIONAL REQUIREMENTS.
2. REFER TO ROOM G104 FOR TYPICAL DATA CONDUIT ROUTING AND CONDUIT SIZE TO EACH FLOOR BOX.
3. PROVIDE A 3/4" X 3/4" INCH DEEP JUNCTION BOX MOUNTED AT 16 INCHES ABOVE FINISH FLOOR FOR SNAGGING EQUIPMENT. RUN TWO 3/4" INCH CONDUITS UP ABOVE CEILING FOR FUTURE USE.
4. PROVIDE A SPEAKER WITH A SURFACE MOUNTED ENCLOSURE MOUNTED AT 11'-0" ABOVE FINISH FLOOR.
5. PROVIDE FLOOR DUCT FOR POWER AND DATA. REFER TO DETAIL 5/E/111 FOR ADDITIONAL REQUIREMENTS.
6. FOR EACH DATA DUCT PROVIDE A WIRE ADAPTER WATER NOSE. 222-1/2 INCH. AND 1/2 INCH CONDUIT FROM DATA DUCT TO ABOVE CEILING PER DRAWINGS.

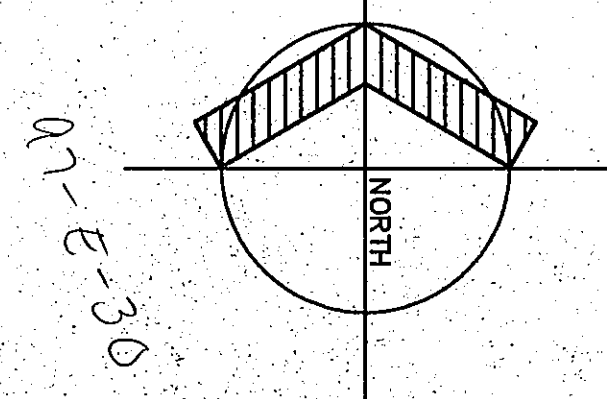

Fanning/Howey Associates, Inc.
Architects Engineers Consultants

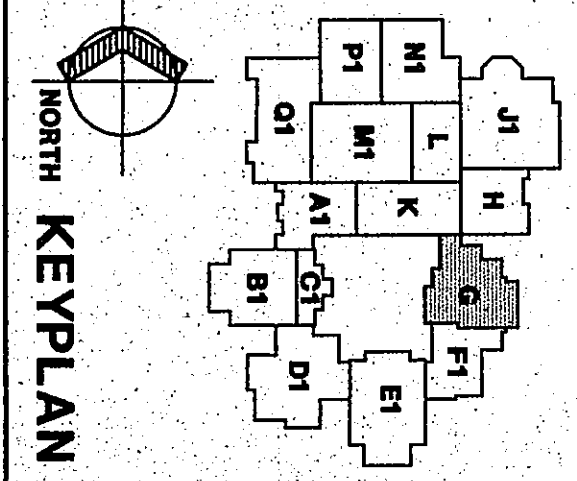

THE NEW
CHESTERTON HIGH SCHOOL
FOR THE
DUNELAND SCHOOL CORPORATION
CHESTERTON, INDIANA

Copyright 1997 by Fanning/Howey Associates, Inc.

AUXILIARY PLAN UNIT G

DRAWN BY: MRS. COMM. NO.: 95067.00
CHECKED BY: WEH DATE: APRIL 21, 1997

E3.12

REVISIONS NO. DATE