
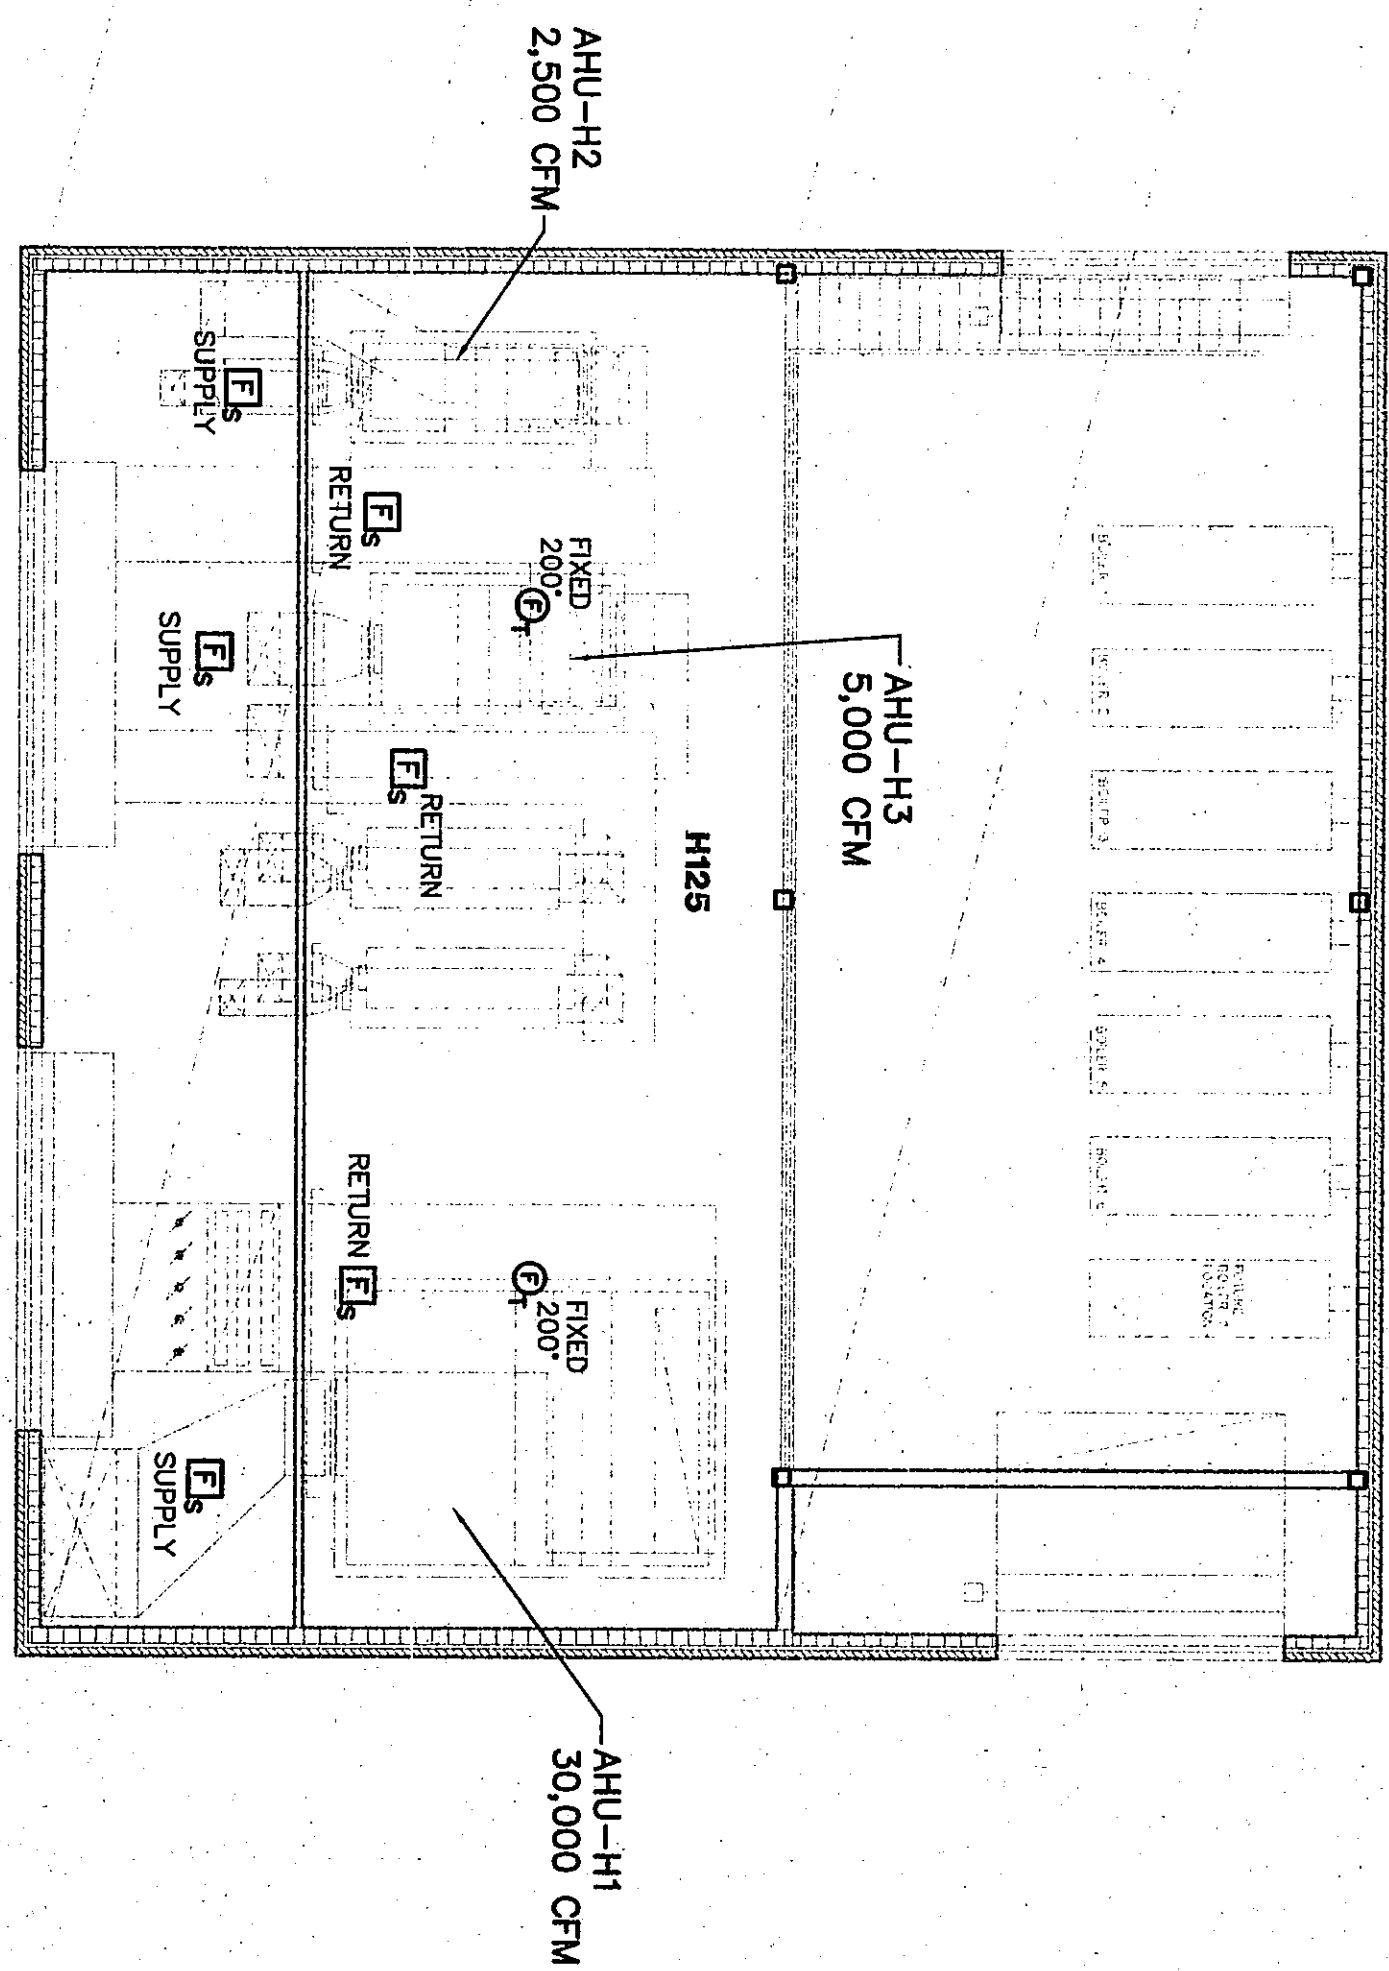


| ROOM NO. | ROOM NAME | AREA S.F. | CEILING HEIGHT |
|----------|-----------|-----------|----------------|
| H101     | COOKING   | 2240      | 10'-0"         |
| H102     | COOKING   | 101       | 9'-4"          |
| H103     | TOILET    | 42        | 9'-4"          |
| H104     | TOILET    | 42        | 9'-4"          |
| H105     | TOILET    | 42        | 9'-4"          |
| H106     | TOILET    | 42        | 9'-4"          |
| H107     | TOILET    | 42        | 9'-4"          |
| H108     | TOILET    | 42        | 9'-4"          |
| H109     | TOILET    | 42        | 9'-4"          |
| H110     | TOILET    | 42        | 9'-4"          |
| H111     | TOILET    | 42        | 9'-4"          |
| H112     | TOILET    | 42        | 9'-4"          |
| H113     | TOILET    | 42        | 9'-4"          |
| H114     | TOILET    | 42        | 9'-4"          |
| H115     | TOILET    | 42        | 9'-4"          |
| H116     | TOILET    | 42        | 9'-4"          |
| H117     | TOILET    | 42        | 9'-4"          |
| H118     | TOILET    | 42        | 9'-4"          |
| H119     | TOILET    | 42        | 9'-4"          |
| H120     | TOILET    | 42        | 9'-4"          |
| H121     | TOILET    | 42        | 9'-4"          |
| H122     | TOILET    | 42        | 9'-4"          |
| H123     | TOILET    | 42        | 9'-4"          |
| H124     | TOILET    | 42        | 9'-4"          |
| H125     | TOILET    | 42        | 9'-4"          |

# ROOM LEGEND "H"

- PLAN NOTES:
- VERIFY EXACT LOCATION OF POST INDICATOR VALVE WITH DIVISION 15.
  - VERIFY EXACT LOCATION OF GAS VALVE WITH DIVISION 15.
  - REFER TO FIRE ALARM RISER DIAGRAM 8/EI.6 FOR FLOW SWITCH AND SUPERVISED VALVE INFORMATION.

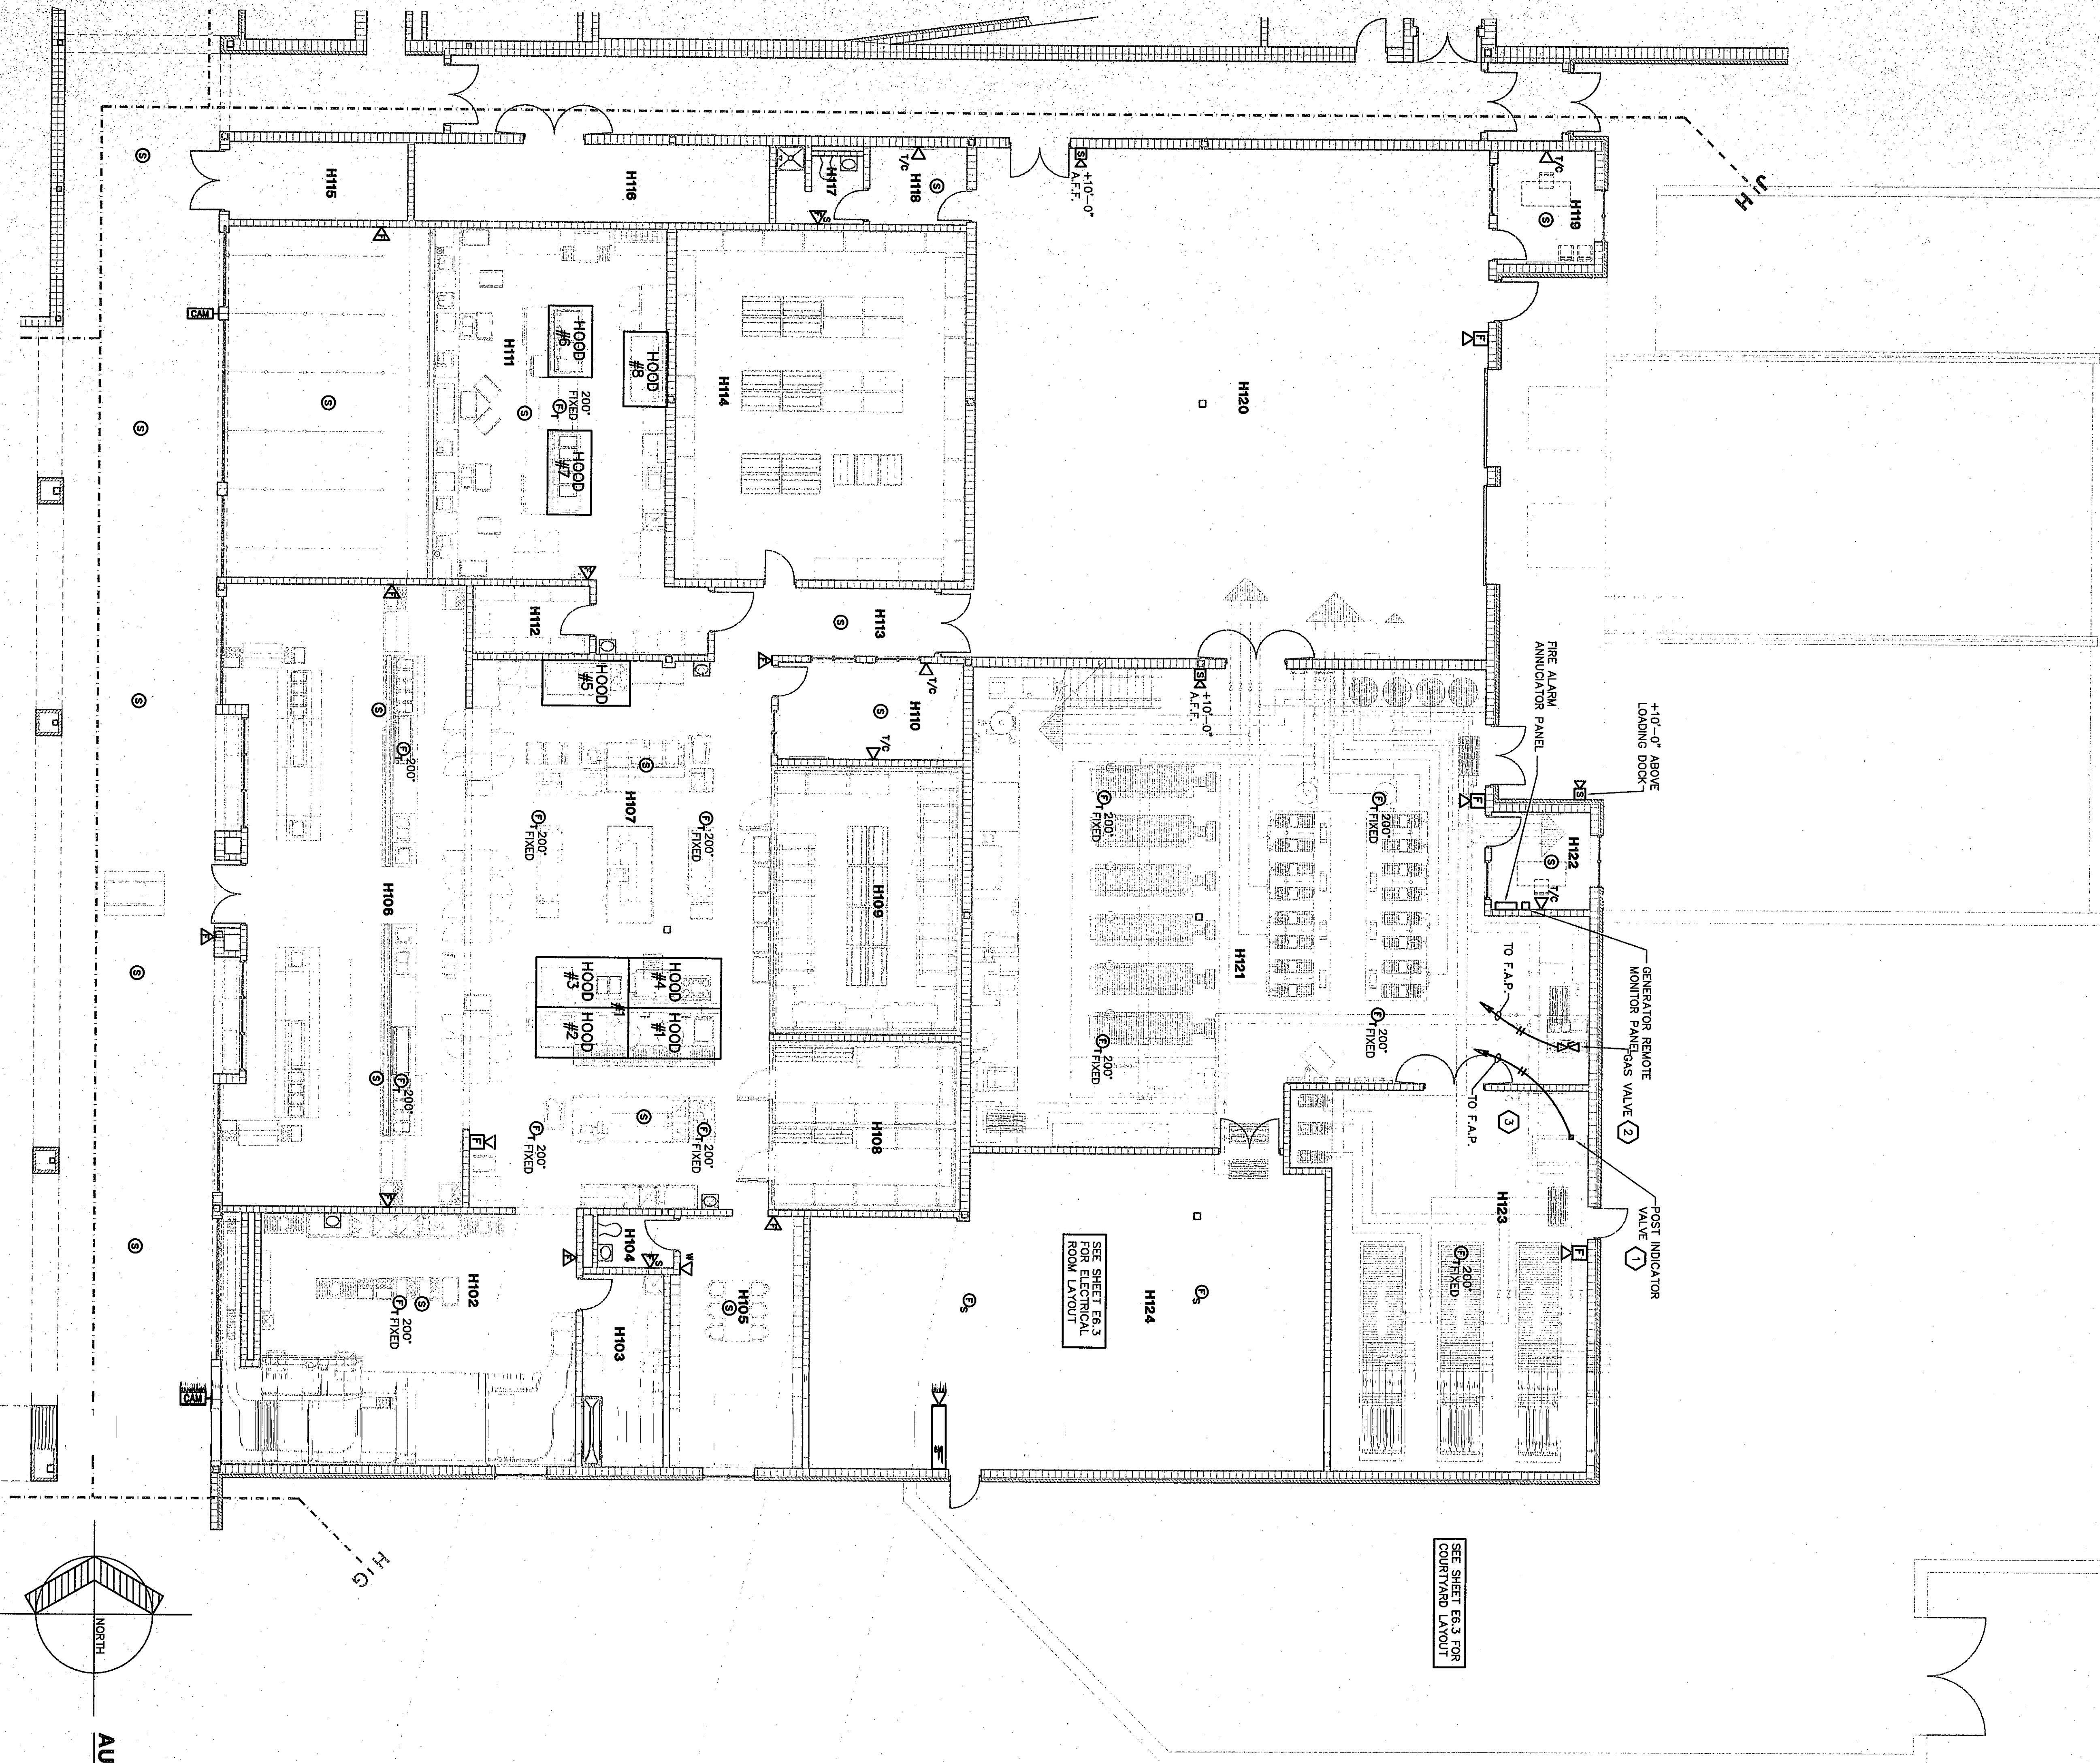


AUXILIARY PLAN MEZZANINE H2

SCALE 1/8" = 1'-0"


AUXILIARY PLAN UNIT H1

SCALE 1/8" = 1'-0"

**Fanning/Howey Associates, Inc.**  
Architects Engineers Consultants

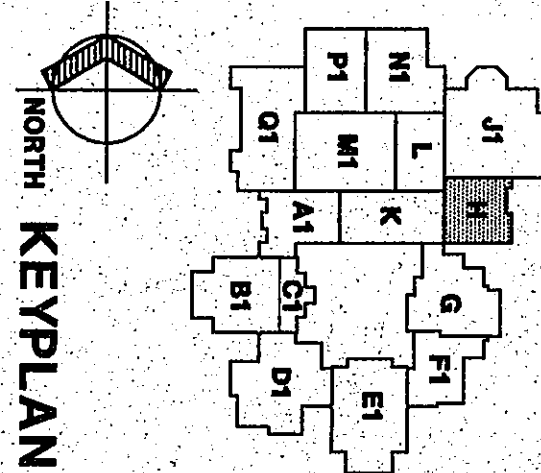

THE NEW  
**CHESTERTON HIGH SCHOOL**  
FOR THE  
DUNELAND SCHOOL CORPORATION  
CHESTERTON, INDIANA

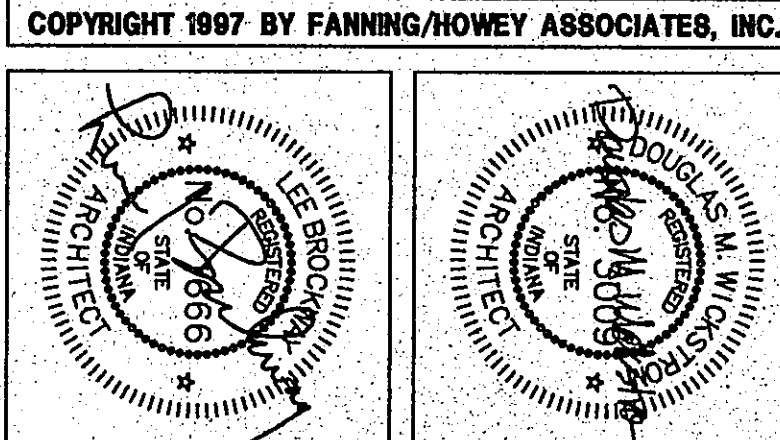

**AUXILIARY PLAN UNIT H1,H2**

DRAWN BY: MRS. COMM. NO.: 95067.00  
CHECKED BY: WBH. DATE: APRIL 21, 1997

**E3.13**

REVISIONS NO. DATE

CHESTERTON HIGH SCHOOL  
35097.00