



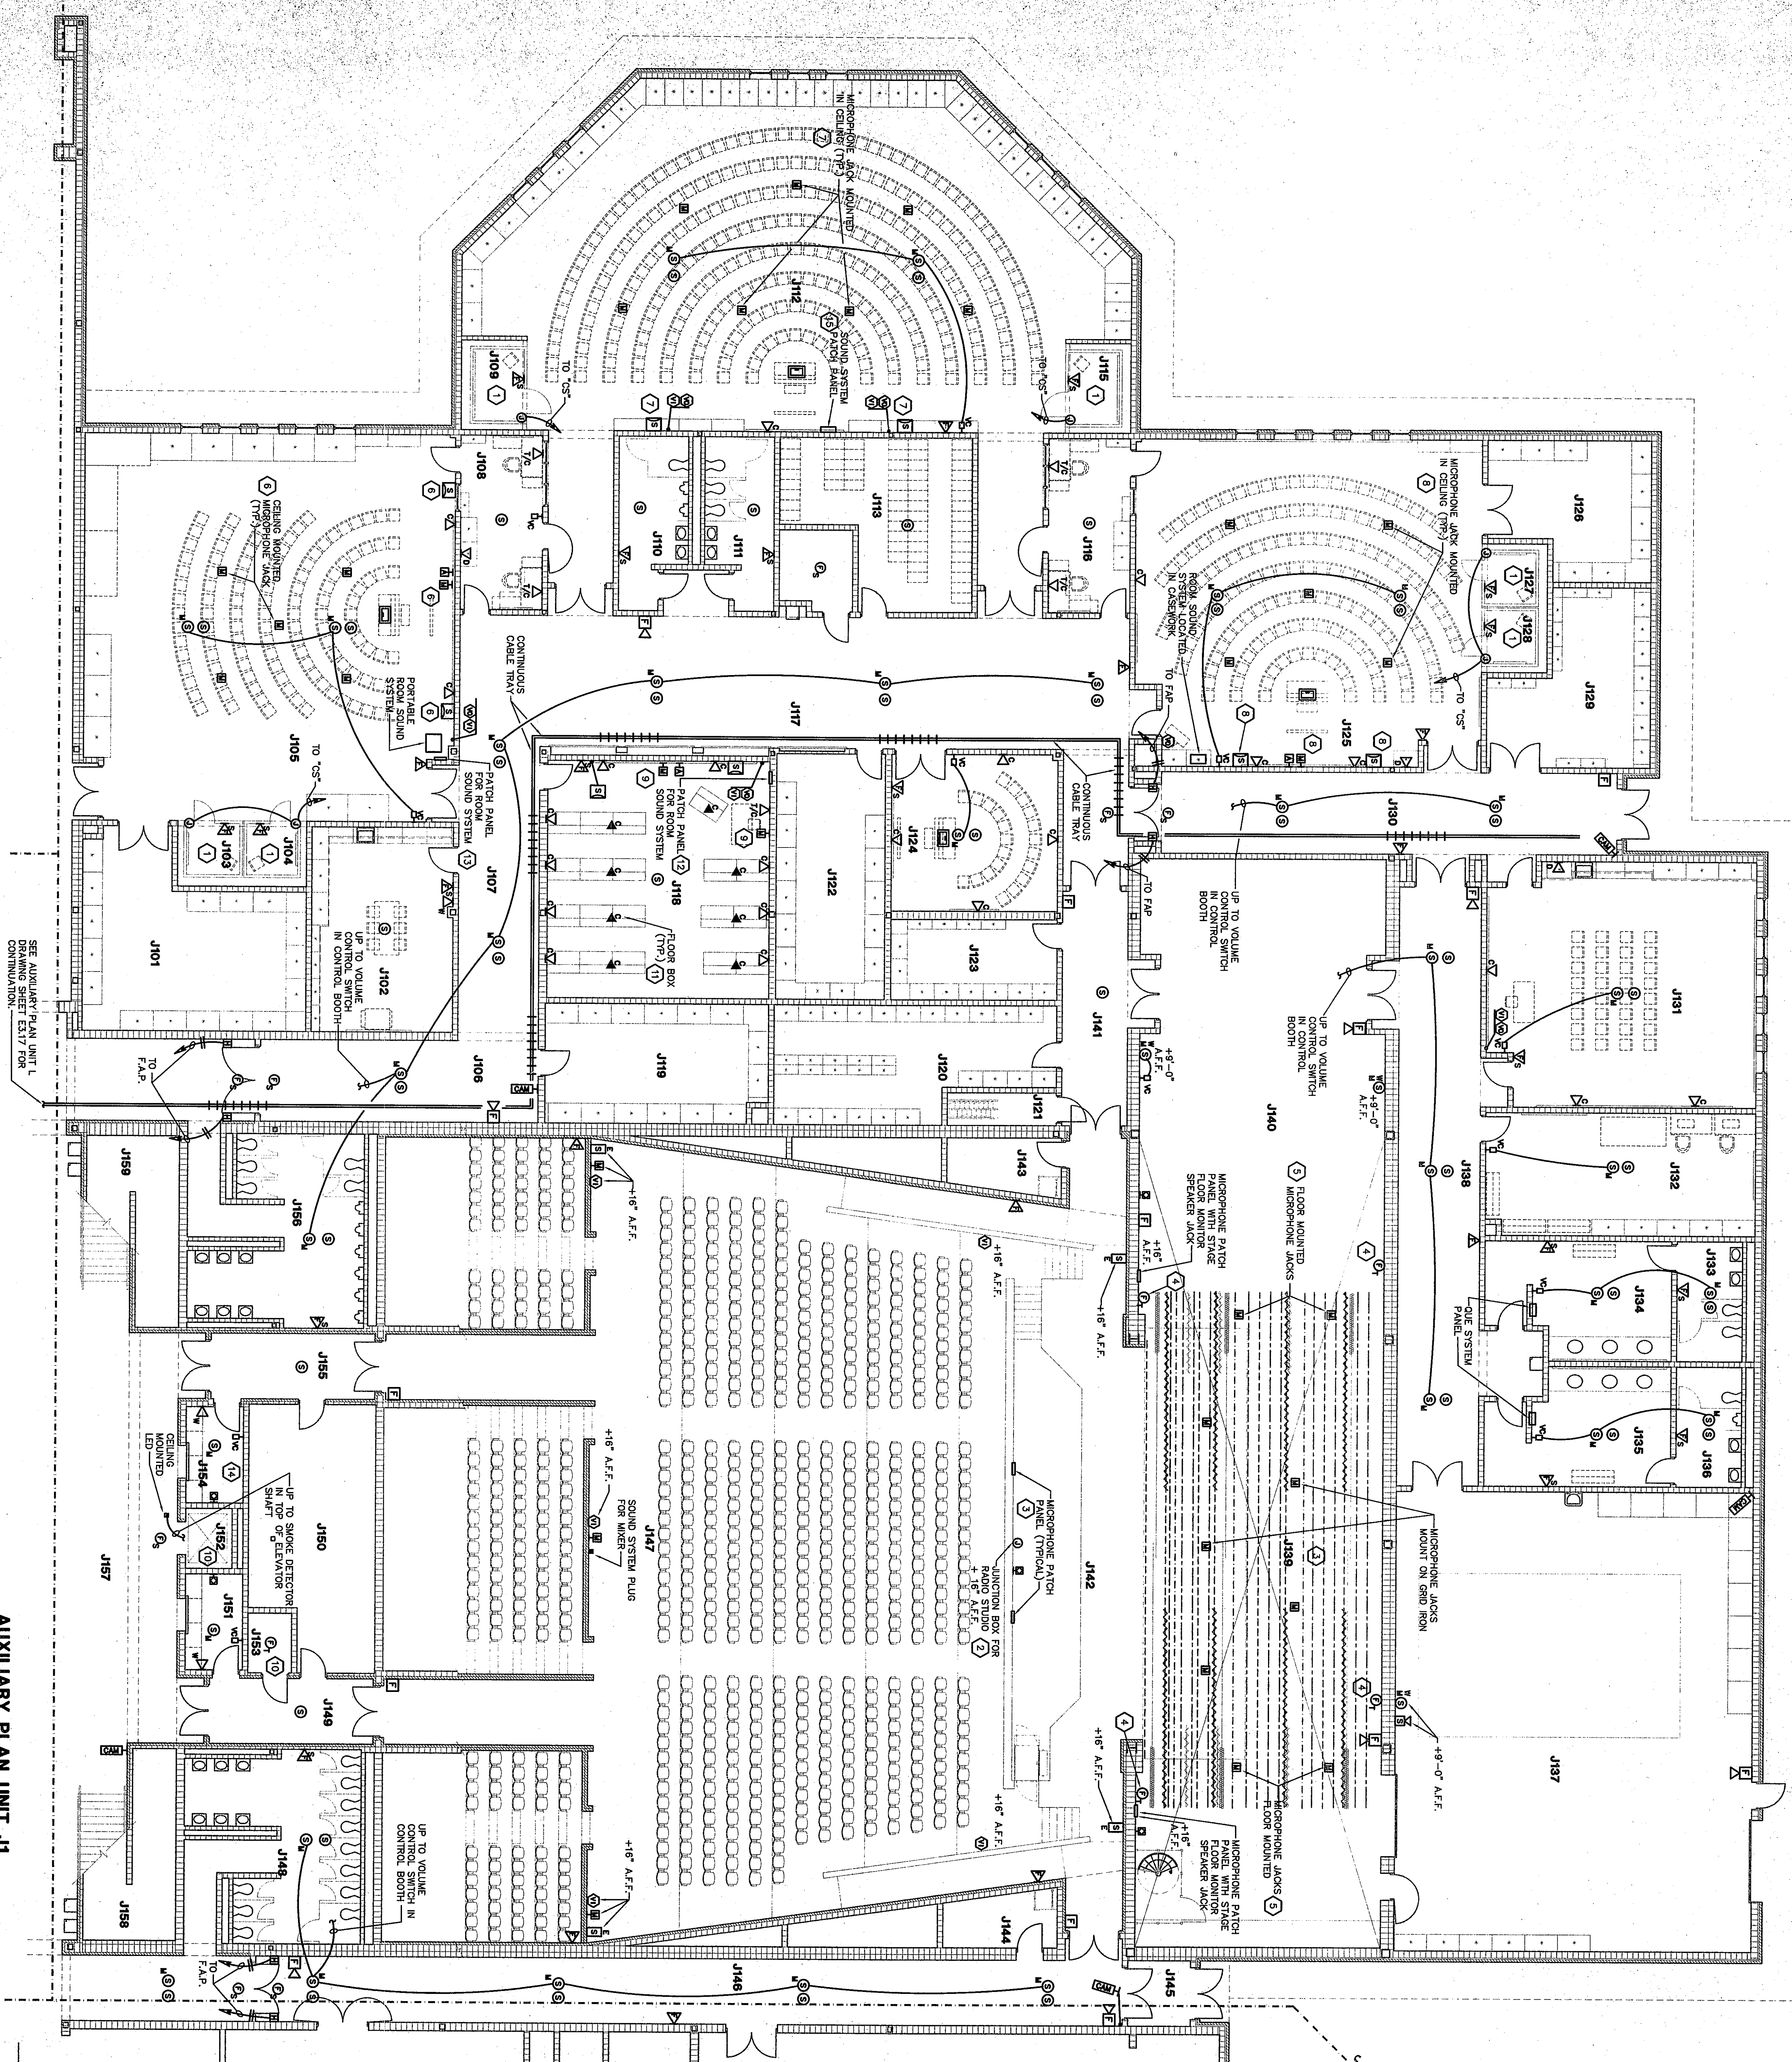

AUXILIARY PLAN UNIT J1

SCALE 1/8" = 1'-0"

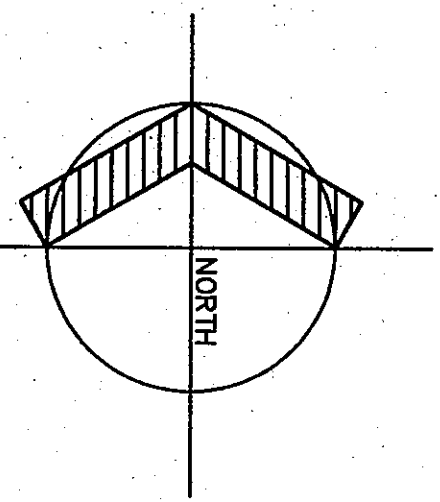

97-E-32

PLAN NOTES:

- 1 PRE-FABRICATED PRACTICE ROOMS WITH SPEAKERS, MICRO-PROCESSORS, CENTRAL SOUND SYSTEM, VENTILATION, AND OTHER SPECIALIZED EQUIPMENT MANUFACTURED.
- 2 PROVIDE A DOUBLE GAGE 3.5" DEEP LANTERN BOX FOR A FLUORESCENT LIGHT STUDO PHONE LINE. RUN A 1" CONDUIT TO ABOVE CEILING OF ROOM 4A17. PROVIDE A TOLL STRING FOR PHONE USE.
- 3 AUDIOBROS AUDIO SOUND SYSTEM. REFER TO DETAIL 6/E1/8 FOR ADDITIONAL INFORMATION.
- 4 MOUNT HET DETECTOR AT 11' -" ABOVE FINISH FLOOR TO DETECT ANY ELECTRICAL CONTACTS. WIRE CONDUITS TO THE CABLES OF THE CONTACTS.
- 5 SQUARE FOUR MICROPHONE JACKS IN A STUPE FLOOR ROCKET FOUR MICROPHONE JACKS IN A STUPE FLOOR MOUNTING PLATE FOR THE MICROPHONE JACKS.
- 6 RUN ALL MICROPHONE JACKS AND SPEAKER JACKS IN ROOM J105 TO SOUND SYSTEM PATCH PANEL IN SAME ROOM.
- 7 RUN ALL MICROPHONE JACKS AND SPEAKER JACKS IN ROOM J112 TO SOUND SYSTEM PATCH PANEL LOCATED IN SAME ROOM.
- 8 RUN ALL MICROPHONE JACKS AND SPEAKER JACKS IN ROOM J125 TO SOUND SYSTEM PATCH PANEL LOCATED IN SAME ROOM.
- 9 RUN ALL MICROPHONE JACKS AND SPEAKER JACKS IN ROOM J131 TO SOUND SYSTEM PATCH PANEL IN SAME ROOM.
- 10 SEE POWER IN AUNT J11. SHEET 55.1.4 FOR ELEVATOR PIT AND ELEVATOR CONTROL ROOM REQUIREMENTS.
- 11 PROVIDE A DOUBLE GAGE FLOOR BOX WITH TELL BARRIER, EQUAL TO HUBBELL B4223 WITH COVERS 53822 AND 53823. PROVIDE A BRASS CARPET FLANGE.
- 12 SOUND SYSTEM PATCH PANEL FOR ROOM J118. REFER TO DETAIL 10/E1/10 FOR ADDITIONAL INFORMATION.
- 13 SOUND SYSTEM PATCH PANEL FOR ROOM J105. REFER TO DETAIL 10/E1/10 FOR ADDITIONAL INFORMATION.
- 14 PROVIDE SPEAKER WITH A SURFACE ENCLOSURE. MOUNT AT 9'-4" ABOVE FINISH FLOOR.
- 15 REFER TO DETAIL 10/E1/10.

AUXILIARY AND POWER PLANS.

AUXILIARY AND POWER PLANS.

ROOM LEGEND "J1"			
ROOM NO.	ROOM NAME	AREA S.F.	CEILING HEIGHT
J101	PRESSURION STORAGE	566	9'-6"
J102	WORKROOM	430	9'-6"
J103	PAINT STORAGE	63	9'-6"
J104	PRACTICE ROOM	63	9'-6"
J105	INSTRUMENT II	208	WARS
J106	OFFICE	213	9'-6"
J107	CORRIDOR	160	9'-6"
J108	BOYS TOILET	160	9'-6"
J109	BOYS TOILET	160	9'-6"
J110	BOYS TOILET	160	9'-6"
J111	BOYS TOILET	160	9'-6"
J112	LIBRARY	305	9'-6"
J113	LIBRARY	305	9'-6"
J114	ELECTRICAL ROOM	85	9'-6"
J115	OFFICE	213	9'-6"
J116	OFFICE	213	9'-6"
J117	CORRIDOR	1404	10'-0"
J118	CORRIDOR	1404	10'-0"
J119	UNIFORM STORAGE	390	9'-6"
J120	EQUIPMENT STORAGE	443	9'-6"
J121	EQUIPMENT STORAGE	443	9'-6"
J122	ROLL-UP/ROLL GUARD	40	9'-6"
J123	BAND BOOSTER STORAGE	200	9'-6"
J124	ENSEMBLE CHAIRS	200	WARS
J125	ENSEMBLE CHAIRS	107	9'-6"
J126	PRACTICE ROOM	304	9'-6"
J127	PRACTICE ROOM	63	9'-6"
J128	STORAGE	63	9'-6"
J129	CORRIDOR	347	10'-0"
J130	CORRIDOR	650	10'-0"
J131	COSTUME STORAGE	491	9'-6"
J132	COSTUME STORAGE	491	9'-6"
J133	TOILET PRESSING ROOM	177	9'-6"
J134	BOYS PRESSING ROOM	298	9'-6"
J135	BOYS PRESSING ROOM	298	9'-6"
J136	TOILET	174	10'-0"
J137	TOILET	174	10'-0"
J138	CORRIDOR	639	10'-0"
J139	STAGE PROP.	2948	10'-0"
J140	PASSAGE	253	9'-6"
J141	PASSAGE	253	9'-6"
J142	ORCHESTRA PIT	655	WARS
J143	STORAGE	80	9'-6"
J144	STORAGE	80	9'-6"
J145	VESTIBULE	80	9'-6"
J146	ADDITION	6789	WARS
J147	WALKWAY TOILET	465	9'-6"
J148	STORAGE	465	9'-6"
J149	STORAGE	465	9'-6"
J150	TICKET SALES	82	9'-6"
J151	TICKET SALES	82	9'-6"
J152	ELVATOR EQUIP. ROOM	42	9'-6"
J153	TICKET SALES	82	9'-6"
J154	TICKET SALES	82	9'-6"
J155	VESTIBULE	161	9'-6"
J156	VESTIBULE	161	9'-6"
J157	LOBBY	1223	10'-0"
J158	STAIR	226	10'-0"
J159	STAIR	226	10'-0"

ROOM LEGEND "J1"


ROOM LEGEND "J1"

AUXILIARY PLAN UNIT J1


DRAWN BY: MRS **COMM. NO.:** 95067.00
CHECKED BY: WBH **DATE:** APRIL 21, 1997

E3.14

REVISIONS	NO.	DATE
-----------	-----	------

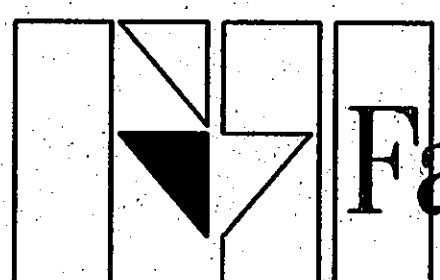

**Fanning/Howey
Associates, Inc.**
Architects Engineers Consultants

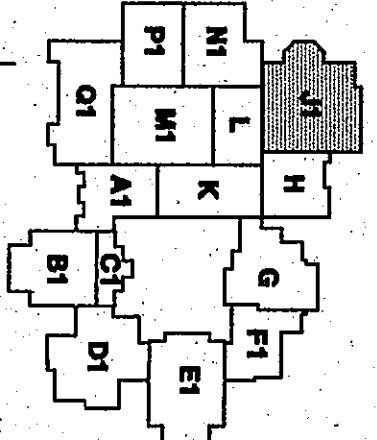

THE NEW
CHESTERTON HIGH SCHOOL
FOR THE
DUNELAND SCHOOL CORPORATION
CHESTERTON, INDIANA

COPYRIGHT 1997 BY FANNING/HOWEY ASSOCIATES, INC.

