



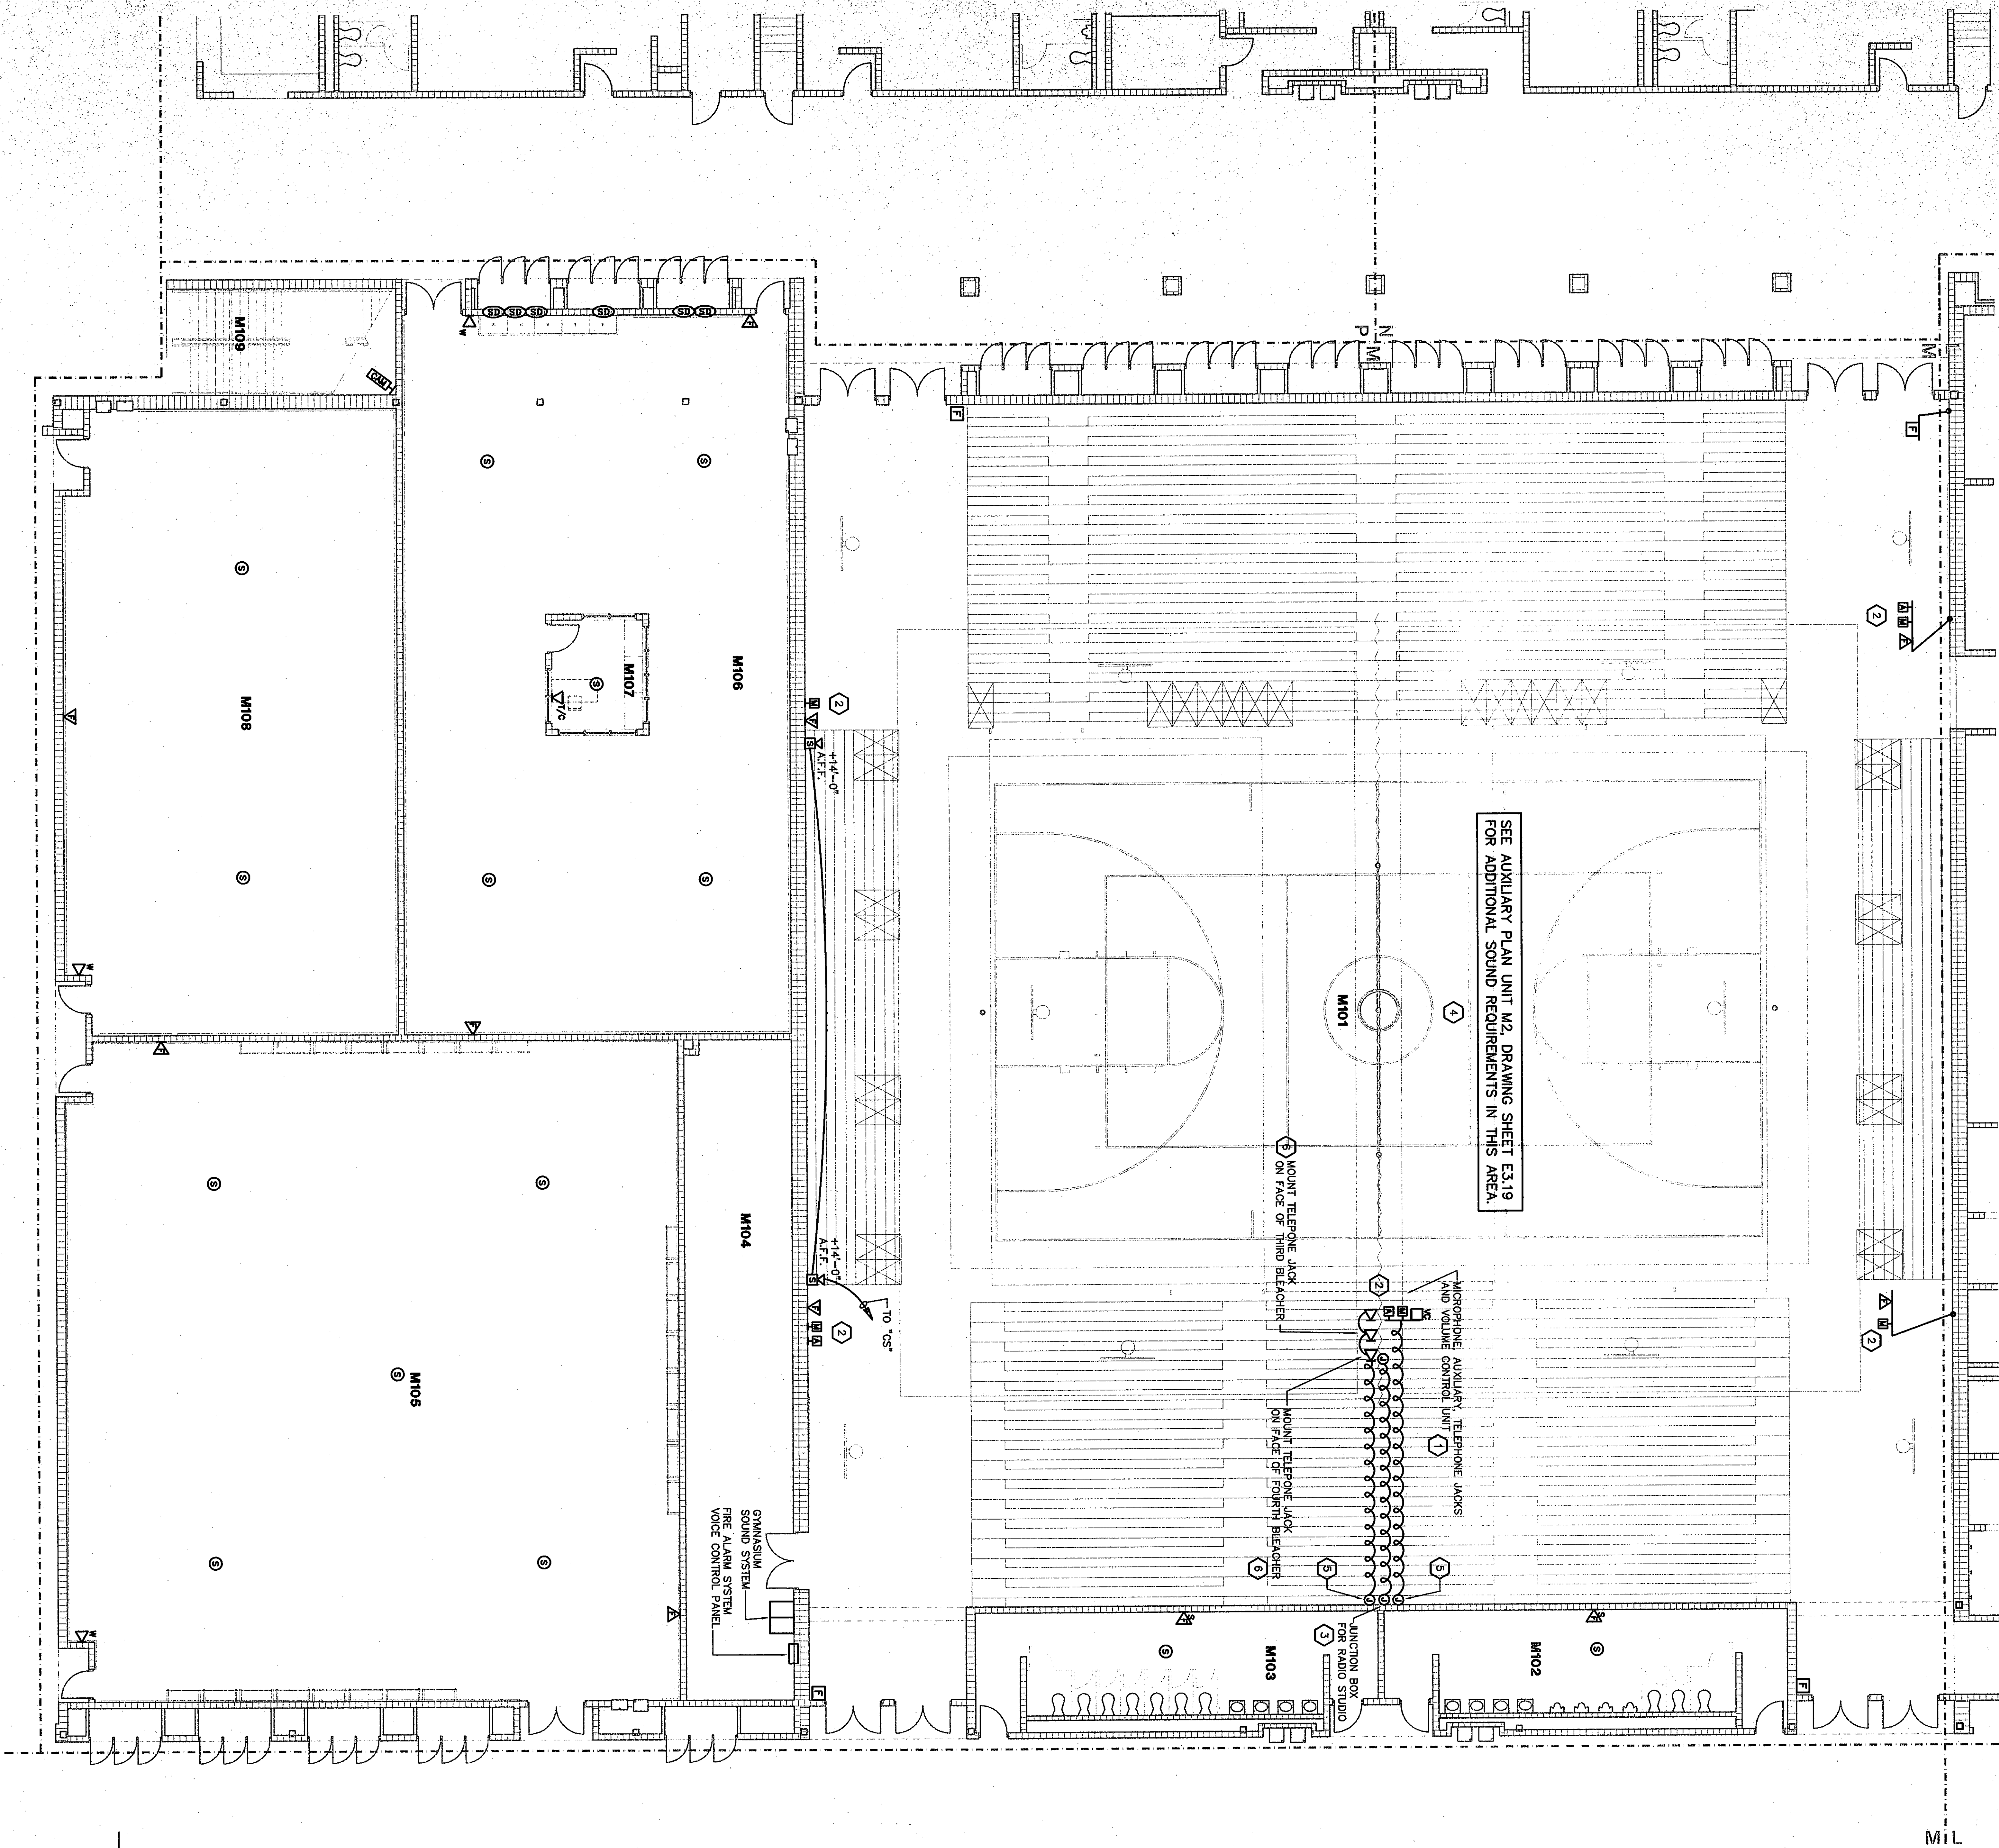

ROOM LEGEND "M1"			
ROOM NO.	ROOM NAME	AREA S.F.	CEILING HEIGHT
M101	GYMNASIUM	17064	9'-4"
M102	MEN'S TOILET	482	9'-4"
M103	WOMEN'S TOILET	482	9'-4"
M104	STORAGE	857	10'-0"
M105	WESTINGHOUSE	4833	10'-0"
M106	OFFICE	120	9'-4"
M107	OFFICE	120	9'-4"
M108	OFFICE	2475	10'-0"
M109	STAIR	247	10'-0"

PLAN NOTES:

1. EQUIPMENT JACKS MOUNTED ON THE FACE OF SECOND BLEACHER. SEE DETAILS 4/E/1.9 AND 5/E/1.9.
2. WIRE EACH MICROPHONE AND AUXILIARY JACK TO THE GYM SOUND SYSTEM.
3. PROVIDE A DOUBLE GANG 3.5 INCHES DEEP JUNCTION BOX FOR A FUTURE RADIO STUDIO PHONE LINE. RUN A 1 INCH CONDUIT TO ABOVE CEILING OF ROOM A217. PROVIDE A PULL STRING FOR FUTURE USE.
4. GYMNASIUM SOUND SYSTEM. REFER TO DETAIL 5/E/1.8 TO ADDITIONAL INFORMATION.
5. REFER TO DETAIL 6/E/1.9 FOR ADDITIONAL INFORMATION.
6. REFER TO DETAIL 4/E/1.9 AND 5/E/1.9 FOR PRESS AREA REQUIREMENTS ON FLOOR PLAN AND TYP.

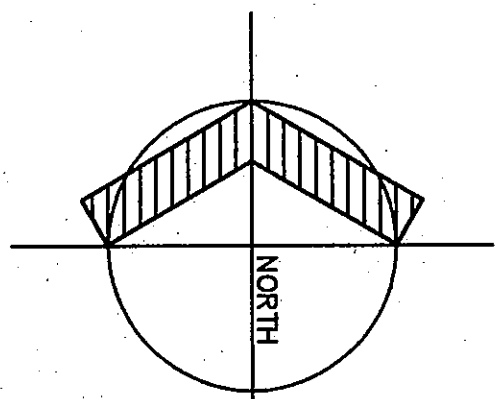


AUXILIARY PLAN UNIT M1

SCALE 1/8" = 1'-0"

01-6-36

AUXILIARY PLAN UNIT M1	
DRAWN BY: MRS. WGB	COMM. NO.: 95067.00
CHECKED BY: WGB	DATE: APRIL 21, 1997
E3.18	
REVISIONS NO. DATE	

Fanning/Howey Associates, Inc.
Architects Engineers Consultants

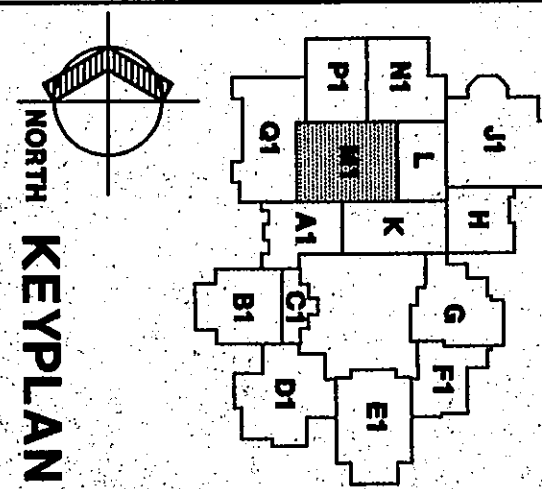

THE NEW
CHESTERTON HIGH SCHOOL
FOR THE
DUNELAND SCHOOL CORPORATION
CHESTERTON, INDIANA

COPYRIGHT 1997 BY FANNING/HOWEY ASSOCIATES, INC.