



AUXILIARY PLAN GYMNASIUMS AREA
(ALTERNATE BID)

SCALE 1/8" = 1'-0"

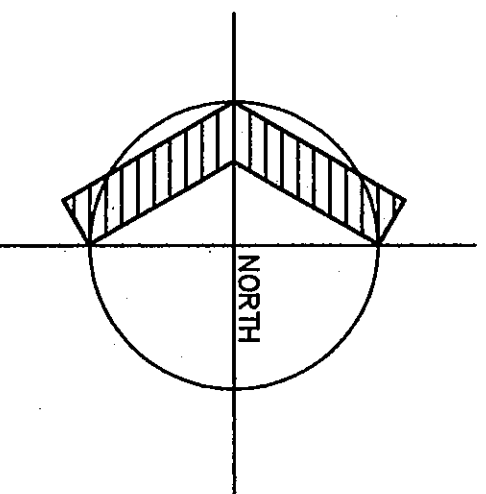

AUXILIARY PLAN UNIT N1

SCALE 1/8" = 1'-0"

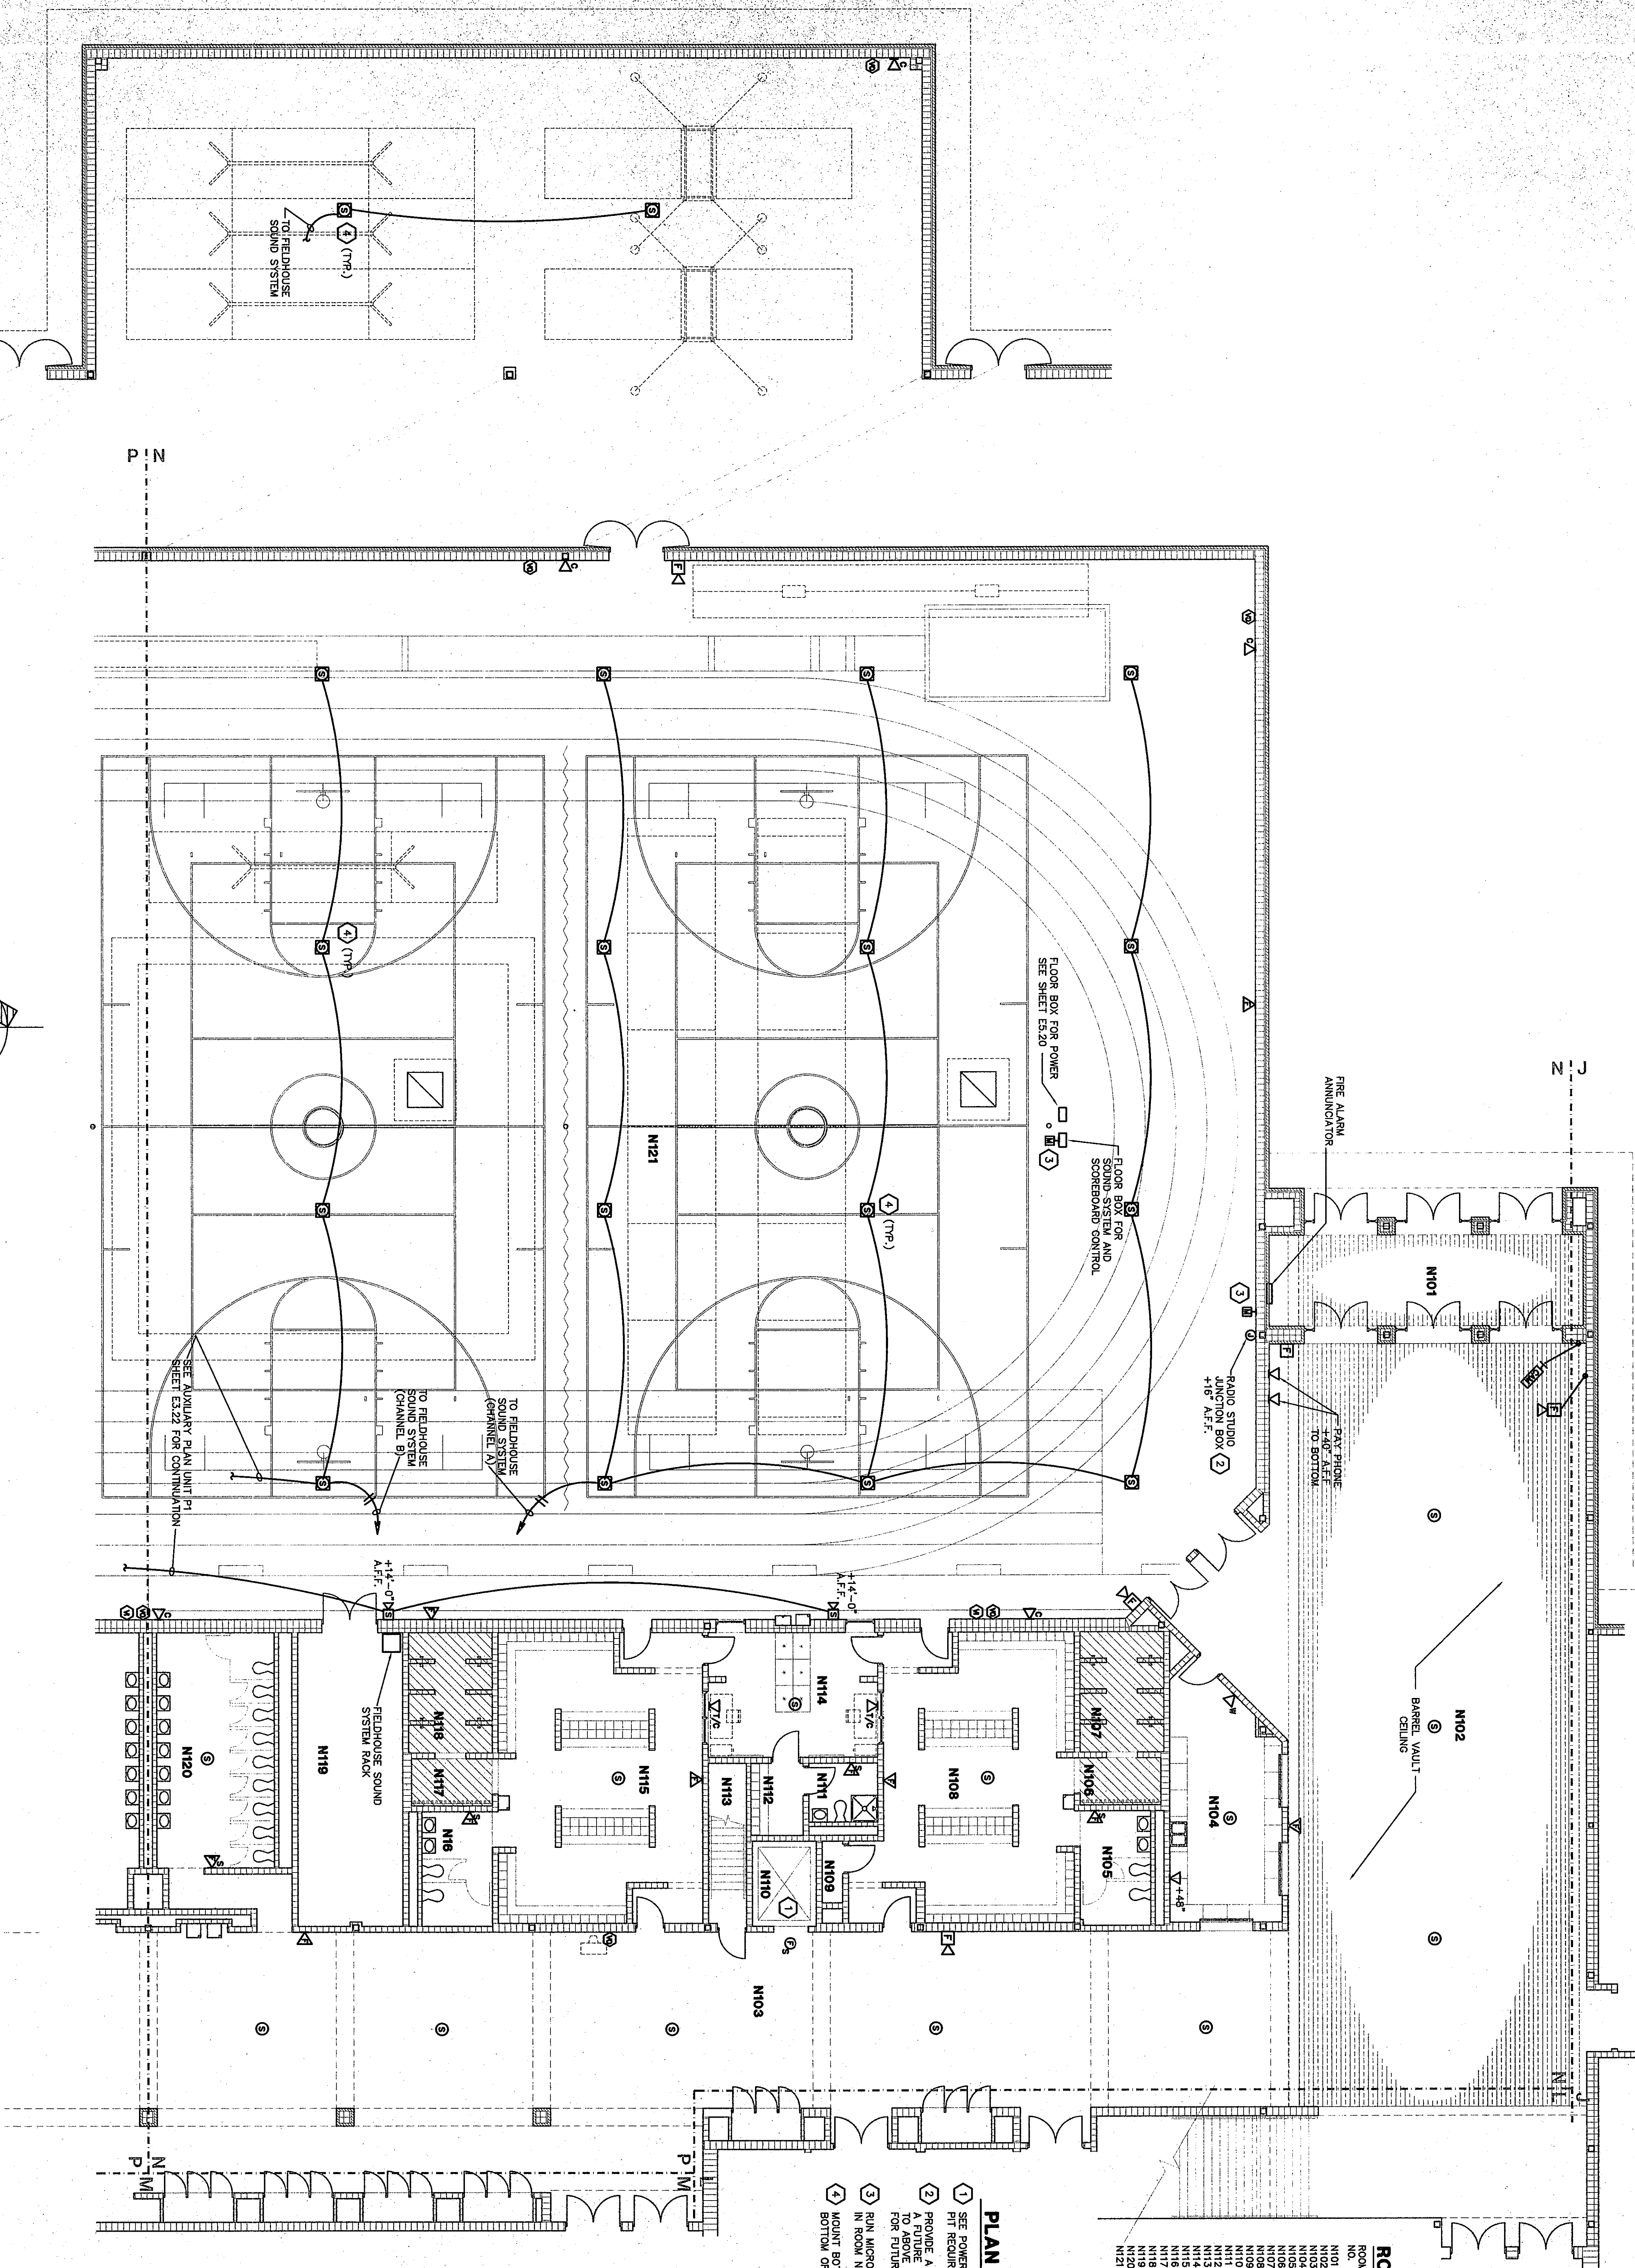

PLAN NOTES:


1. SEE POWER PLAN UNIT P1, SHEET E3.20 FOR ELEVATOR PIT REQUIREMENTS.
2. PROVIDE A DOUBLE GANG 3.5 INCH DEEP JUNCTION BOX FOR A FUTURE RADIO STUDIO PHONE LINE. RUN A 1 INCH CONDUIT TO ABOVE CEILING OF ROOM A217. PROVIDE A PULL STRING FOR FUTURE USE.
3. RUN MICROPHONE TO FIELDHOUSE SOUND SYSTEM RACK IN ROOM N119.
4. MOUNT BOTTOM OF SPEAKER AT THE SAME HEIGHT AS THE BOTTOM OF STRUCTURAL STEEL.

ROOM LEGEND "N1"

ROOM NO.	ROOM NAME	AREA S.F.	CEILING HEIGHT
N101	VESTIBULE	397	10'-0"
N102	CORRIDOR	355	10'-0"
N103	CONCESSION STAND	337	9'-4"
N104	TOILET	40	9'-4"
N105	TOILET	40	9'-4"
N106	SHOWER	130	9'-4"
N107	SHOWER	130	9'-4"
N108	SHOWER	130	9'-4"
N109	SHOWER	130	9'-4"
N110	SHOWER	130	9'-4"
N111	SHOWER	130	9'-4"
N112	SHOWER	130	9'-4"
N113	SHOWER	130	9'-4"
N114	SHOWER	130	9'-4"
N115	SHOWER	130	9'-4"
N116	SHOWER	130	9'-4"
N117	SHOWER	130	9'-4"
N118	SHOWER	130	9'-4"
N119	SHOWER	130	9'-4"
N120	SHOWER	130	9'-4"
N121	SHOWER	130	9'-4"






KEYPLAN

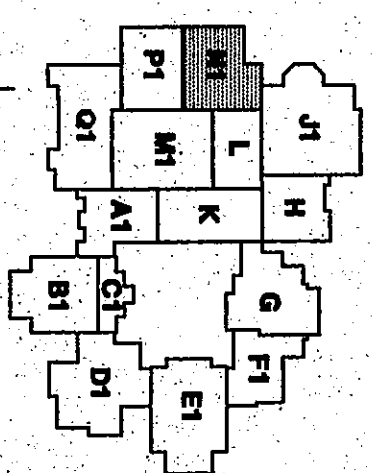

THE NEW
CHESTERTON HIGH SCHOOL
FOR THE
DUNELAND SCHOOL CORPORATION
CHESTERTON, INDIANA

COPYRIGHT 1997 BY FANNING/HOWEY ASSOCIATES, INC.

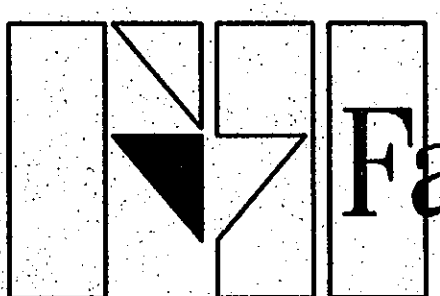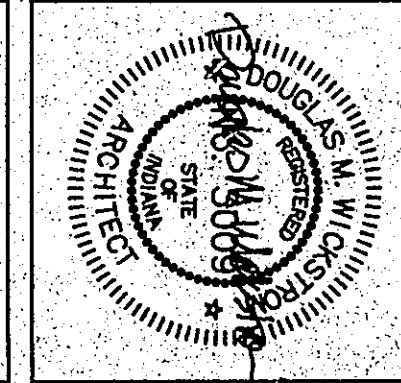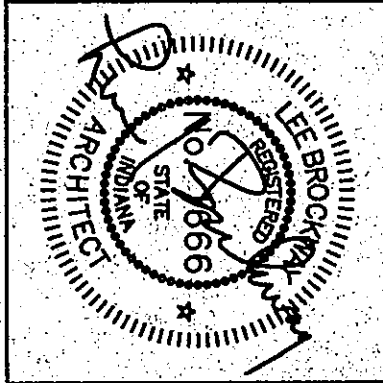

Fanning/Howey
Associates, Inc.
Architects Engineers Consultants

AUXILIARY PLAN UNIT N1

DRAWN BY: MRS. COMM. NO.: 95067.00
CHECKED BY: WBH DATE: APRIL 21, 1997

E3.20

REVISIONS NO. DATE

CHESTERTON HIGH SCHOOL
E3.20 (A)