



1h

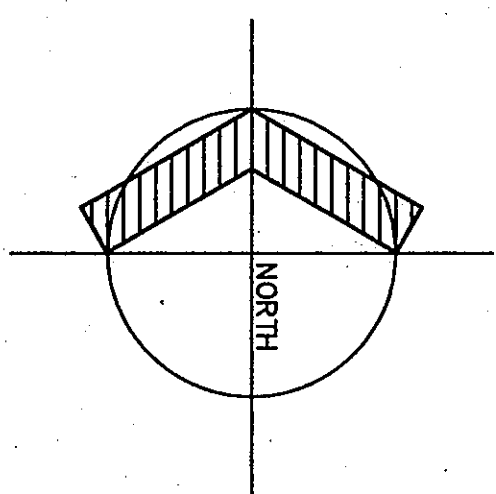

AUXILIARY PLAN UNIT N2

SCALE 1/8" = 1'-0"

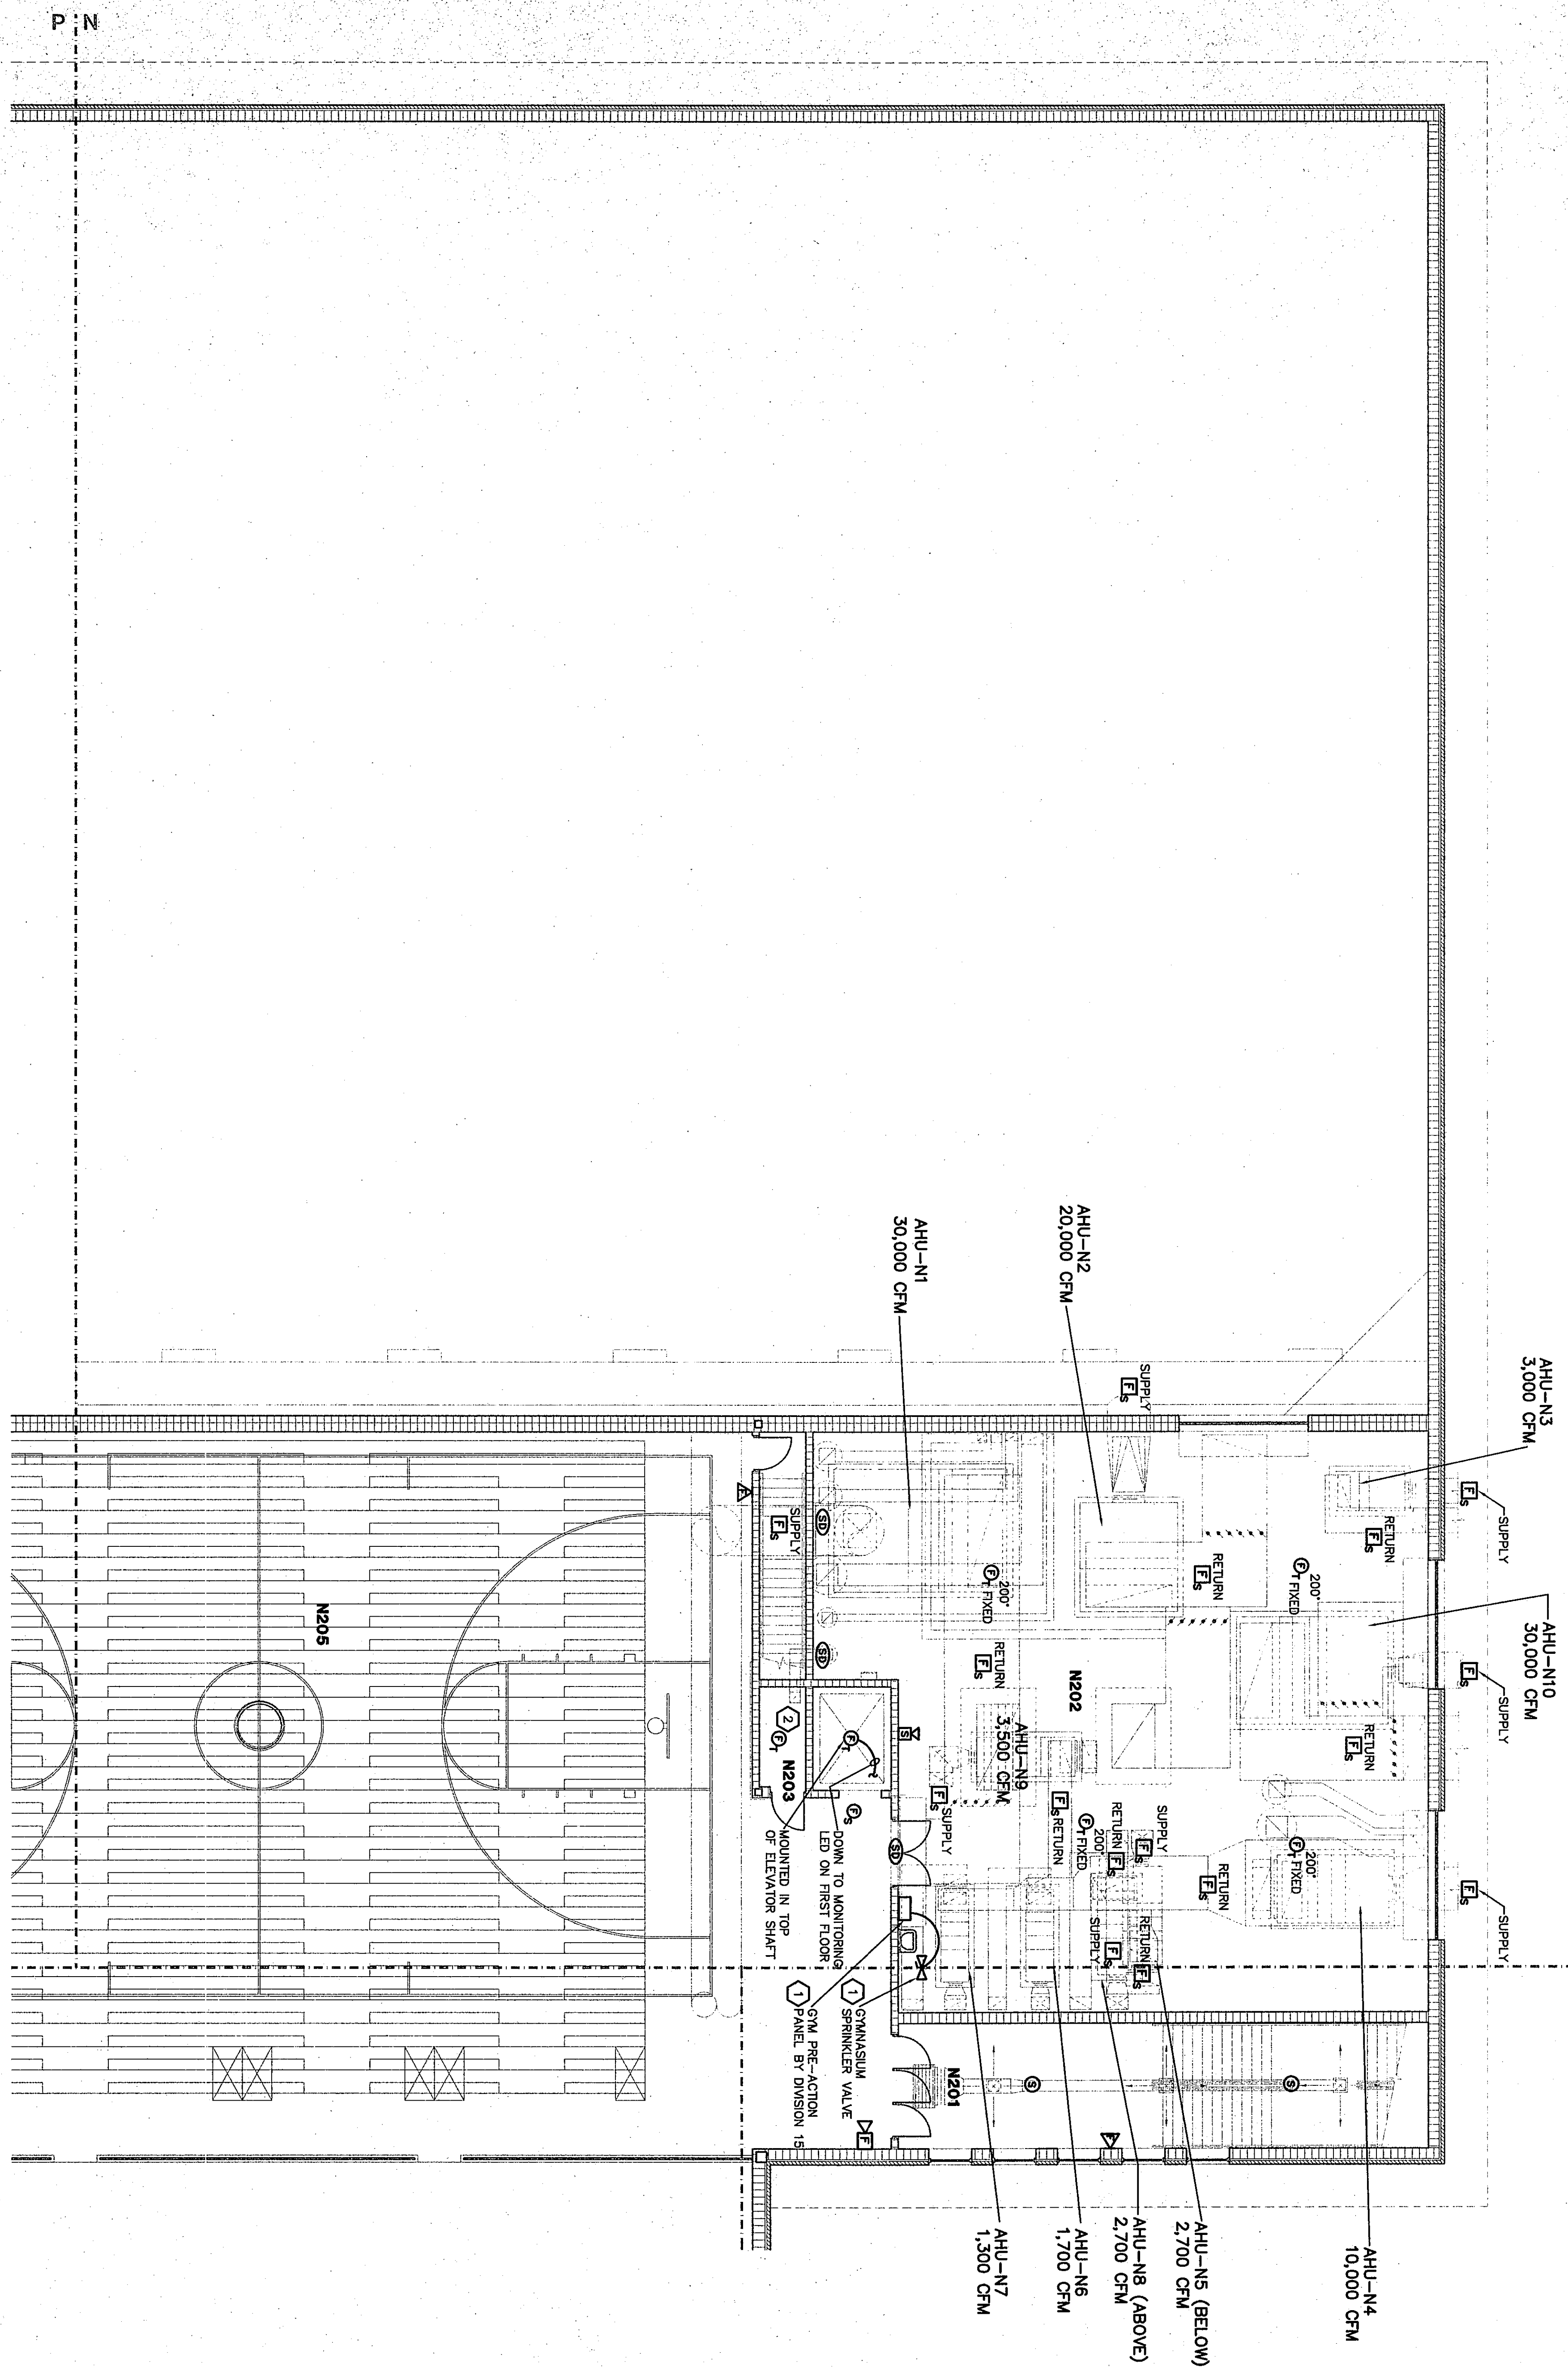

ROOM LEGEND "N2"			
ROOM NO.	ROOM NAME	AREA S.F.	CEILING HEIGHT
N201	STAIR	579	10'-8"
N202	STAIRWELL	279	10'-8"
N203	ELEVATOR EQUIPMENT	37	10'-8"
N204	NOT USED	---	---
N205	BLAUNY COURT	4681	---

- PLAN NOTES:**
- 1. VERIFY EXACT LOCATION OF PRE-ACTION PANEL AND SPRINKLER VALVE WITH DIVISION 15.
 - 2. REFER TO POWER PLAN UNIT N2 SHEET ES.21 FOR ELEVATOR CONTROL ROOM REQUIREMENTS.


01-E-39

AUXILIARY PLAN UNIT N2


DRAWN BY: MRS COMM. NO.: 95067.00
CHECKED BY: WBH DATE: APRIL 21, 1997

E3.21

REVISIONS NO. DATE

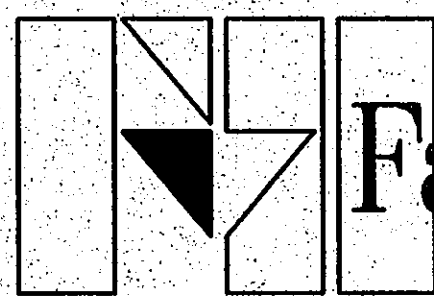

Fanning/Howey Associates, Inc.
Architects Engineers Consultants

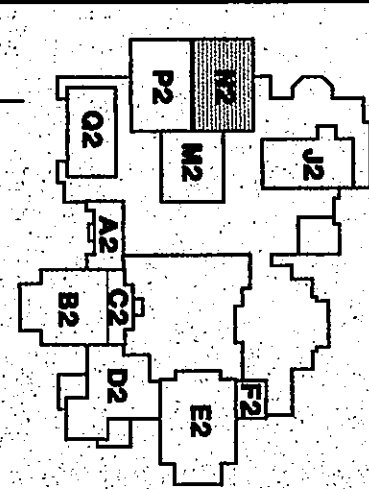

THE NEW
CHESTERTON HIGH SCHOOL
FOR THE
DUNELAND SCHOOL CORPORATION
CHESTERTON, INDIANA

COPYRIGHT 1997 BY FANNING/HOWEY ASSOCIATES, INC.

