


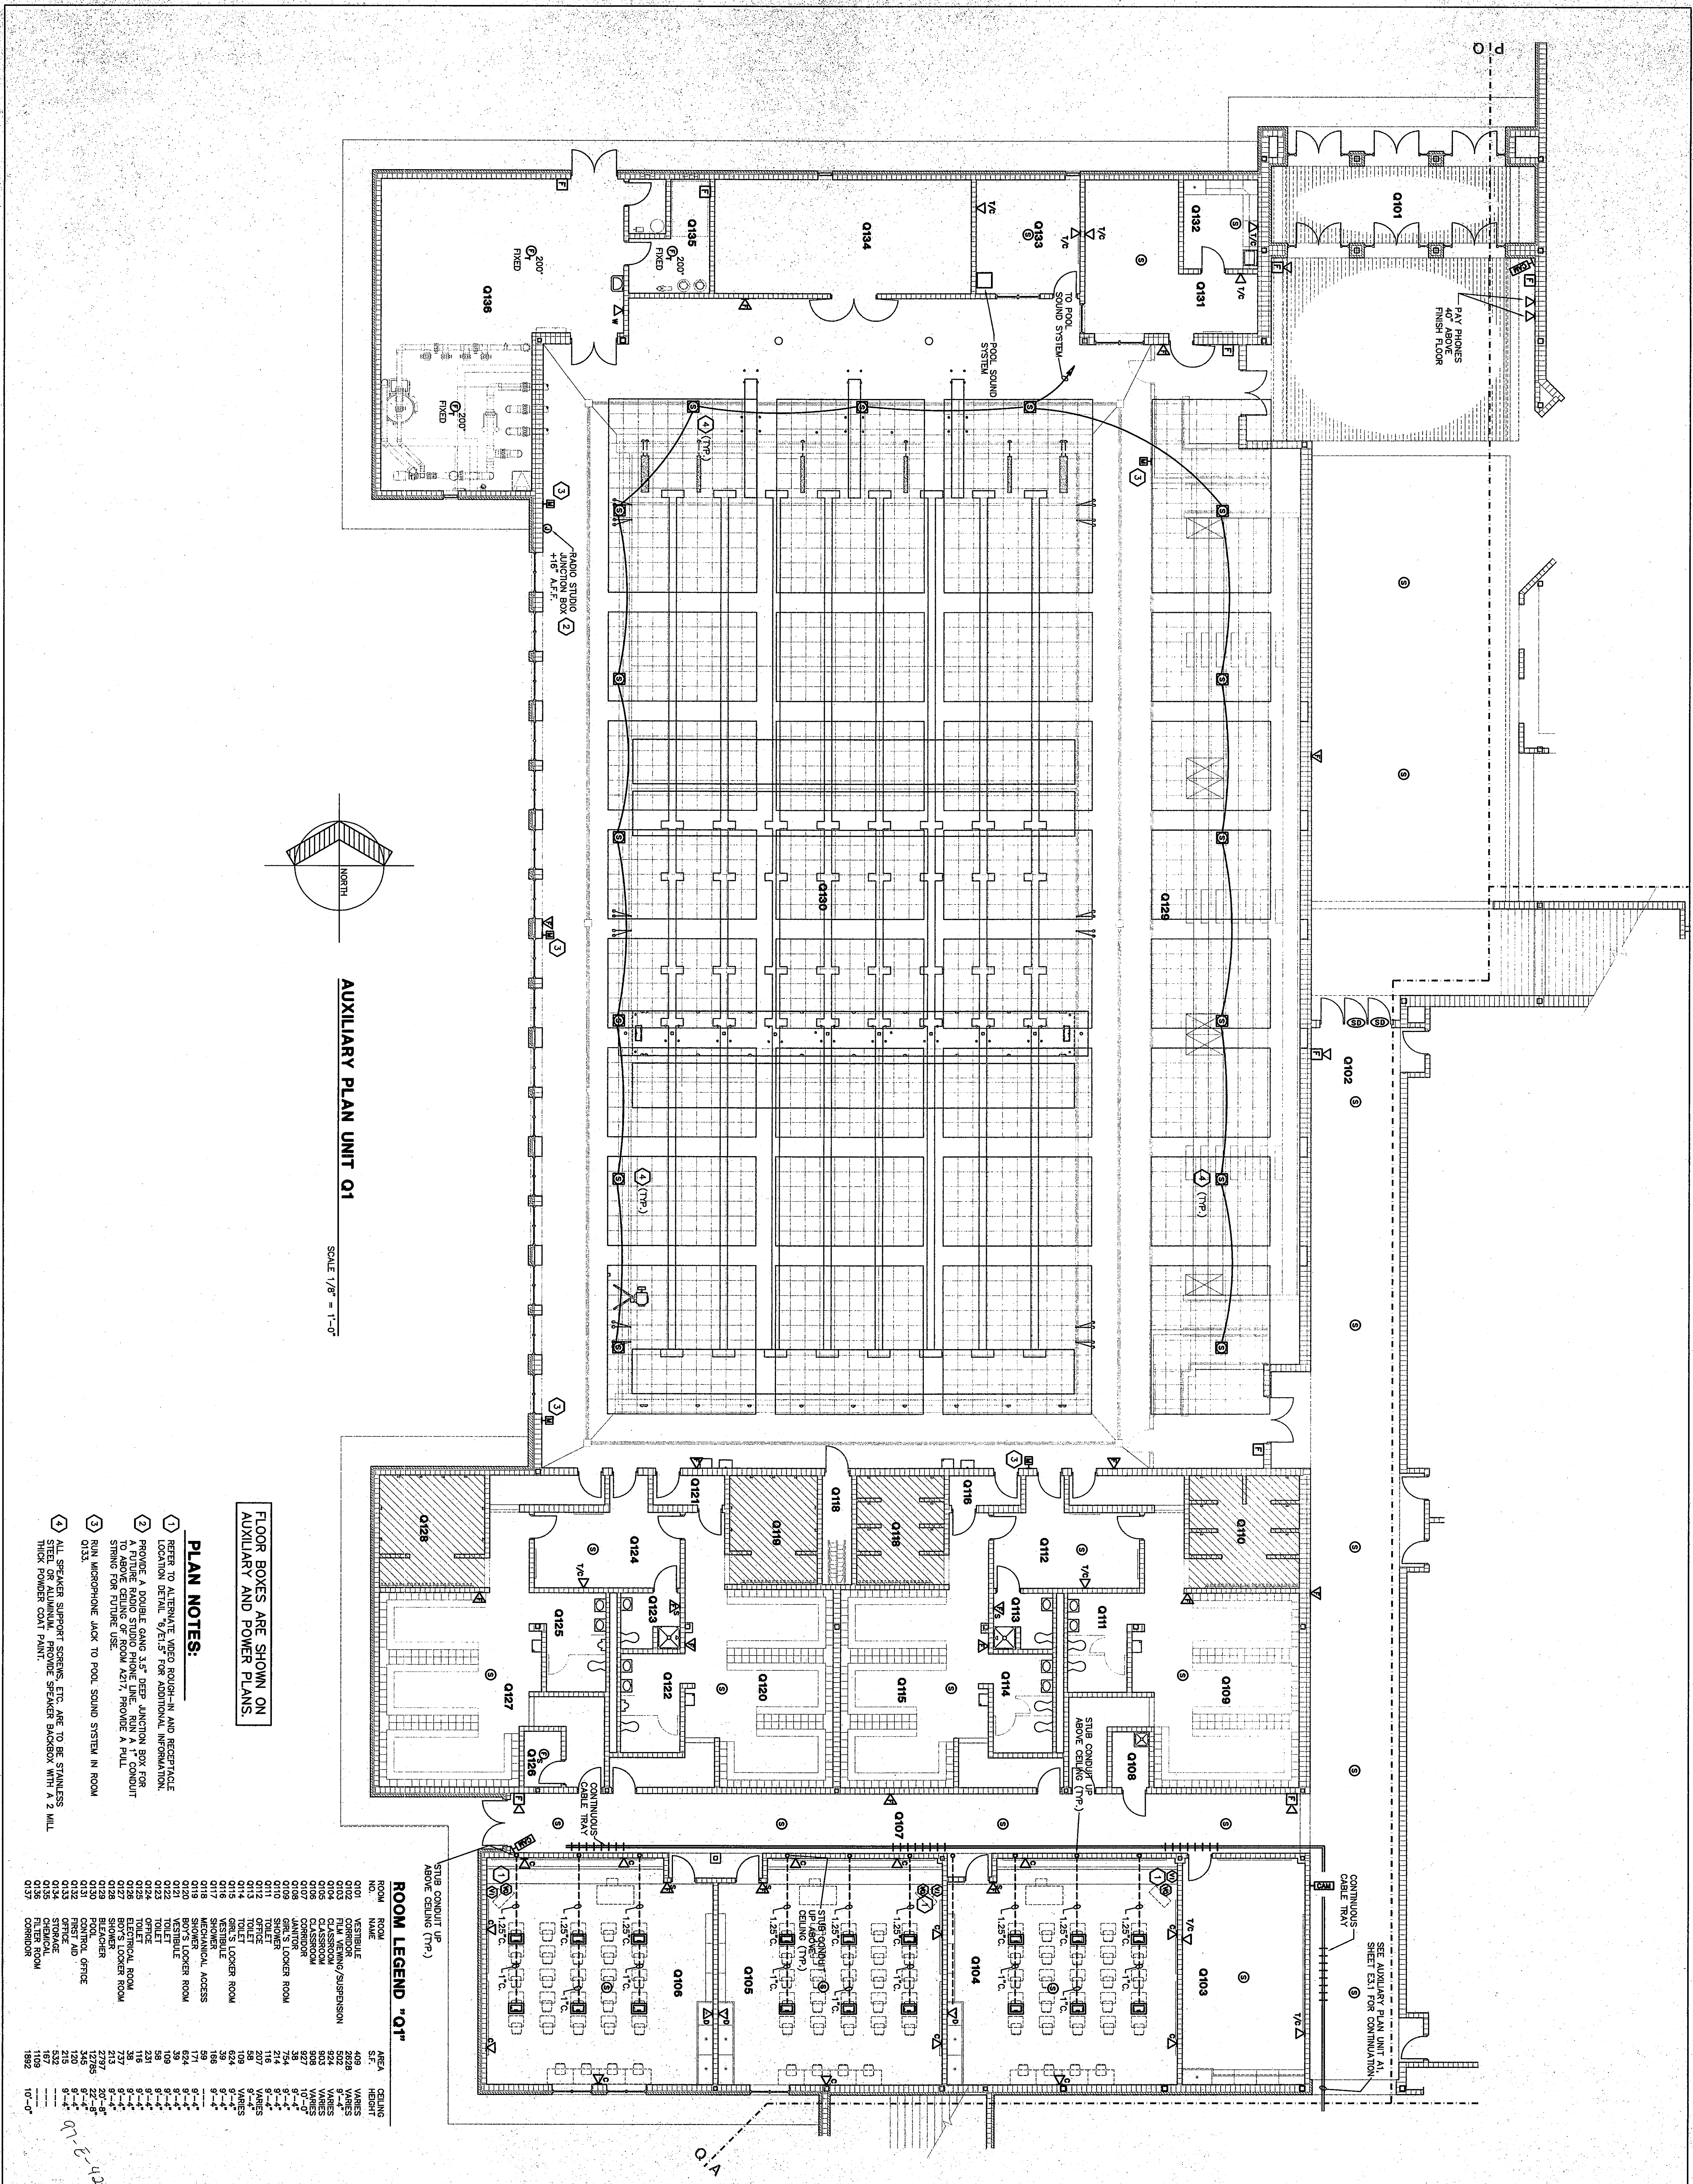

**FLOOR BOXES ARE SHOWN ON  
AUXILIARY AND POWER PLANS.**

**PLAN NOTES:**

1. REFER TO ALTERNATE VIDEO ROOM-IN AND RECEPTACLE LOCATION DETAIL 8/21/97 FOR ADDITIONAL INFORMATION.
2. PROVIDE A DOUBLE GANG 3.5" DEEP JUNCTION BOX FOR A FUTURE RADIO STUDIO PHONE LINE. RUN A 1" CONDUIT STRING FOR FUTURE USE.
3. RUN MICROPHONE JACK TO POOL SOUND SYSTEM IN ROOM Q133.
4. ALL SPEAKER SUPPORT SCREWS, ETC. ARE TO BE STAINLESS STEEL OR ALUMINUM. PROVIDE SPEAKER BACKBOX WITH A 2 MIL THICK POWDER COAT PAINT.

| ROOM LEGEND "Q1" |           |           |
|------------------|-----------|-----------|
| ROOM NO.         | ROOM NAME | AREA S.F. |
| Q101             | VESTIBULE | 469       |
| Q102             | CORRIDOR  | 2628      |
| Q103             | CLASSROOM | 924       |
| Q104             | CLASSROOM | 924       |
| Q105             | CLASSROOM | 924       |
| Q106             | CLASSROOM | 924       |
| Q107             | CLASSROOM | 924       |
| Q108             | CLASSROOM | 924       |
| Q109             | CLASSROOM | 924       |
| Q110             | CLASSROOM | 924       |
| Q111             | CLASSROOM | 924       |
| Q112             | CLASSROOM | 924       |
| Q113             | CLASSROOM | 924       |
| Q114             | CLASSROOM | 924       |
| Q115             | CLASSROOM | 924       |
| Q116             | CLASSROOM | 924       |
| Q117             | CLASSROOM | 924       |
| Q118             | CLASSROOM | 924       |
| Q119             | CLASSROOM | 924       |
| Q120             | CLASSROOM | 924       |
| Q121             | CLASSROOM | 924       |
| Q122             | CLASSROOM | 924       |
| Q123             | CLASSROOM | 924       |
| Q124             | CLASSROOM | 924       |
| Q125             | CLASSROOM | 924       |
| Q126             | CLASSROOM | 924       |
| Q127             | CLASSROOM | 924       |
| Q128             | CLASSROOM | 924       |
| Q129             | CLASSROOM | 924       |
| Q130             | CLASSROOM | 924       |
| Q131             | CLASSROOM | 924       |
| Q132             | CLASSROOM | 924       |
| Q133             | CLASSROOM | 924       |
| Q134             | CLASSROOM | 924       |
| Q135             | CLASSROOM | 924       |

**AUXILIARY PLAN UNIT Q1**

DRAWN BY: MRS COMM. NO.: 95067.00  
CHECKED BY: WBH DATE: APRIL 21, 1997

**E3.24**

**Fanning/Howey Associates, Inc.**  
Architects Engineers Consultants

**THE NEW CHESTERTON HIGH SCHOOL FOR THE DUNELAND SCHOOL CORPORATION CHESTERTON, INDIANA**

COPYRIGHT 1997 BY FANNING/HOWEY ASSOCIATES, INC.