



74

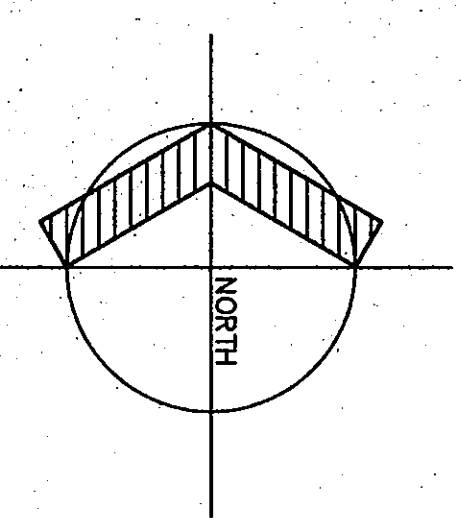

LIGHTING PLAN UNIT A1

SCALE 1/8" = 1'-0"

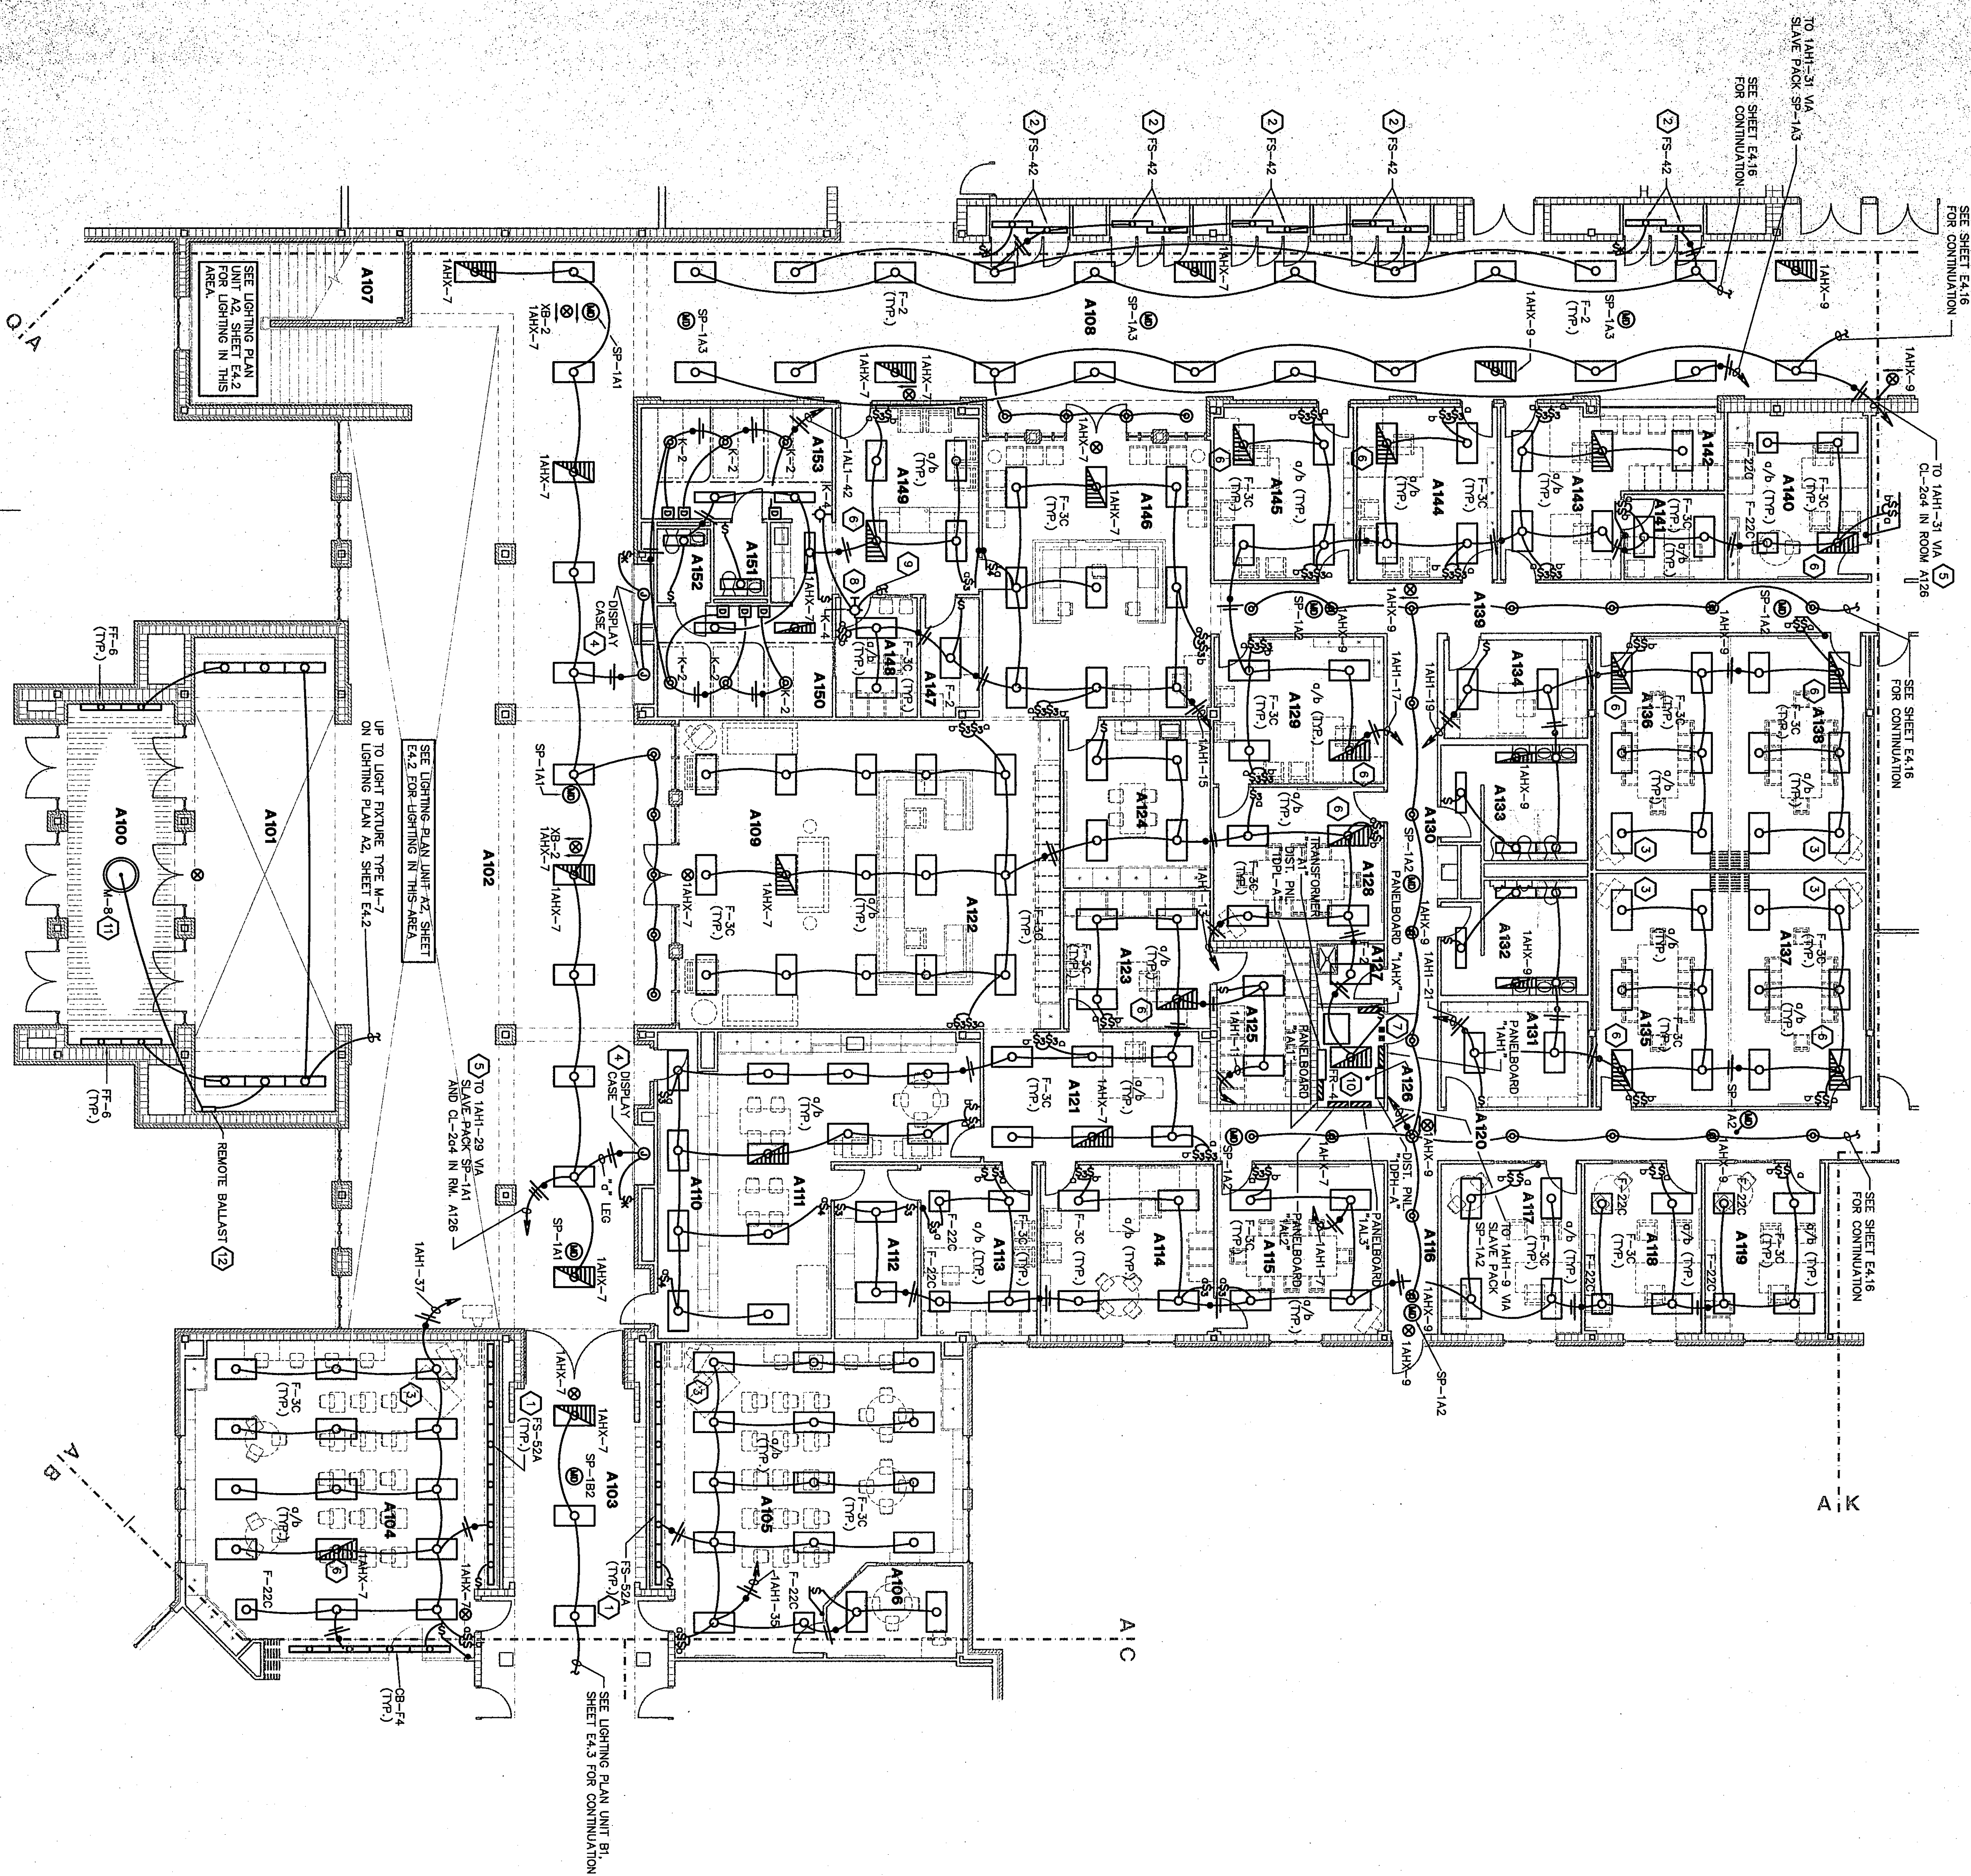

PLAN NOTES:

1. UNDER ALTERNATE BID PROVIDE LIGHT FIXTURE TYPE FS-32A MOUNTED IN COVE, 4" DIA. DOWN LIGHT TYPE, 4" DIA. MOUNTED ABOVE CHALKBOARD. SEE DETAIL 1/E1.2.
2. LIGHT FIXTURE TYPE FS-42 MOUNTED IN DISPLAY CASE. SEE DETAIL 1/E1.2.
3. WIRE BOTH BALLAST IN THIS LIGHT FIXTURE TO SWITCH LEG "0" PROVIDE SUFFICIENT FLEXIBLE CONDUIT TO MOVE THIS FIXTURE ONE GRID IN ANY DIRECTION.
4. PRE-MAUFACTURED DISPLAY CASE WITH LIGHT FIXTURE, LAMPS AND WIRE ALL EQUIPMENT. SEE DETAIL 5/E1.2.
5. FOR CORRIDOR LIGHTING CONTROL, SEE DETAIL 8/E1.4.
6. PROVIDE EMERGENCY LIGHT FIXTURE WITH A CONTROL RELAY, PER DETAIL 1/E1.5.
7. LIGHTING CONTROLS CL-104, CL-204 LOCATED ABOVE PANELBOARD "1AH".
8. MOUNT LIGHT FIXTURE TYPE K-4 ABOVE DOOR.
9. CONTINUED TO ROOM B103. SEE DRAWING SHEET E4.3.
10. WIRE LIGHT FIXTURE TO CIRCUIT 1AHX-9.
11. MOUNT LIGHT FIXTURE TYPE M-8 AT 9'-0" ABOVE FINISH FLOOR.
12. MOUNT REMOTE BALLAST AT 12 INCHES ABOVE LAV-IN CEILING.

ROOM LEGEND "A1"		
ROOM NO.	ROOM NAME	AREA S.F. CEILING HEIGHT
A100	VESTIBULE	737 VARIES
A101	COMMONS	688 VARIES
A102	COMMONS	320 VARIES
A103	COMMONS	24 VARIES
A104	COMMONS	310 VARIES
A105	COMMONS	843 VARIES
A106	COMMONS	346 VARIES
A107	COMMONS	24 VARIES
A108	COMMONS	207 VARIES
A109	COMMONS	689 VARIES
A110	COMMONS	543 VARIES
A111	COMMONS	144 VARIES
A112	COMMONS	294 VARIES
A113	COMMONS	283 VARIES
A114	COMMONS	238 VARIES
A115	COMMONS	204 VARIES
A116	COMMONS	204 VARIES
A117	COMMONS	204 VARIES
A118	COMMONS	204 VARIES
A119	COMMONS	204 VARIES
A120	COMMONS	204 VARIES
A121	COMMONS	204 VARIES
A122	COMMONS	204 VARIES
A123	COMMONS	204 VARIES
A124	COMMONS	204 VARIES
A125	COMMONS	204 VARIES
A126	COMMONS	204 VARIES
A127	COMMONS	204 VARIES
A128	COMMONS	204 VARIES
A129	COMMONS	204 VARIES
A130	COMMONS	204 VARIES
A131	COMMONS	204 VARIES
A132	COMMONS	204 VARIES
A133	COMMONS	204 VARIES
A134	COMMONS	204 VARIES
A135	COMMONS	204 VARIES
A136	COMMONS	204 VARIES
A137	COMMONS	204 VARIES
A138	COMMONS	204 VARIES
A139	COMMONS	204 VARIES
A140	COMMONS	204 VARIES
A141	COMMONS	204 VARIES
A142	COMMONS	204 VARIES
A143	COMMONS	204 VARIES
A144	COMMONS	204 VARIES
A145	COMMONS	204 VARIES
A146	COMMONS	204 VARIES
A147	COMMONS	204 VARIES
A148	COMMONS	204 VARIES
A149	COMMONS	204 VARIES
A150	COMMONS	204 VARIES
A151	COMMONS	204 VARIES
A152	COMMONS	204 VARIES
A153	COMMONS	204 VARIES

- ALL 2'x4' LIGHT FIXTURES SHALL BE PLAN TYPE F-3 UNLESS OTHERWISE NOTED.
- ALL 1'x4' LIGHT FIXTURES SHALL BE PLAN TYPE F-1 UNLESS OTHERWISE NOTED.
- ALL 2'x2' LIGHT FIXTURES SHALL BE PLAN TYPE F-22 UNLESS OTHERWISE NOTED.
- ALL RECES CAN LIGHTS SHALL BE PLAN TYPE RV-1 UNLESS OTHERWISE NOTED.
- ALL EXIT SIGNS SHALL BE PLAN TYPE XB-1 UNLESS OTHERWISE NOTED.