
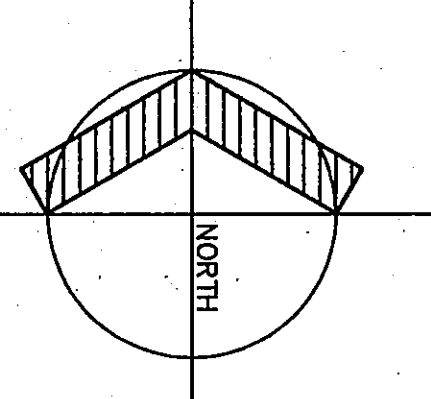


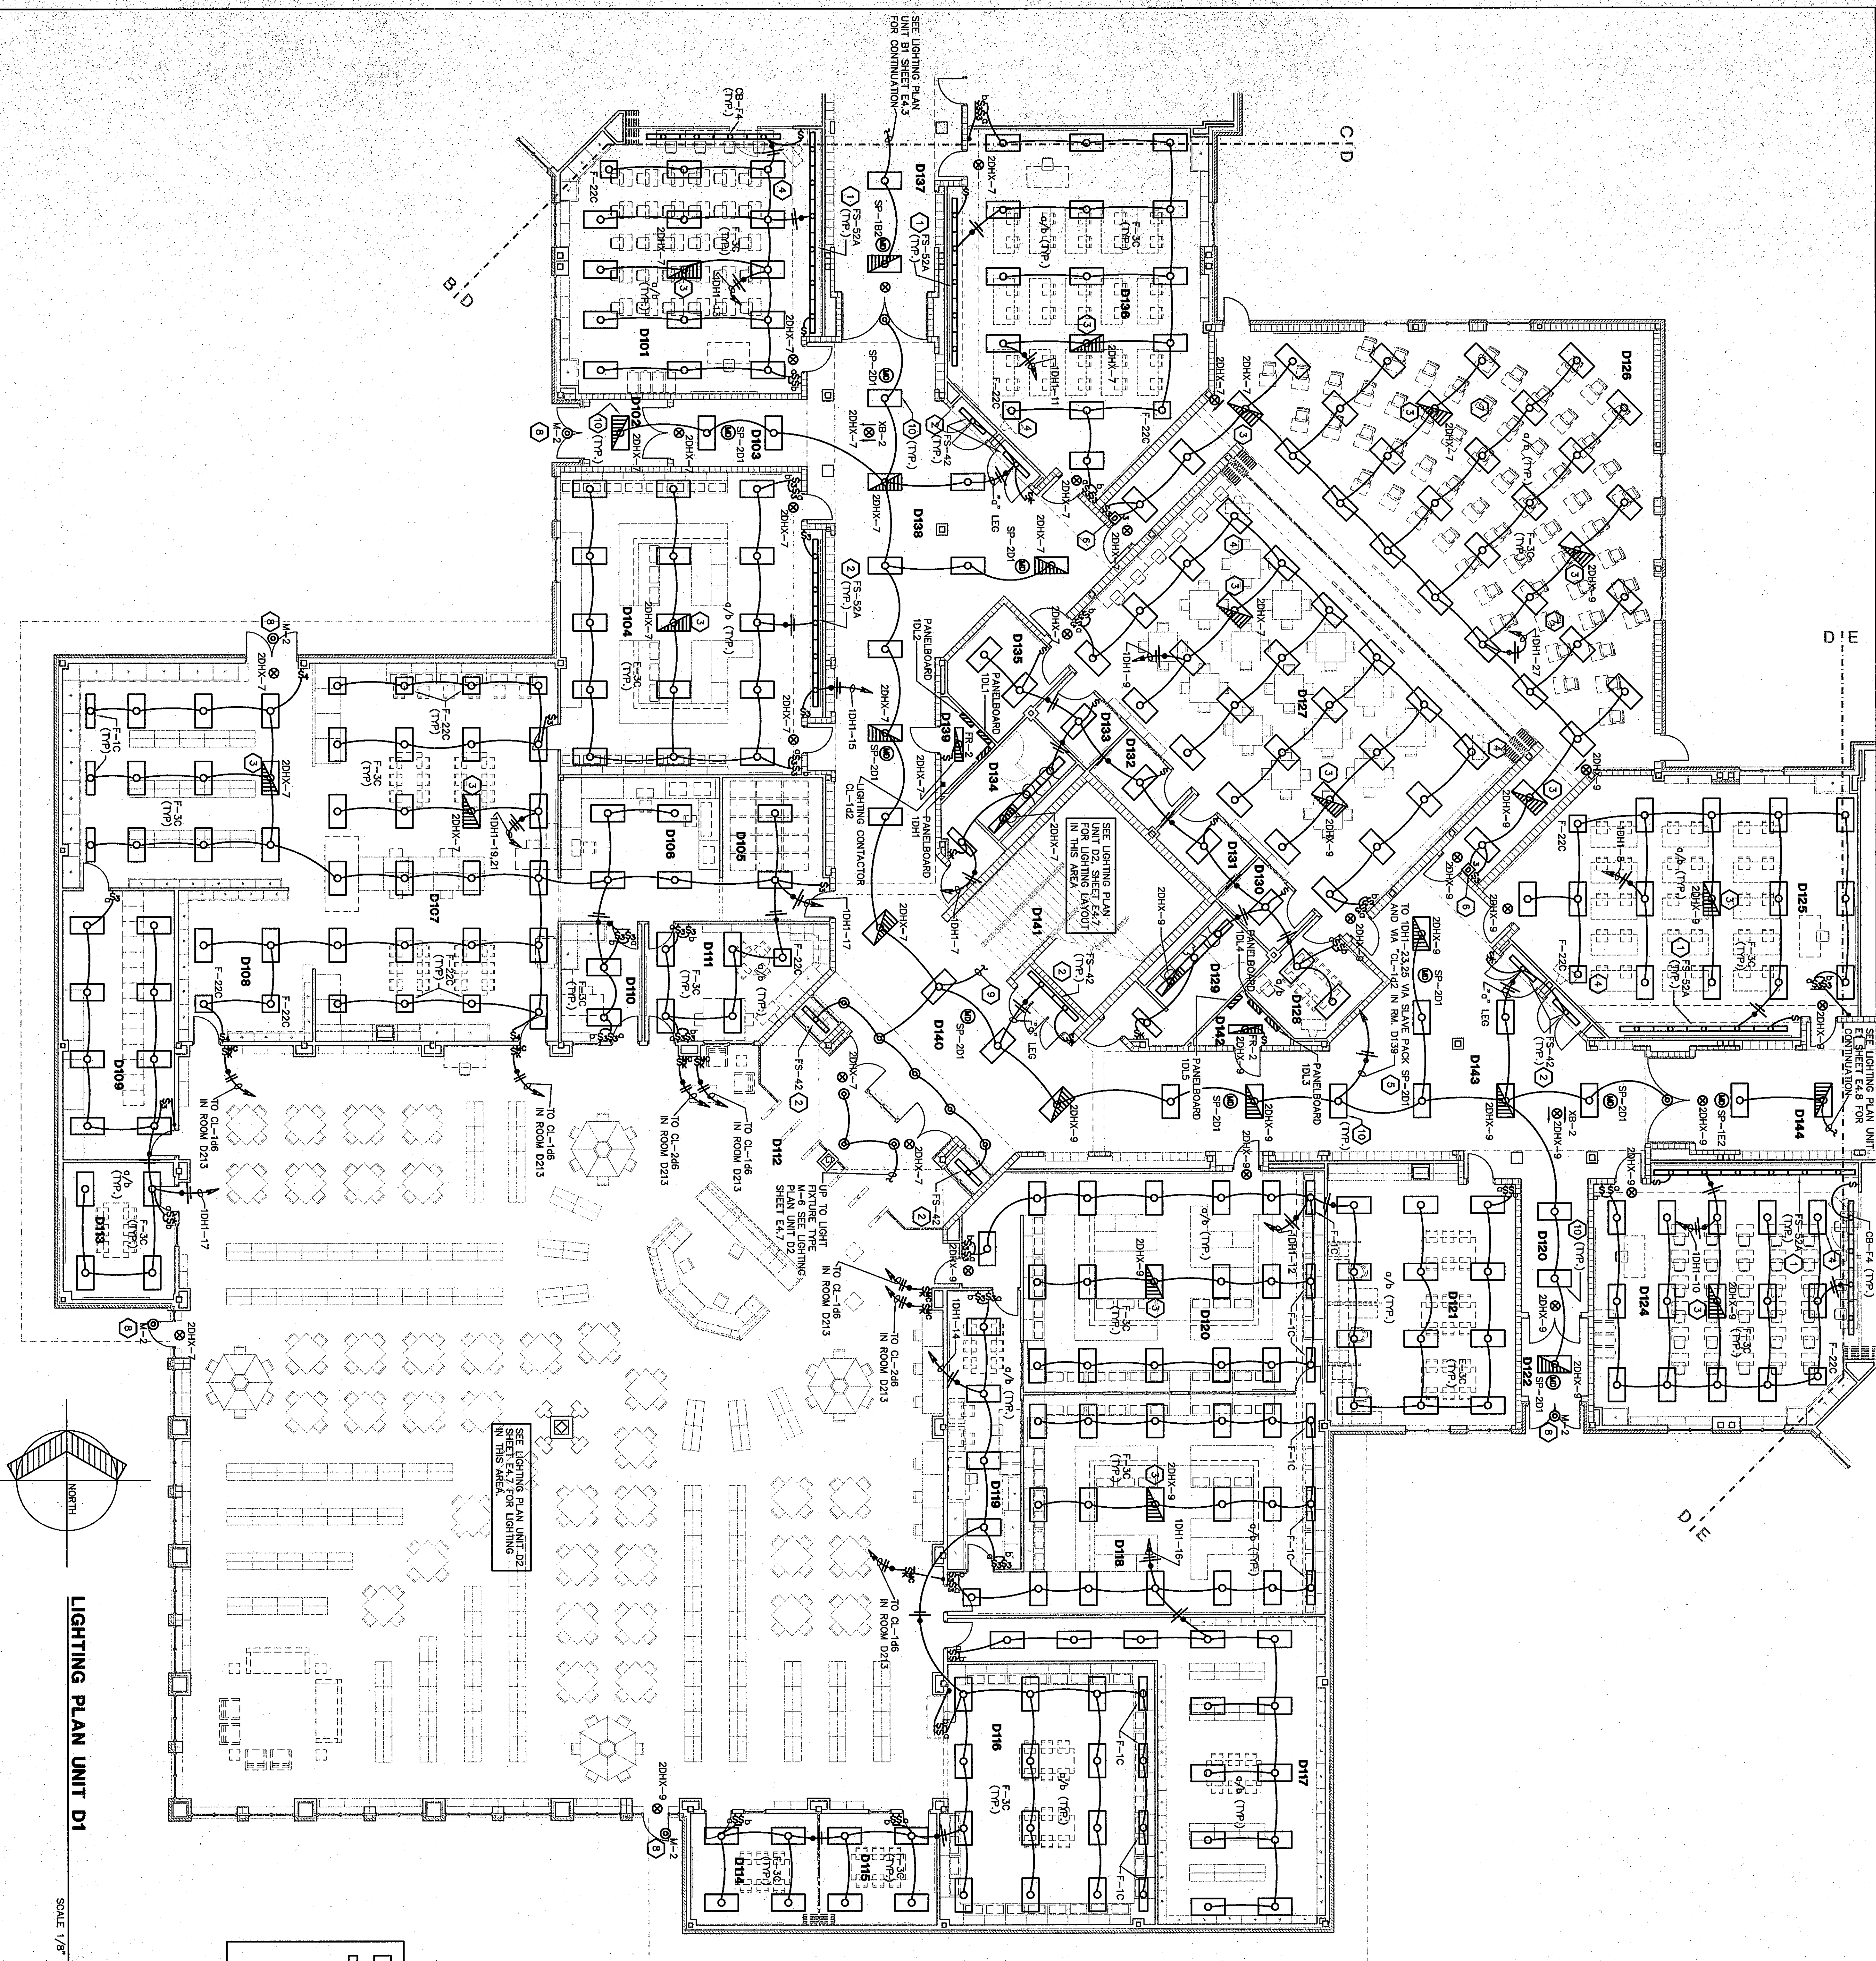

LIGHTING PLAN UNIT D1

SCALE 1/8" = 1'-0"

- ALL 2'x4' LIGHT FIXTURES SHALL BE PLAN TYPE F-3 UNLESS OTHERWISE NOTED.
- ALL 1'x4' LIGHT FIXTURES SHALL BE PLAN TYPE F-1 UNLESS OTHERWISE NOTED.
- ALL 2'x2' LIGHT FIXTURES SHALL BE PLAN TYPE F-22 UNLESS OTHERWISE NOTED.
- ALL RECESS CAN LIGHTS SHALL BE PLAN TYPE RP-1 UNLESS OTHERWISE NOTED.
- ALL EXIT SIGNS SHALL BE PLAN TYPE XG-1 UNLESS OTHERWISE NOTED.

- PLAN NOTES:**
1. UNDER ALTERNATE BID PROVIDE LIGHT FIXTURE TYPE FS-52A MOUNTED IN COVE. SEE DETAIL 4/E1.5 UNDER BASE BID PROVIDE LIGHT FIXTURE TYPE GS-4 MOUNTED ABOVE CHALKBOARD. SEE DETAIL 4/E1.3.
 2. LIGHT FIXTURE TYPE FS-42 MOUNTED IN DISPLAY CASE. SEE DETAIL 4/E1.2.
 3. PROVIDE THE EMERGENCY LIGHT FIXTURE WITH A CONTROL RELAY. PROVIDE THE RELAY ABOVE CEILING NEAR LIGHT FIXTURE. WIRE PER DETAIL 4/E1.4.
 4. WIRE BOTH BALLAST IN THIS LIGHT FIXTURE TO SWITCH LEG. PROVIDE ENOUGH FLEXIBLE CONDUIT TO MOVE THIS FIXTURE ONE GRID IN ANY DIRECTION.
 5. FOR CORRIDOR LIGHTING CONTROL REFER TO DETAIL 8/E1.4.
 6. WALLBOX DIMMER FOR FLUORESCENT LIGHTING. REFER TO DETAIL 4/E1.8 FOR ADDITIONAL INFORMATION.
 7. PROVIDE THREE LAMP ELECTRONIC DIMMING BALLAST FOR EACH LIGHT FIXTURE IN ROOM D126. SEE SPECIFICATIONS FOR BALLAST REQUIREMENTS.
 8. SECURITY LIGHTING. SEE SITE PLAN.
 9. TO STANWELL LIGHTS ABOVE. SEE DRAWING SHEET E4.7 FOR CONTINUATION.
 10. WIRE THE TWO OUTBOARD LAMP TO CIRCUIT 10H-23. WIRE THE INBOARD LAMP TO CIRCUIT 10H-25. UNLESS THE LAMP IS ON AN EMERGENCY CIRCUIT. REFER TO DETAIL 8/E1.4.

ROOM LEGEND "D1"		
ROOM NO.	ROOM NAME	AREA S.F.
D101	CLASSROOM	959
D102	CLASSROOM	959
D103	CLASSROOM	1088
D104	MULTI-MEDIA CLASSROOM	1088
D105	AV STORAGE	200
D106	AV STORAGE	200
D107	AV STORAGE	2113
D108	AV STORAGE	2113
D109	AV STORAGE	2113
D110	AV STORAGE	2113
D111	AV STORAGE	2113
D112	AV STORAGE	2113
D113	AV STORAGE	2113
D114	AV STORAGE	2113
D115	AV STORAGE	2113
D116	AV STORAGE	2113
D117	AV STORAGE	2113
D118	AV STORAGE	2113
D119	AV STORAGE	2113
D120	AV STORAGE	2113
D121	AV STORAGE	2113
D122	AV STORAGE	2113
D123	AV STORAGE	2113
D124	AV STORAGE	2113
D125	AV STORAGE	2113
D126	AV STORAGE	2113

LIGHTING PLAN UNIT D1

DRAWN BY: MRS. COMM. NO.: 95067.00
CHECKED BY: WBH DATE: APRIL 21, 1997

E4.6

REVISIONS NO. DATE

Fanning/Howey Associates, Inc.
Architects Engineers Consultants

KEYPLAN

THE NEW CHESTERTON HIGH SCHOOL FOR THE DUNELAND SCHOOL CORPORATION CHESTERTON, INDIANA

COPYRIGHT 1997 BY FANNING/HOWEY ASSOCIATES, INC.