


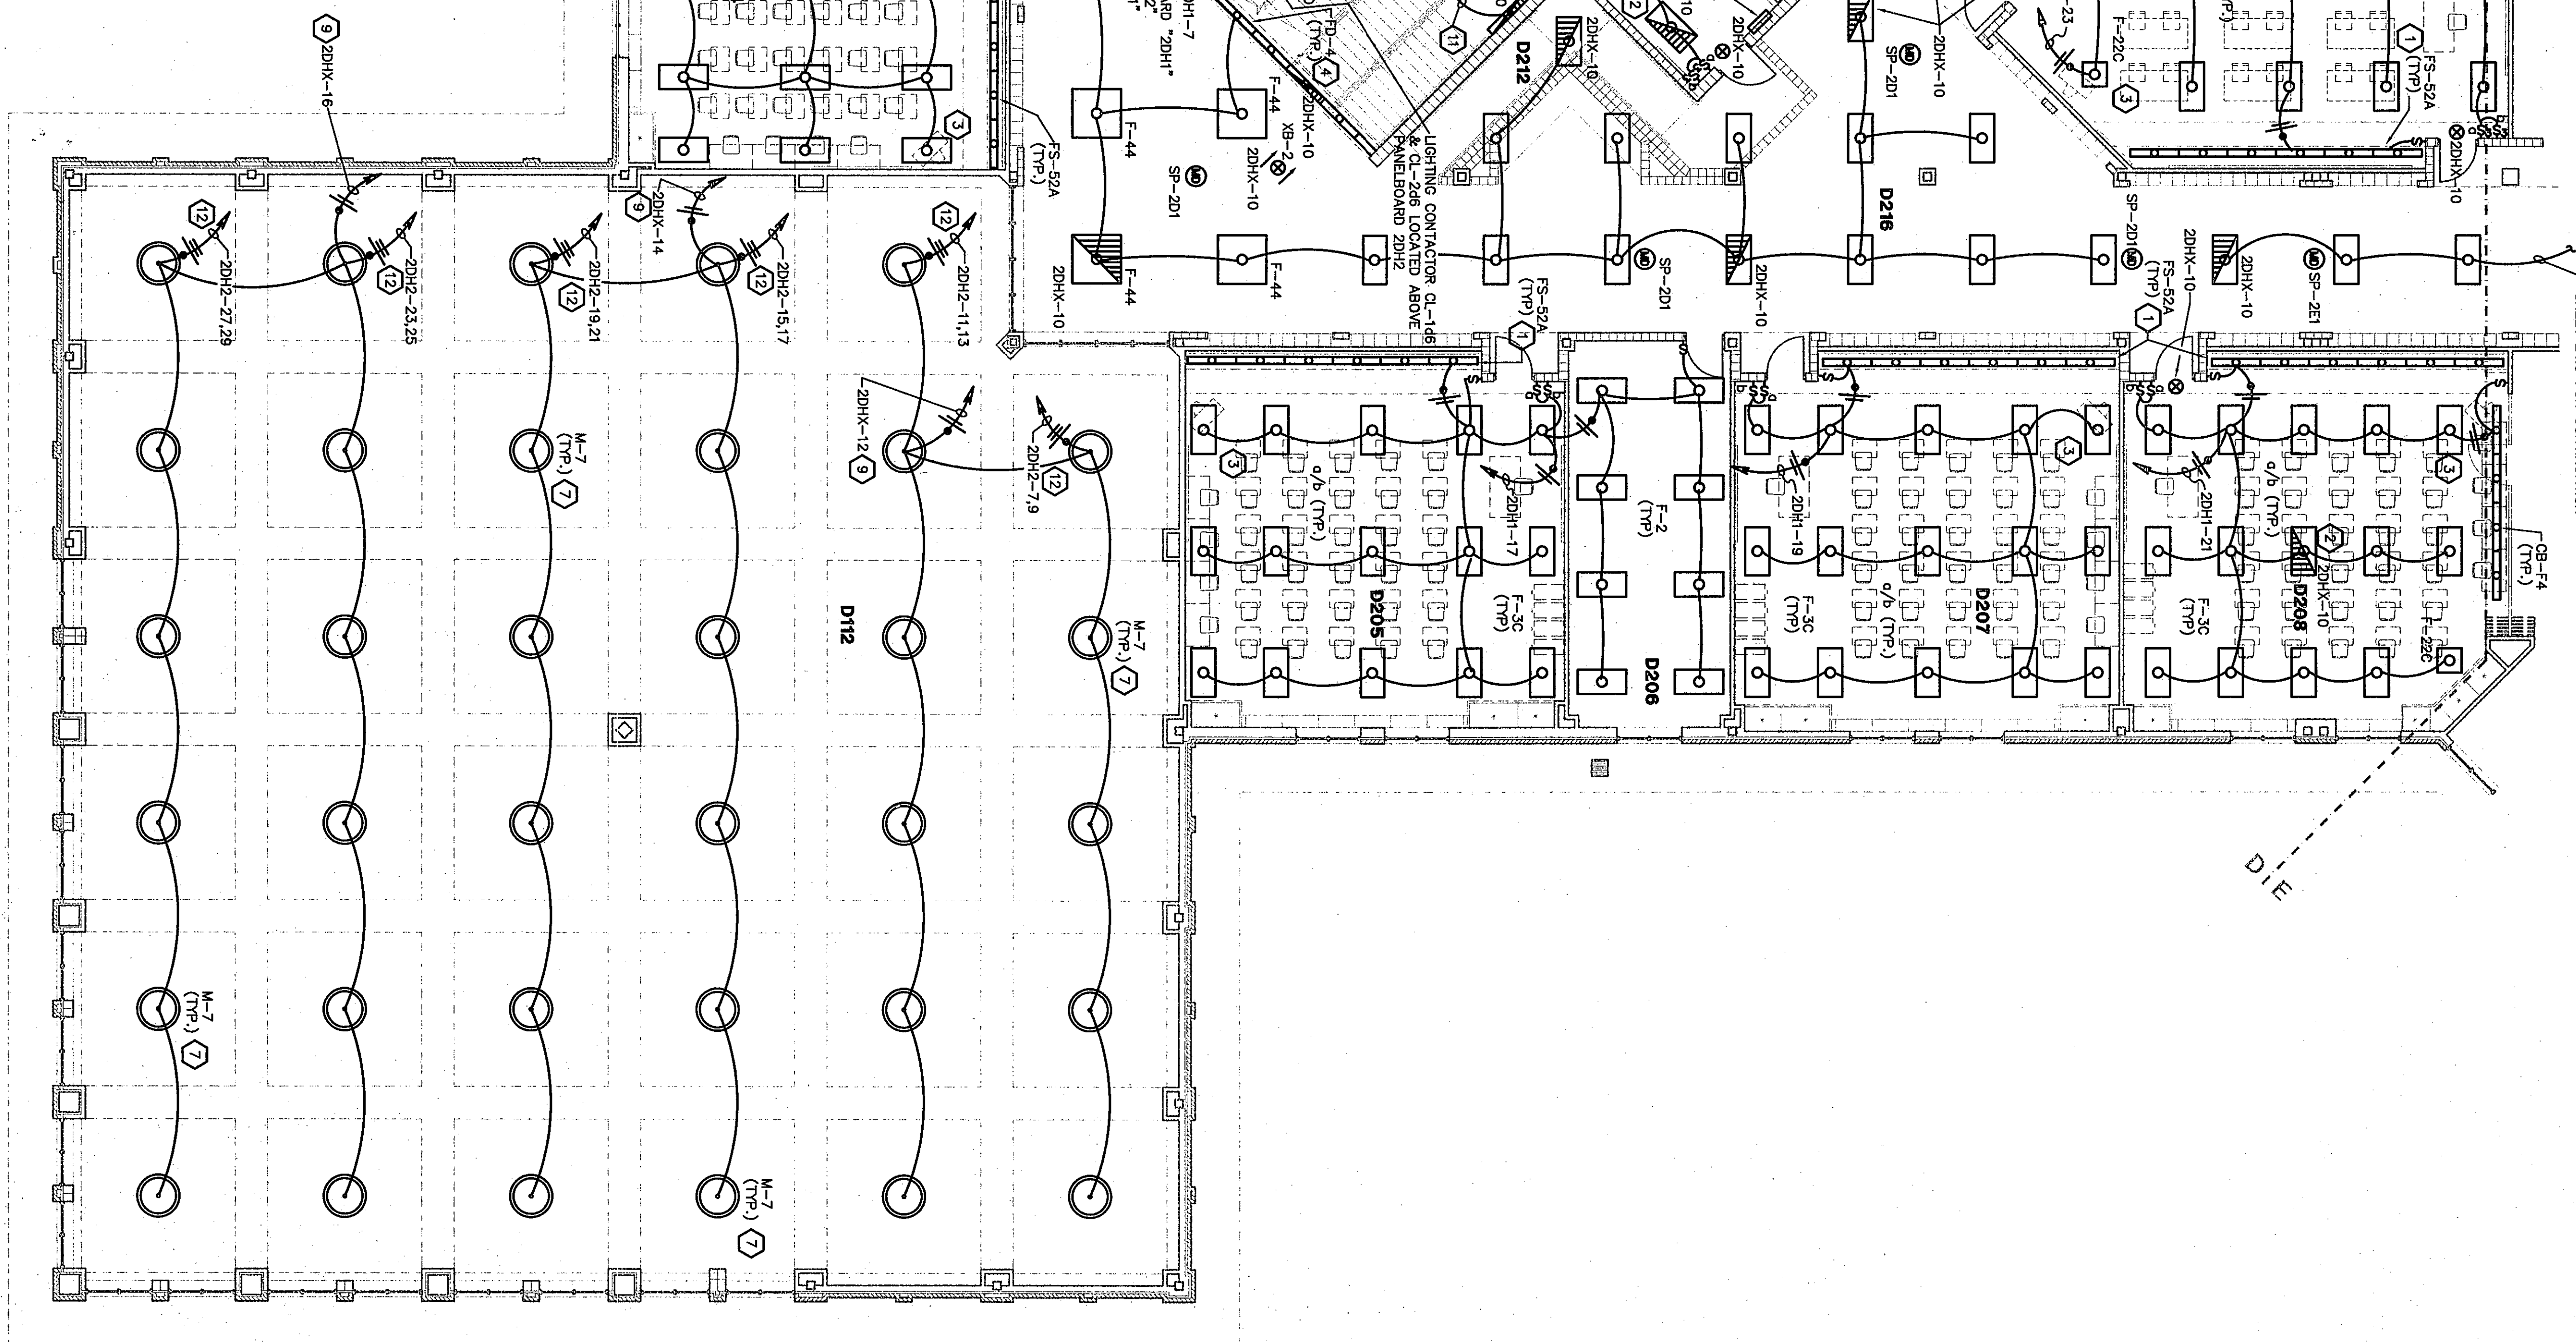

SCALE 1/8" = 1'-0"



ROOM LEGEND "D2"			
ROOM	ROOM	AREA	CEILING
Nr.		S.F.	HEIGHT
D201	CLASSROOM	955	WARES
D202	CLASSROOM	955	WARES
D203	DEPARTMENTAL OFFICE	416	9'-4"
D204	CLASSROOM	931	WARES
D205	CLASSROOM	931	WARES
D206	CLASSROOM	931	WARES
D207	CLASSROOM	972	WARES
D208	CLASSROOM	959	WARES
D209	LABORATORY	268	WARES
D210	LABORATORY	268	WARES
D211	INTERPRETED INSTRUCTION	1,300	13'-4"
D212	INTEGRATED STUDY LAB	1,312	WARES
D213	PLANT ROOM	115	WARES
D214	COMPUTER LAB	2057	10'-0"
D215	CORRIDOR	2052	10'-0"

PLAN NOTES:


- [illegible]

LIGHTING PLAN UNIT D2


DRAWN BY: MRS	COMM. NO.: 95067.00
CHECKED BY: WBH	DATE: APRIL 21, 1997

E4.7

REVISIONS NO.	DATE
---------------	------

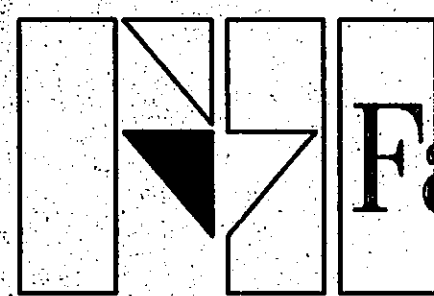

**Fanning/Howey
Associates, Inc.**
Architects Engineers Consultants

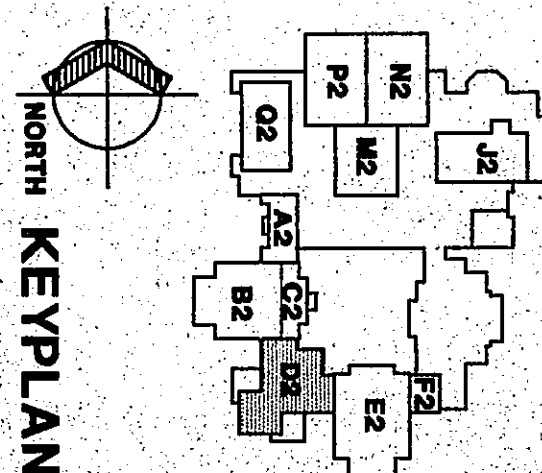

THE NEW
CHESTERTON HIGH SCHOOL
FOR THE
DUNELAND SCHOOL CORPORATION
CHESTERTON, INDIANA

COPYRIGHT 1997 BY FANNING/HOWEY ASSOCIATES, INC.

