
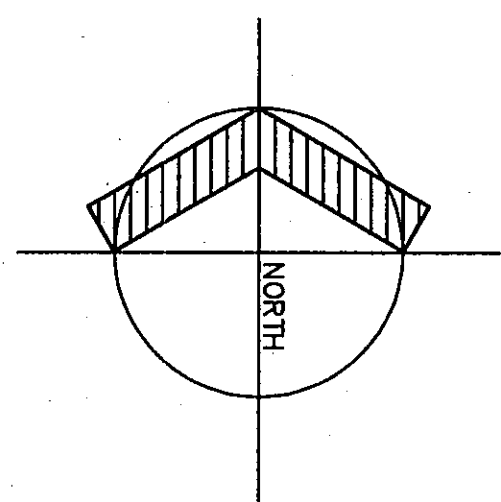


95

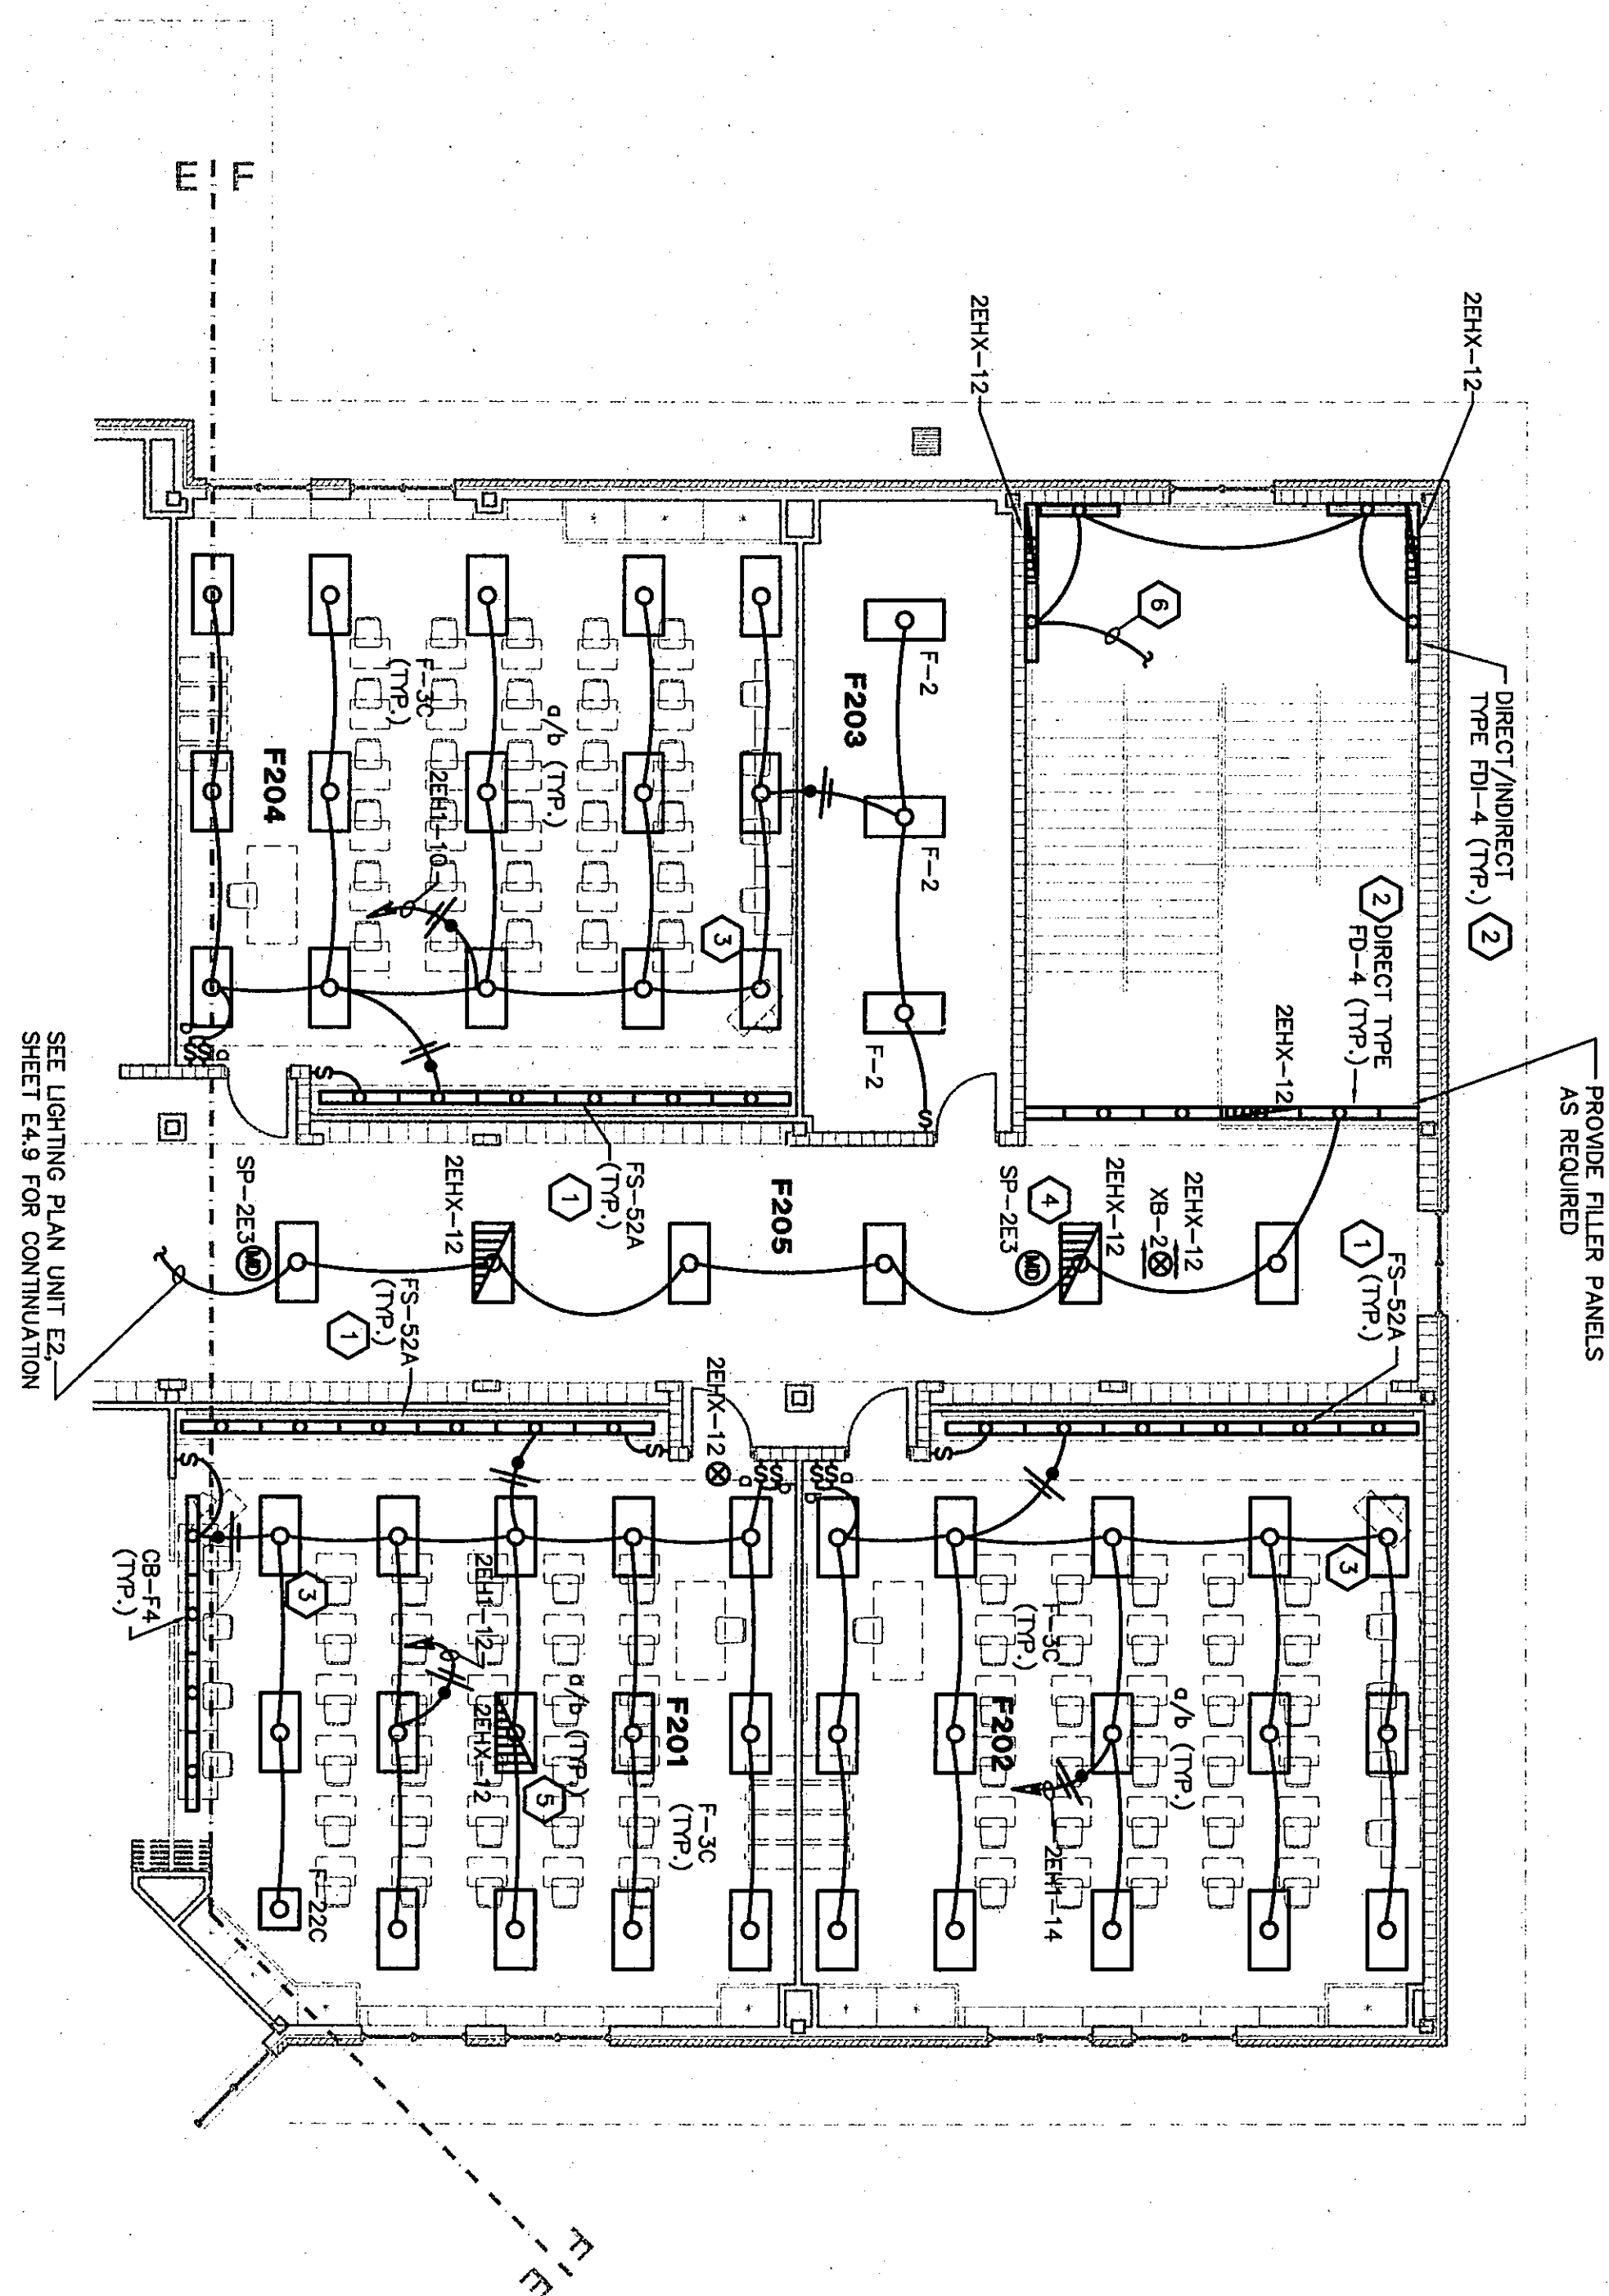

LIGHTING PLAN UNIT F2

SCALE 1/8" = 1'-0"

ROOM LEGEND "F1"			
ROOM NO.	ROOM NAME	AREA S.F.	CEILING HEIGHT
F201	CLASSROOM	960	VAIRES
F202	CLASSROOM	972	VAIRES
F203	CLASSROOM	972	VAIRES
F204	CLASSROOM	972	VAIRES
F205	CORRIDOR	823	10'-0"

PLAN NOTES:

- 1 UNDER ALTERNATE BID PROVIDE LIGHT FIXTURE TYPE FS-52A MOUNTED IN COVE, SEE DETAIL 4/E1.5. UNDER BASE BID PROVIDE LIGHT FIXTURE TYPE CB-4 MOUNTED ABOVE CHALKBOARD, SEE DETAIL 4/E1.5.
- 2 MOUNT LIGHT FIXTURE TYPE FD-4 AND FD-4 PER DETAIL 11/E1.10.
- 3 WIRE BOTH BALLAST IN THIS LIGHT FIXTURE TO SWITCH LEG "C". PROVIDE ENOUGH FLEXIBLE CONDUIT TO MOVE THIS FIXTURE ONE GRID IN ANY DIRECTION.
- 4 FOR CORRIDOR/STAIRWAY LIGHTING CONTROL, SEE DETAIL 8/E1.4.
- 5 PROVIDE THE EMERGENCY LIGHT FIXTURE WITH A CONTROL RELAY, MOUNT CONTROL RELAY ABOVE CEILING NEAR LIGHT FIXTURE, WIRE PER DETAIL 17/E1.5.
- 6 TO CIRCUIT TERN-38. SEE DRAWING SHEET EA.10 FOR CONTINUATION.

☐	ALL 2'x4' LIGHT FIXTURES SHALL BE PLAN TYPE F-3 UNLESS OTHERWISE NOTED.
☐	ALL 1'x4' LIGHT FIXTURES SHALL BE PLAN TYPE F-1 UNLESS OTHERWISE NOTED.
☐	ALL 2'x2' LIGHT FIXTURES SHALL BE PLAN TYPE F-22 UNLESS OTHERWISE NOTED.
☐	ALL RECESS CAN LIGHTS SHALL BE PLAN TYPE RD-1 UNLESS OTHERWISE NOTED.
☒	ALL EXIT SIGNS SHALL BE PLAN TYPE XB-1 UNLESS OTHERWISE NOTED.

01-E-54

LIGHTING PLAN UNIT F2

DRAWN BY: MRS

COMM. NO.: 95067.00

CHECKED BY: WBH


DATE: APRIL 21, 1997

E4.11

REVISIONS NO. DATE

Fanning/Howey Associates, Inc.

Architects Engineers Consultants

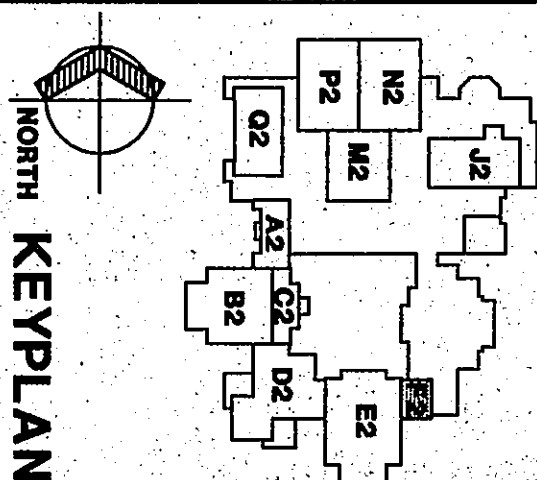

THE NEW

CHESTERTON HIGH SCHOOL

FOR THE

DUNELAND SCHOOL CORPORATION

CHESTERTON, INDIANA

COPYRIGHT 1997 BY FANNING/HOWEY ASSOCIATES, INC.