
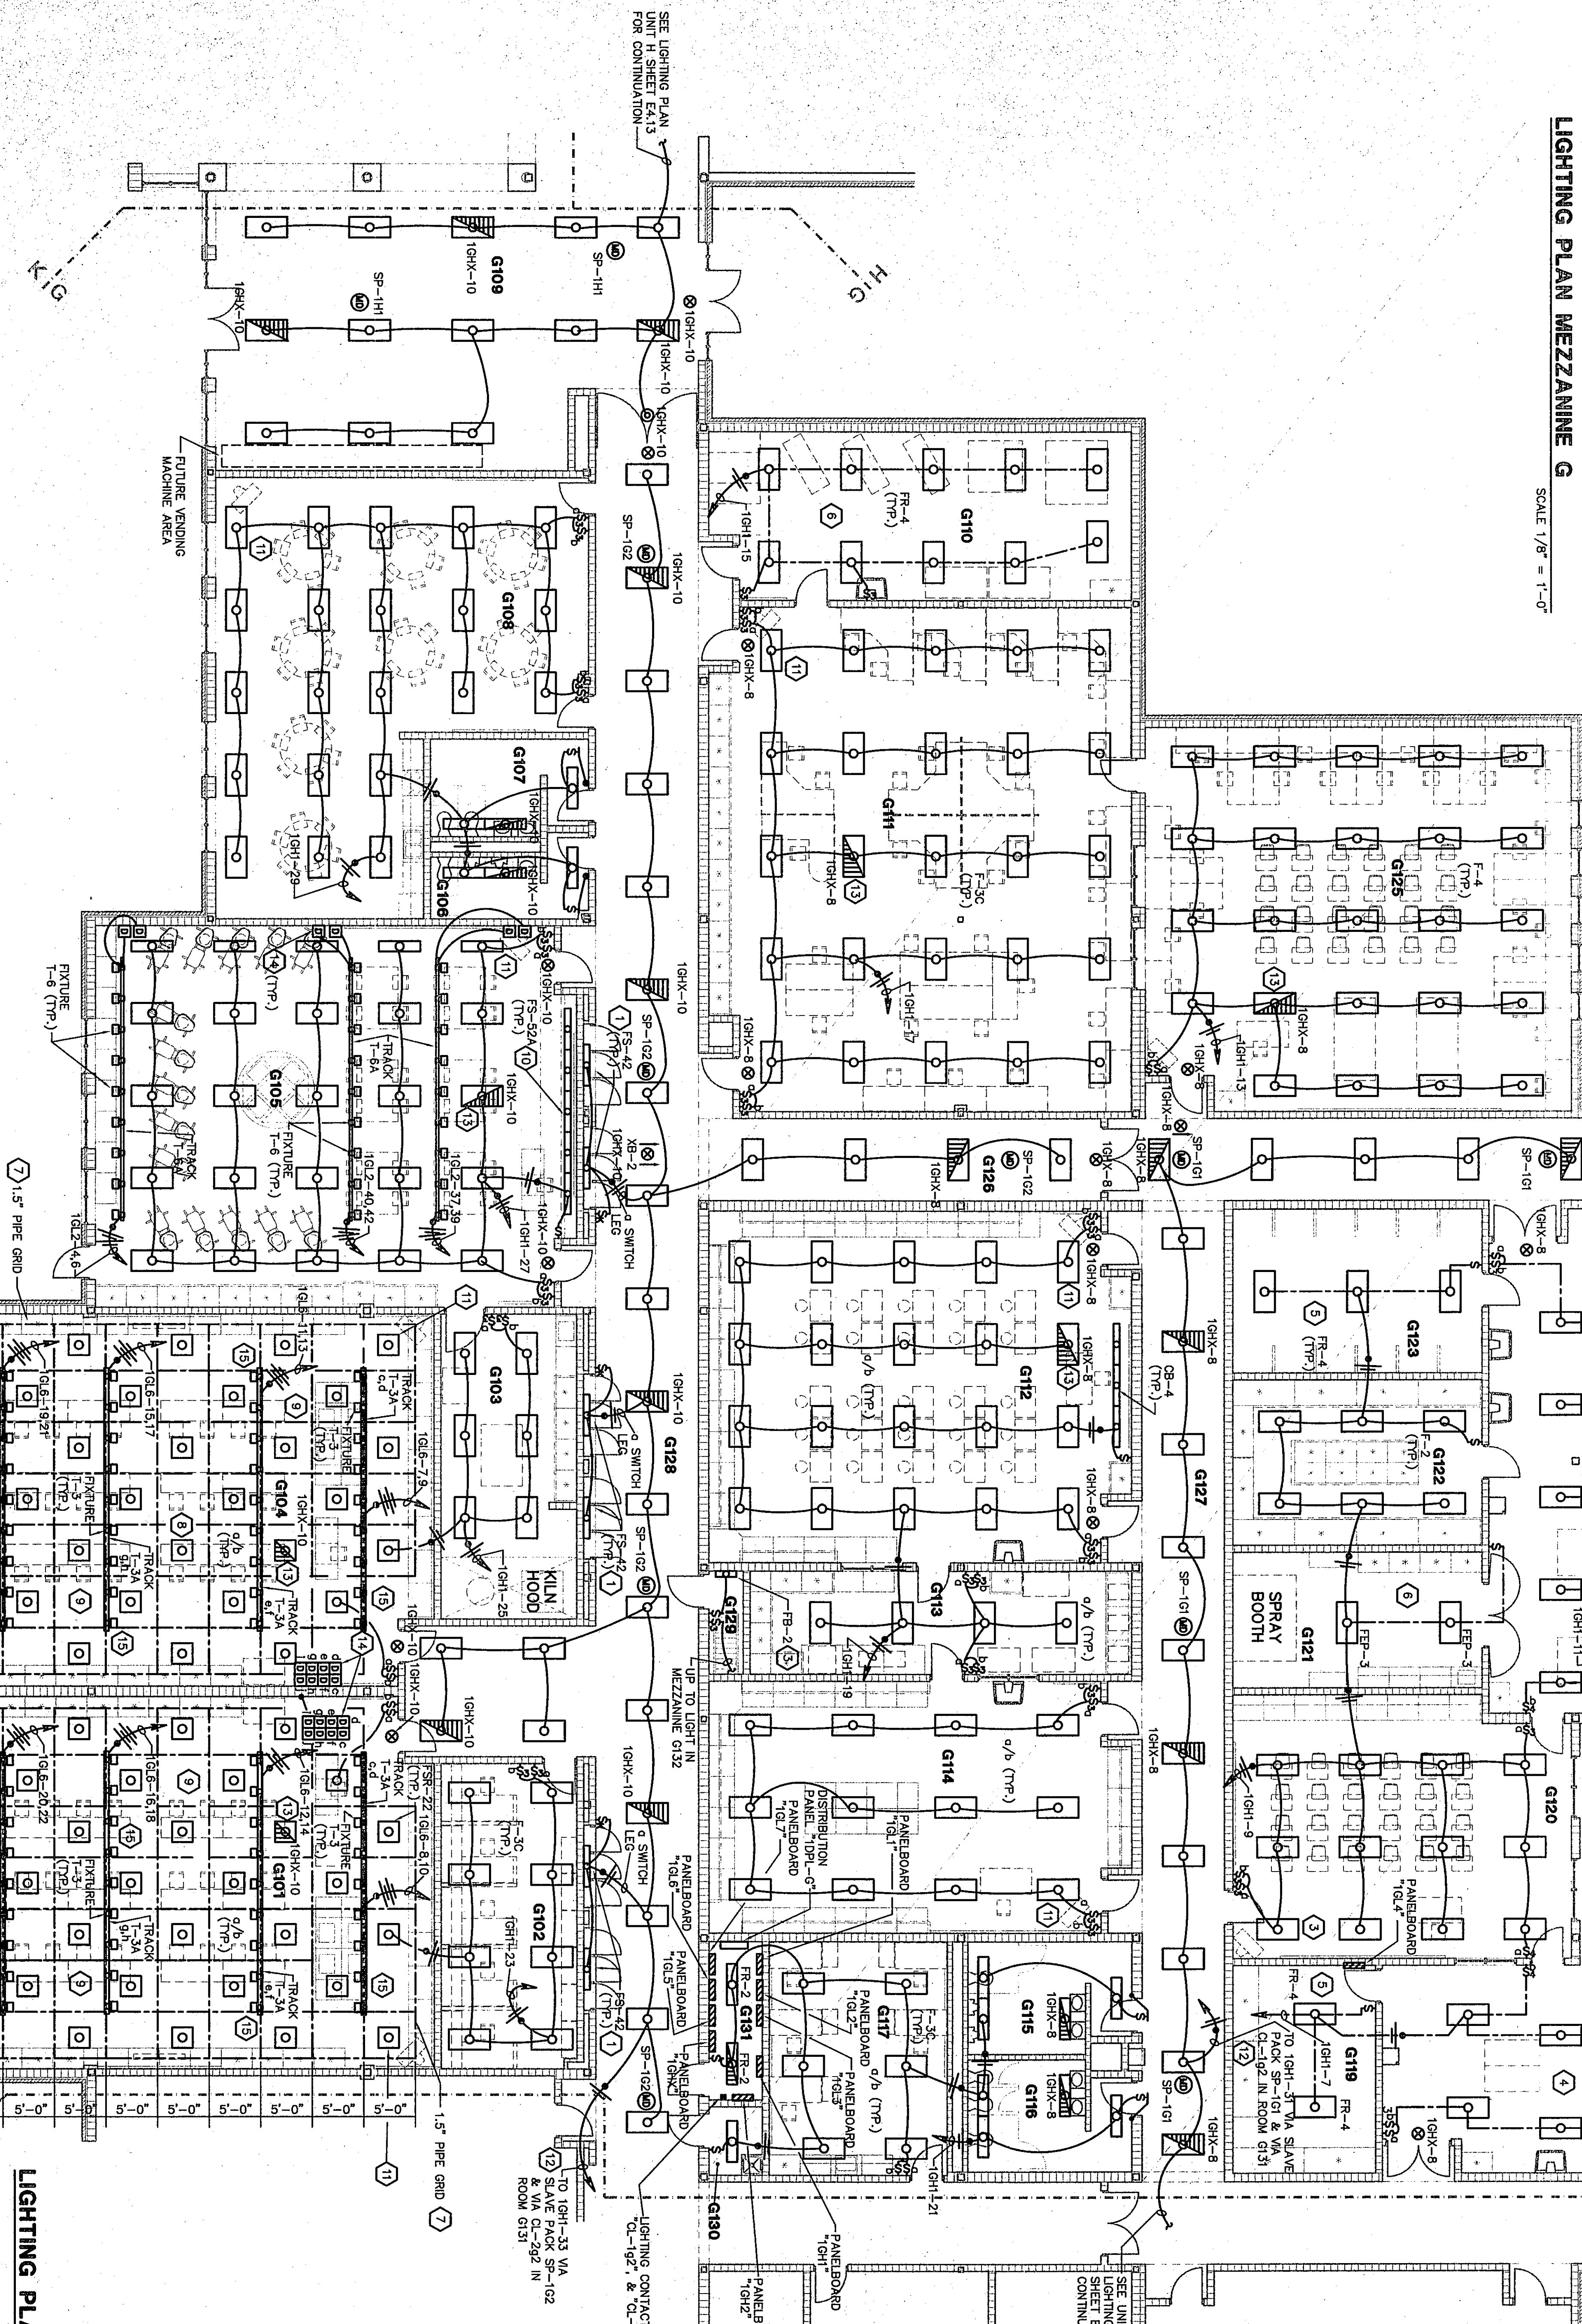


65

LIGHTING PLAN MEZZANINE G
SCALE 1/8" = 1'-0"

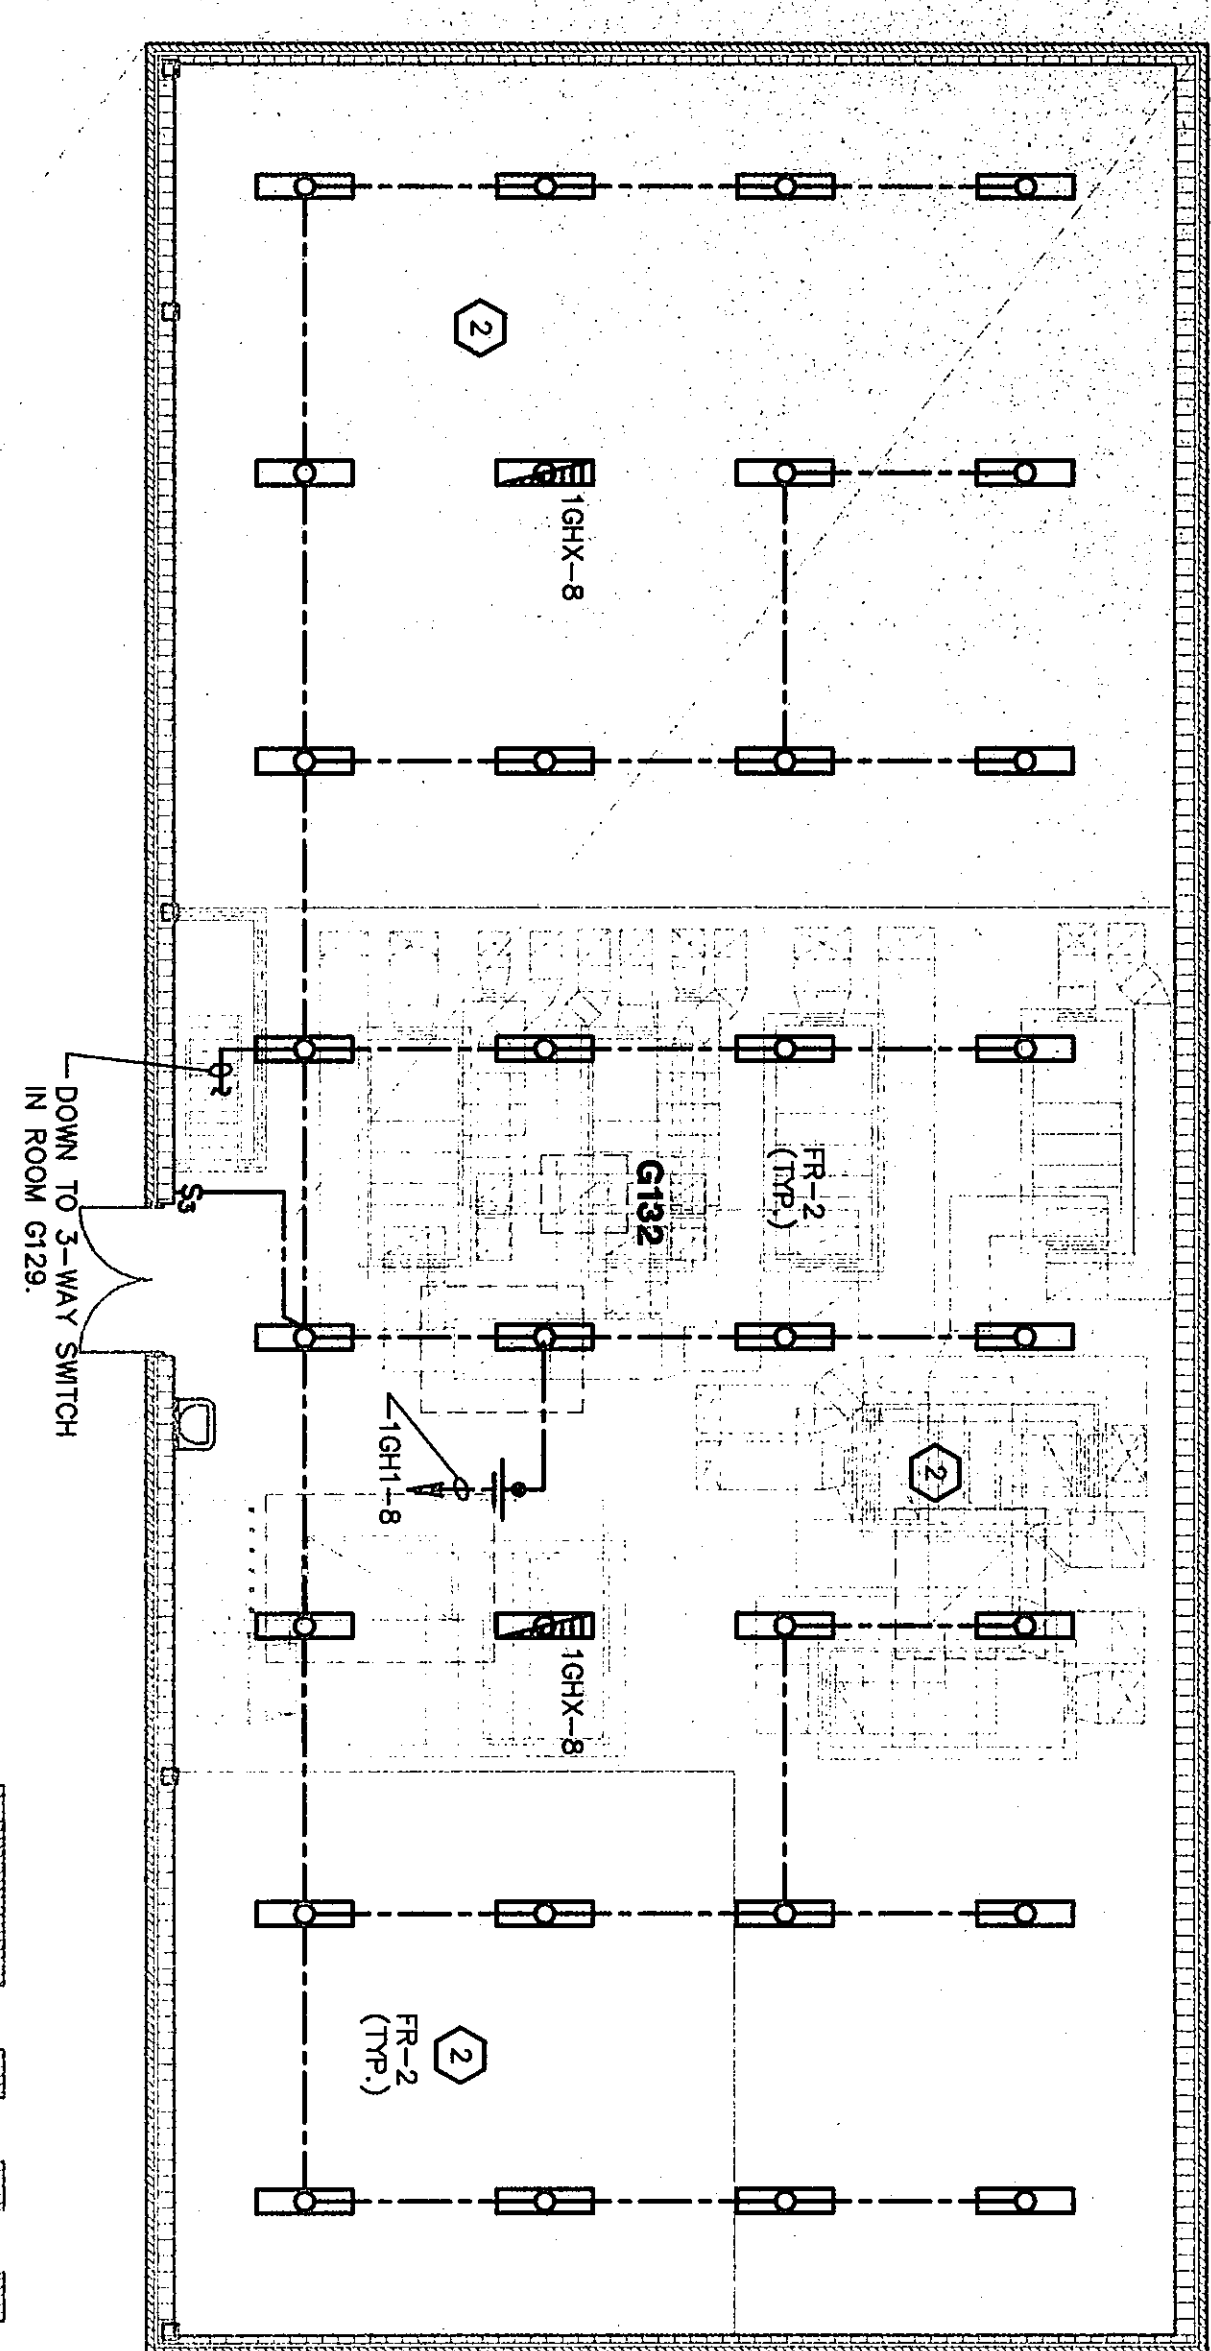


LIGHTING PLAN UNIT G
SCALE 1/8" = 1'-0"

PLAN NOTES:


1. LIGHT FIXTURE TYPE RS-42 MOUNTED IN DISPLAY CASE. SEE DETAIL 1/E12.
2. MOUNT LIGHT FIXTURE TYPE RS-2 AT 8'-6" ABOVE FINISH FLOOR. MOUNT LIGHT FIXTURES TO MEET ALL MECHANICAL EQUIPMENT.
3. MOUNT LIGHT FIXTURE TYPE RS-2 ON WALL AT 8'-0" ABOVE FINISH FLOOR.
4. MOUNT LIGHT FIXTURE TYPE RS-4 AT 16'-0" ABOVE FINISH FLOOR.
5. MOUNT LIGHT FIXTURE TYPE RS-4 AT 16'-0" ABOVE FINISH FLOOR.
6. MOUNT LIGHT FIXTURE TYPE RS-4 AT 16'-0" ABOVE FINISH FLOOR.
7. MOUNT LIGHT FIXTURE TYPE RS-4 AT 16'-0" ABOVE FINISH FLOOR.
8. MOUNT LIGHT FIXTURE TYPE RS-4 AT 16'-0" ABOVE FINISH FLOOR.
9. MOUNT LIGHT FIXTURE TYPE RS-4 AT 16'-0" ABOVE FINISH FLOOR.
10. MOUNT LIGHT FIXTURE TYPE RS-4 AT 16'-0" ABOVE FINISH FLOOR.
11. MOUNT LIGHT FIXTURE TYPE RS-4 AT 16'-0" ABOVE FINISH FLOOR.
12. MOUNT LIGHT FIXTURE TYPE RS-4 AT 16'-0" ABOVE FINISH FLOOR.
13. MOUNT LIGHT FIXTURE TYPE RS-4 AT 16'-0" ABOVE FINISH FLOOR.
14. MOUNT LIGHT FIXTURE TYPE RS-4 AT 16'-0" ABOVE FINISH FLOOR.
15. MOUNT LIGHT FIXTURE TYPE RS-4 AT 16'-0" ABOVE FINISH FLOOR.
16. MOUNT LIGHT FIXTURE TYPE RS-4 AT 16'-0" ABOVE FINISH FLOOR.
17. MOUNT LIGHT FIXTURE TYPE RS-4 AT 16'-0" ABOVE FINISH FLOOR.
18. MOUNT LIGHT FIXTURE TYPE RS-4 AT 16'-0" ABOVE FINISH FLOOR.
19. MOUNT LIGHT FIXTURE TYPE RS-4 AT 16'-0" ABOVE FINISH FLOOR.

- ALL 2'x4' LIGHT FIXTURES SHALL BE PLAN TYPE F-3 UNLESS OTHERWISE NOTED.
- ALL 1'x4' LIGHT FIXTURES SHALL BE PLAN TYPE F-1 UNLESS OTHERWISE NOTED.
- ALL 2'x2' LIGHT FIXTURES SHALL BE PLAN TYPE F-22 UNLESS OTHERWISE NOTED.
- ALL RECESS CAN LIGHTS SHALL BE PLAN TYPE RD-1 UNLESS OTHERWISE NOTED.
- ALL EXIT SIGNS SHALL BE PLAN TYPE AB-1 UNLESS OTHERWISE NOTED.

ROOM LEGEND "G1"			AREA	CEILING
ROOM NO.	ROOM NAME	S.F.	HEIGHT	
G101	22/23 LAB	1700	9'-4"	
G102	22/23 LAB	1700	9'-4"	
G103	KILN ROOM	388	9'-4"	
G104	22/23 LAB	1700	9'-4"	
G105	22/23 LAB	1700	9'-4"	
G106	22/23 LAB	1700	9'-4"	
G107	22/23 LAB	1700	9'-4"	
G108	22/23 LAB	1700	9'-4"	
G109	22/23 LAB	1700	9'-4"	
G110	22/23 LAB	1700	9'-4"	
G111	22/23 LAB	1700	9'-4"	
G112	22/23 LAB	1700	9'-4"	
G113	22/23 LAB	1700	9'-4"	
G114	22/23 LAB	1700	9'-4"	
G115	22/23 LAB	1700	9'-4"	
G116	22/23 LAB	1700	9'-4"	
G117	22/23 LAB	1700	9'-4"	
G118	22/23 LAB	1700	9'-4"	
G119	22/23 LAB	1700	9'-4"	
G120	22/23 LAB	1700	9'-4"	
G121	22/23 LAB	1700	9'-4"	
G122	22/23 LAB	1700	9'-4"	
G123	22/23 LAB	1700	9'-4"	
G124	22/23 LAB	1700	9'-4"	
G125	22/23 LAB	1700	9'-4"	
G126	22/23 LAB	1700	9'-4"	
G127	22/23 LAB	1700	9'-4"	
G128	22/23 LAB	1700	9'-4"	
G129	22/23 LAB	1700	9'-4"	
G130	22/23 LAB	1700	9'-4"	
G131	22/23 LAB	1700	9'-4"	
G132	22/23 LAB	1700	9'-4"	
G133	22/23 LAB	1700	9'-4"	

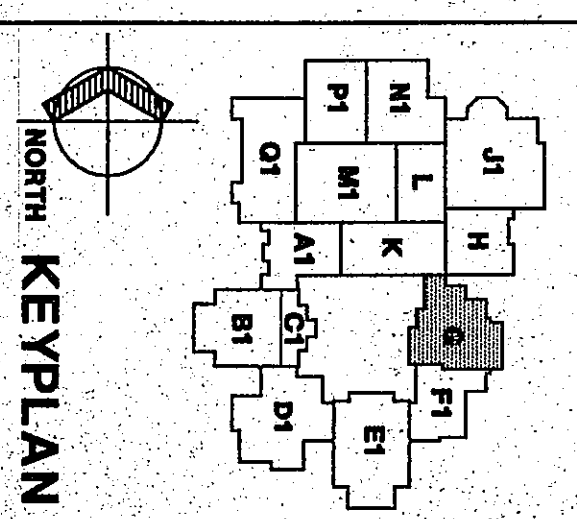

THE NEW
CHESTERTON HIGH SCHOOL
FOR THE
DUNELAND SCHOOL CORPORATION
CHESTERTON, INDIANA

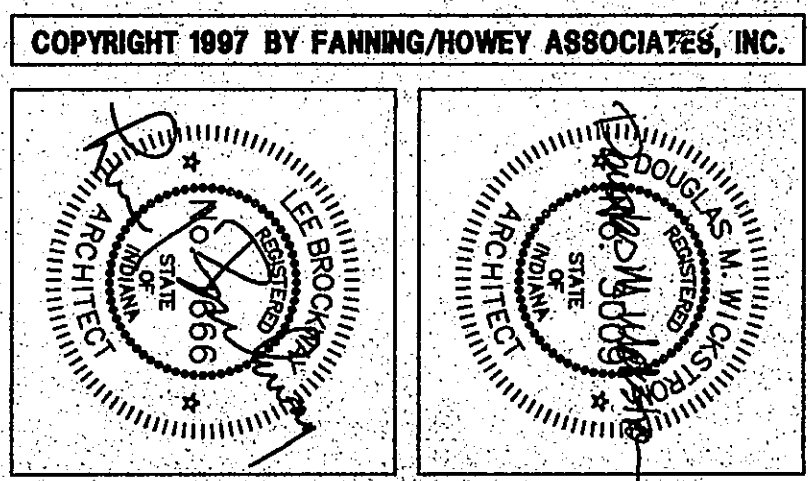

LIGHTING PLAN UNIT G	
DRAWN BY: MRS. COMM. NO.: 95067.00	CHECKED BY: WBH DATE: APRIL 21, 1997
E4.12	REVISIONS NO. DATE

Fanning/Howey Associates, Inc.
Architects Engineers Consultants