
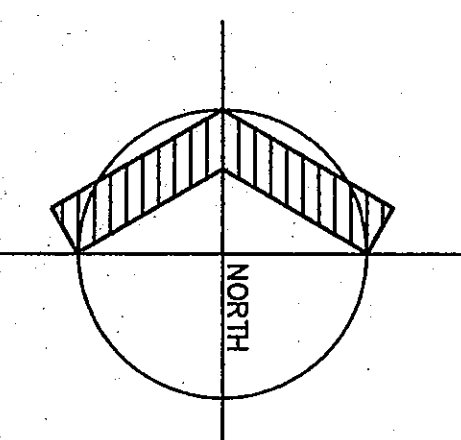
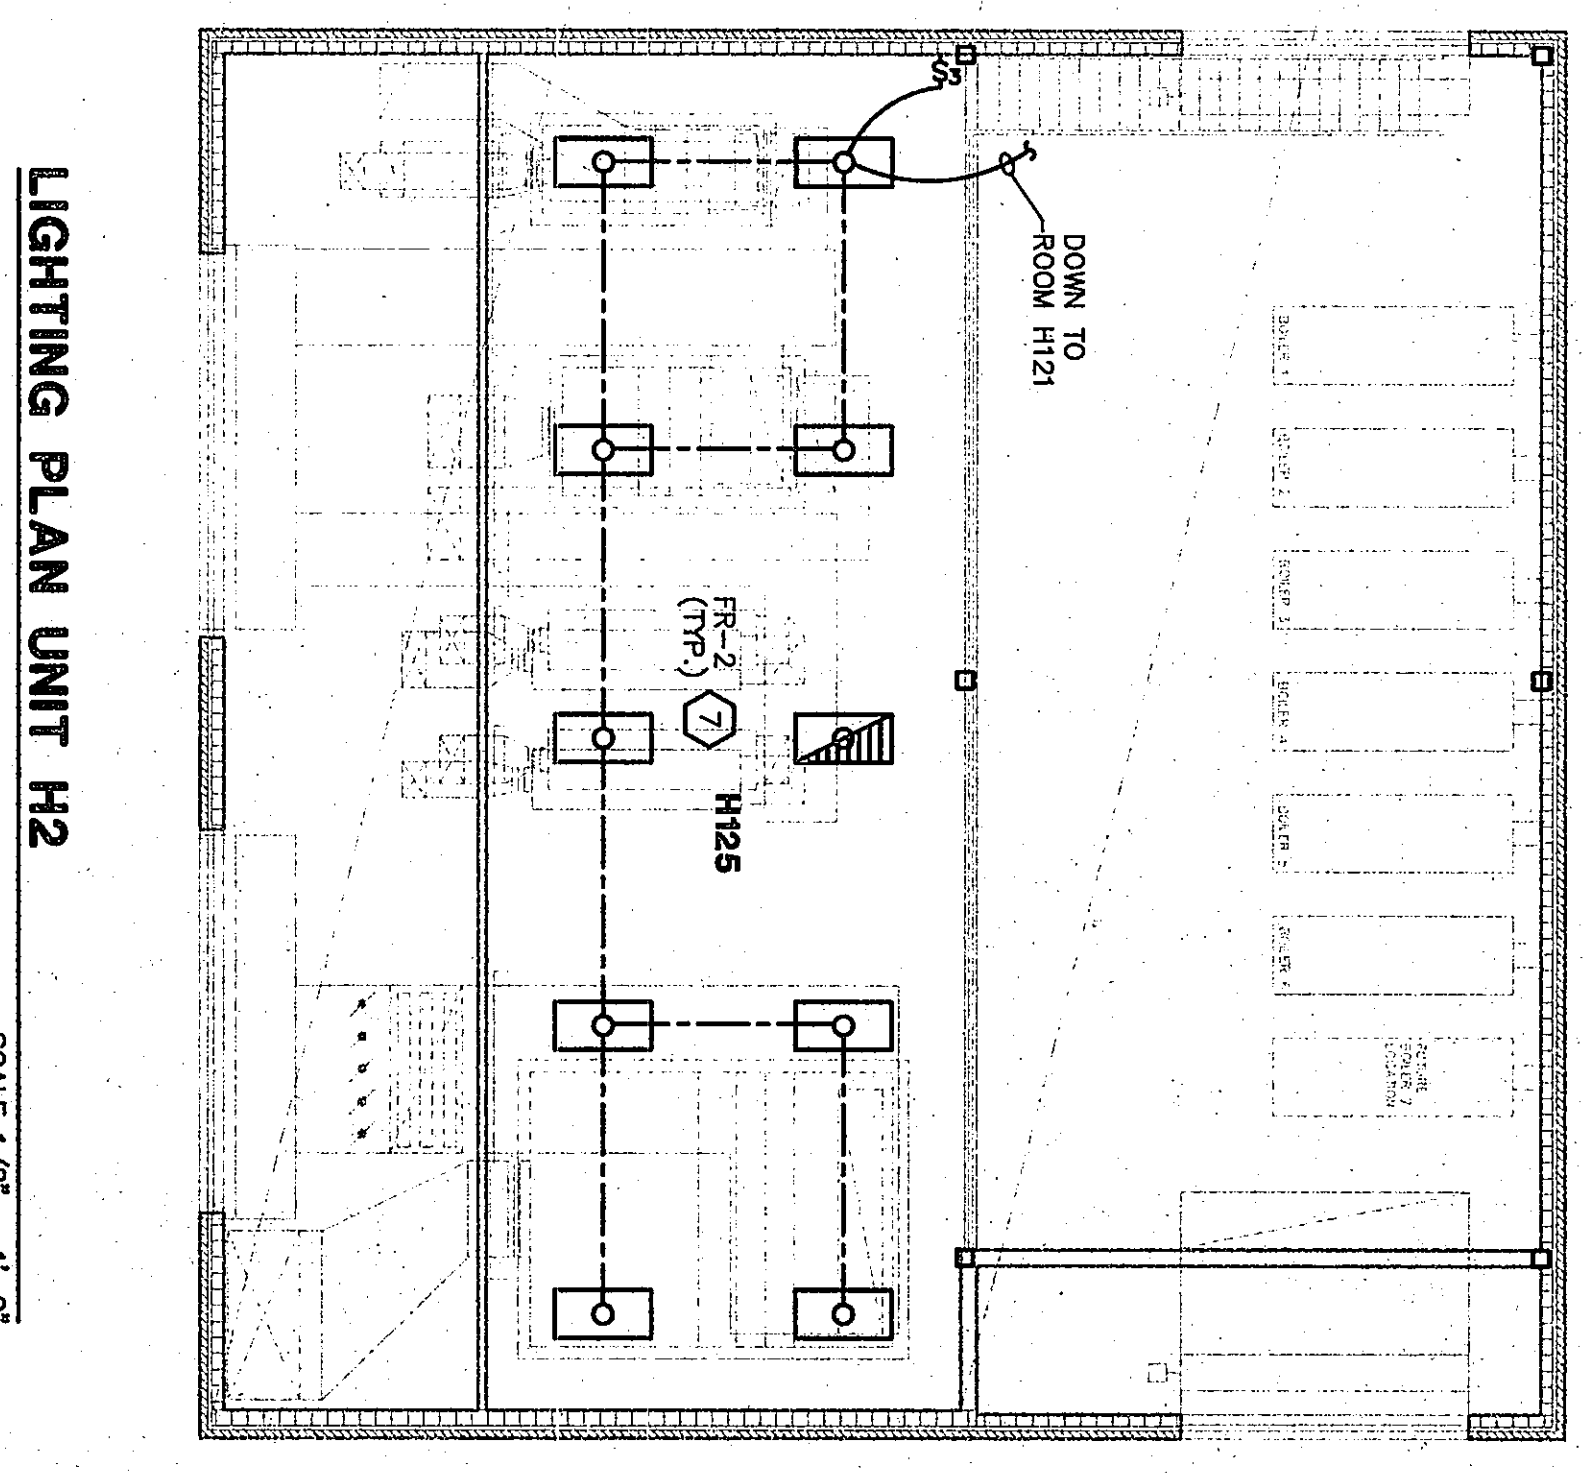


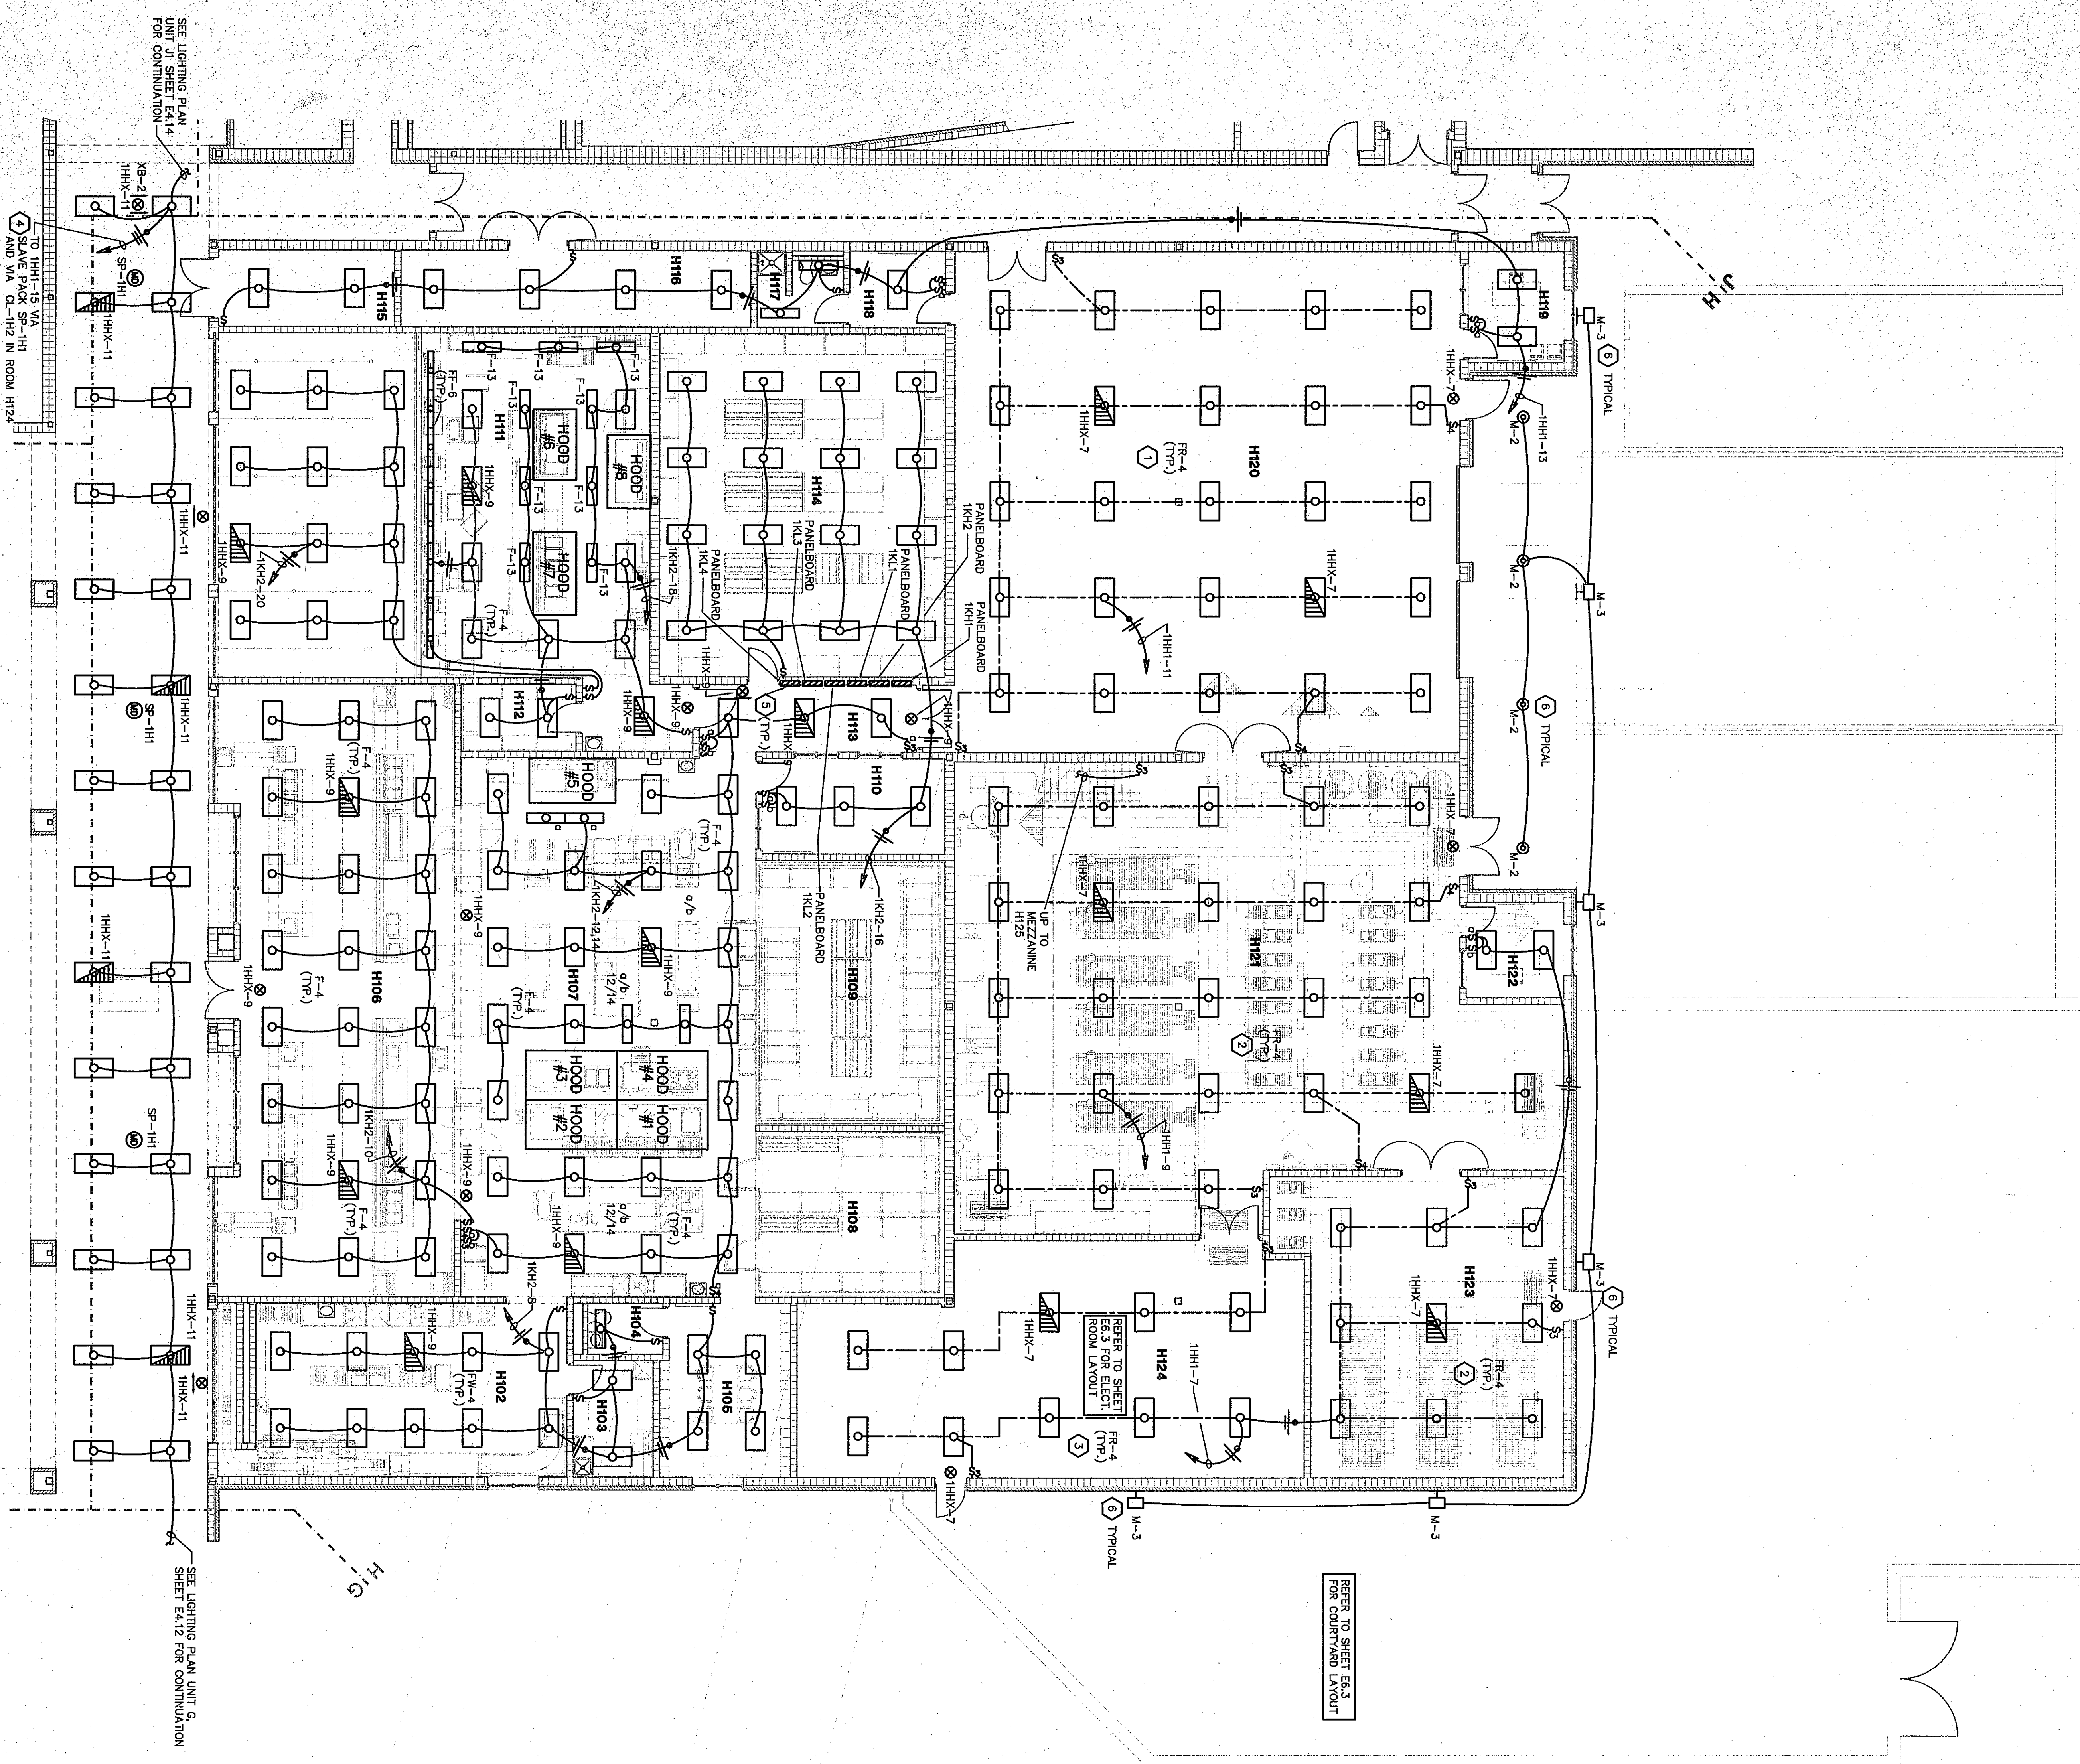

LIGHTING PLAN UNIT H1

SCALE 1/8" = 1'-0"

LIGHTING PLAN UNIT H2

SCALE 1/8" = 1'-0"

- PLAN NOTES:**
- 1 MOUNT LIGHT FIXTURE TYPE FR-4 AT 12'-6" ABOVE FINISH FLOOR.
 - 2 MOUNT LIGHT FIXTURE TYPE FR-4 AT 10'-0" ABOVE FINISH FLOOR. SEE DETAIL 8/E1.4 FOR CORRIDOR LIGHTING CONTROL.
 - 3 MOUNT LIGHT FIXTURE TYPE FR-4 AT 9'-6" ABOVE FINISH FLOOR.
 - 4 FOR CORRIDOR LIGHTING CONTROL, SEE DETAIL 8/E1.4.
 - 5 SEE DETAIL 1/E1.6 FOR PANELBOARD LAYOUT.
 - 6 SECURITY LIGHTING, SEE SITE PLAN.
 - 7 MOUNT LIGHT FIXTURE TYPE FR-2 AT 9'-6" ABOVE FINISH FLOOR. MOUNT FIXTURE TO MISS ALL MECHANICAL EQUIPMENT.
- ALL 2'x4' LIGHT FIXTURES SHALL BE PLAN TYPE F-3 UNLESS OTHERWISE NOTED.
ALL 1'x4' LIGHT FIXTURES SHALL BE PLAN TYPE F-1 UNLESS OTHERWISE NOTED.
ALL 2'x2' LIGHT FIXTURES SHALL BE PLAN TYPE F-22 UNLESS OTHERWISE NOTED.
ALL RECESSED CAN LIGHTS SHALL BE PLAN TYPE PD-1 UNLESS OTHERWISE NOTED.
ALL EXIT SIGNS SHALL BE PLAN TYPE XB-1 UNLESS OTHERWISE NOTED.

ROOM LEGEND "H1"

ROOM NO.	NAME	SQ. FT.	CEILING HIGHT
H101	CORRIDOR	2240	10'-0"
H102	WATERWASHING	600	9'-4"
H103	JANITOR/LAUNDRY	101	9'-4"
H104	LOCKER/BREAK ROOM	242	9'-4"
H105	SEWING	553	9'-4"
H106	COOKING/BAKING	553	9'-4"
H107	COOLER	342	9'-4"
H108	FREEZER	346	9'-4"
H109	FAST FOOD SERVING	1711	9'-4"
H110	STORAGE	149	9'-4"
H111	STORAGE	149	9'-4"
H112	STORAGE	149	9'-4"
H113	STORAGE	149	9'-4"
H114	STORAGE	149	9'-4"
H115	STORAGE	149	9'-4"
H116	TOILET	70	9'-4"
H117	TOILET	70	9'-4"
H118	OFFICE	81	9'-4"
H119	OFFICE	77	9'-4"
H120	SHIPPING/RECEIVING	2728	9'-4"
H121	BOILER ROOM	2859	9'-4"
H122	CHILLER ROOM	2859	9'-4"
H123	ELECTRICAL ROOM	1209	9'-4"
H124	MECHANICAL MEZZ	1209	9'-4"


LIGHTING PLAN UNIT H1,H2

DRAWN BY: MRS. COMM. NO.: 95067.00
CHECKED BY: WBH DATE: APRIL 21, 1997

E4.13

REVISIONS NO. DATE

Fanning/Howey Associates, Inc.
Architects Engineers Consultants

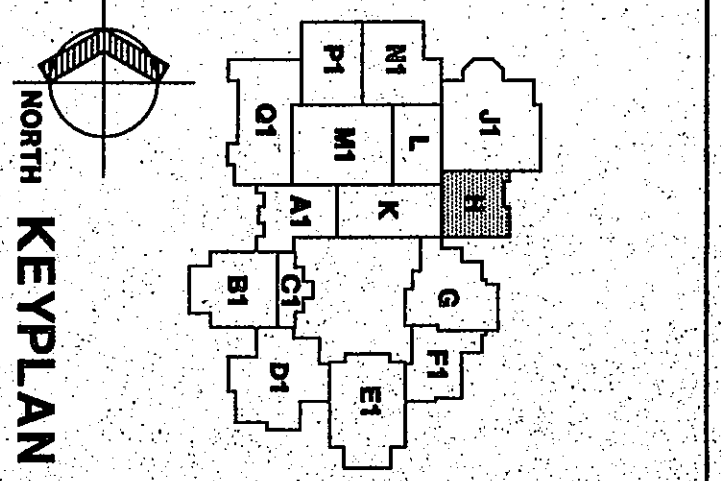

THE NEW
CHESTERTON HIGH SCHOOL
FOR THE
DUNELAND SCHOOL CORPORATION
CHESTERTON, INDIANA

Copyright 1997 by Fanning/Howey Associates, Inc.