


59

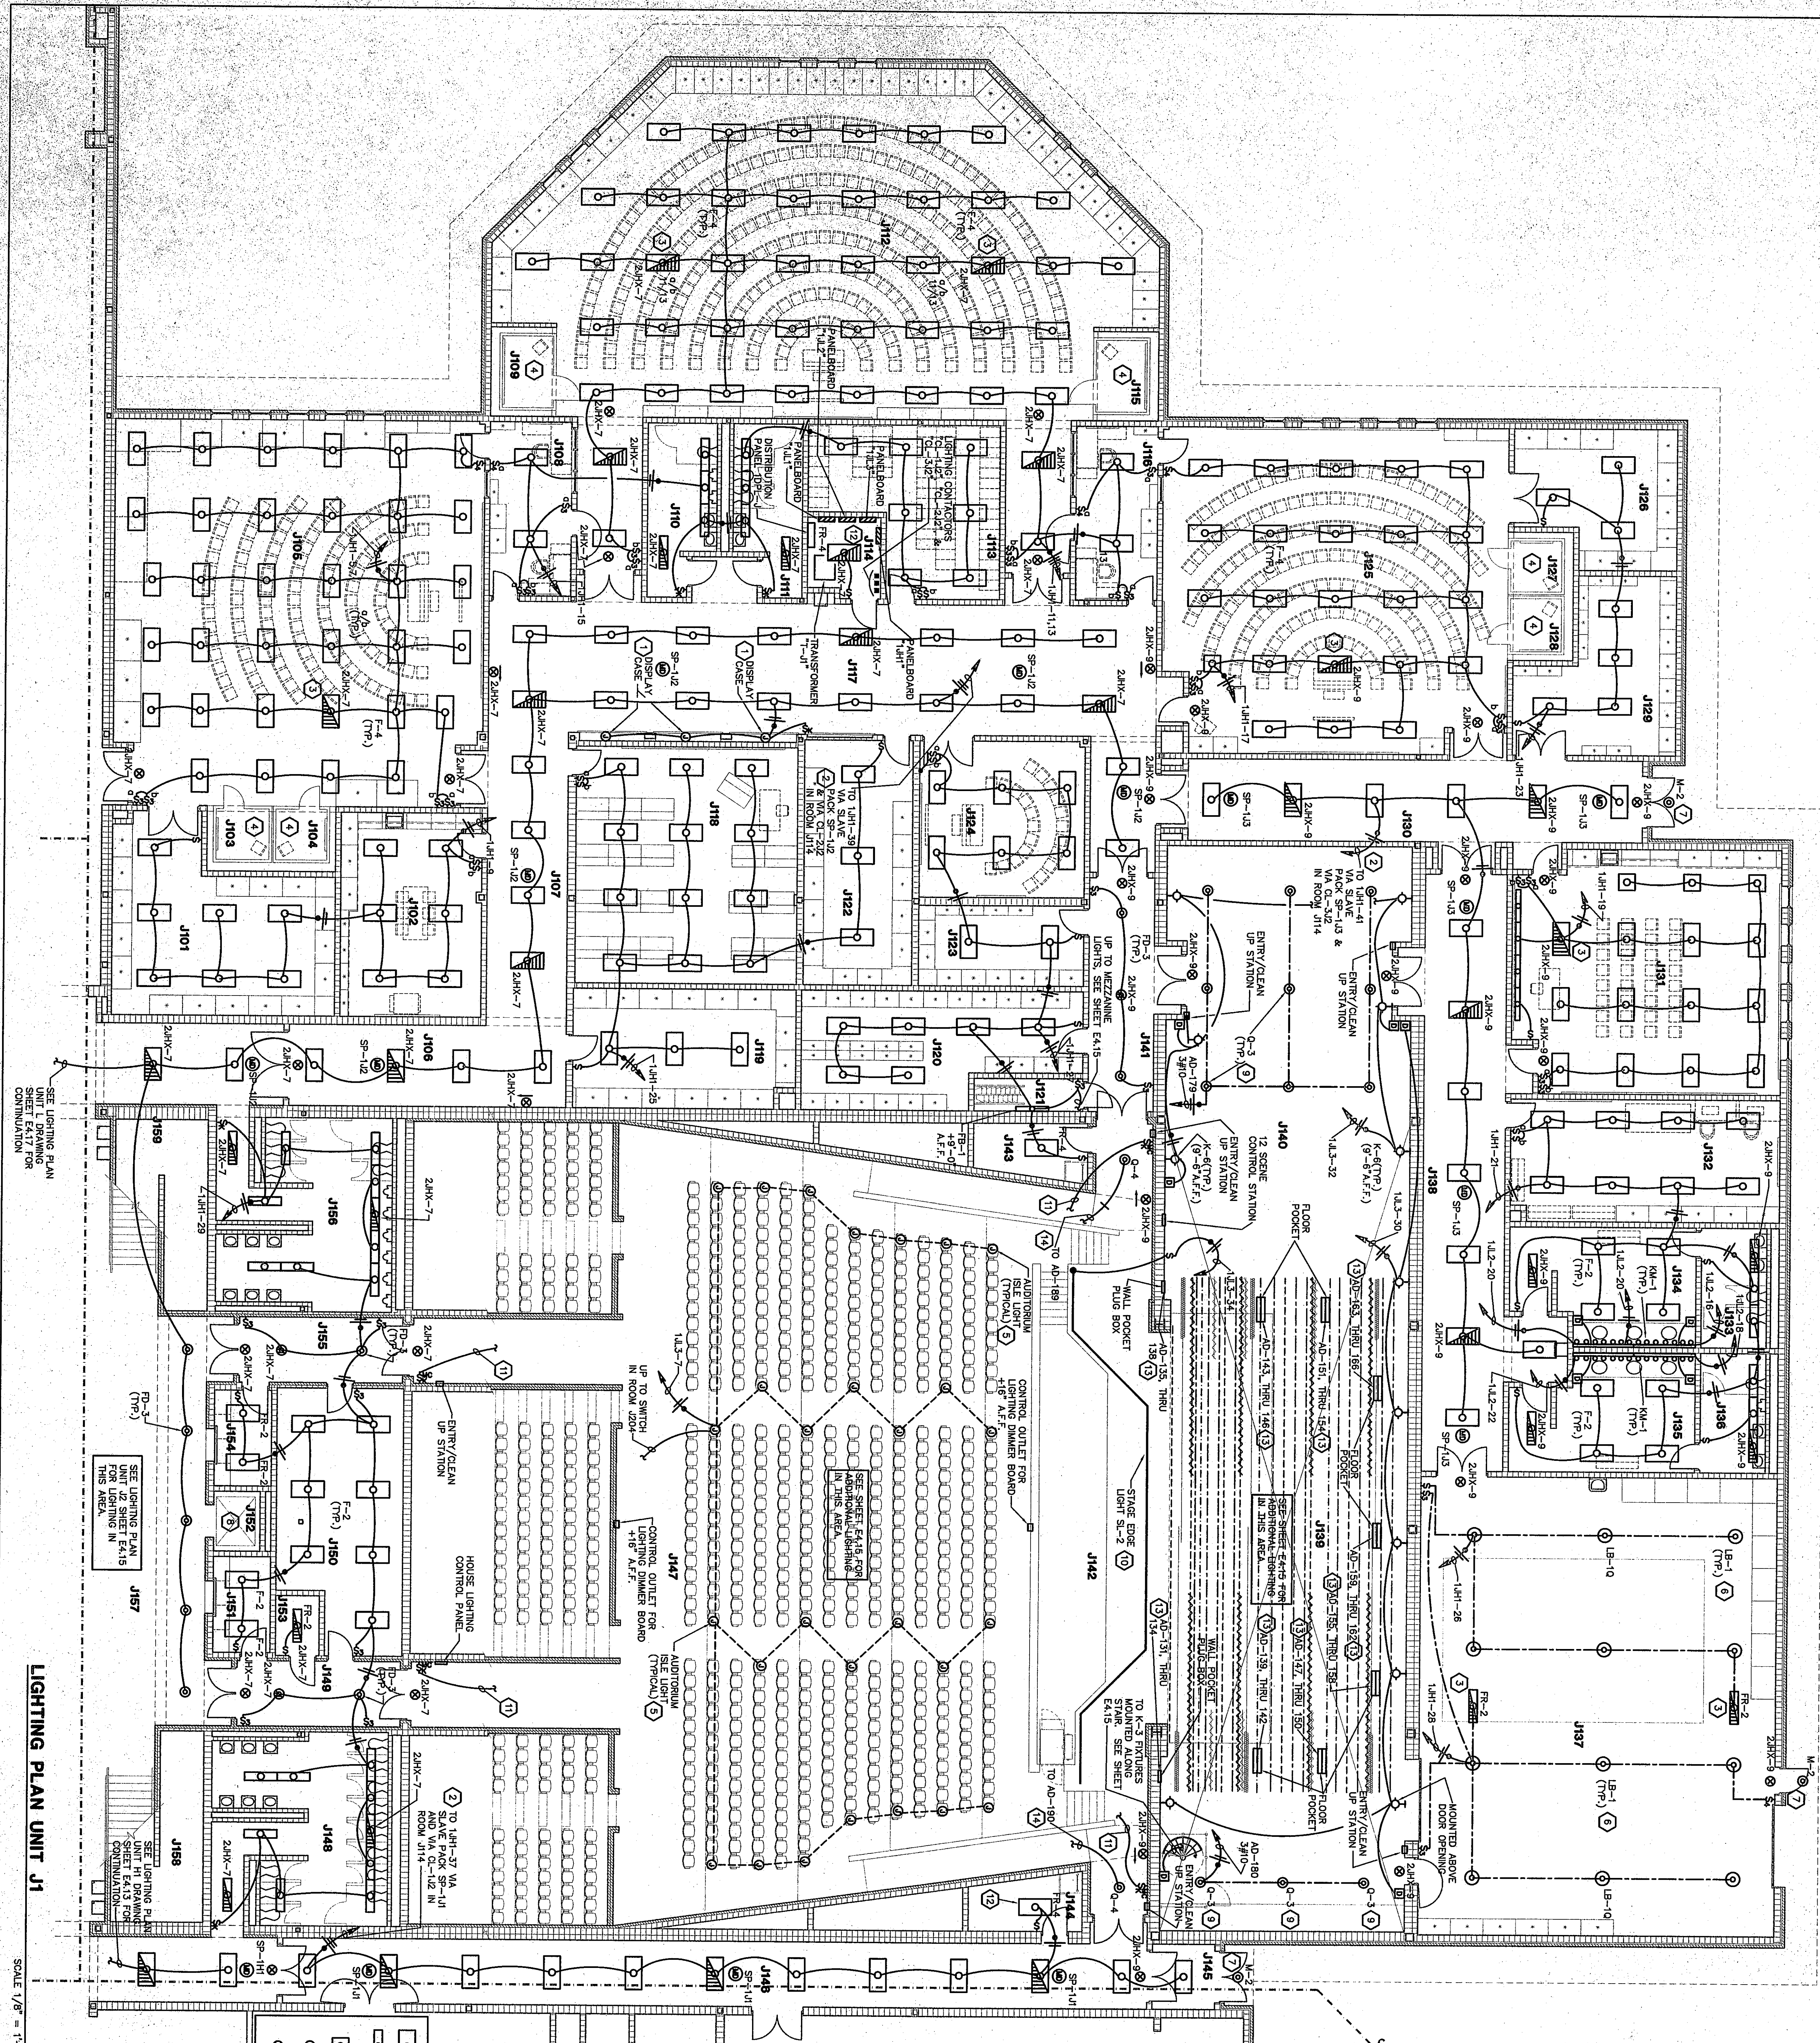


SEE LIGHTING PLAN UNIT 1 DRAWING SHEET E4.17 FOR CONTINUATION

SEE LIGHTING PLAN UNIT 1 DRAWING SHEET E4.18 FOR CONTINUATION

SEE LIGHTING PLAN UNIT 1 DRAWING SHEET E4.19 FOR CONTINUATION

SEE LIGHTING PLAN UNIT 1 DRAWING SHEET E4.20 FOR CONTINUATION

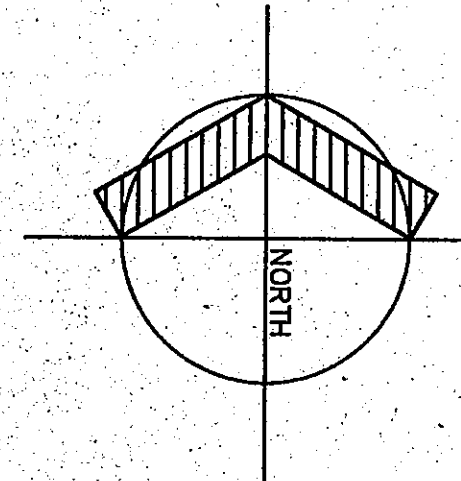

SCALE 1/8" = 1'-0"

- PLAN NOTES:**
1. PREMANUFACTURED DISPLAY CASE WITH LIGHT FIXTURE, LAMPS MOUNTED AND WIRE PER DETAIL 8/E1.4.
 2. PROVIDE THE EMERGENCY LIGHT FIXTURE WITH A CONTROL LIGHT FIXTURE, WIRE PER DETAIL 8/E1.5.
 3. MUSIC PRACTICE ROOMS, SEE SHEET E4.14 FOR WIRING REQUIREMENTS.
 4. AUDITORIUM SET LIGHT PROVIDED BY SEATING MANUFACTURER, DIVISION 16 SHALL WIRE EACH SET LIGHT PER DETAIL 8/E1.7.
 5. MOUNT BOTTOM OF LIGHT FIXTURE TYPE LB-1 AND RB-2 AT MOUNTING REQUIREMENTS DETAIL 8/E1.1 FOR LOW BAY.
 6. SECURITY LIGHTING, SEE SITE PLAN.
 7. SEE POWER PLAN UNIT J1, SHEET E4.14 FOR ELEVATOR PIT REQUIREMENTS.
 8. MOUNT LIGHT FIXTURE TYPE Q-3 AT 14'-0" ABOVE FINISH FLOOR.
 9. DIVISION 16 SHALL MOUNT STAGE EDGE LIGHT IN FLOOR 6" AWAY FROM EDGE OF ORCHESTRA PIT. SEE DETAIL 8/E1.3.
 10. MOMENTARY SWITCH TO CONTROL LIGHTING CONTACTOR C-11B, SEE LIGHTING PLAN UNIT 12 SHEET E4.15.
 11. MOUNT LIGHT FIXTURE TYPE RB-4 AT 4'-0" ABOVE FINISH FLOOR.
 12. RUN #10 AND WIRE (EACH CIRCUIT WITH FULL SIZE DEDICATED NEUTRAL) PLUS GROUND.
 13. WIRE FIXTURE Q-4 TO DIMMER PACK CIRCUIT AS INDICATED.
- ALL 2'x4' LIGHT FIXTURES SHALL BE PLAN TYPE F-3 UNLESS OTHERWISE NOTED.
ALL 1'x4' LIGHT FIXTURES SHALL BE PLAN TYPE F-1 UNLESS OTHERWISE NOTED.
ALL 2'x2' LIGHT FIXTURES SHALL BE PLAN TYPE F-22 UNLESS OTHERWISE NOTED.
ALL RECESS CAN LIGHTS SHALL BE PLAN TYPE RD-1 UNLESS OTHERWISE NOTED.
ALL EXIT SIGNS SHALL BE PLAN TYPE XB-1 UNLESS OTHERWISE NOTED.

ROOM LEGEND "J1"

ROOM NO.	ROOM NAME	AREA S.F.	CEILING HEIGHT
J101	PRACTICE ROOM	556	9'-4"
J102	PRACTICE ROOM	556	9'-4"
J103	PRACTICE ROOM	556	9'-4"
J200	PRACTICE ROOM	556	9'-4"

Lighting Plan Unit J1

DRAWN BY: MRS. COMM. NO.: 95067.00
CHECKED BY: WBH DATE: APRIL 21, 1997

E4.14

REVISIONS NO. DATE

Fanning/Howey Associates, Inc.

Architects Engineers Consultants

THE NEW CHESTERTON HIGH SCHOOL FOR THE DUNELAND SCHOOL CORPORATION CHESTERTON, INDIANA

COPYRIGHT 1997 BY FANNING/HOWEY ASSOCIATES, INC.