


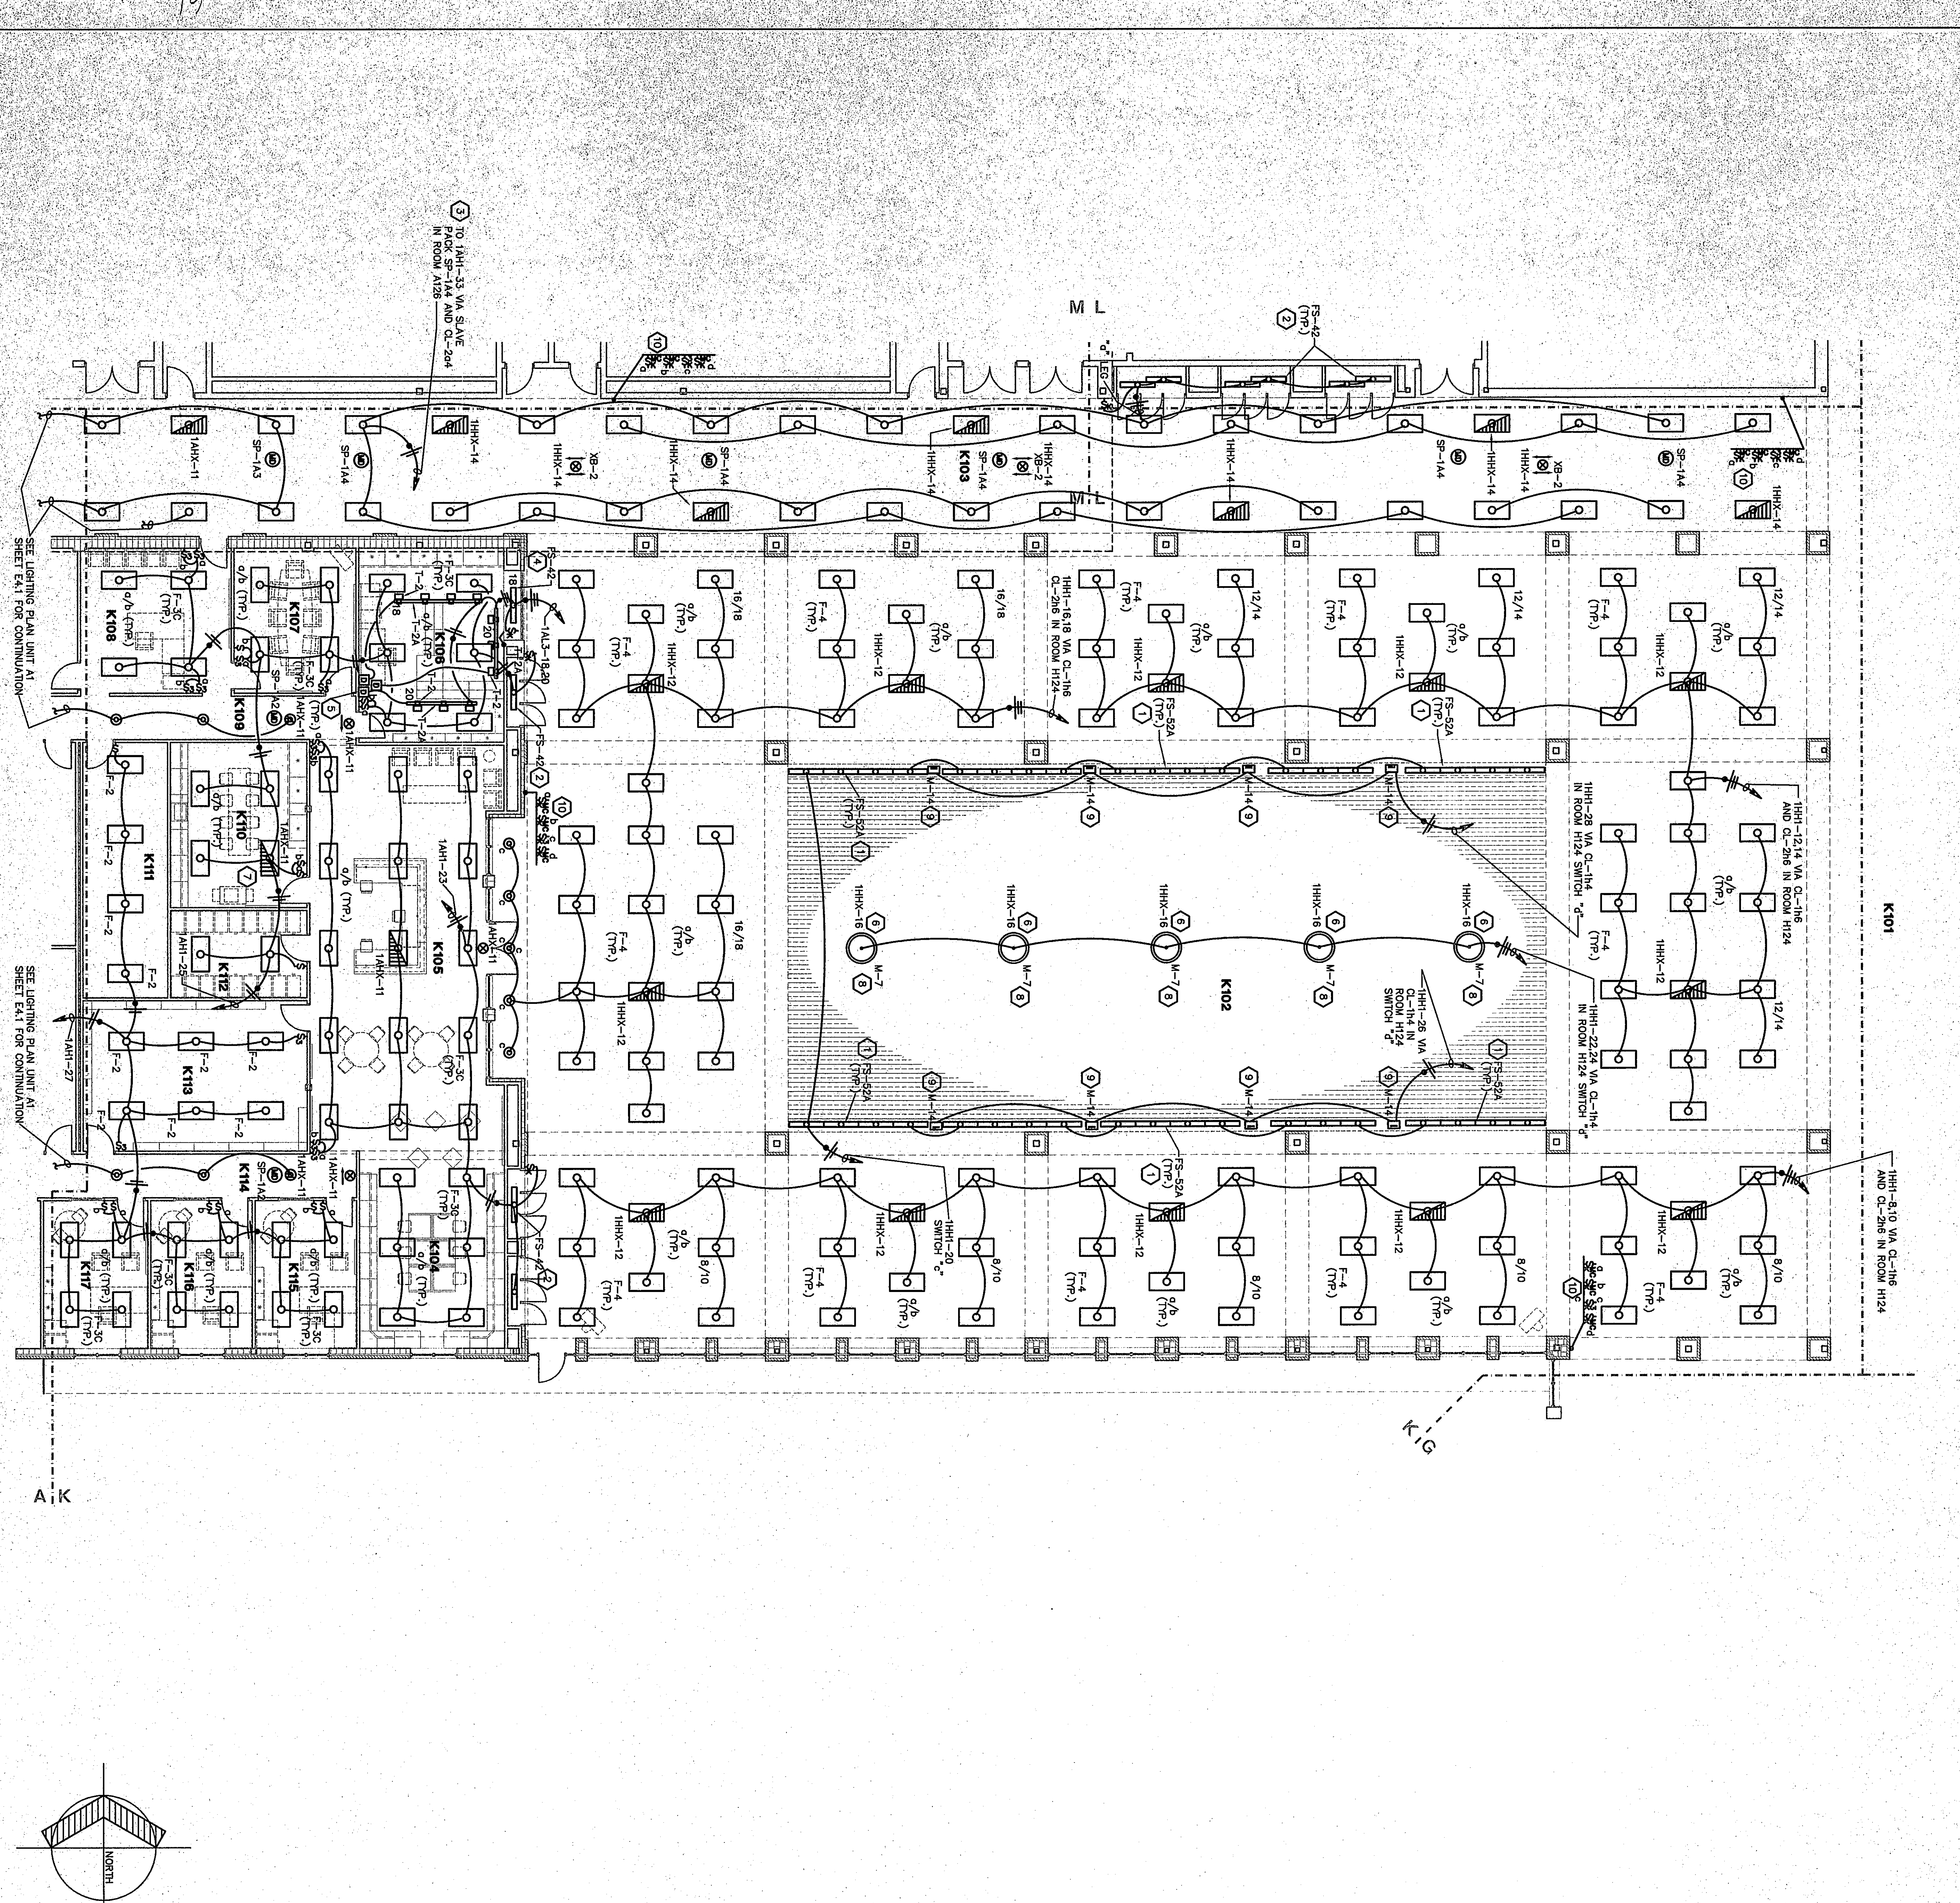

ROOM LEGEND "K"			
ROOM	AREA	CEILING	HEIGHT
K101	13468	10'-0"	9'-4"
K102	13468	10'-0"	9'-4"
K103	13468	10'-0"	9'-4"
K104	13468	10'-0"	9'-4"
K105	13468	10'-0"	9'-4"
K106	13468	10'-0"	9'-4"
K107	13468	10'-0"	9'-4"
K108	13468	10'-0"	9'-4"
K109	13468	10'-0"	9'-4"
K110	13468	10'-0"	9'-4"
K111	13468	10'-0"	9'-4"
K112	13468	10'-0"	9'-4"
K113	13468	10'-0"	9'-4"
K114	13468	10'-0"	9'-4"
K115	13468	10'-0"	9'-4"
K116	13468	10'-0"	9'-4"
K117	13468	10'-0"	9'-4"

PLAN NOTES:

1. LIGHT FIXTURE TYPE FS-524 MOUNTED IN COVE. SEE DETAIL 2/E1.6 AND 3/E1.6.
2. LIGHT FIXTURE TYPE FS-42 MOUNTED IN DISPLAY CASE. SEE DETAIL 1/E1.2.
3. FOR CORRIDOR LIGHTING CONTROL. SEE DETAIL 9/E1.4.
4. LIGHT FIXTURE TYPE FS-42 (120V. BALLAST REQUIRED) MOUNTED IN DISPLAY CASE.
5. DIMMERS IN THIS AREA SHALL HAVE BUILT IN RADIO FREQUENCY INTERFERENCE EQUAL TO LUTRON 2000 WATT MODEL NOVA N-2000. COLOR BY ARCHITECT/ENGINEER. TRACK LIGHT FIXTURES SHALL BE PROVIDED WITH LOW NOISE LAMPS.
6. EMERGENCY LIGHTING CIRCUIT CONNECTED TO COMPACT FLUORESCENT LAMPS OF FIXTURE TYPE M-7.
7. PROVIDE EMERGENCY RELAY. REFER TO EMERGENCY LIGHTING DETAIL 1/E1.2.
8. MOUNT LIGHT FIXTURE TYPE M-7 AT 12'-0" ABOVE FINISH FLOOR.
9. MOUNT LIGHT FIXTURE TYPE M-14 IN COVE.
10. CARTERIA LIGHT SWITCHING IS TO BE AS FOLLOWS:
a. LIGHTING CONTRACTOR CL-1H6
b. LIGHTING CONTRACTOR CL-2H6
c. CIRCUIT 1H1-20
d. LIGHTING CONTRACTOR CL-1H4

- ALL 2'x4' LIGHT FIXTURES SHALL BE PLAN TYPE F-3 UNLESS OTHERWISE NOTED.
- ALL 1'x4' LIGHT FIXTURES SHALL BE PLAN TYPE F-1 UNLESS OTHERWISE NOTED.
- ALL 2'x2' LIGHT FIXTURES SHALL BE PLAN TYPE F-22 UNLESS OTHERWISE NOTED.
- ALL RECESSED CAN LIGHTS SHALL BE PLAN TYPE RP-1 UNLESS OTHERWISE NOTED.
- ⊗ ALL EXIT SIGNS SHALL BE PLAN TYPE 98-1 UNLESS OTHERWISE NOTED.

LIGHTING PLAN UNIT K

SCALE 1/8" = 1'-0"

Lighting Plan Unit K

Drawn By: MRS. COMM. NO.: 95067.00

Checked By: WBH DATE: APRIL 21, 1997

E4.16

Revisions No. Date

Fanning/Howey Associates, Inc.

Architects Engineers Consultants

North Keyplan

Keyplan

The New Chesterton High School for the Duneland School Corporation Chesterton, Indiana

Copyright 1997 by Fanning/Howey Associates, Inc.

Seal 1

Seal 2